




MOREHEAD CITY COUNTRY CLUB CLUBHOUSE

MOREHEAD CITY, NORTH CAROLINA

DRAWING LIST

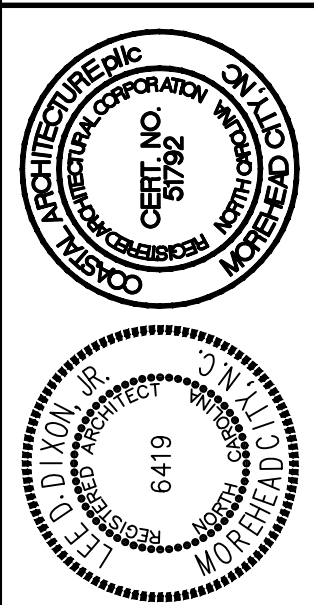

CS-1	COVER SHEET	F-1	PLUMBING SPECIFICATIONS
G-1	GENERAL DATA	F-2.1	FIRST FLOOR DWV PLAN
G-2	FIRST FLOOR LIFE SAFETY PLAN	F-2.2	SECOND FLOOR DWV PLAN
G-2.1	SECOND FLOOR LIFE SAFETY PLAN	F-2.3	ROOF TOP/MAIN ROOF DWV AND ROOF DRAIN PLAN
G-2.2	ROOF TOP LIFE SAFETY PLAN	F-2.4	HIGH ROOF DWV/ROOF DRAIN PLAN
A-1	FIRST FLOOR PLAN	F-3.1	FIRST FLOOR WATER PLAN
A-1.1	SECOND FLOOR PLAN	F-3.2	SECOND FLOOR WATER PLAN
A-1.2	ROOF TOP FLOOR PLAN	F-3.3	ROOF TOP WATER PLAN
A-1.3	MAIN ROOF PLAN	F-4	FIRST FLOOR DWV/WATER RISER
A-1.4	HIGH ROOF PLAN	F-5	SECOND FLOOR DWV/WATER RISER
A-2	FIRST FLOOR REFLECTED CEILING PLAN	F-6	ROOF TOP RISER
A-2.1	SECOND FLOOR REFLECTED CEILING PLAN	F-7	NATURAL GAS RISER
A-2.2	ROOF TOP FLOOR REFLECTED CEILING PLAN	M-1	HVAC SCHEDULES
A-3	DOOR AND ROOM FINISH SCHEDULES	M-1.1	HVAC SCHEDULES
A-4	EXTERIOR ELEVATIONS	M-2.1	FIRST FLOOR HVAC PLAN
A-4.1	EXTERIOR ELEVATIONS	M-2.2	SECOND FLOOR HVAC PLAN
A-5	BUILDING SECTION	M-2.3	ROOFTOP HVAC PLAN
A-5.1	BUILDING SECTION	M-3	HVAC SPECIFICATIONS
A-5.2	BUILDING SECTION	E-1	ELECTRICAL SPECIFICATIONS
A-5.3	BUILDING SECTION	E-2.1	FIRST FLOOR LIGHTING PLAN
A-5.4	WALL SECTION	E-2.2	SECOND FLOOR LIGHTING PLAN
A-5.5	WALL SECTION	E-2.3	ROOFTOP LIGHTING PLAN
A-5.10	BUILDING SECTION	E-3.1	FIRST FLOOR POWER PLAN
A-5.12	WALL SECTION	E-3.2	SECOND FLOOR POWER PLAN
A-5.13	WALL SECTION	E-3.3	ROOFTOP POWER PLAN
A-5.14	BUILDING SECTION	E-4	ELECTRICAL PANELS AND RISER
A-6	ENLARGED PLANS	E-5	ELECTRICAL RISER
A-6.1	ENLARGED DETAILS	FA-1	FIRE ALARM SPECIFICATIONS
A-6.2	PERGOLA DETAILS	FA-2.1	FIRST FLOOR FIRE ALARM PLAN
A-7	INTERIOR ELEVATIONS	FA-2.2	SECOND FLOOR FIRE ALARM PLAN
A-7.1	INTERIOR ELEVATIONS	FA-2.3	ROOFTOP FIRE ALARM PLAN
A-7.2	INTERIOR ELEVATIONS		
A-7.3	INTERIOR ELEVATIONS		
A-7.4	INTERIOR ELEVATIONS		
A-7.5	INTERIOR ELEVATIONS		
K-1.0	ENLARGED KITCHEN PLAN		
K-1.1	ENLARGED BAR PLAN		
S0.1	GENERAL NOTES		
S1.0	FOUNDATION PLAN		
S1.1	SECOND FLOOR FRAMING PLAN		
S1.2	MAIN FLOOR FRAMING PLAN		
S1.3	HIGH ROOF FRAMING PLAN		
S1.4	MECHANICAL PLATFORM FRAMING PLAN		
S2.0	BRACE FRAME ELEVATIONS		
S3.0	FOUNDATION DETAILS		
S3.1	FOUNDATION DETAILS		
S4.0	FRAMING DETAILS		
S4.1	FRAMING DETAILS		
S4.2	FRAMING DETAILS		
S5.0	LGS OPENING ELEVATIONS		
S5.1	LGS OPENING ELEVATIONS		

APPENDIX B

2018 BUILDING CODE SUMMARY
FOR ALL COMMERCIAL PROJECTS
(EXCEPT ONE- AND TWO-FAMILY DWELLINGS AND TOWNHOUSES)

Name of Project: MCCC CLUBHOUSE
Address: MOREHEAD CITY, NORTH CAROLINA
Owner/Authorized Agent: LEE DIXON
Owned By: City/County: MOREHEAD CITY
Code Enforcement Jurisdiction: City
CONTACT: DESIGNER: Coastal Architecture
Architectural: Lee Dixon
Civil: Burke Design Group
Electrical: Burke Design Group
Fire Alarm: Burke Design Group
Plumbing: Burke Design Group
Mechanical: Burke Design Group
Sprinkler-Standpipe: FDR
Structural: Heath Hendrick
Retaining Walls > 5 feet High: Other: (Other) should include firms and individuals such as truss, precast, pre-engineered, interior designers, etc.)

2018 NC BUILDING CODE: New Building
2018 NC EXISTING BUILDING CODE: (check all that apply)
CONSTRUCTED: (date)
RENOVATED: (date)
OCCUPANCY CATEGORY (Table 1604.5): Current: Proposed:

BASIC BUILDING DATA
Construction Type: I-A, I-B, I-C, I-D, I-E, I-F, I-G, I-H, I-I, I-J, I-K, I-L, I-M, I-N, I-O, I-P, I-Q, I-R, I-S, I-T, I-U, I-V, I-W, I-X, I-Y, I-Z
Sprinklers: No, Partial, Full
Standpipes: No, Class I, Class II, Class III
Primary Fire District: No, Yes
Special Inspections Required: No, Yes

GROSS BUILDING AREA TABLE
Floor: Existing (sq ft), New (sq ft), Subtotal
3rd Floor: 2,211
2nd Floor: 11,664 (INCLUDES PORCH)
Mezzanine: -
1st Floor: 11,664 (INCLUDES PORCH)
Basement: -
TOTAL: 25,545

ENERGY REQUIREMENTS:
The following data shall be considered minimum and any special attribute required to meet the energy code shall also be provided. Each Designer shall furnish the required portions of the project information for the plan data sheet. If performance method, state the annual energy cost for the standard reference design versus the annual energy cost for the proposed design.
Existing building envelope complies with code: (If checked, the remainder of this section is not applicable.)
Exempt Building: Provide code or statutory reference:
Climate Zone: 3A, 4A, 5A
Method of Compliance:
Energy Code: Performance, Prescriptive
ASHRAE 90.1: Performance, Prescriptive
Other: Performance (specify source)
THERMAL ENVELOPE: (Prescriptive method only)
Roof/Ceiling Assembly (each assembly)
Description of assembly: TPO ON TAPERED INSULATION CONCRETE/ STEEL W/ FOAM INSULATION
U-Value of total assembly: 0.023
R-Value of insulation: R-39
Skylights in each assembly: N/A
U-Value of skylight: N/A
total square footage of skylights in each assembly:
Exterior Walls (each assembly)
Description of assembly: EIFS ON PENGLASS ON METAL STUDS W/ FOAM INSULATION 4 GUB
U-Value of total assembly: 0.038
R-Value of insulation: R-19
Openings (windows or doors with glazing)
U-Value of assembly: <0.30
Solar heat gain coefficient: <0.25
projection factor:
Door R-Values:
Walls below grade (each assembly)
Description of assembly: N/A
U-Value of total assembly:
R-Value of insulation:
Floors over unconditioned space (each assembly)
Description of assembly: N/A
U-Value of total assembly:
R-Value of insulation:
Floors slab on grade
Description of assembly: 4" CONCRETE W/ 2" PERIMETER INSULATION ON VAPOR BARRIER
U-Value of total assembly:
R-Value of insulation:
Horizontal/vertical requirement: R-10
slab heated:

ALLOWABLE AREA

Primary Occupancy Classification(s):
Assembly: A-1, A-2, A-3, A-4, A-5
Business: A-1, A-2, A-3, A-4, A-5
Educational: A-1, A-2, A-3, A-4, A-5
Factory: F-1 Moderate, F-2 Low, F-3 High, F-4 Health, F-5 HPM
Hazardous: H-1 Detonate, H-2 Deflagrate, H-3 Combust, H-4 Health, H-5 HPM
Institutional: I-1, I-2, I-3, I-4
I-3 Condition: I-1, I-2, I-3, I-4, I-5
I-2 Condition: I-1, I-2, I-3, I-4, I-5
I-3 Condition: I-1, I-2, I-3, I-4, I-5
Mercantile: M-1, M-2, M-3, M-4, M-5
Residential: R-1, R-2, R-3, R-4
Storage: S-1 Moderate, S-2 Low, S-3 High-piled, S-4 Repair Garage
Utility and Miscellaneous: U-1, U-2, U-3, U-4, U-5
Accessory Occupancy Classification(s):
Incidental Uses (Table 509):
This separation is not exempt as a Nonseparated Use (see exceptions).
Special Uses (Chapter 4 - List Code Sections):
Special Provisions: (Chapter 5 - List Code Sections):
Mixed Occupancy: No, Yes Separation: No separation, Hr: Exemption:
Non-separated Use (508.3): required per 1508.3.3
Separated Use (508.4): See below for area calculations for each story, the area of the occupancy shall be such that the sum of the ratios of the actual floor area of each use divided by the allowable floor area for each use shall not exceed 1.
Select one:
Actual Area of Occupancy A + Actual Area of Occupancy B
Allowable Area of Occupancy A Allowable Area of Occupancy B
= < 1.00

STORY NO.	DESCRIPTION AND USE	(A) BLDG AREA PER STORY (ACTUAL)	(B) TABLE 508.4 AREA	(C) AREA FOR FRONTAGE INCREASES 1	(D) ALLOWABLE AREA PER STORY OR INCREASES 1
1	A-2, B, M	11,644 (includes Porch)	25,000	1,125	32,625
2	A-2	11,644 (includes Porch)	25,000	1,125	32,625
3	A-2	2,211	25,000	1,125	32,625

1. Frontage area increases from Section 508.2 are computed thus:
a. Perimeter which fronts a public way or open space having 20 feet minimum width = 432 (F)
b. Total Building Perimeter = 432 (P)
c. Ratio (F/P) = 1 (F/P)
d. W = Minimum width of public way = 30 (W)
2. Unintended area applicable under conditions of Section 507.
3. Maximum Building Area = total number of stories in the building x D (maximum 3 stories) (508.2).
4. The maximum area of open parking garages must comply with Table 406.5.4. The maximum area of air traffic control towers must comply with Table 412.1.
5. Frontage increase is based on the unsprinklered area value in Table 508.2.

STRUCTURAL DESIGN

DESIGN LOADS:
Importance Factors: Wind (IW) _____
Snow (IS) _____
Seismic (IE) _____
Live Loads: Roof _____ psf
Mezzanine _____ psf
Floor _____ psf
Ground Snow Load: _____ psf
Wind Load: Basic Wind Speed _____ mph (ASCE-7)
SEISMIC DESIGN CATEGORY: A, B, C, D
Provide the following Seismic Design Parameters:
Occupancy Category (Table 1604.5): I, II, III, IV
Spectral Response Acceleration SS _____ % S1
Site Classification (ASCE 7): A, B, C, D, E, F
Data Source: Field Test, Presumptive, Historical Data
Basic structural system (check one)
Bearing Wall, Dual w/Special Moment Frame, Building Frame, Dual w/intermediate R/C or Special Steel, Moment Frame, Inverted Pendulum
Analysis Procedure: Simplified, Equivalent Lateral Force, Dynamic
Architectural, Mechanical, Components anchored? Yes, No
LATERAL DESIGN CONTROL: Earthquake, Wind
SOIL BEARING CAPACITIES:
Field Test (provide copy of test report) _____ psf
Presumptive Bearing Capacity _____ psf
Pile size, type, and capacity _____

ALLOWABLE HEIGHT

Building Height in Feet (Table 504.3): 15
Building Height in Stories (Table 504.4): 3
1. Provide code reference if the "Shown on Plans" quantity is not based on Table 504.3 or 504.4.

FIRE PROTECTION REQUIREMENTS

BUILDING ELEMENT: Structural Frame, Bearing Walls, Exterior, North, East, West, South, Nonbearing walls and partitions, Exterior walls, North, East, West, South, Interior walls and partitions, Floor Construction, Including supporting beams and joists, Floor Ceiling Assembly, Columns Supporting Floors, Roof Construction, including supporting beams and joists, Roof Ceiling Assembly, Columns Supporting Roof, Shaft Enclosures—Exit, Shaft Enclosures—Other, Corridor Separation, Occupancy/Fire Barrier Separation, Party/Fire Wall Separation, Smoke Barrier Separation, Smoke Partition, Tenant/Dwelling Unit/ Sleeping Unit Separation, Incidental Use Separation
FIRE SEPARATION DISTANCE (feet): > 30
RATING: REQ'D, PROVIDED (W/ REDUCTION)
DETAIL # AND SHEET #
DESIGN # FOR RATED ASSEMBLY
SHEET # FOR RATED PENETRATION
SHEET # FOR RATED JOINTS

MECHANICAL DESIGN

MECHANICAL SUMMARY
MECHANICAL SYSTEMS, SERVICE SYSTEMS AND EQUIPMENT
Thermal Zone: winter dry bulb: _____
summer dry bulb: _____
winter design conditions: winter dry bulb: _____
summer dry bulb: _____
Building heating load: _____
Building cooling load: _____
Mechanical Spacing Conditioning System
Unitary: description of unit: _____
heating efficiency: _____
cooling efficiency: _____
size category of unit: _____
Boiler: Size category, if oversized, state reason: _____
Chiller: Size category, if oversized, state reason: _____
List equipment efficiencies: _____

ELECTRICAL DESIGN

ELECTRICAL SUMMARY
ELECTRICAL SYSTEM AND EQUIPMENT
Method of Compliance:
Energy Code: Prescriptive, Performance
ASHRAE 90.1: Prescriptive, Performance
Lighting schedule (each fixture type)
lamp type required in fixture
number of lamps per fixture
ballast type used
number of ballasts in fixture
total wattage per fixture
total interior wattage specified versus allowed (whole building or space by space)
total exterior wattage specified versus allowed
Additional Prescriptive Compliance
506.2.1 More Efficient Mechanical Equipment
506.2.2 Reduced Lighting Power Density
506.2.3 Energy Recovery Ventilation Systems
506.2.4 Higher Efficiency Service Water Heating
506.2.5 On-Site Supply of Renewable Energy
506.2.6 Automatic Daylighting Control Systems

PERCENTAGE OF WALL OPENING CALCULATIONS

FIRE SEPARATION DISTANCE (feet) FROM PROPERTY LINES: >30
DEGREE OF OPENINGS PROTECTION (TABLE 705.3): UFG
ALLOWABLE AREA (%): NO LIMIT
ACTUAL SHOWN ON PLANS (%): NO LIMIT

LIFE SAFETY SYSTEM REQUIREMENTS

Emergency Lighting: Yes, No
Exit Signs: Yes, No
Fire Alarm: Yes, No
Smoke Detection Systems: Yes, No
Carbon Monoxide Detection: Yes, No

LIFE SAFETY PLAN REQUIREMENTS

Life Safety Plan Sheet #: G-2, G-2.1, G-2.2
Fire and/or smoke rated wall locations (Chapter 7)
Assumed and real property line locations (if not on the site plan)
Exterior wall opening area with respect to distance to assumed property lines (705.8)
Occupancy Use for each area as it relates to occupant load calculation (Table 1004.1.2)
Occupant loads for each area
Exit access travel distances (1017)
Common path of travel distances [Tables 1006.2.1 & 1006.3.2(1)]
Dead end lengths (1020.4)
Clear exit widths for each exit door
Maximum calculated occupant load capacity each exit door can accommodate based on egress width (1005.3)
Actual occupant load for each exit door
A separate schematic plan indicating where fire rated floor/ceiling and/or roof structure is provided for purposes of occupancy separation
Location of doors with panic hardware (1010.1.10)
Location of doors with delayed egress locks and the amount of delay (1010.1.9.7)
Location of doors with electromagnetic egress locks (1010.1.9.9)
Location of doors equipped with hold-open devices
Location of emergency escape windows (1030)
The square footage of each fire area (202)
The square footage of each smoke compartment for Occupancy Classification I-2 (407.5)
Note any code exceptions or table notes that may have been utilized regarding the items above

ACCESSIBLE DWELLING UNITS (SECTION 1107)

TOTAL UNITS, ACCESSIBLE UNITS REQUIRED, ACCESSIBLE UNITS PROVIDED, TYPE A UNITS REQUIRED, TYPE A UNITS PROVIDED, TYPE B UNITS REQUIRED, TYPE B UNITS PROVIDED, TOTAL ACCESSIBLE UNITS PROVIDED
N/A

ACCESSIBLE PARKING (SECTION 1106)

LOT OR PARKING AREA, TOTAL # OF PARKING SPACES, # OF ACCESSIBLE SPACES PROVIDED, REGULAR WITH 5' ACCESSIBLE, 132" ACCESSIBLE, 8' ACCESSIBLE, TOTAL # ACCESSIBLE PROVIDED
SEE CIVIL PLANS

PLUMBING FIXTURE REQUIREMENTS (TABLE 2902.1)

USE, WATERCLOSETS, URINALS, LAVATORIES, SHOWERS/TUBS, DRINKING FOUNTAINS
EXIST'G, NEW, REQ'D
SEE PLUMBING CODE 410.4

SPECIAL APPROVALS

Special approval: (Local Jurisdiction, Department of Insurance, OSC, DPI, DHHS, ICC, etc., describe below)

4'-0"

8'-0"

BLUE BORDER STRIPE

WHITE BACKGROUND U.O.N.

BLUE LOGO

BLACK LETTERS U.O.N.

1/2" EXTERIOR GRADE PLYWOOD

P.T. 6x6 POSTS SET IN GROUND 2'-6" WITH 2-2x6 BRACES

ARCHITECTS & ENGINEERS: Coastal Architecture
4206 Bridges St. Ext., Suite C, Morehead City, North Carolina 28557
www.coastalarchitecture.net
CONTRACTOR:

PROJECT SIGN

NOT TO SCALE

NOTE: SUBMIT SHOP DRAWING FOR COORDINATION OF LETTER HEIGHTS SPECIFIC SIGN COLORS.

NOTE: VERIFY SIGN SIZES AND REQUIREMENTS W/ TOWN

SIGN LOCATION TO BE FIELD VERIFIED W/ ARCHITECT

Coastal Architecture

Architectural Design, Planning, Interiors

AIA

Member of the American Institute of Architects

Lee D. Dixon, Jr., AIA
252-247-2121
leed@coastalarchitecture.net

4206 Bridges St. Ext., Suite C, Morehead City, NC 28557

www.CoastalArchitecture.net

MOREHEAD CITY COUNTRY CLUB CLUBHOUSE

MOREHEAD CITY, NORTH CAROLINA

NOTICE TO CONTRACTORS

OFFICE OF THE TOWN ENGINEER

6419

NOTICE TO ARCHITECTS

6419

GENERAL DATA

20010

ISSUED: 01/29/21

DWG BY: BLS/MES


CKD BY: LDD

REVISIONS

SHEET NO. G-1 OF

THESE DRAWING AND SPECIFICATIONS REPRESENT AN INSTRUMENT OF SERVICE AND AS SUCH SHALL REMAIN IN OWNERSHIP WITH THE ARCHITECT. USE OR REPRODUCTION BY ANY MEANS, IN WHOLE OR IN PART, WITHOUT THE ARCHITECT'S WRITTEN CONSENT, IS PROHIBITED.

**MOREHEAD CITY COUNTRY CLUB
CLUBHOUSE**
MOREHEAD CITY, NORTH CAROLINA

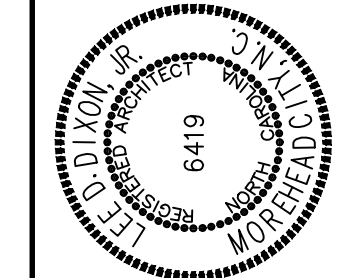

LIFE SAFETY PLAN
FIRST FLOOR

20010

ISSUED:	01/29/21
DWG BY:	BLS/MES


CKD BY:	LDD
REVISIONS	

REVISIONS	

SHEET NO.	


G-2

OF

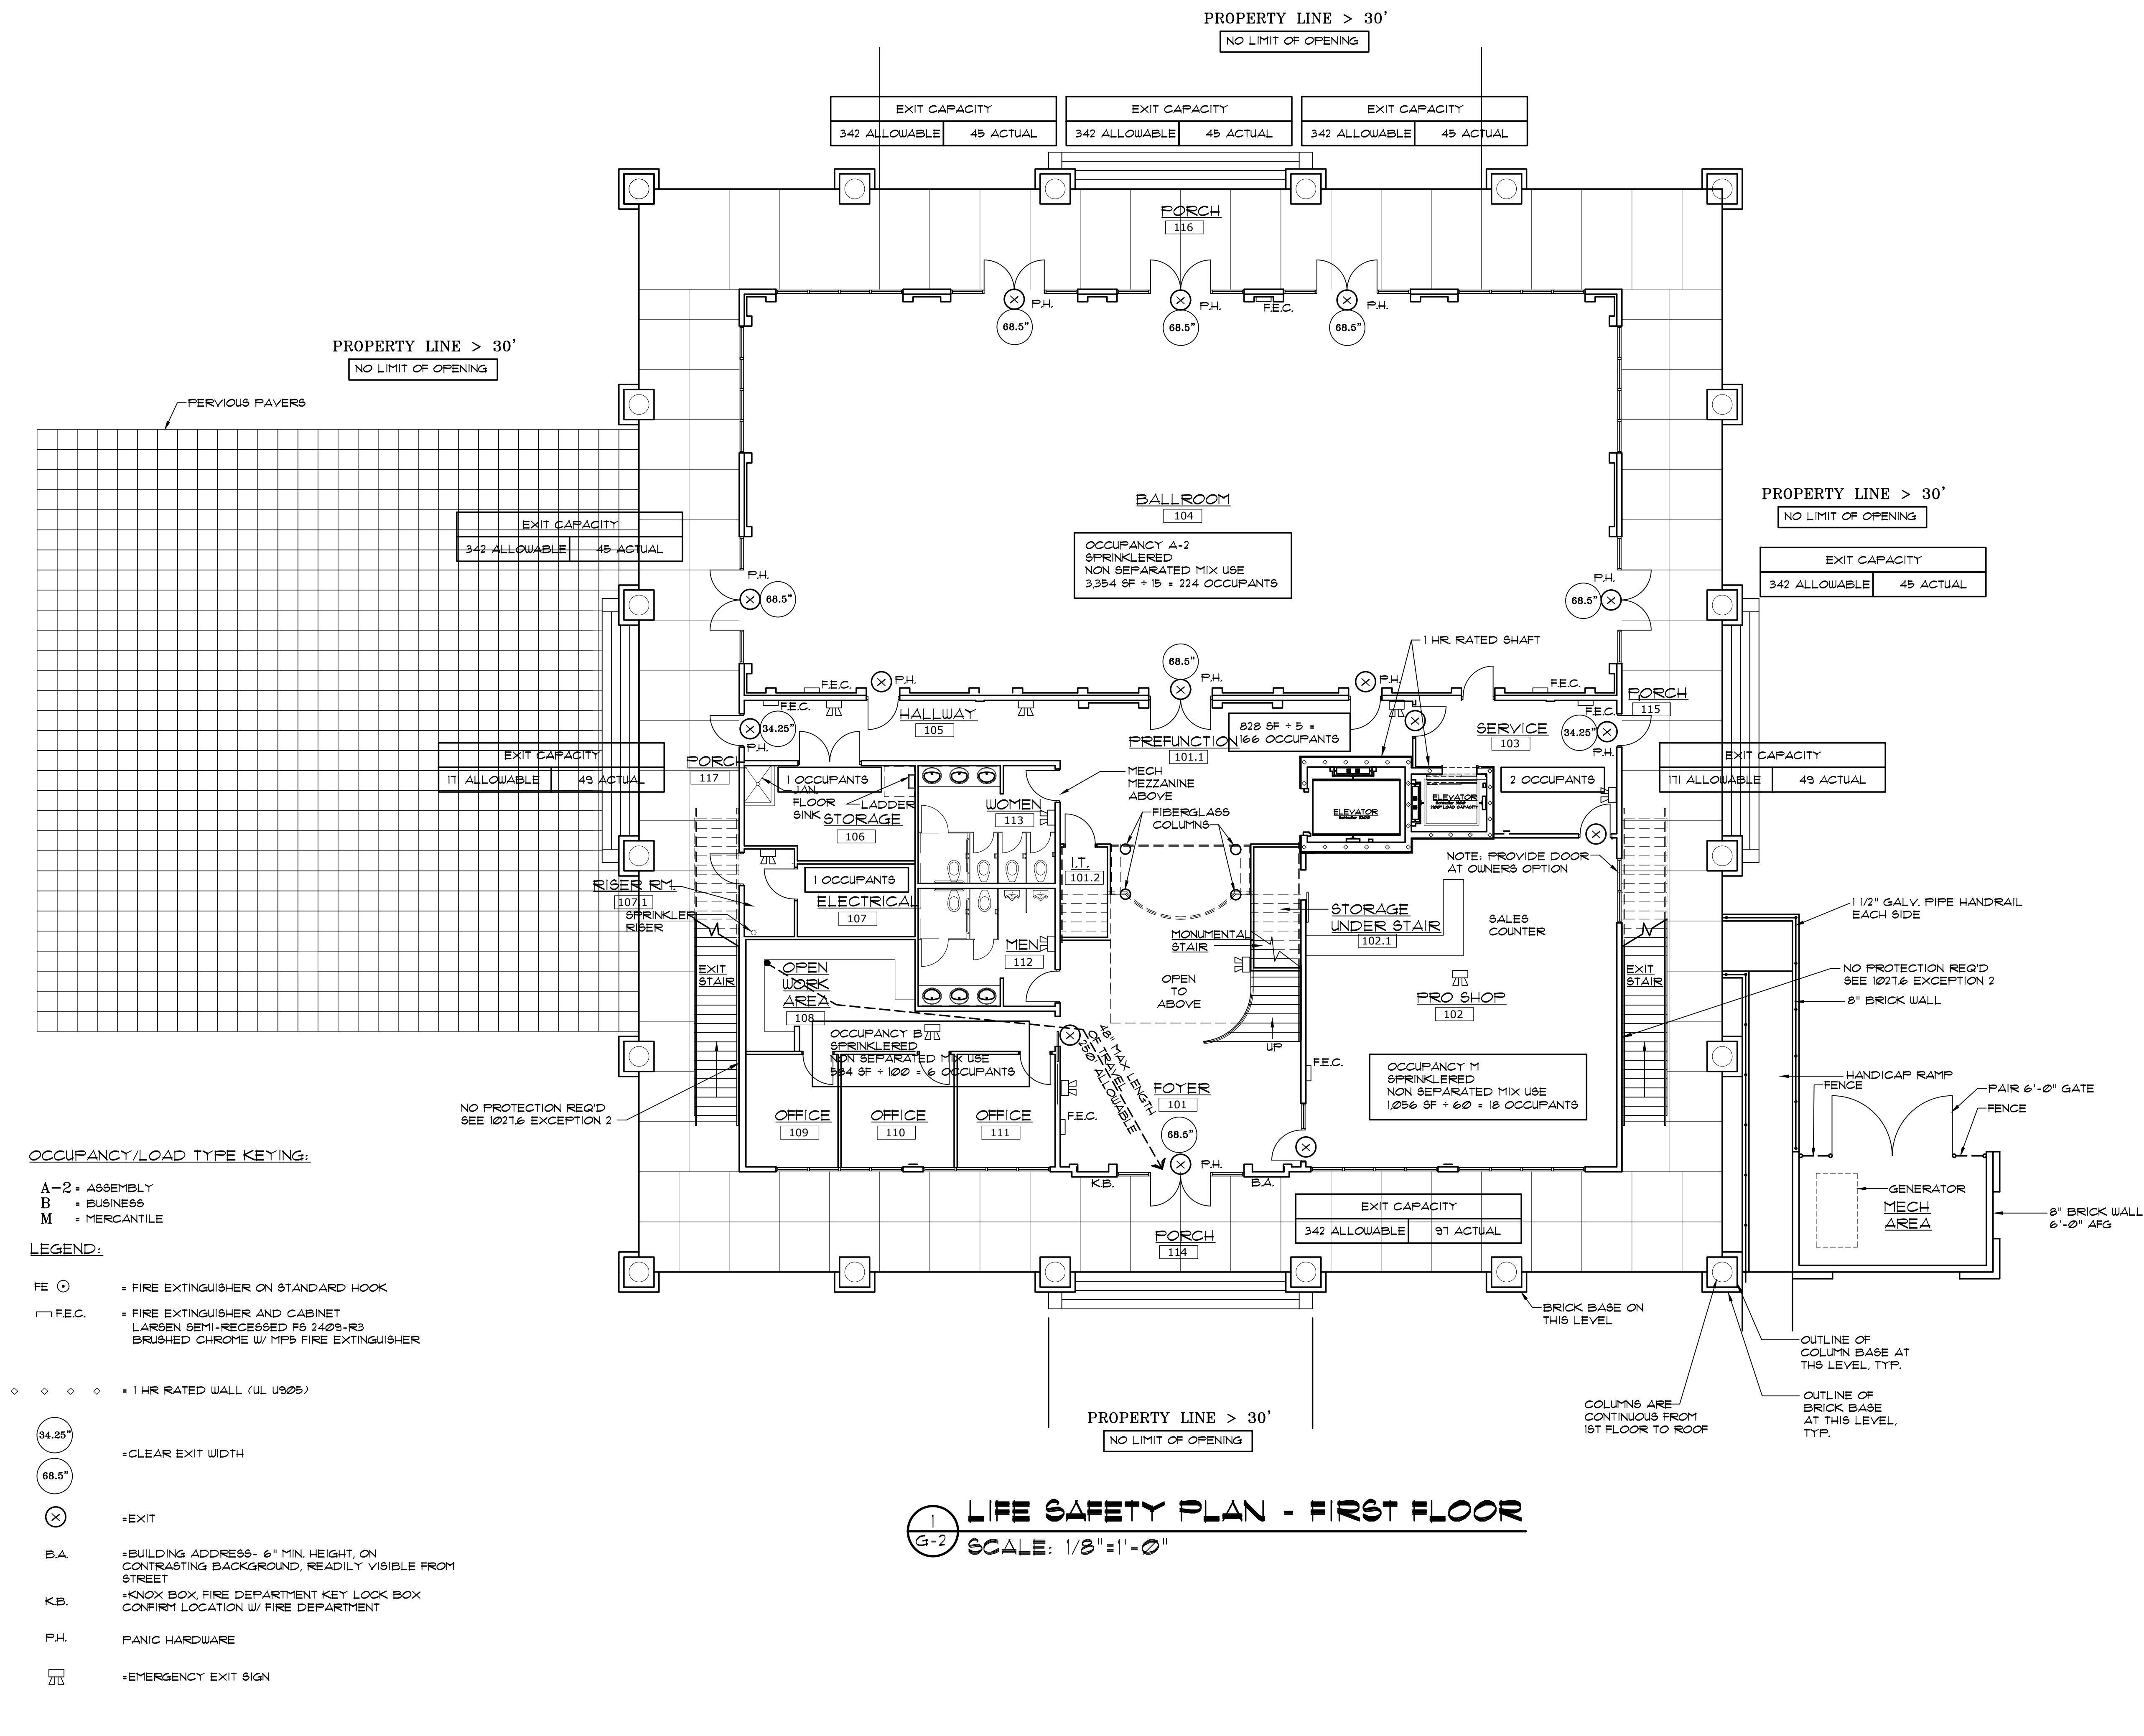

THESE DRAWING AND SPECIFICATIONS REPRESENT AN INSTRUMENT OF SERVICE AND AS SUCH SHALL REMAIN IN OWNERSHIP WITH THE ARCHITECT. USE OR REPRODUCTION BY ANY MEANS, IN WHOLE OR IN PART, WITHOUT THE ARCHITECT'S WRITTEN CONSENT IS PROHIBITED.

Design No. U905
Bearing Wall Rating — 2 HR.
Nonbearing Wall Rating — 2 HR

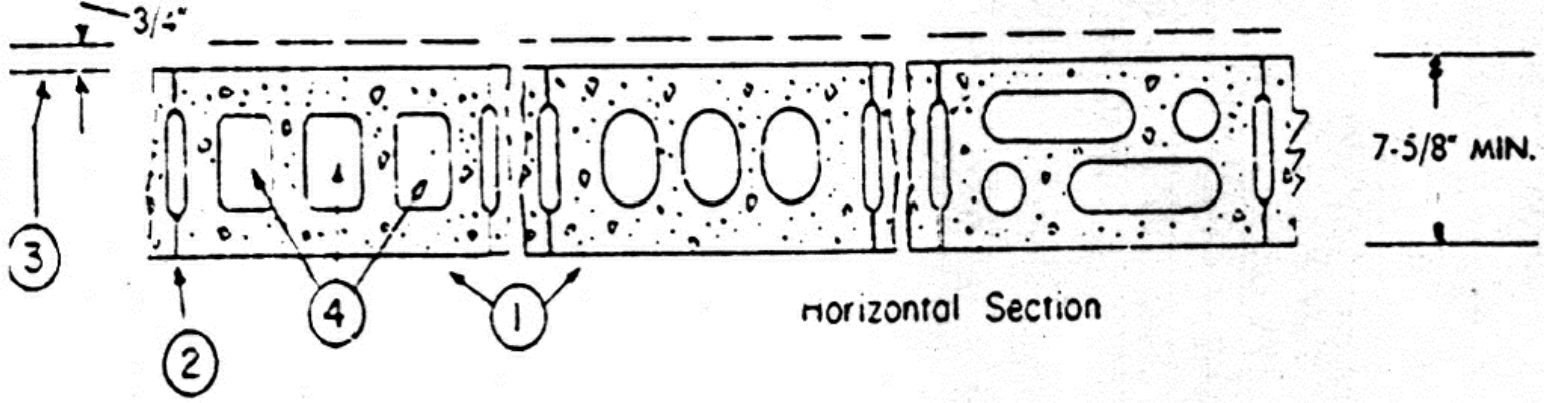

1. Concrete Blocks* — Various designs. Classification D-2 (2 hr). See Concrete Blocks category for list of eligible manufacturers.
 2. Mortar — Blocks laid in full bed of mortar, nom. 3/8 in. thick, of not less than 2-1/4 and not more than 3-1/2 parts of clean sharp sand to 1 part Portland cement (proportioned by volume) and not more than 50 percent hydrated lime (by cement volume). Vertical joints staggered.
 3. Portland Cement Stucco or Gypsum Plaster — Add 1/2 hr to classification if used. Where combustible members are framed in wall, plaster or stucco must be applied on the face opposite framing to achieve a max. Classification of 1-1/2 hr. Attached to concrete blocks (Item 1).
 4. Loose Masonry Fill — If all core spaces are filled with loose dry expanded slag, expanded clay or shale (Rotary Kiln Process), water repellant vermiculite masonry fill insulation, or silicone treated perlite loose fill insulation add 2 hr to classification.
 5. Foamed Plastic* — (Optional-Not Shown) — 1-1/2 in. thick max, 4 ft wide sheathing attached to concrete blocks (Item 1).
- CELOTEX CORP —Type Thermax
*Bearing the UL Classification Marking

2 UL U905
G-2.1 SCALE: N.T.S.

OCCUPANCY/LOAD TYPE KEYING:

A-2 = ASSEMBLY

LEGEND:

FE ○ = FIRE EXTINGUISHER ON STANDARD HOOK
F.E.C. = FIRE EXTINGUISHER AND CABINET
LARSSEN SEMI-RECESSED F8 2403-R3
BRUSHED CHROME W/ MP3 FIRE EXTINGUISHER

◇ ◇ ◇ ◇ = 1 HR. RATED WALL (UL U905)

34.25" = CLEAR EXIT WIDTH

68.5" = CLEAR EXIT WIDTH


⊗ = EXIT

B.A. = BUILDING ADDRESS- 6" MIN. HEIGHT, ON CONTRASTING BACKGROUND, READILY VISIBLE FROM STREET


K.B. = KNOX BOX, FIRE DEPARTMENT KEY LOCK BOX, CONFIRM LOCATION W/ FIRE DEPARTMENT

P.H. = PANIC HARDWARE



⊞ = EMERGENCY EXIT SIGN

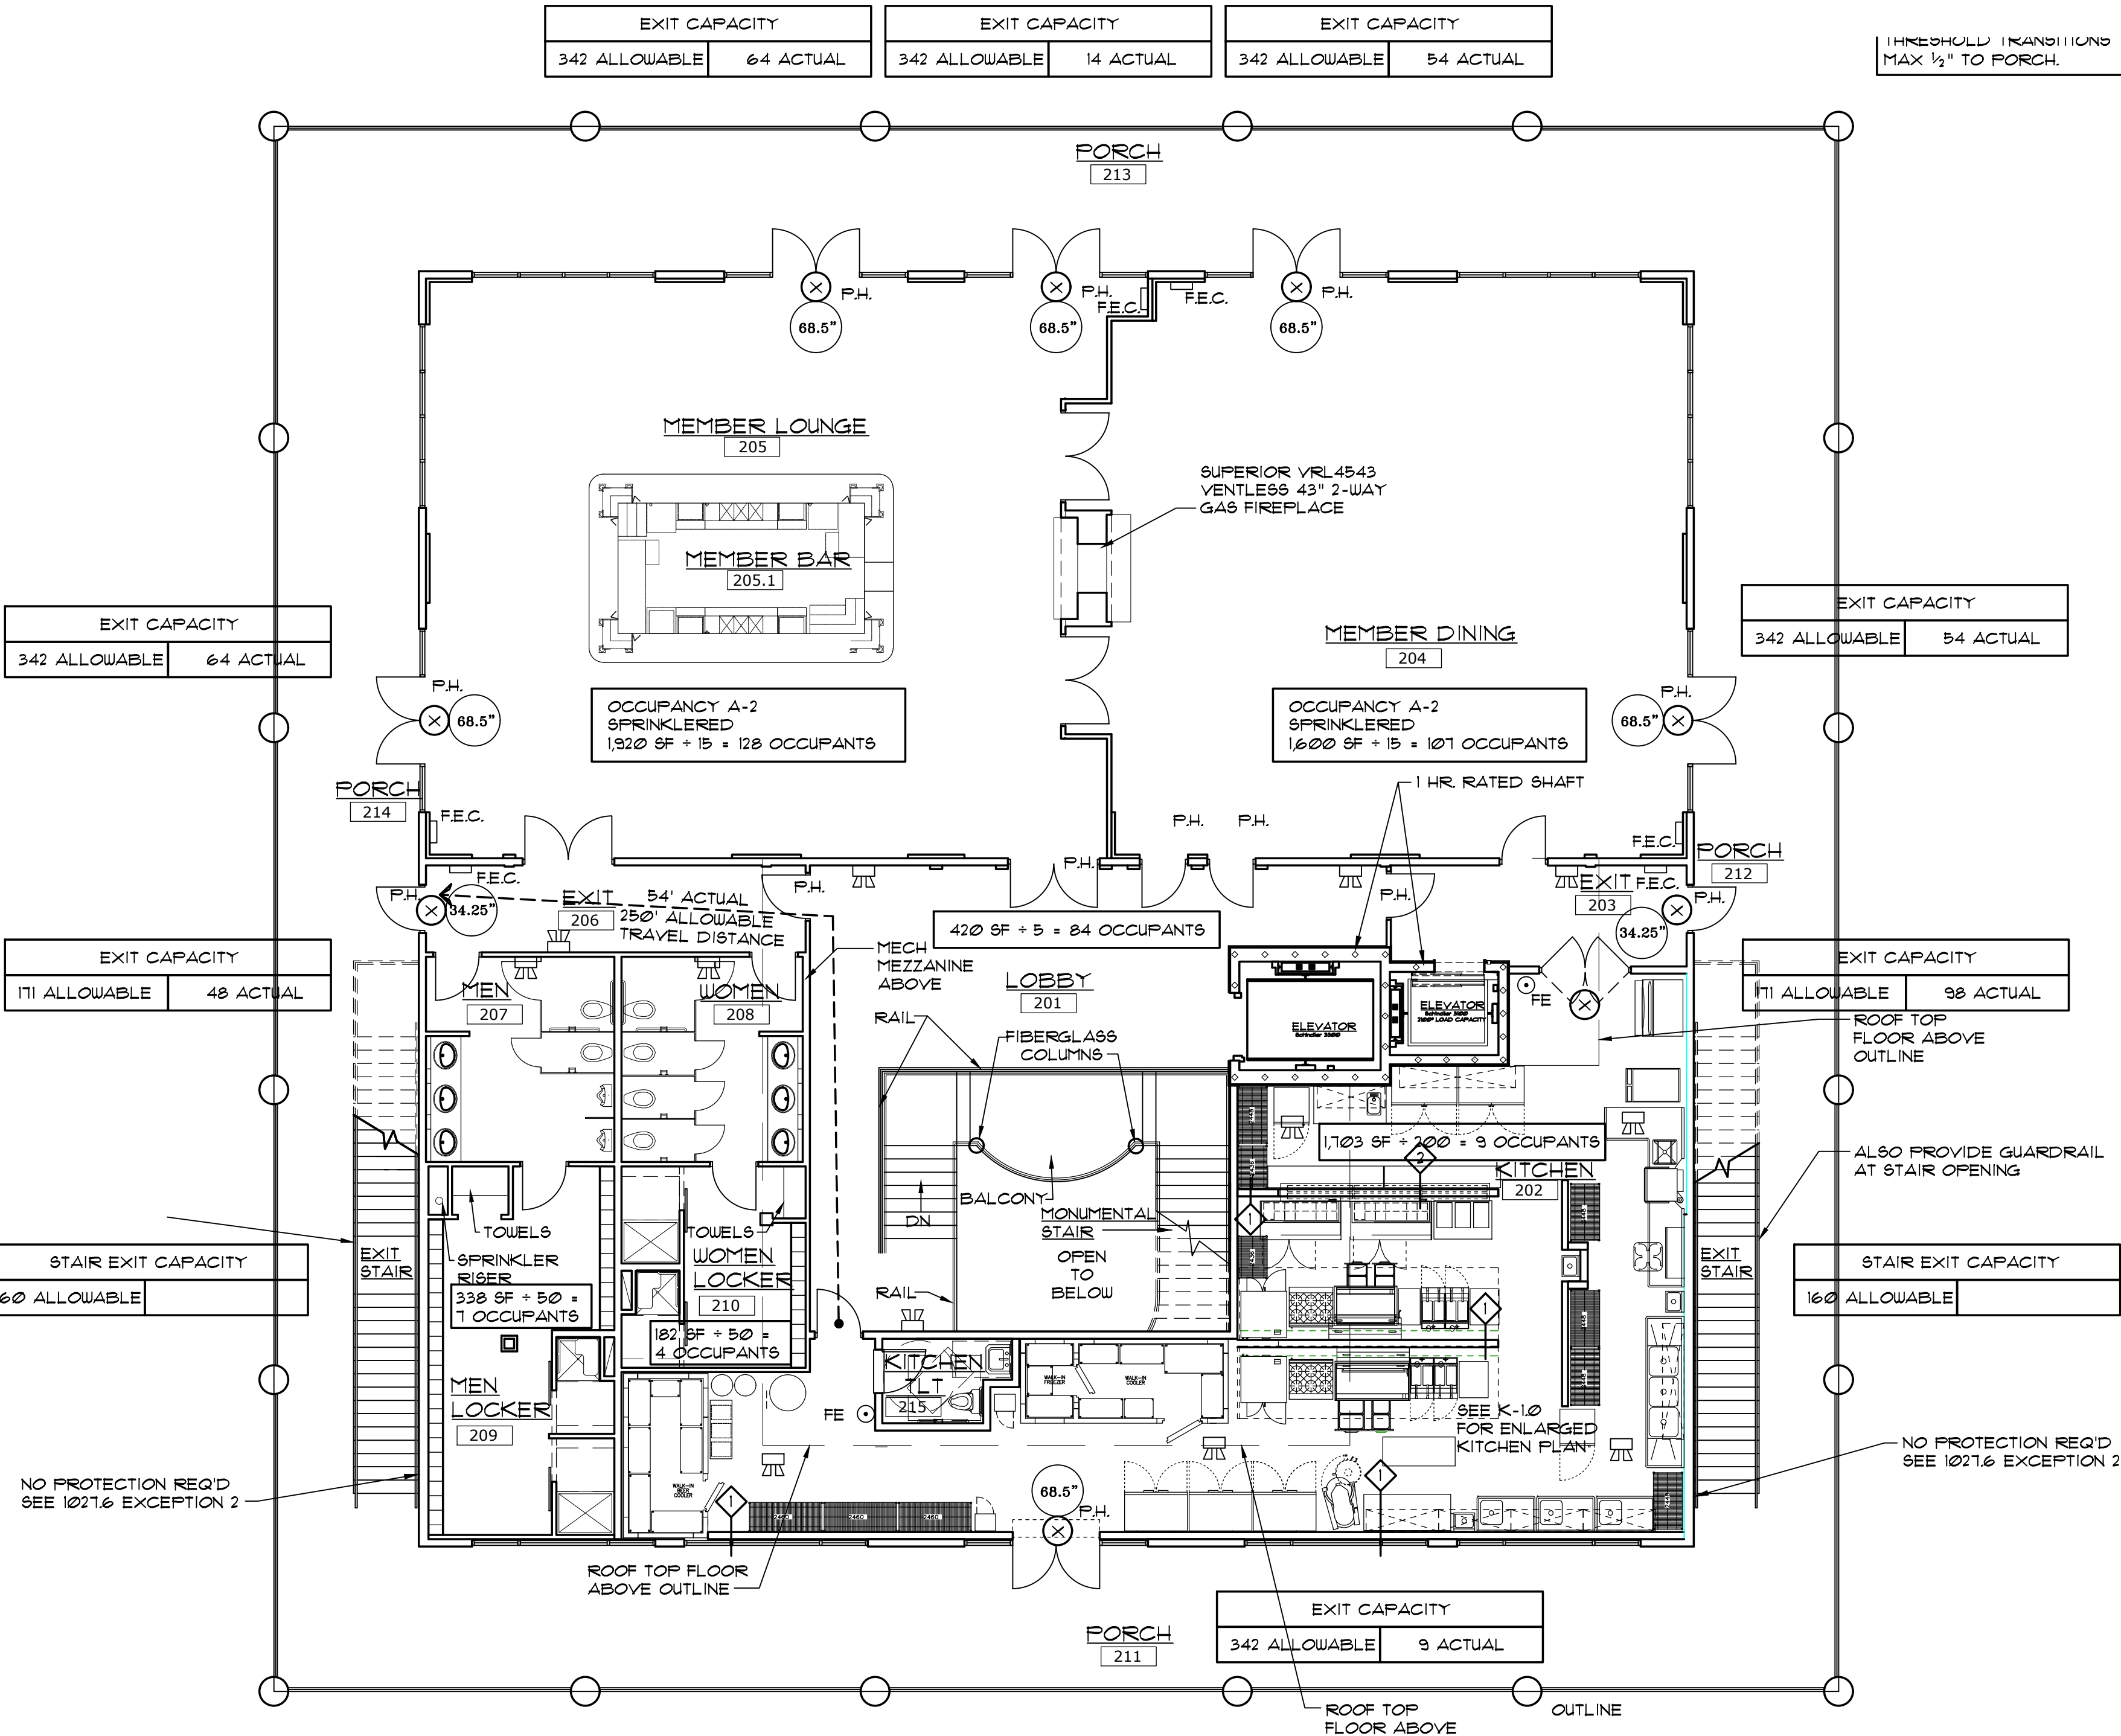

1 LIFE SAFETY PLAN - SECOND FLOOR
G-2.1 SCALE: 1/8" = 1'-0"

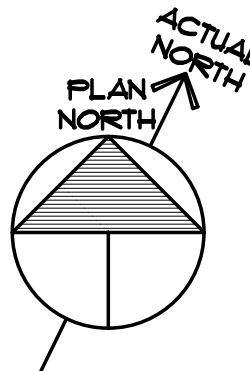

MOREHEAD CITY COUNTRY CLUB
CLUBHOUSE
MOREHEAD CITY, NORTH CAROLINA

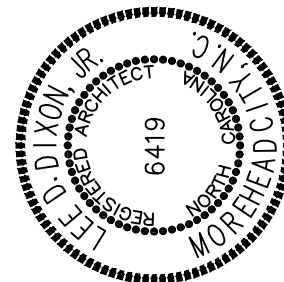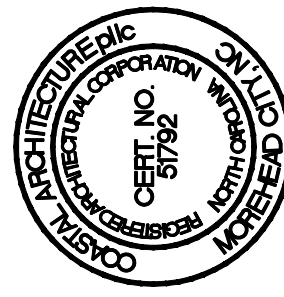

LIFE SAFETY PLAN
ROOF TOP FLOOR

20010

ISSUED: 01/29/21

DWG BY: BLS/MES

CKD BY: LDD

REVISIONS

SHEET NO.

G-2.2

OF

OCCUPANCY/LOAD TYPE KEYING:

A-2 = ASSEMBLY

LEGEND:

FE ○ = FIRE EXTINGUISHER ON STANDARD HOOK

□ F.E.C. = FIRE EXTINGUISHER AND CABINET
LARSEN SEMI-RECESSED F8 2403-R3
BRUSHED CHROME W/ MP3 FIRE EXTINGUISHER

◇ ◇ ◇ ◇ = 1 HR RATED WALL (UL U305)

34.25" = CLEAR EXIT WIDTH

68.5" = CLEAR EXIT WIDTH


⊗ = EXIT

B.A. = BUILDING ADDRESS- 6" MIN. HEIGHT, ON
CONTRASTING BACKGROUND, READILY VISIBLE FROM
STREET


K.B. = KNOX BOX FIRE DEPARTMENT KEY LOCK BOX
CONFIRM LOCATION W/ FIRE DEPARTMENT

P.H. = PANIC HARDWARE


⊞ = EMERGENCY EXIT SIGN

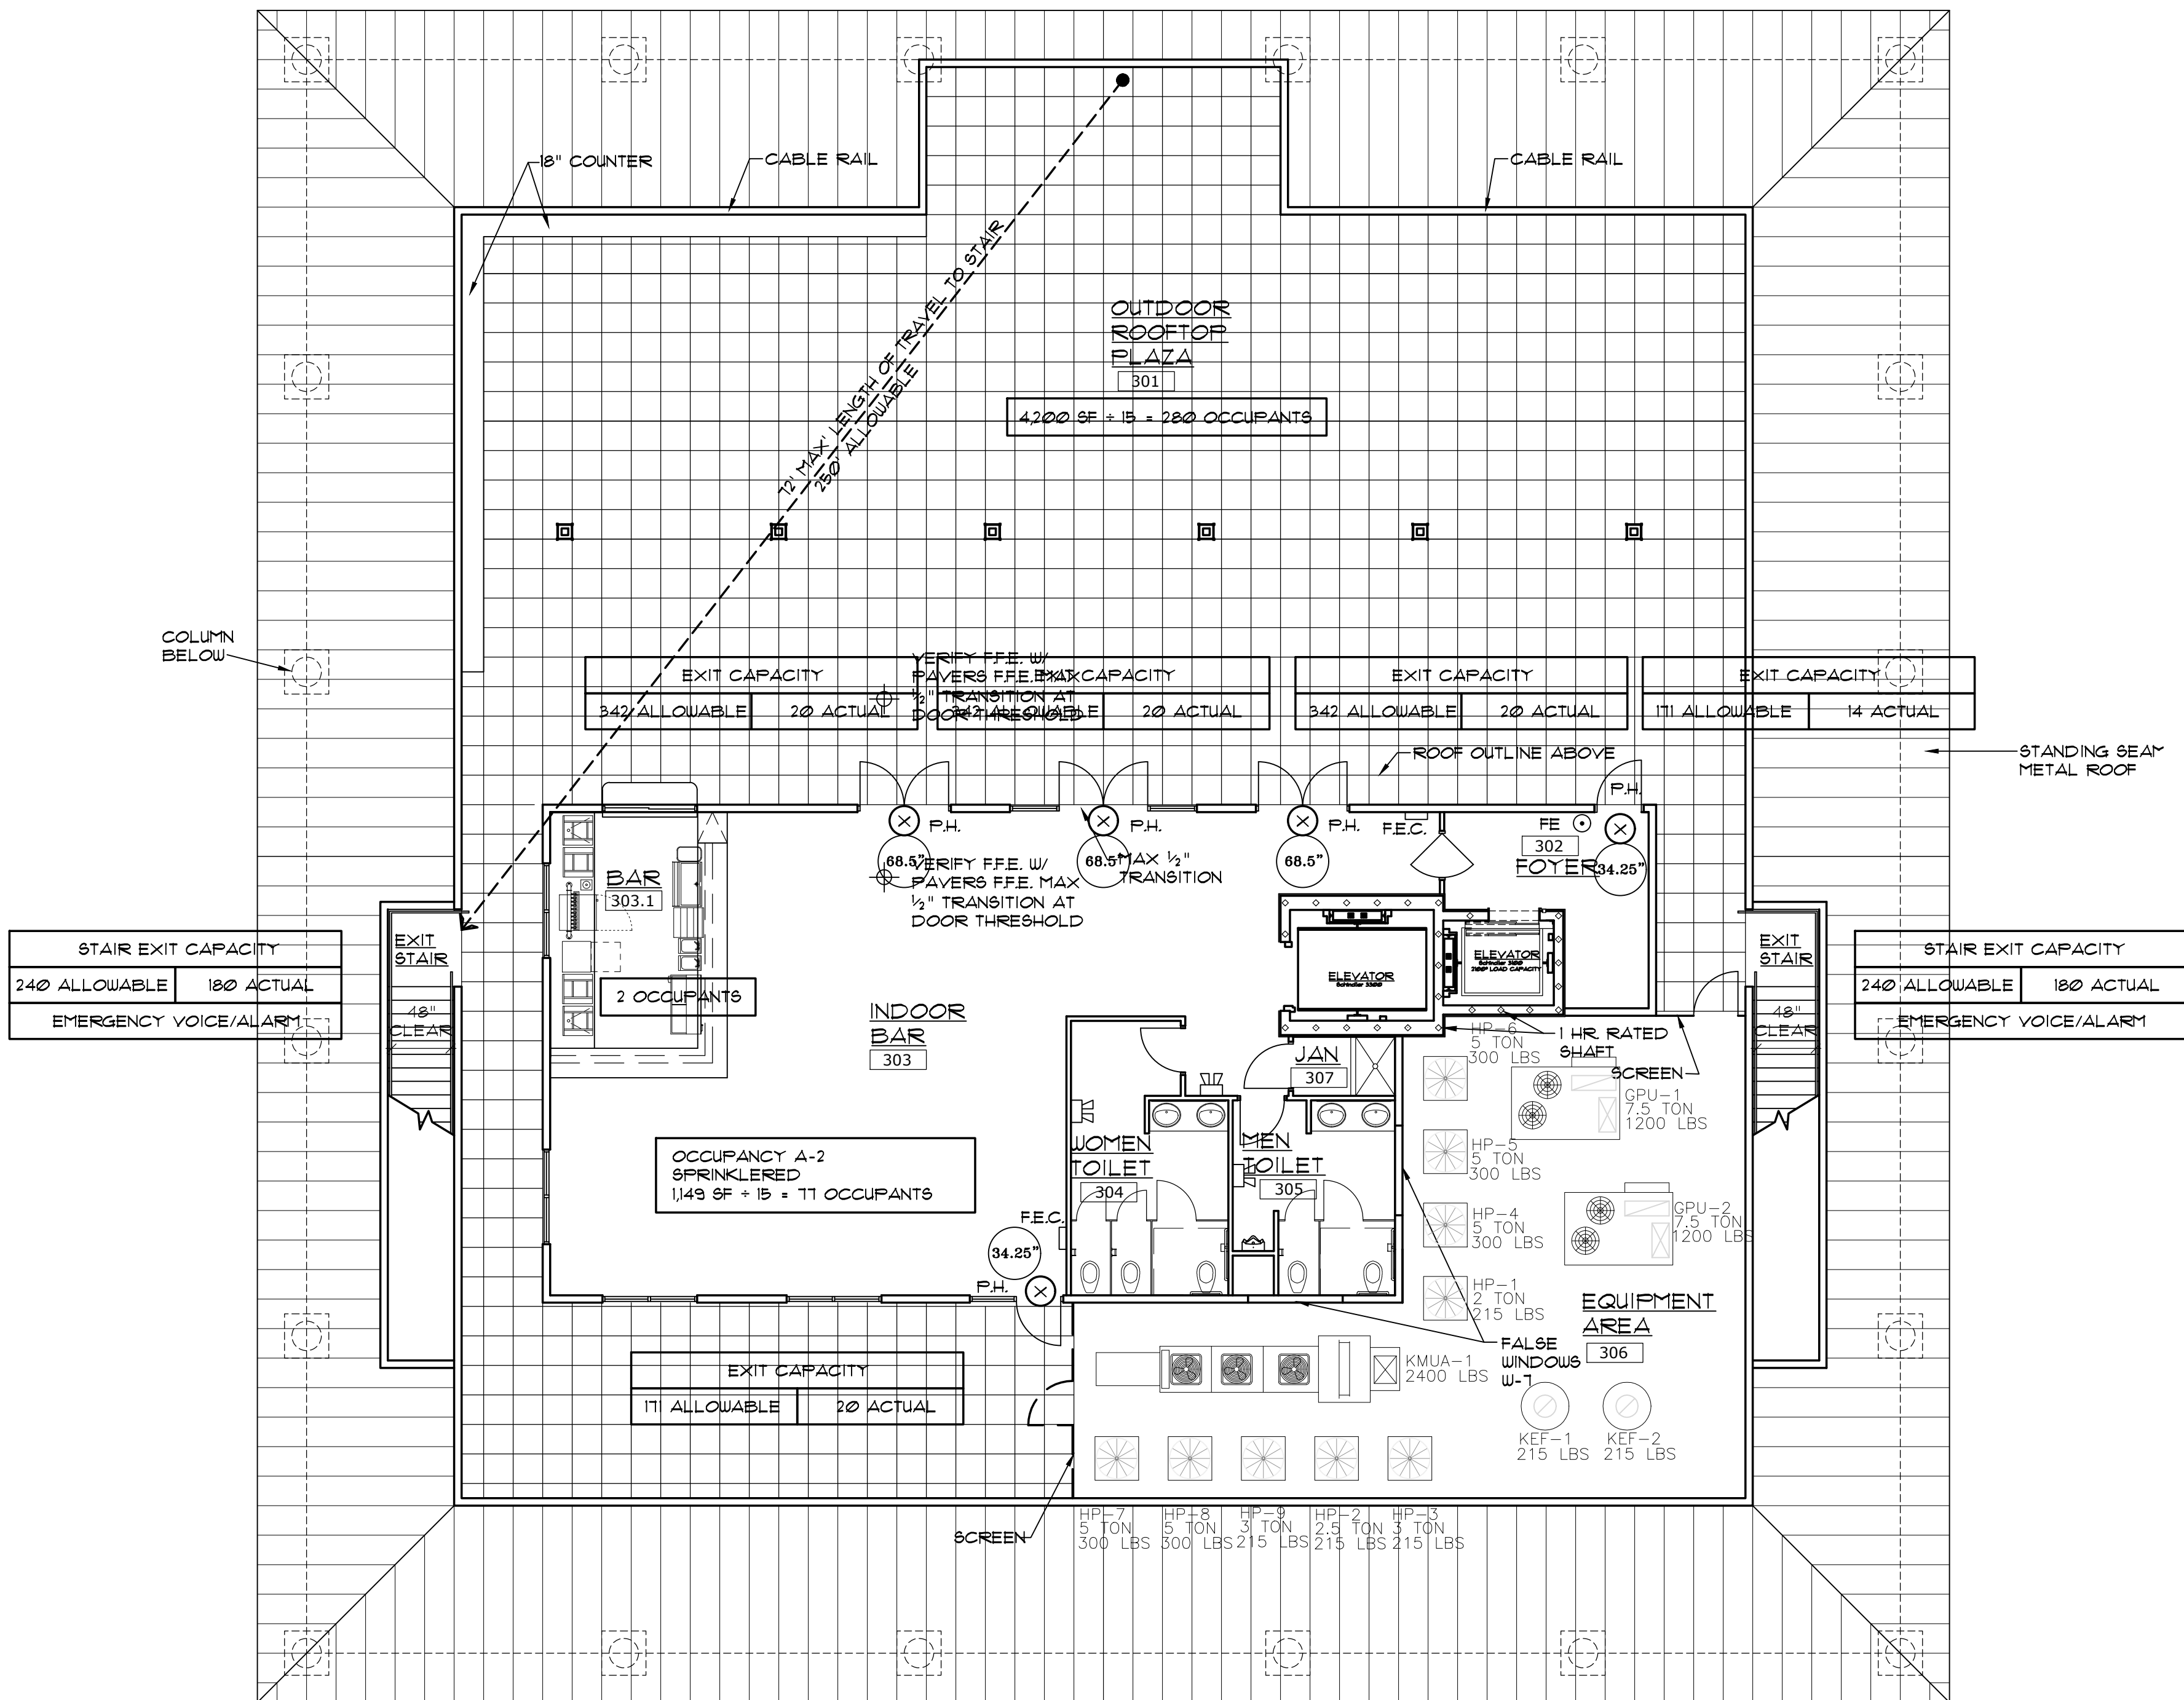

1 LIFE SAFETY PLAN - ROOF TOP FLOOR
1-22 SCALE: 1/8" = 1'-0"

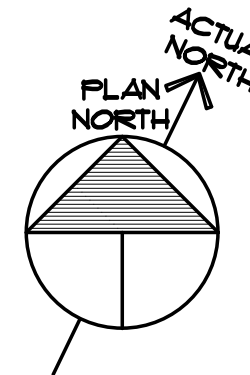

MOREHEAD CITY COUNTRY CLUB
CLUBHOUSE
MOREHEAD CITY, NORTH CAROLINA

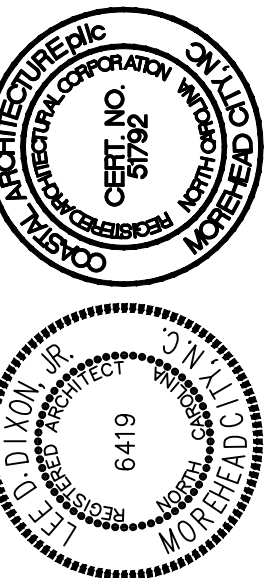


FIRST FLOOR PLAN

20010



ISSUED: 01/29/21
DWG BY: LSA/BLS/MES
CKD BY: LDD

REVISIONS

SHEET NO.
A-1
OF

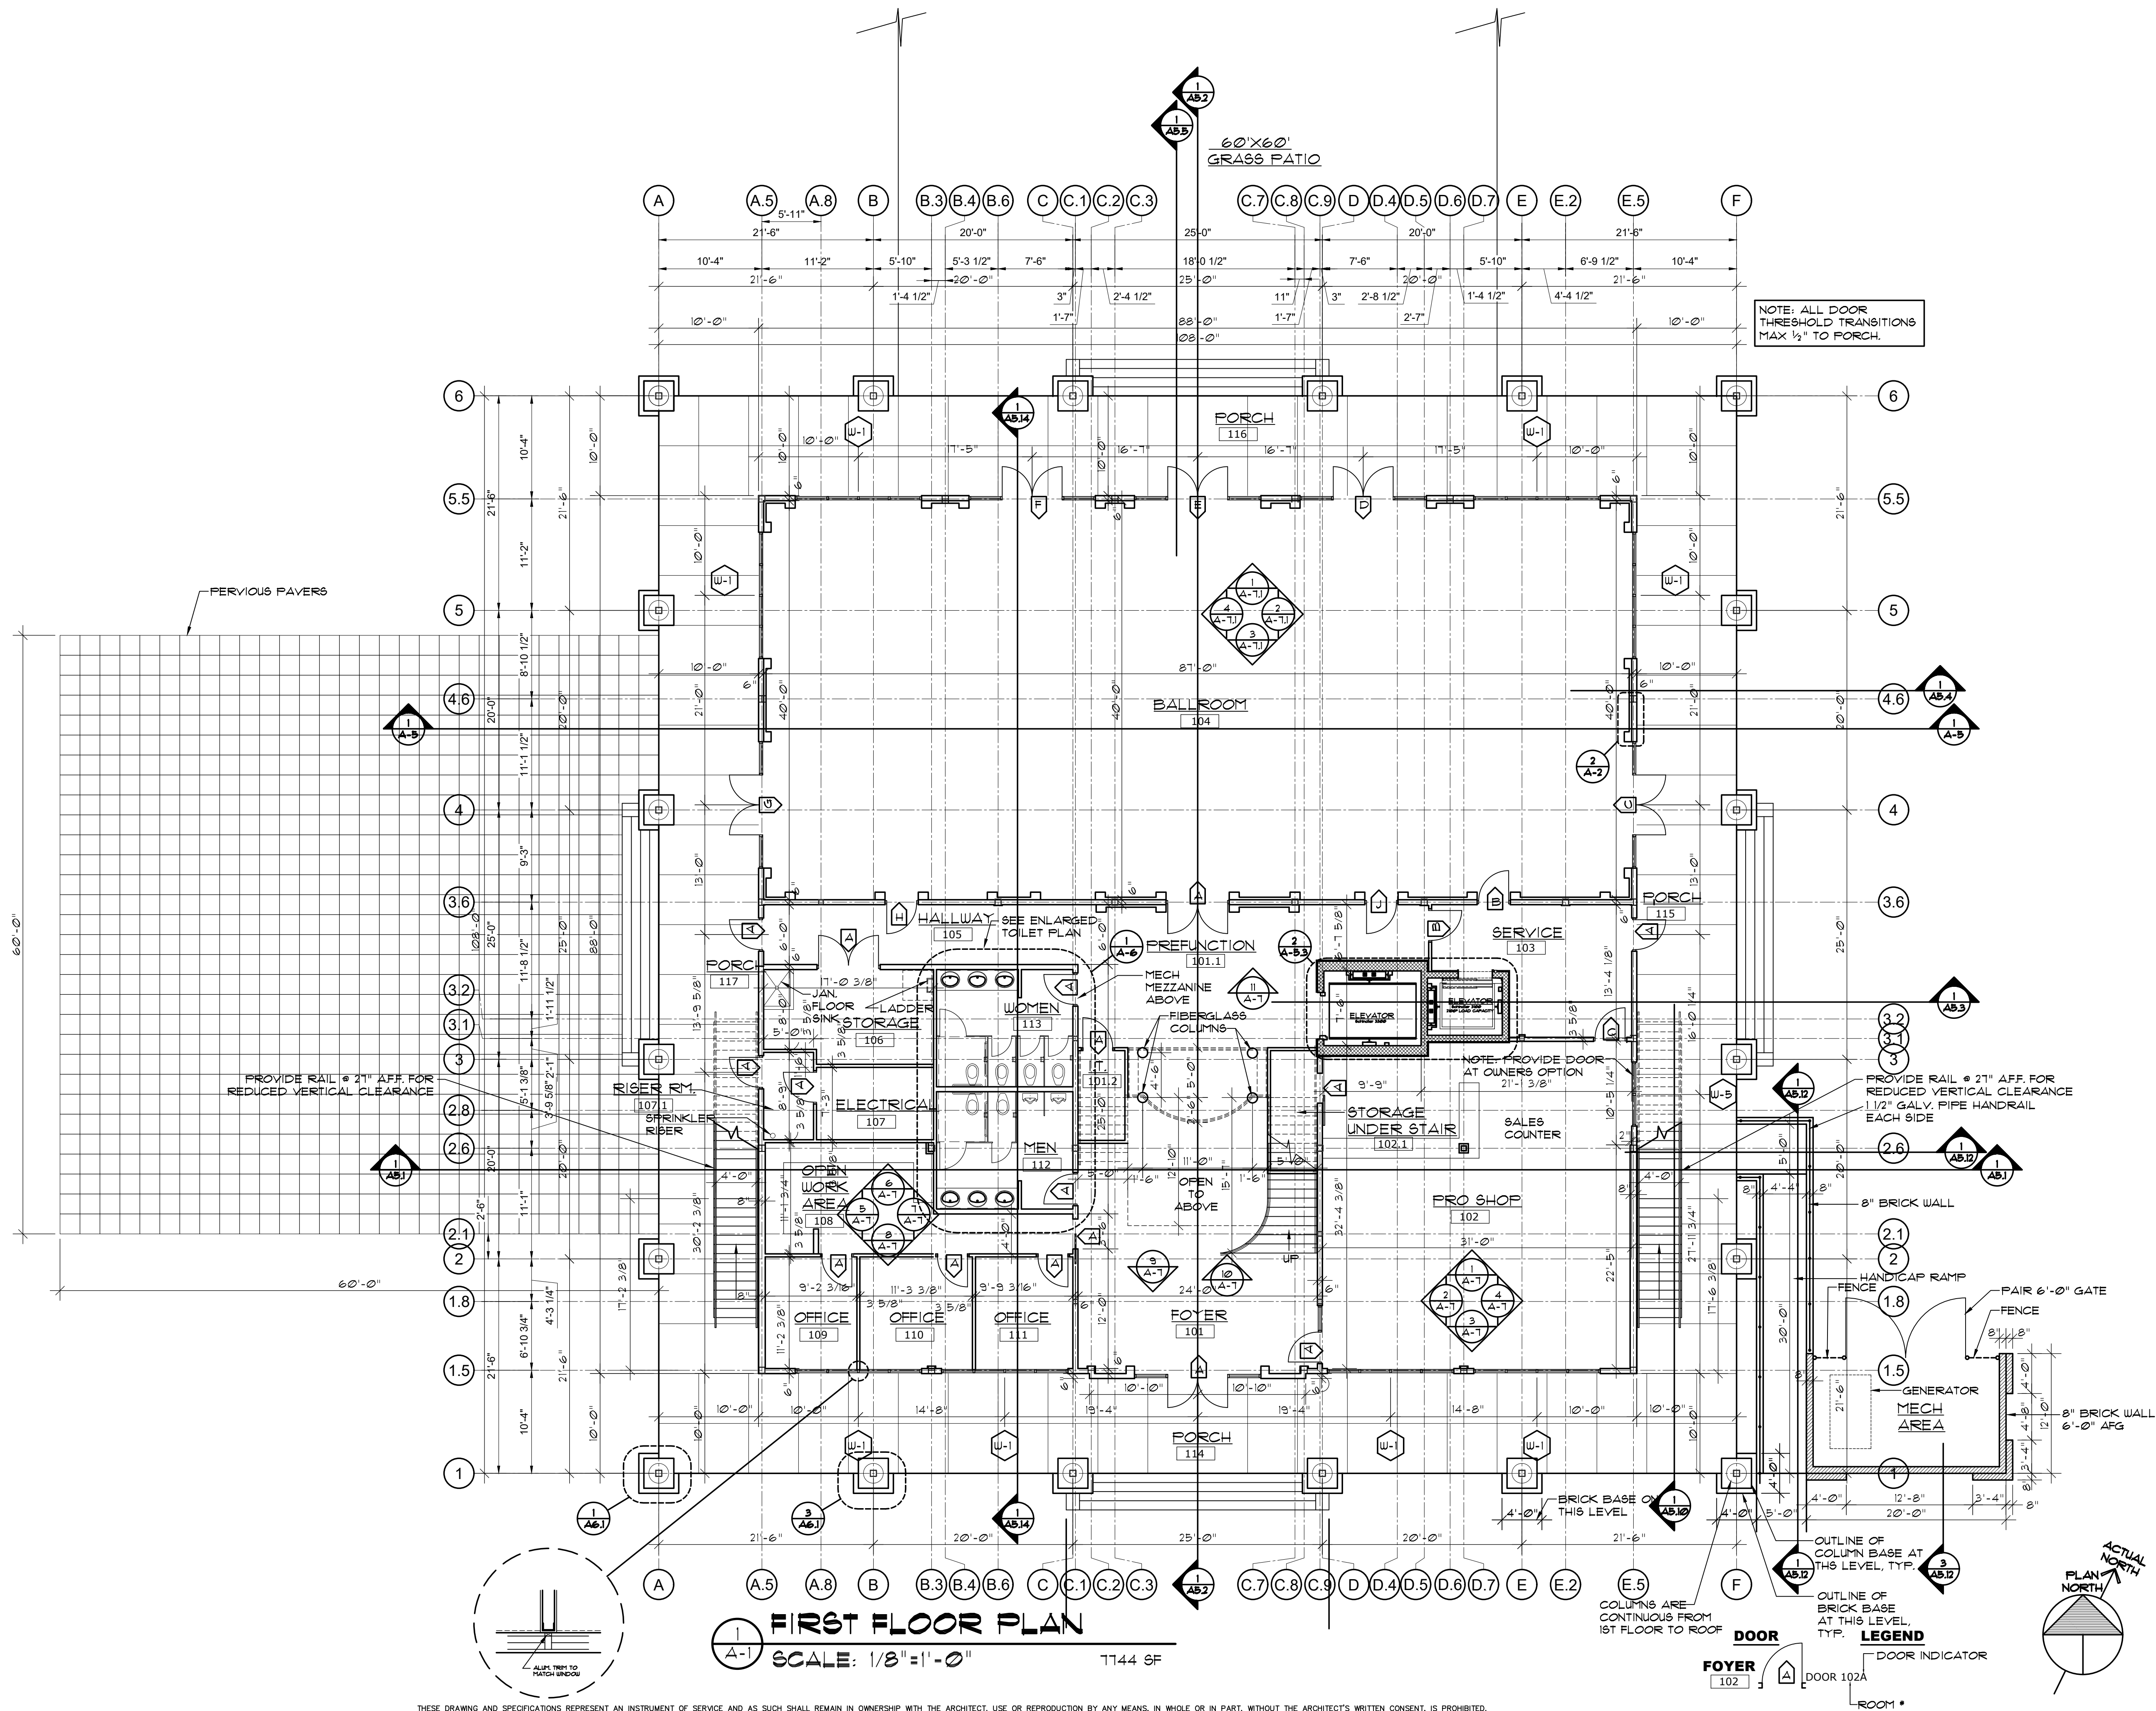

MOREHEAD CITY COUNTRY CLUB
CLUBHOUSE
MOREHEAD CITY, NORTH CAROLINA

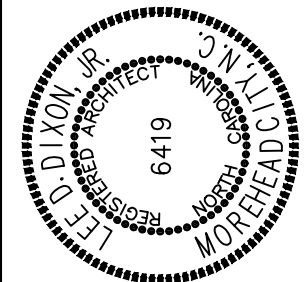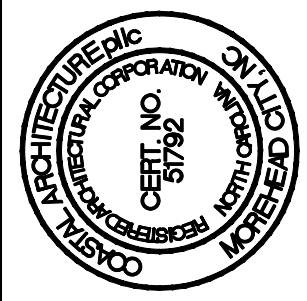

SECOND FLOOR PLAN


20010

ISSUED: 01/29/21
DWG BY: LSA/BLS/MES
CKD BY: LDD



REVISIONS

SHEET NO.

A-1.1
OF

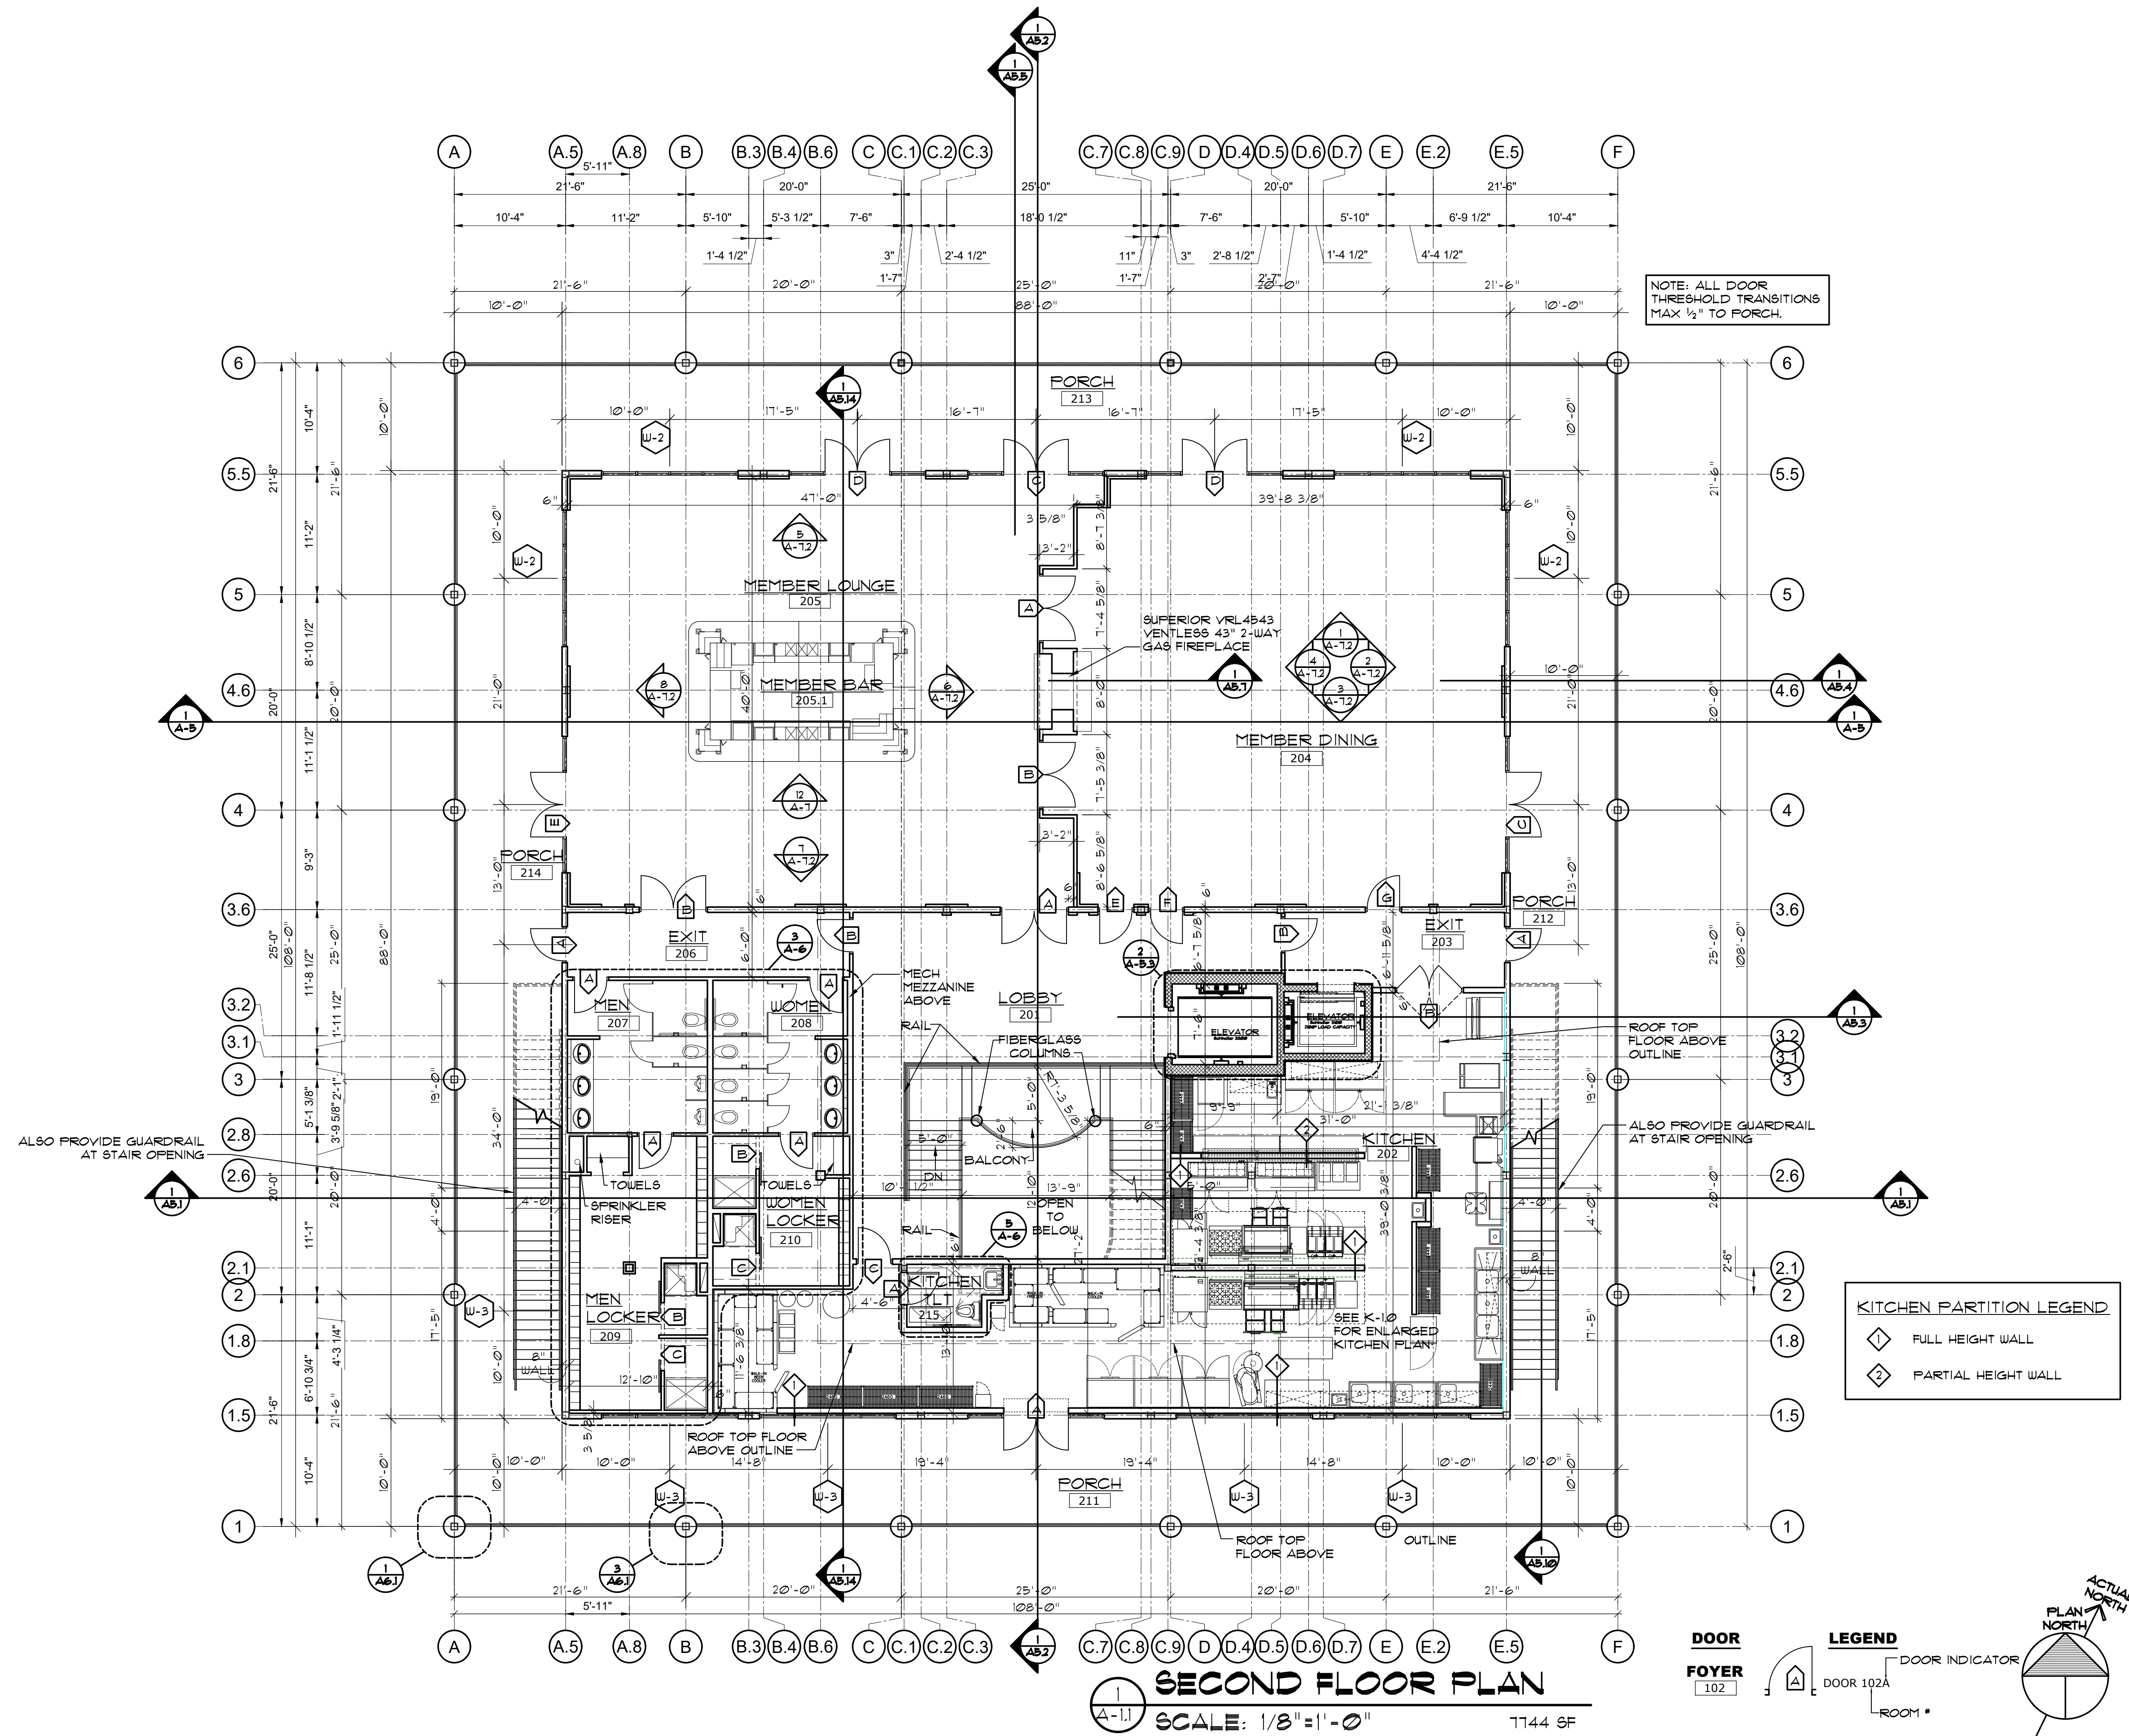

MOREHEAD CITY COUNTRY CLUB
CLUBHOUSE
MOREHEAD CITY, NORTH CAROLINA

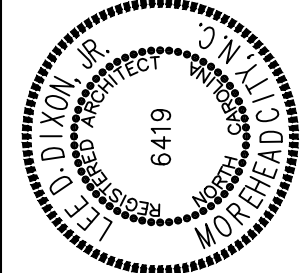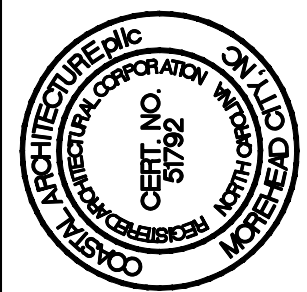

ROOF TOP
FLOOR PLAN


20010

ISSUED: 01/29/21
DWG BY: BLS/MES
CKD BY: LDD


REVISIONS

SHEET NO.

A-1.2
OF

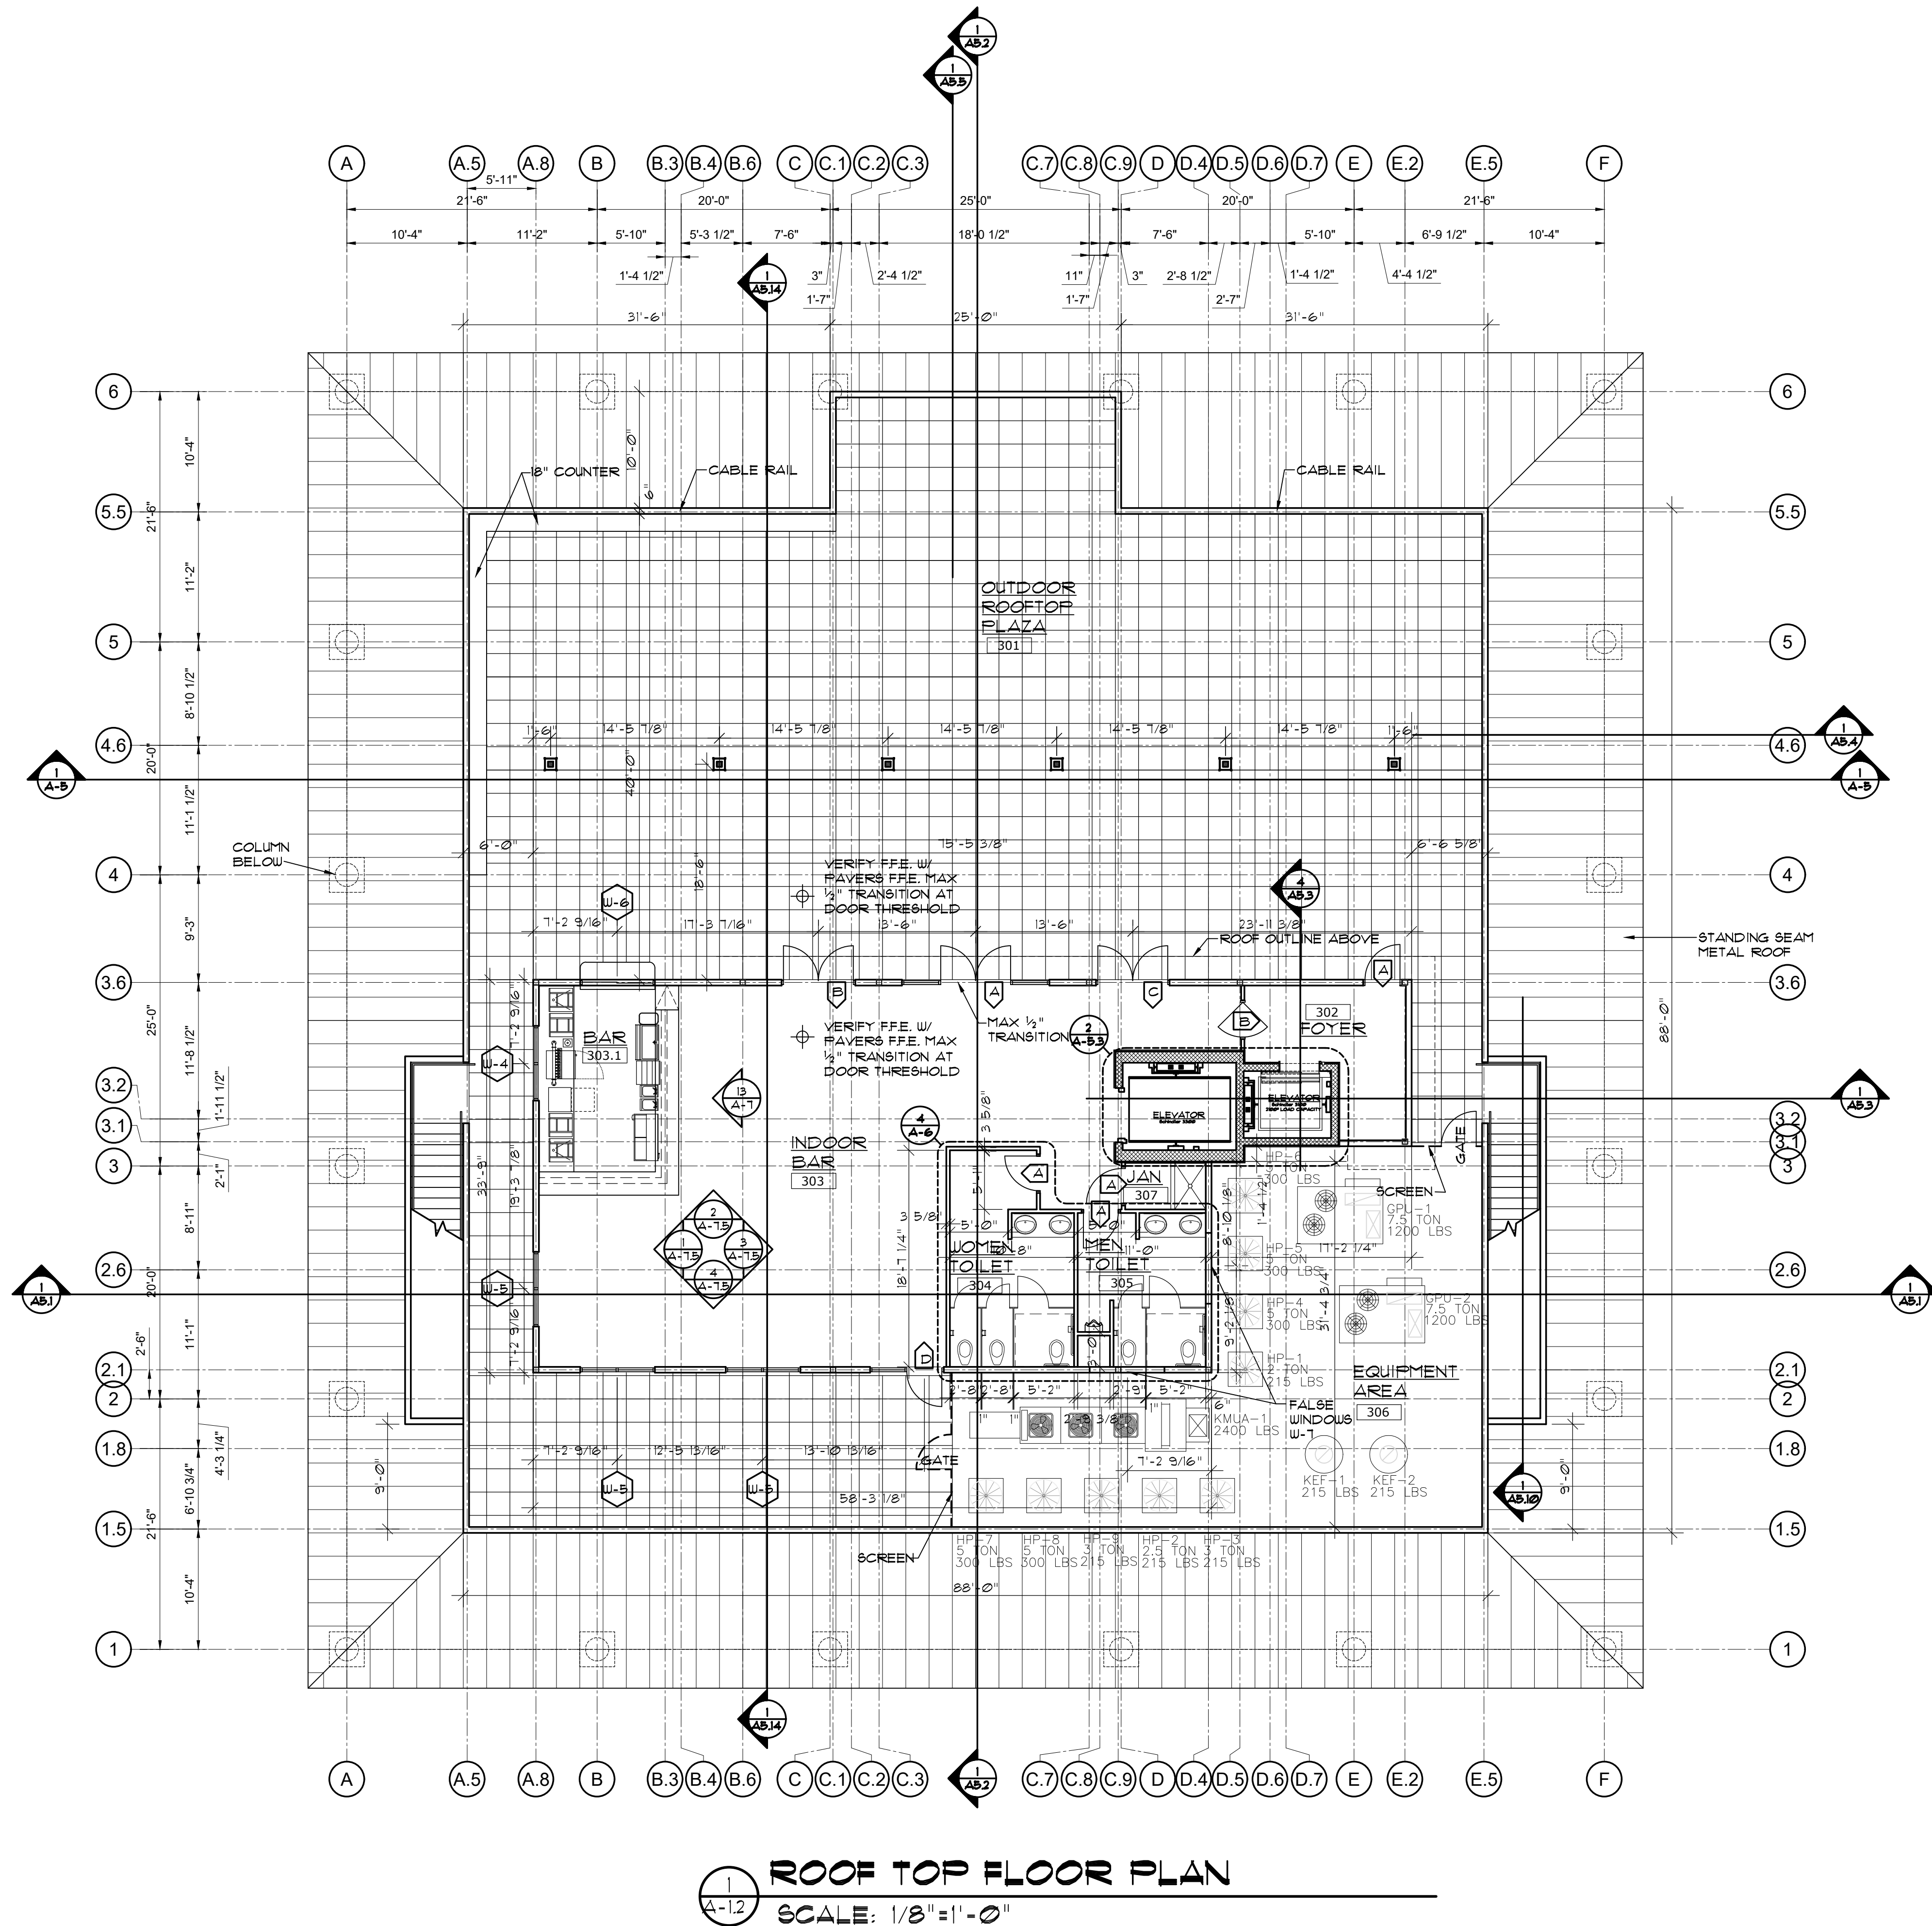

1
A-1.2
ROOF TOP FLOOR PLAN
SCALE: 1/8" = 1'-0"

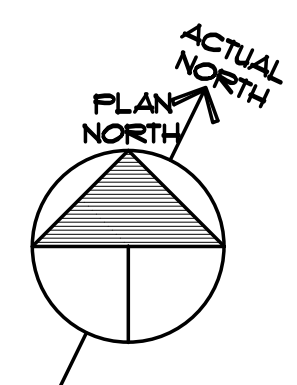

TPO ROOFING SYSTEM AND DESIGN CRITERIA


1. PROVIDE COMPLETE SHOP DRAWINGS SHOWING ALL ATTACHMENTS, FLASHING, DETAILS, ETC. ALL ROOF SYSTEMS TO MEET REQUIRED WIND LOADS. SUBMIT TO ARCHITECT FOR APPROVAL.
2. PROVIDE 30 YEAR WARRANTY ON COMPLETE ROOF SYSTEM.
3. MEMBRANE: FIRESTONE ULTRAPLY PLATINUM TPO, .80" THICK, FULLY ADHESIVE.
4. WALKWAY PAD, TPO ECO PAD, PROVIDE WALKWAY PAD AT ALL HATCHES AND MECHANICAL EQUIPMENT.
5. PARAPET COPING AND EDGE METAL SYSTEMS: FIRESTONE ANCHORGUARD PLATINUM FASCOA OR COPING SYSTEM
6. COORDINATE WITH ROOF PLAZA PAVERS DESIGN

GENERAL NOTES FOR ROOFING SYSTEMS & DESIGN CRITERIA


1. ROOF DRAINAGE IS SHOWN FOR GENERAL INFORMATION ONLY. SEE PLUMBING DRAWING FOR LOCATION AND SIZE. REFERENCE CIVIL DRAWINGS FOR ROOF DRAIN AND ROLL TIE IN OVERFLOW DRAINS TO DRAIN TO DAYLIGHT THROUGH EXTERIOR WALLS. TERMINATE OVERFLOW DRAINS WITH DECORATIVE SCUPPER.
2. ALL ROOF TOP EQUIPMENT, PLUMBING, VENTS, CONDENSING UNITS, EXHAUST FANS, ETC. ARE TO BE CONCEALED FROM VIEW BEHIND PARAPET WALLS.
3. KEEP ROOF MOUNTED EQUIPMENT AWAY FROM ROOF EDGE TO REDUCE SIGHTLINES.
4. PROVIDE POWER OUTLETS AROUND PERIMETER AND NEAR HVAC EQUIPMENT FOR SERVICING AND MAINTENANCE.
6. INSIDE FACES OF PARAPETS TO BE CLAD IN TPO ROOFING MEMBRANE FROM FRONT EDGE OF TOP, OVER TOP AND DOWN BACKSIDE OF PARAPET.
7. PROVIDE DOUBLE LAYER ROOF MEMBRANE UNDER WALKWAY PAD.
8. SLOPE TOP OF PARAPETS TOWARDS ROOF AT 1/8" : 12" - TYPICAL.
9. PROVIDE CURBS AND VIBRATION ISOLATION BLOCKS AT ALL ROOF TOP EQUIPMENT.
10. ENSURE POSITIVE DRAINAGE TO ALL ROOF DRAINS AND OVERFLOW DRAINS. MAINTAIN A SLOPE OF 1/4" MINIMUM.
11. ALL MECHANICAL DUCT WORK IS TO BE INSULATED IN WHITE WRAP TO MATCH ROOF COLOR.
12. NO DUCTWORK OR EQUIPMENT IS TO BE VISIBLE FROM GROUND LEVEL.
13. ENSURE STUBS AND COLLECTORS ARE INSTALLED DURING FOUNDATION INSTALLATION TO SUPPORT ROOF DRAINS.
14. SEE PLUMBING DRAWINGS FOR ROOF DRAIN AND OVERFLOW DRAIN DETAILS.
15. REFERENCE MECHANICAL, ELECTRICAL, PLUMBING PLANS FOR PENETRATIONS AND EQUIPMENT. PROVIDE WALK SURFACE TO ALL EQUIPMENT FOR MAINTENANCE.
16. PROVIDE PRE-MANUFACTURED INTERIOR & EXTERIOR CORNER CAP/SLEEVE AT ALL CORNERS AND ROUND BOOTS AT ALL PIPE PENETRATIONS WITH TURN-DOWNS AS REQUIRED.
17. MECHANICAL EXHAUST ROOF PENETRATIONS TO RECEIVE SHOP FORMED ALUMINUM CHASE CAP, TYPICAL SEE P.M. & E. DRAWINGS.
18. CONTRACTOR TO PROVIDE TEMPORARY ROOF SYSTEM DURING CONSTRUCTION TO PROTECT CONSTRUCTION ACTIVITIES FROM MOISTURE DAMAGE PRIOR TO FULL BUILDING DRY-IN.

SUBMIT SHOP DRAWINGS FOR

1. ROOFING SYSTEM
2. TAPERED INSULATION
3. FLASHING DETAILS
4. CURB DETAILS
5. ALL ROOF PENETRATIONS
6. ROOF PLAZA PAVERS
7. ROOF DRAINS

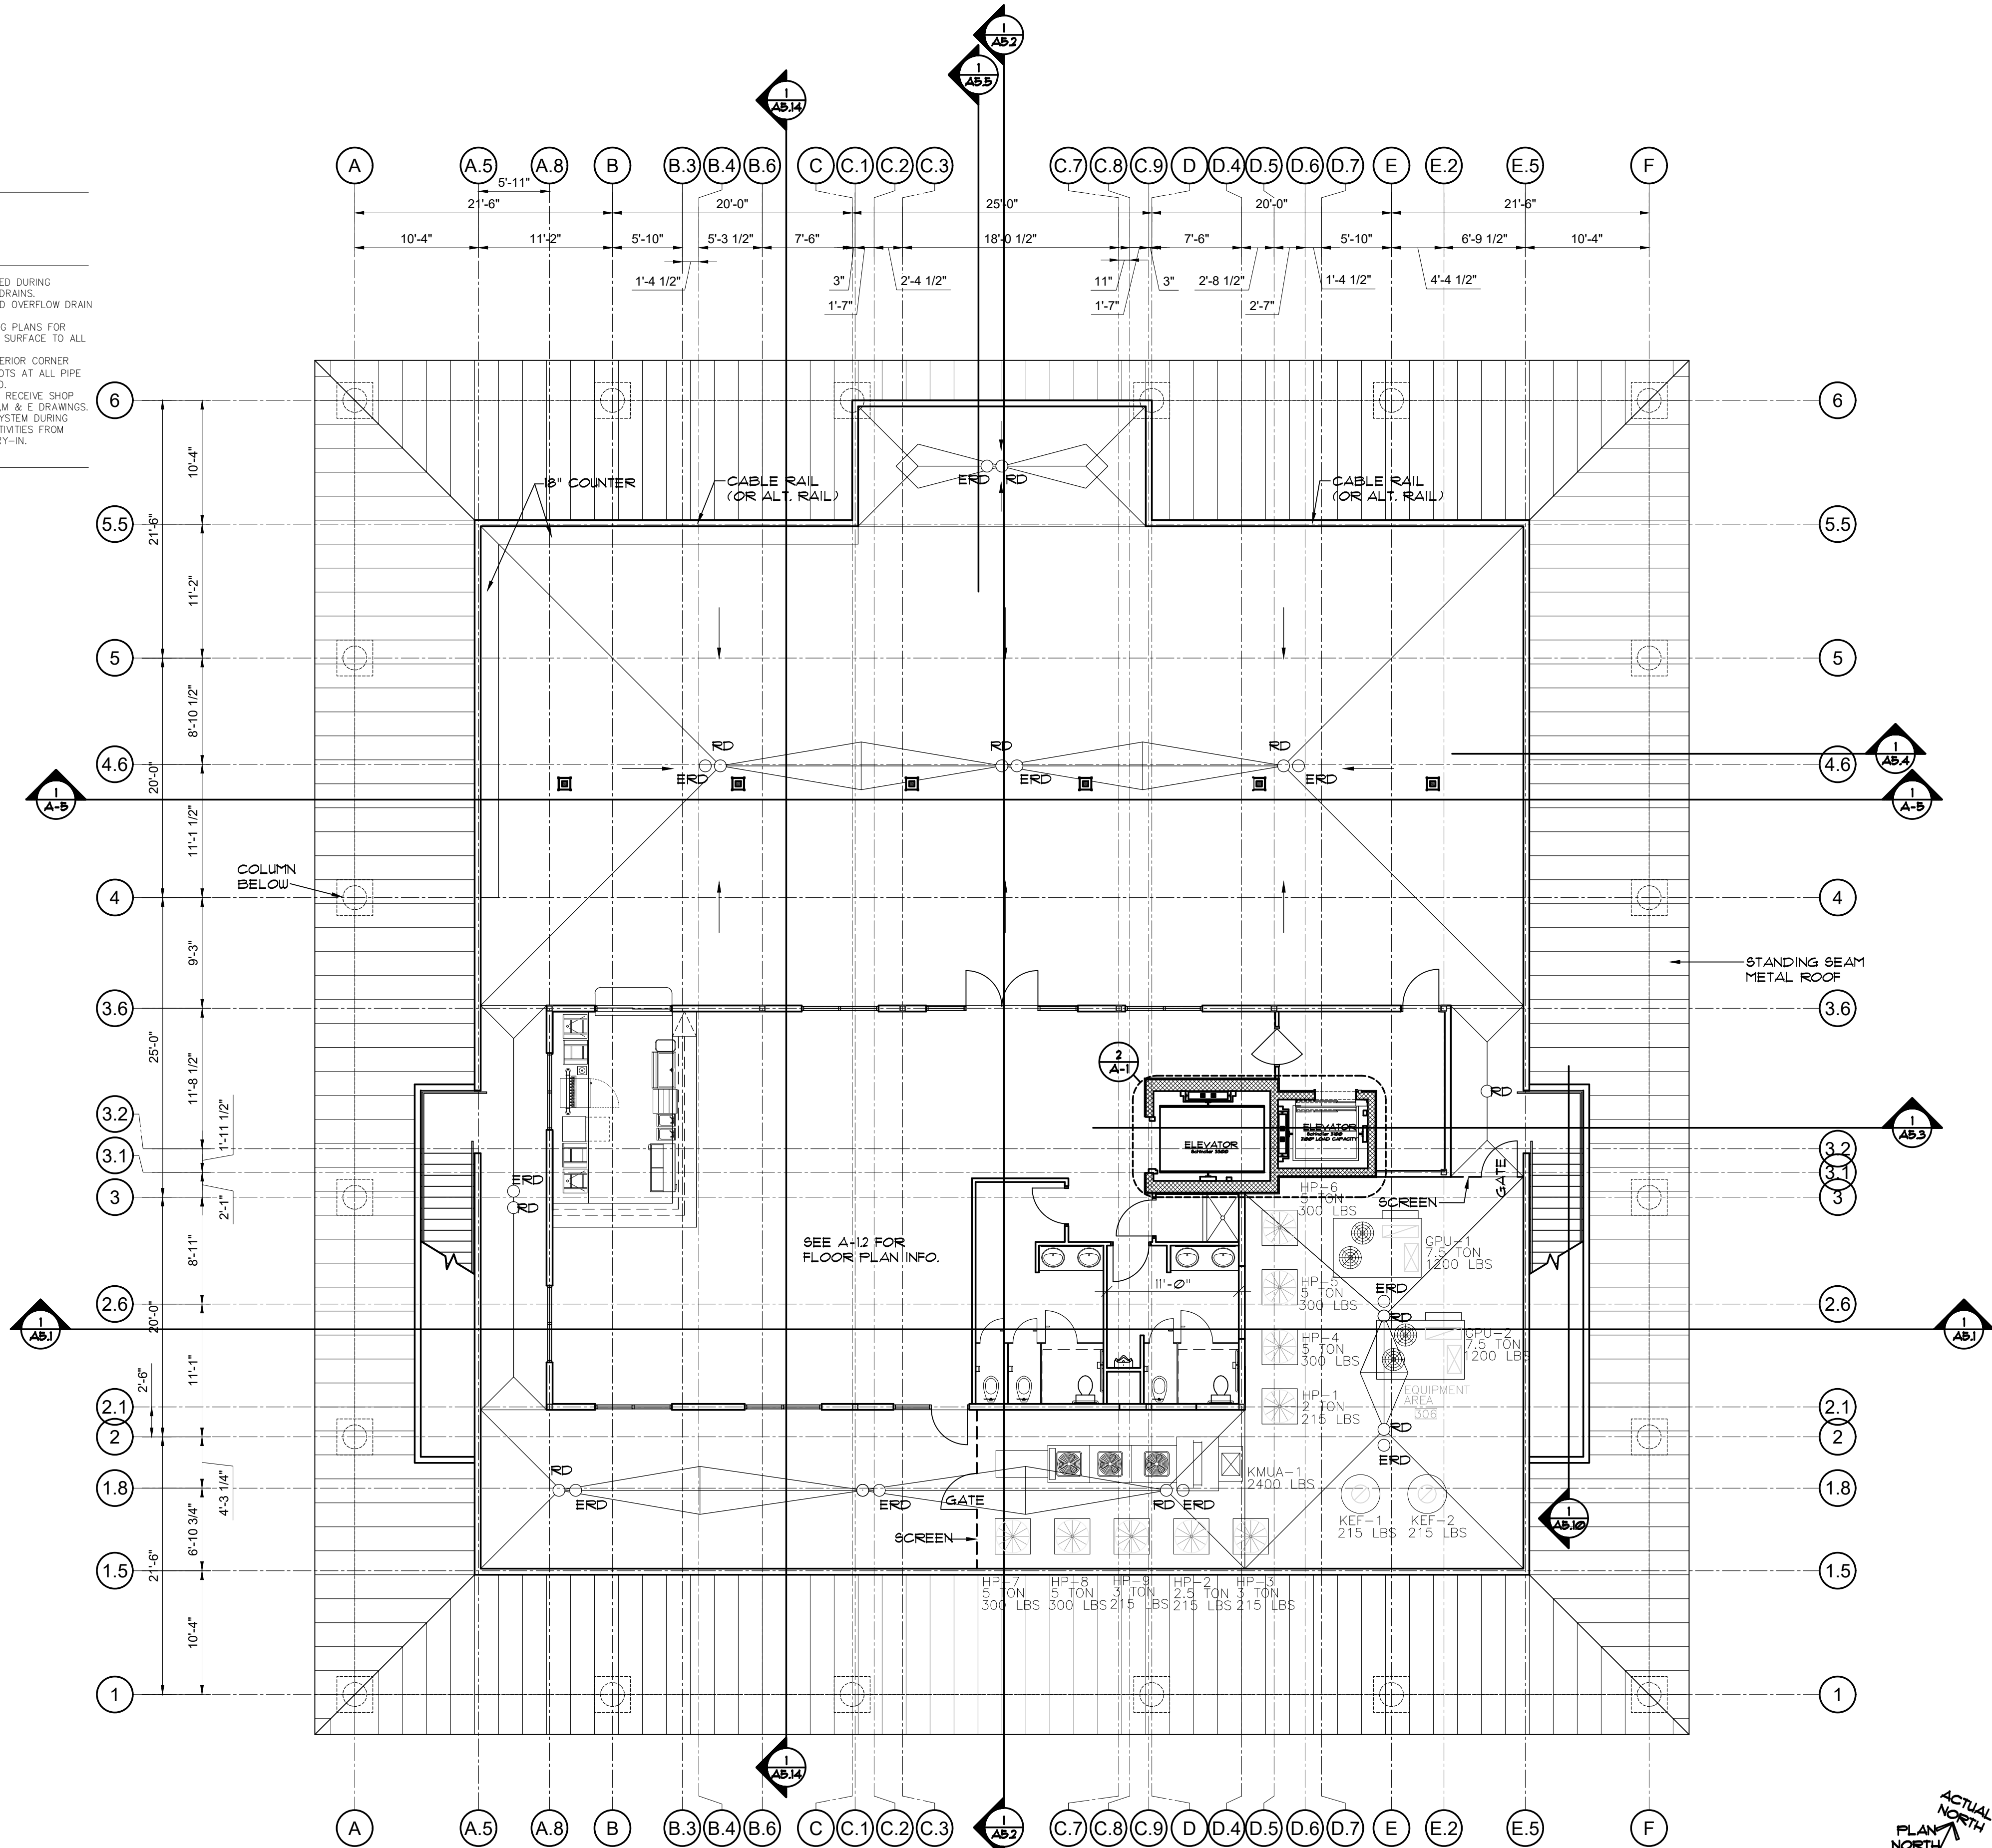

MAIN ROOF PLAN
SCALE: 1/8" = 1'-0"

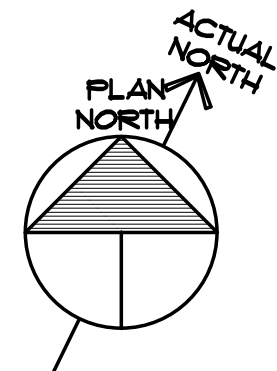

Coastal
Architecture
• Architectural Design
• Planning
• Interiors

Member of the American Institute of Architects

Lee D. Dixon, Jr., AIA
252-247-2127
lee@coastalarchitecture.net

4206 Bridges St. Ext., Suite C
Morehead City, NC 28557

www.CoastalArchitecture.net

MOREHEAD CITY COUNTRY CLUB
CLUBHOUSE
MOREHEAD CITY, NORTH CAROLINA

MAIN ROOF PLAN



20010

ISSUED: 01/29/21
DWG BY: BLS/MES
CKD BY: LDD

REVISIONS

SHEET NO.
A-1.3
OF

MOREHEAD CITY COUNTRY CLUB
CLUBHOUSE
MOREHEAD CITY, NORTH CAROLINA

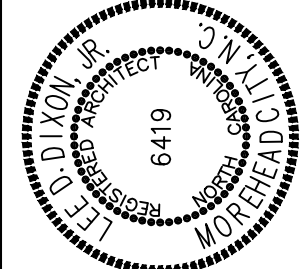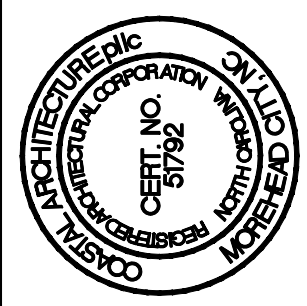


HIGH ROOF PLAN

20010


ISSUED: 01/29/21
DWG BY: BLS
CKD BY: LDD

REVISIONS



SHEET NO.
A-1.4
OF

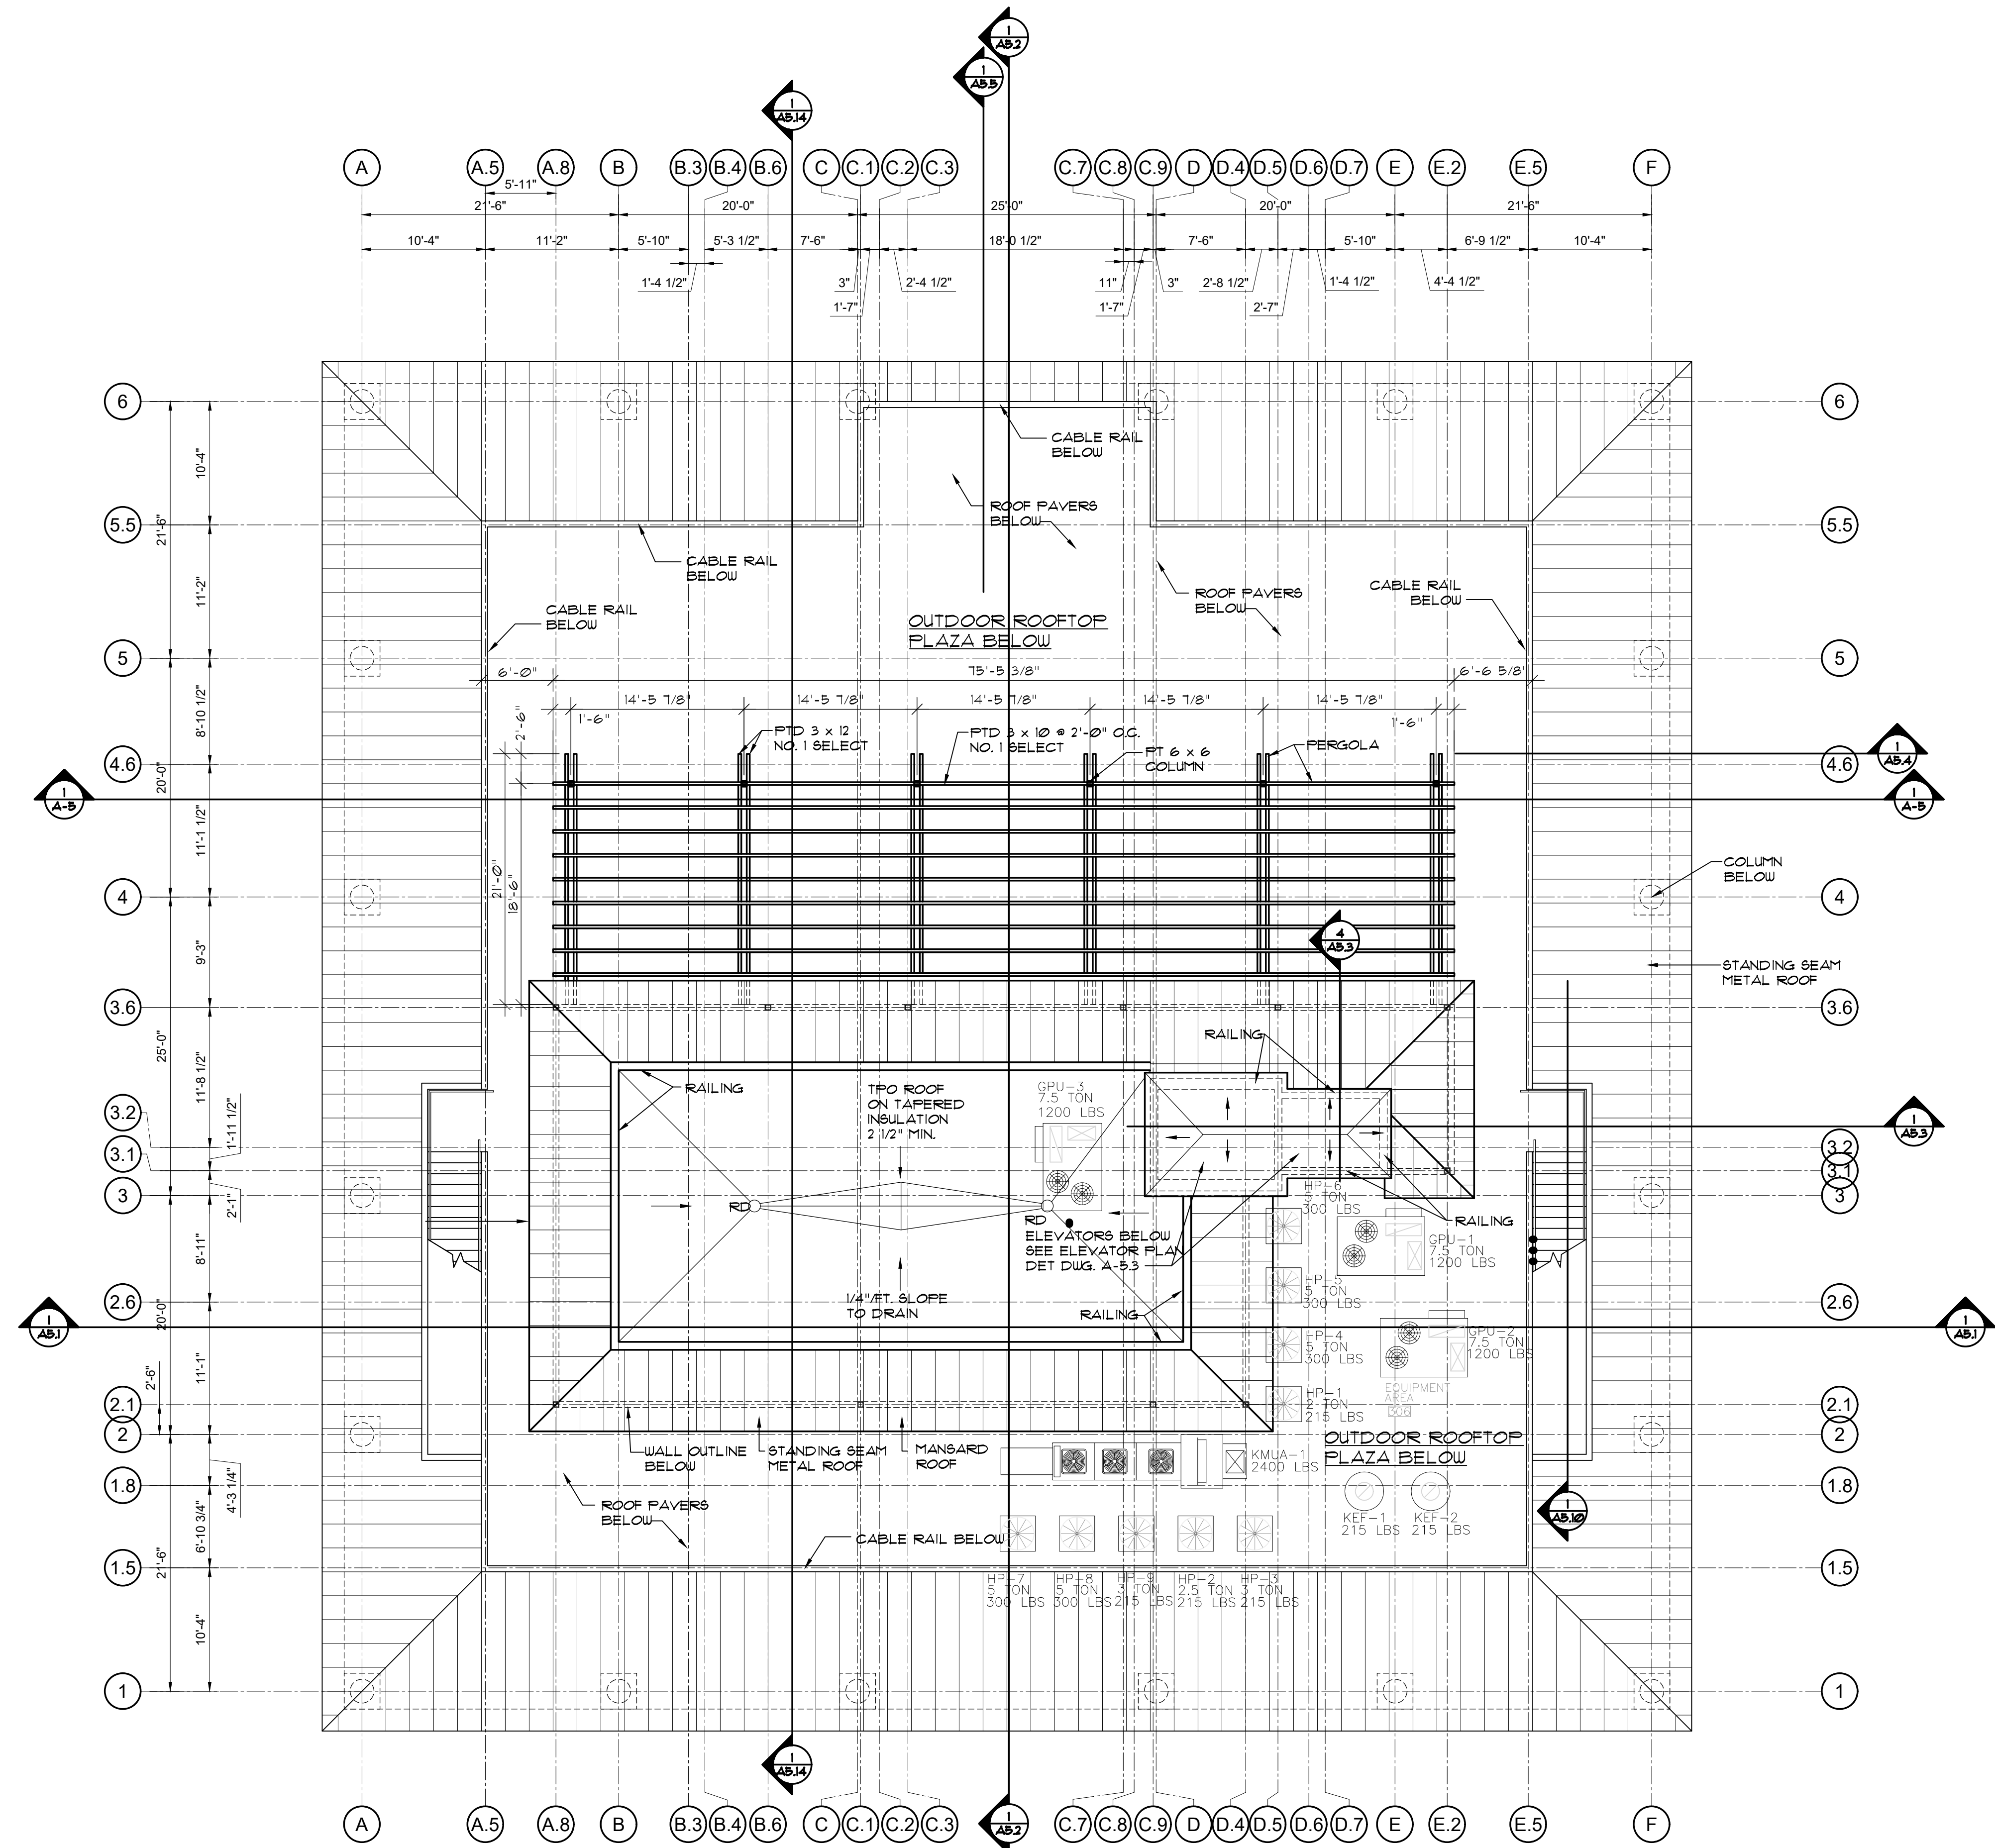

HIGH ROOF PLAN
SCALE: 1/8" = 1'-0"

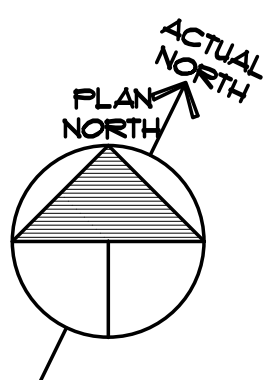

MOREHEAD CITY COUNTRY CLUB
CLUBHOUSE
MOREHEAD CITY, NORTH CAROLINA

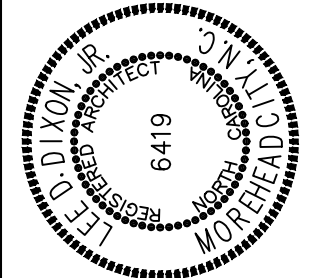
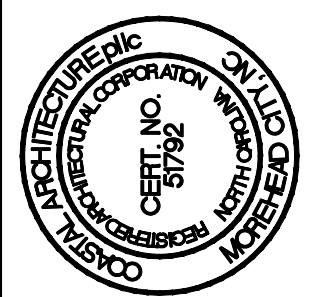


FIRST FLOOR
REFLECTED CEILING
PLAN

20010

ISSUED: 01/29/21
DWG BY: MES
CKD BY: LDD
REVISIONS

SHEET NO.
A-2
OF

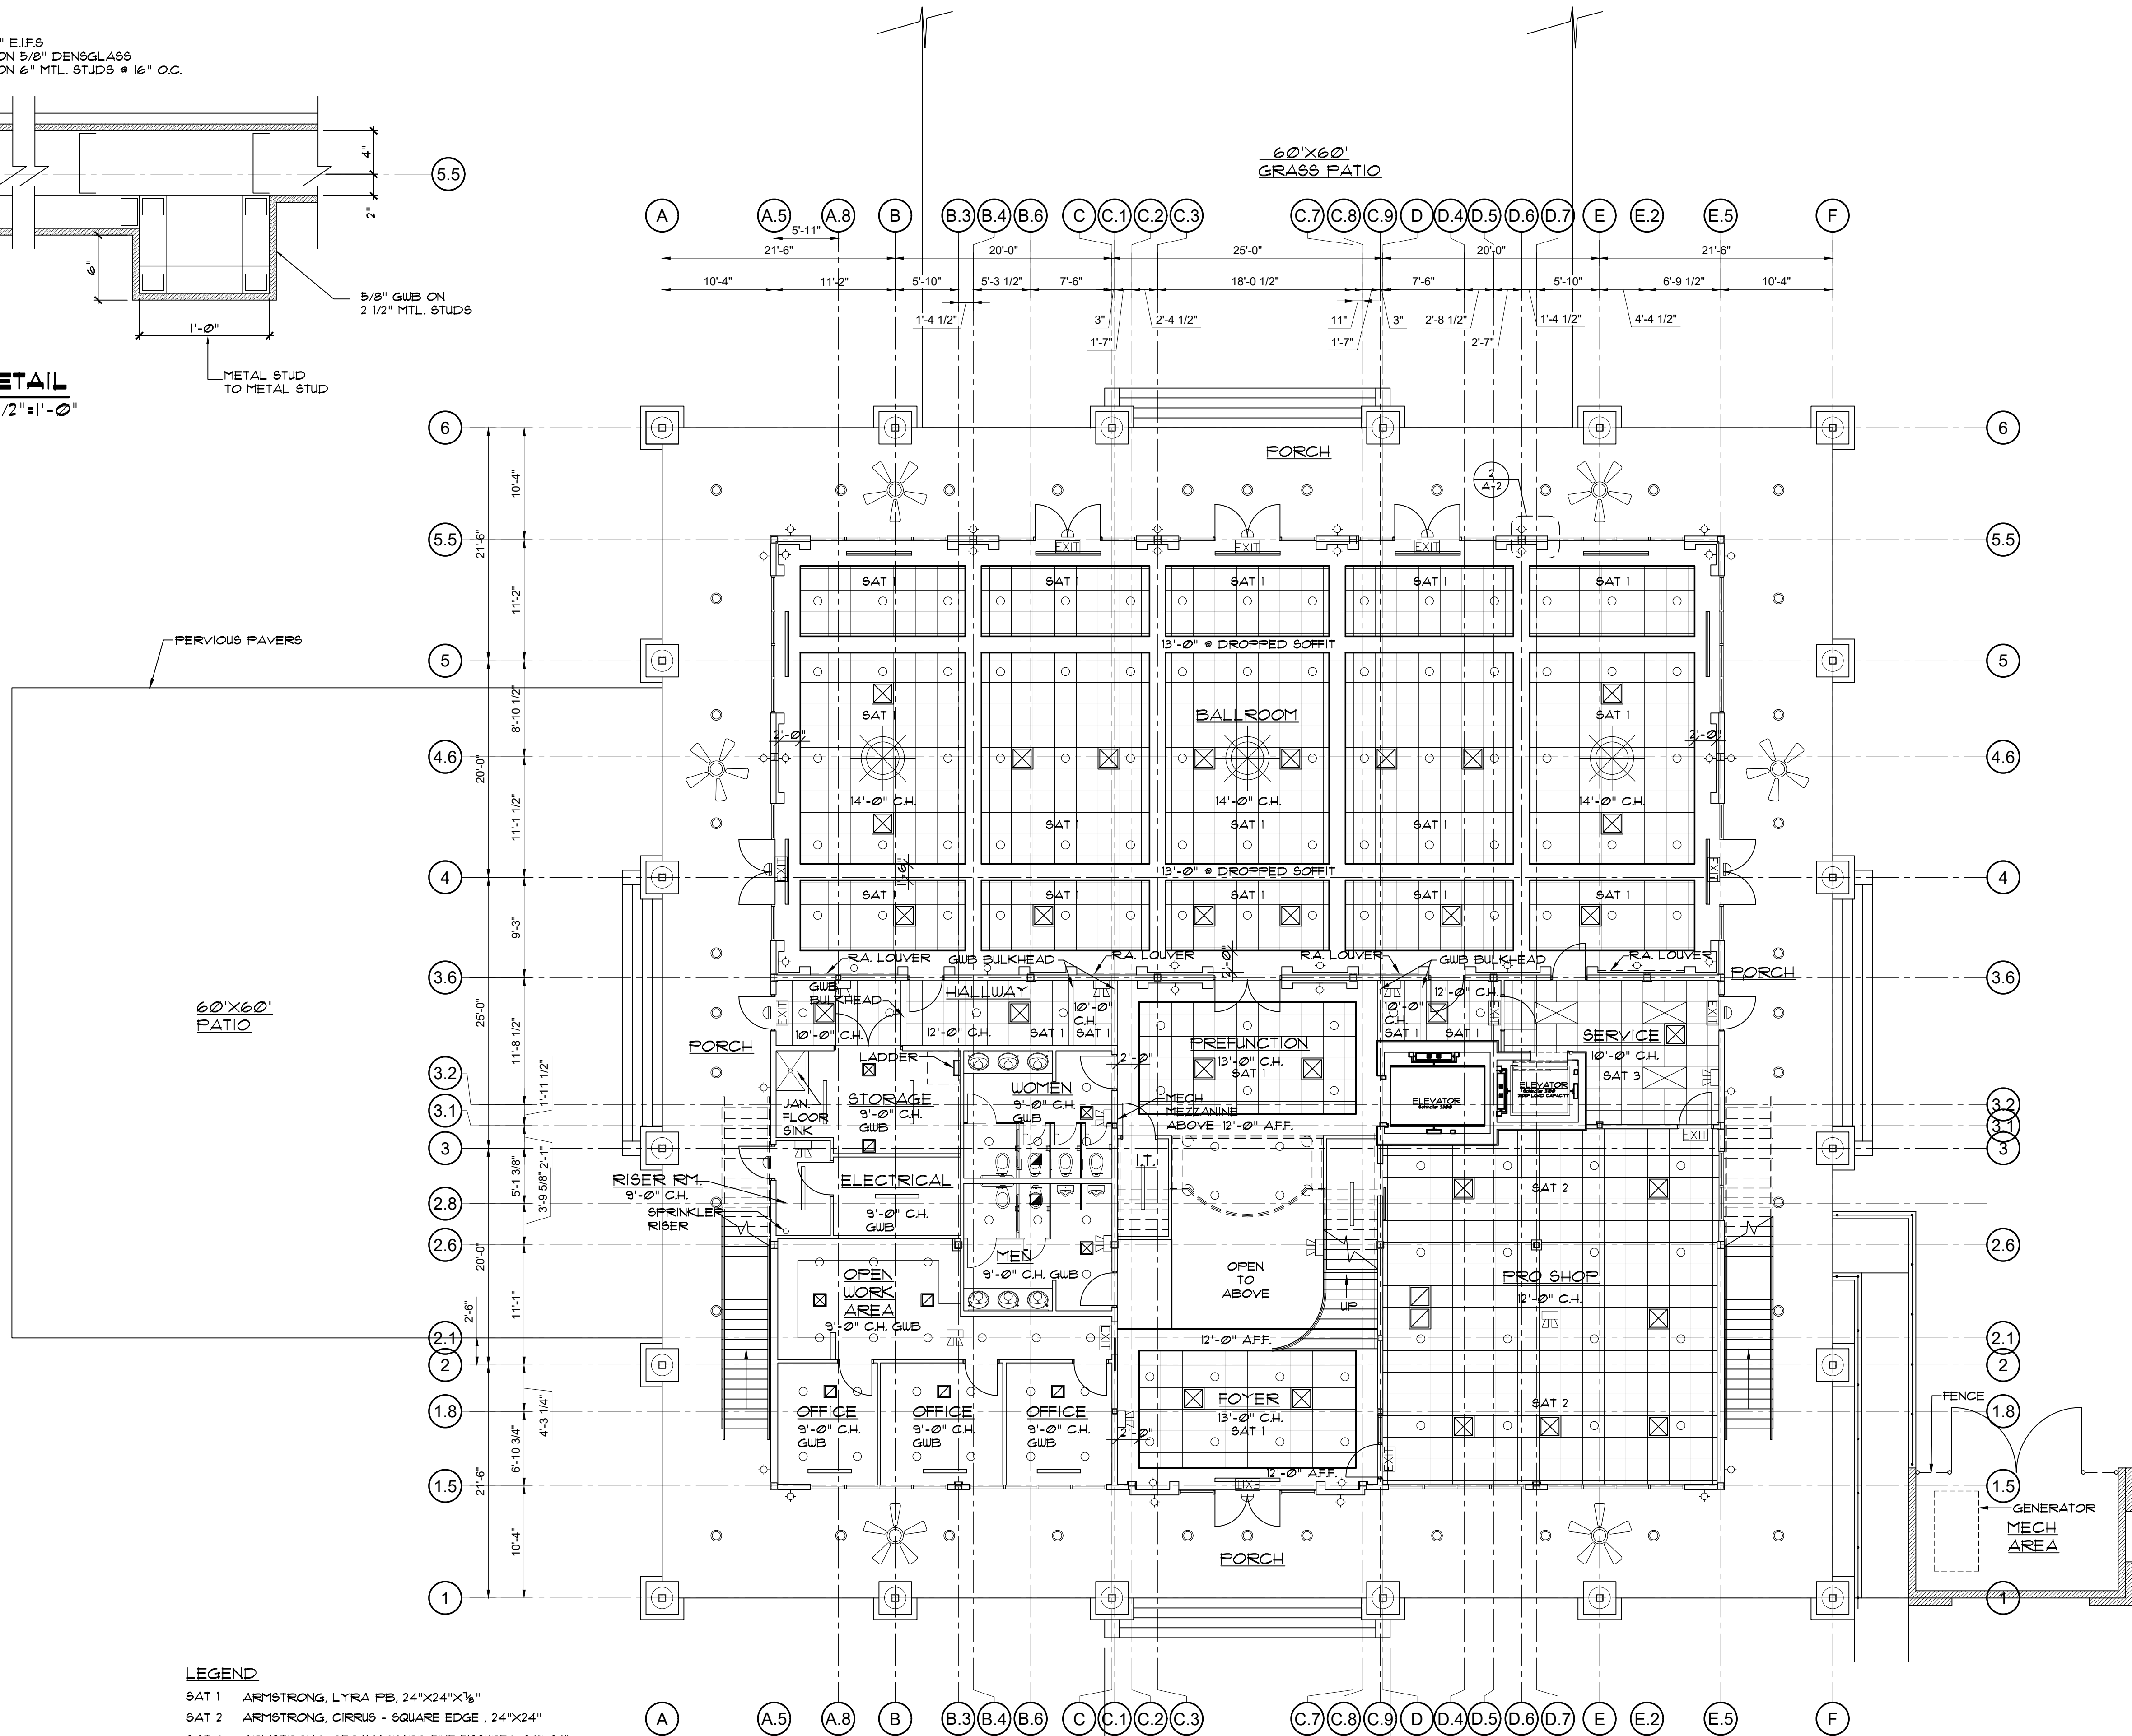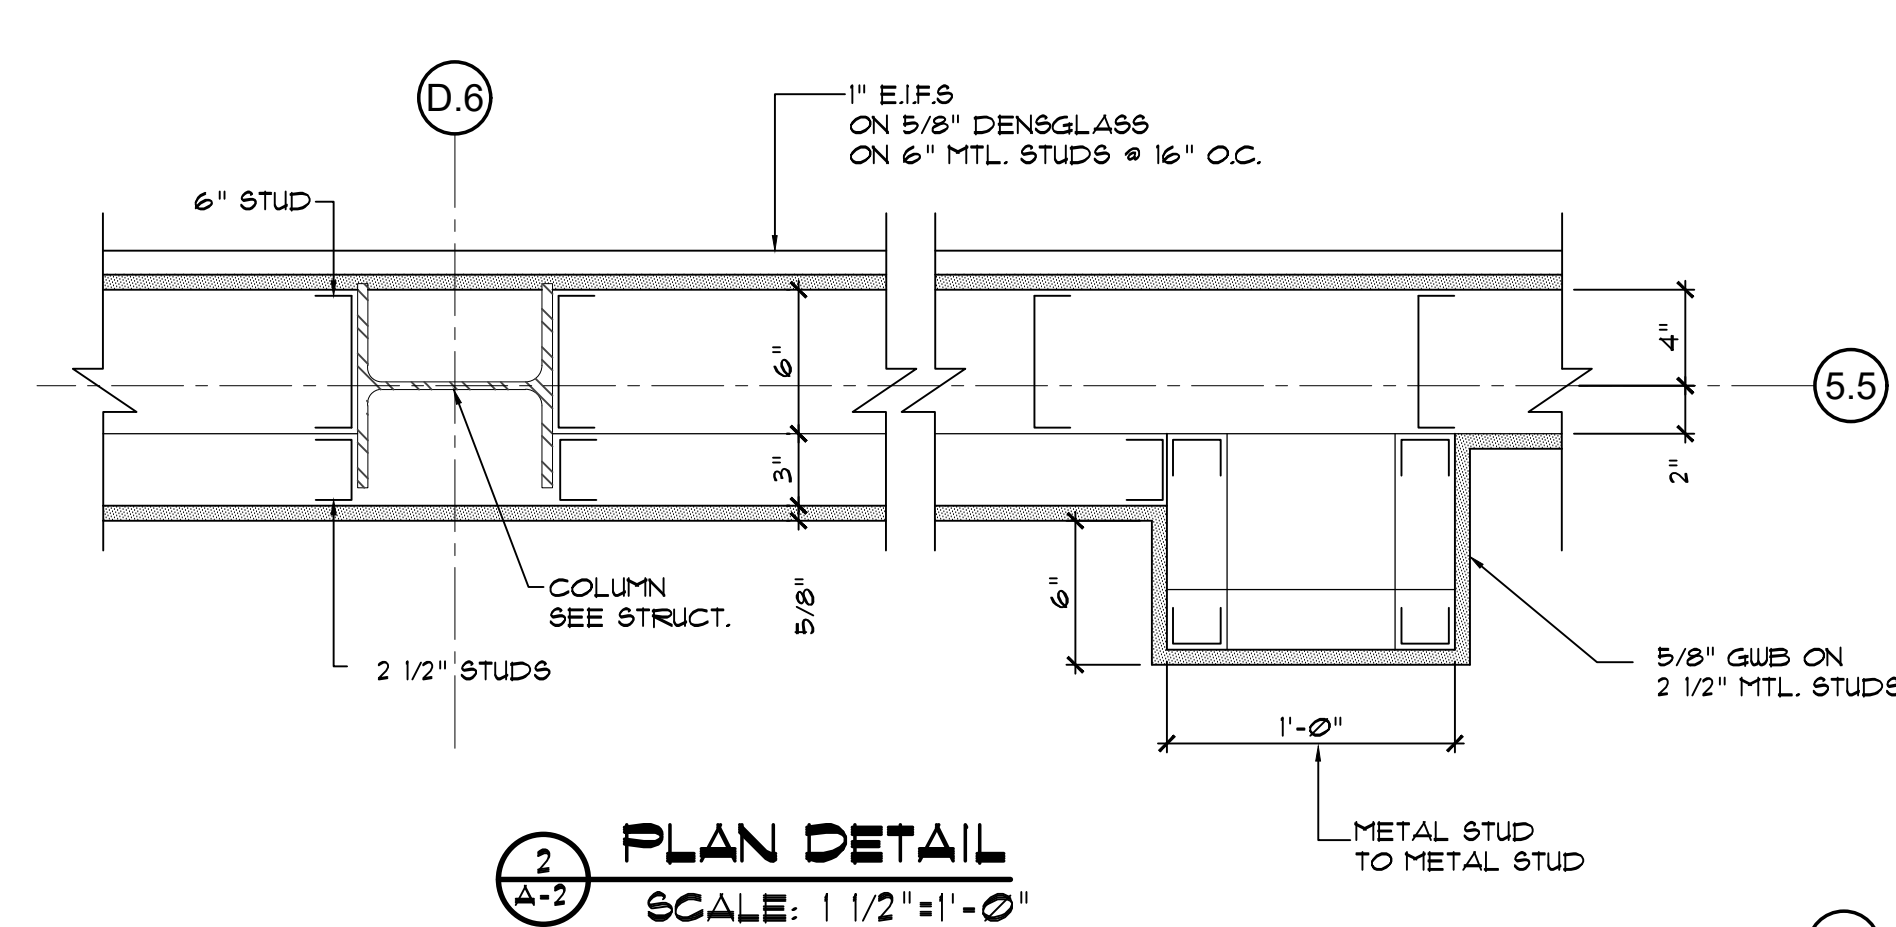


- LEGEND
- SAT 1 ARMSTRONG, LYRA PB, 24"x24"x3/8"
- SAT 2 ARMSTRONG, CIRrus - SQUARE EDGE, 24"x24"
- SAT 3 ARMSTRONG, CERAMAGUARD FINE FIGURED, 24"x24"


1 A-2 FIRST FLOOR REFLECTED CEILING PLAN
SCALE: 1/8"=1'-0"

1144 SF

THESE DRAWING AND SPECIFICATIONS REPRESENT AN INSTRUMENT OF SERVICE AND AS SUCH SHALL REMAIN IN OWNERSHIP WITH THE ARCHITECT. USE OR REPRODUCTION BY ANY MEANS, IN WHOLE OR IN PART, WITHOUT THE ARCHITECT'S WRITTEN CONSENT, IS PROHIBITED.

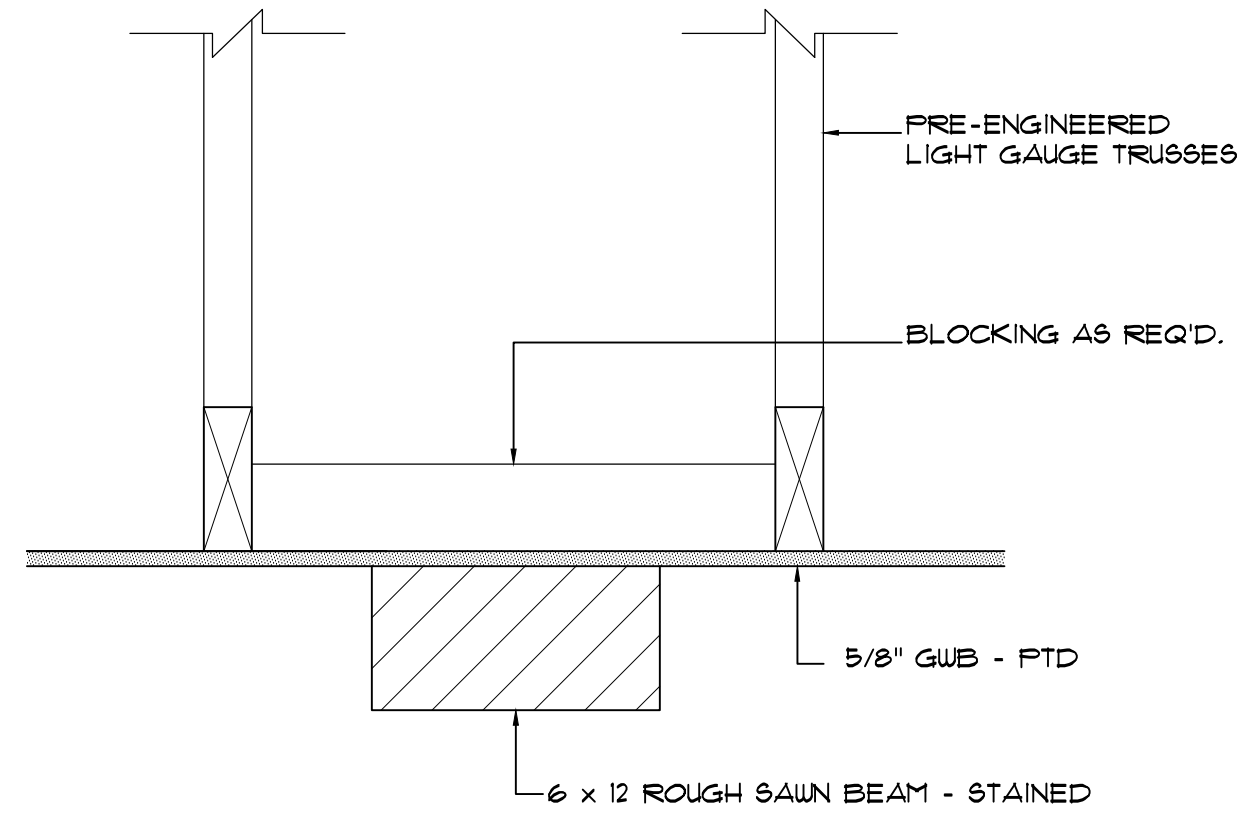

2
A-2.2
DETAIL
SCALE: 1 1/2" = 1'-0"

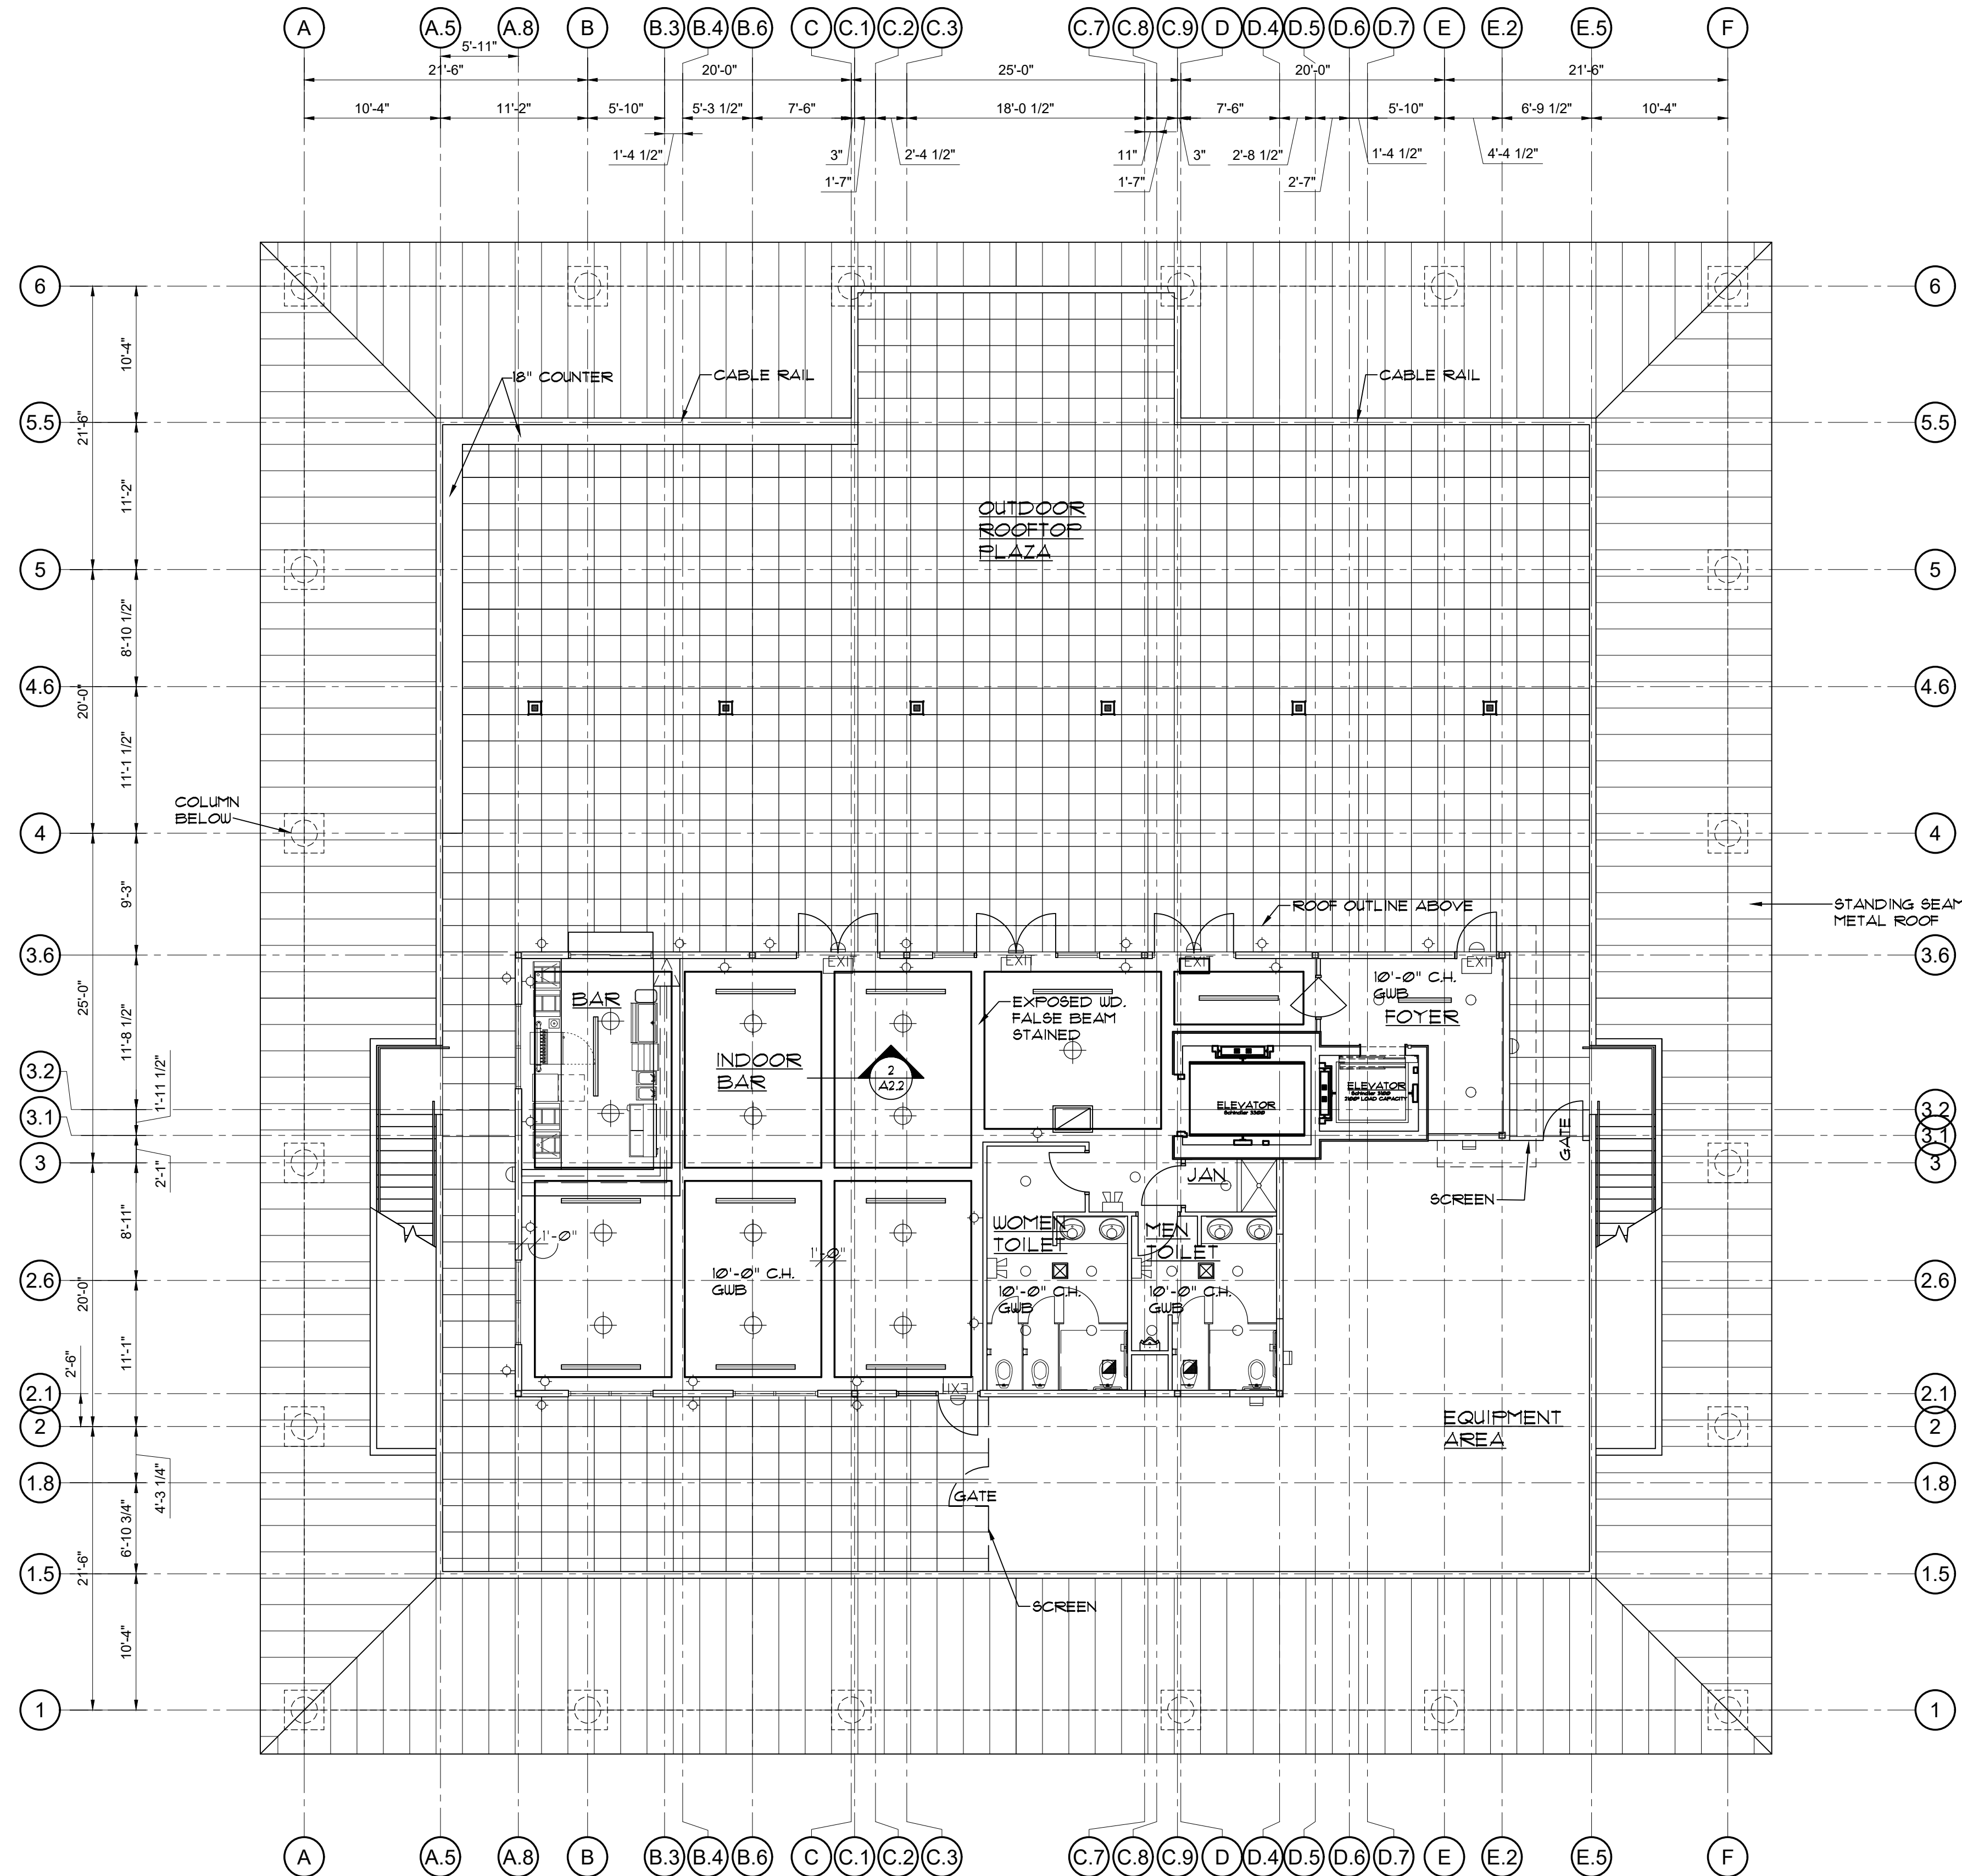

1
A-2.2
ROOF TOP FLOOR REFLECTED CEILING PLAN
SCALE: 1/8" = 1'-0"



- Architectural Design
- Planning
- Interiors





Member of the American Institute of Architects

Lee D. Dixon, Jr., AIA
252-247-2127
lee@coastalarchitecture.net

4206 Bridges St. Ext.,
Suite C
Morehead City, NC
28557

www.CoastalArchitecture.net

MOREHEAD CITY COUNTRY CLUB
CLUBHOUSE
MOREHEAD CITY, NORTH CAROLINA

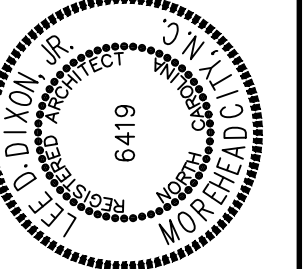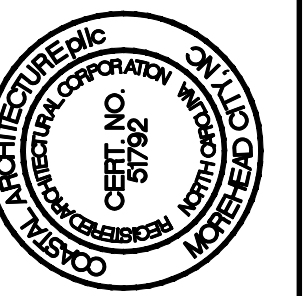

ROOF TOP
FLOOR REFLECTED
CEILING PLAN

20010

ISSUED: 01/29/21

DWG BY: MES



CKD BY: LDD

REVISIONS

SHEET NO.

A-2.2
OF

MOREHEAD CITY COUNTRY CLUB
CLUBHOUSE
MOREHEAD CITY, NORTH CAROLINA

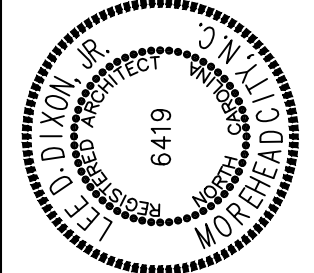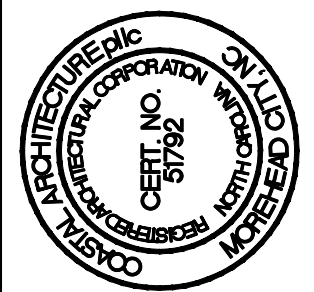

EXTERIOR ELEVATIONS

20010

ISSUED: 01/29/21

DWG BY: BLS/MES


CKD BY: LDD

REVISIONS


SHEET NO.

A-4

OF

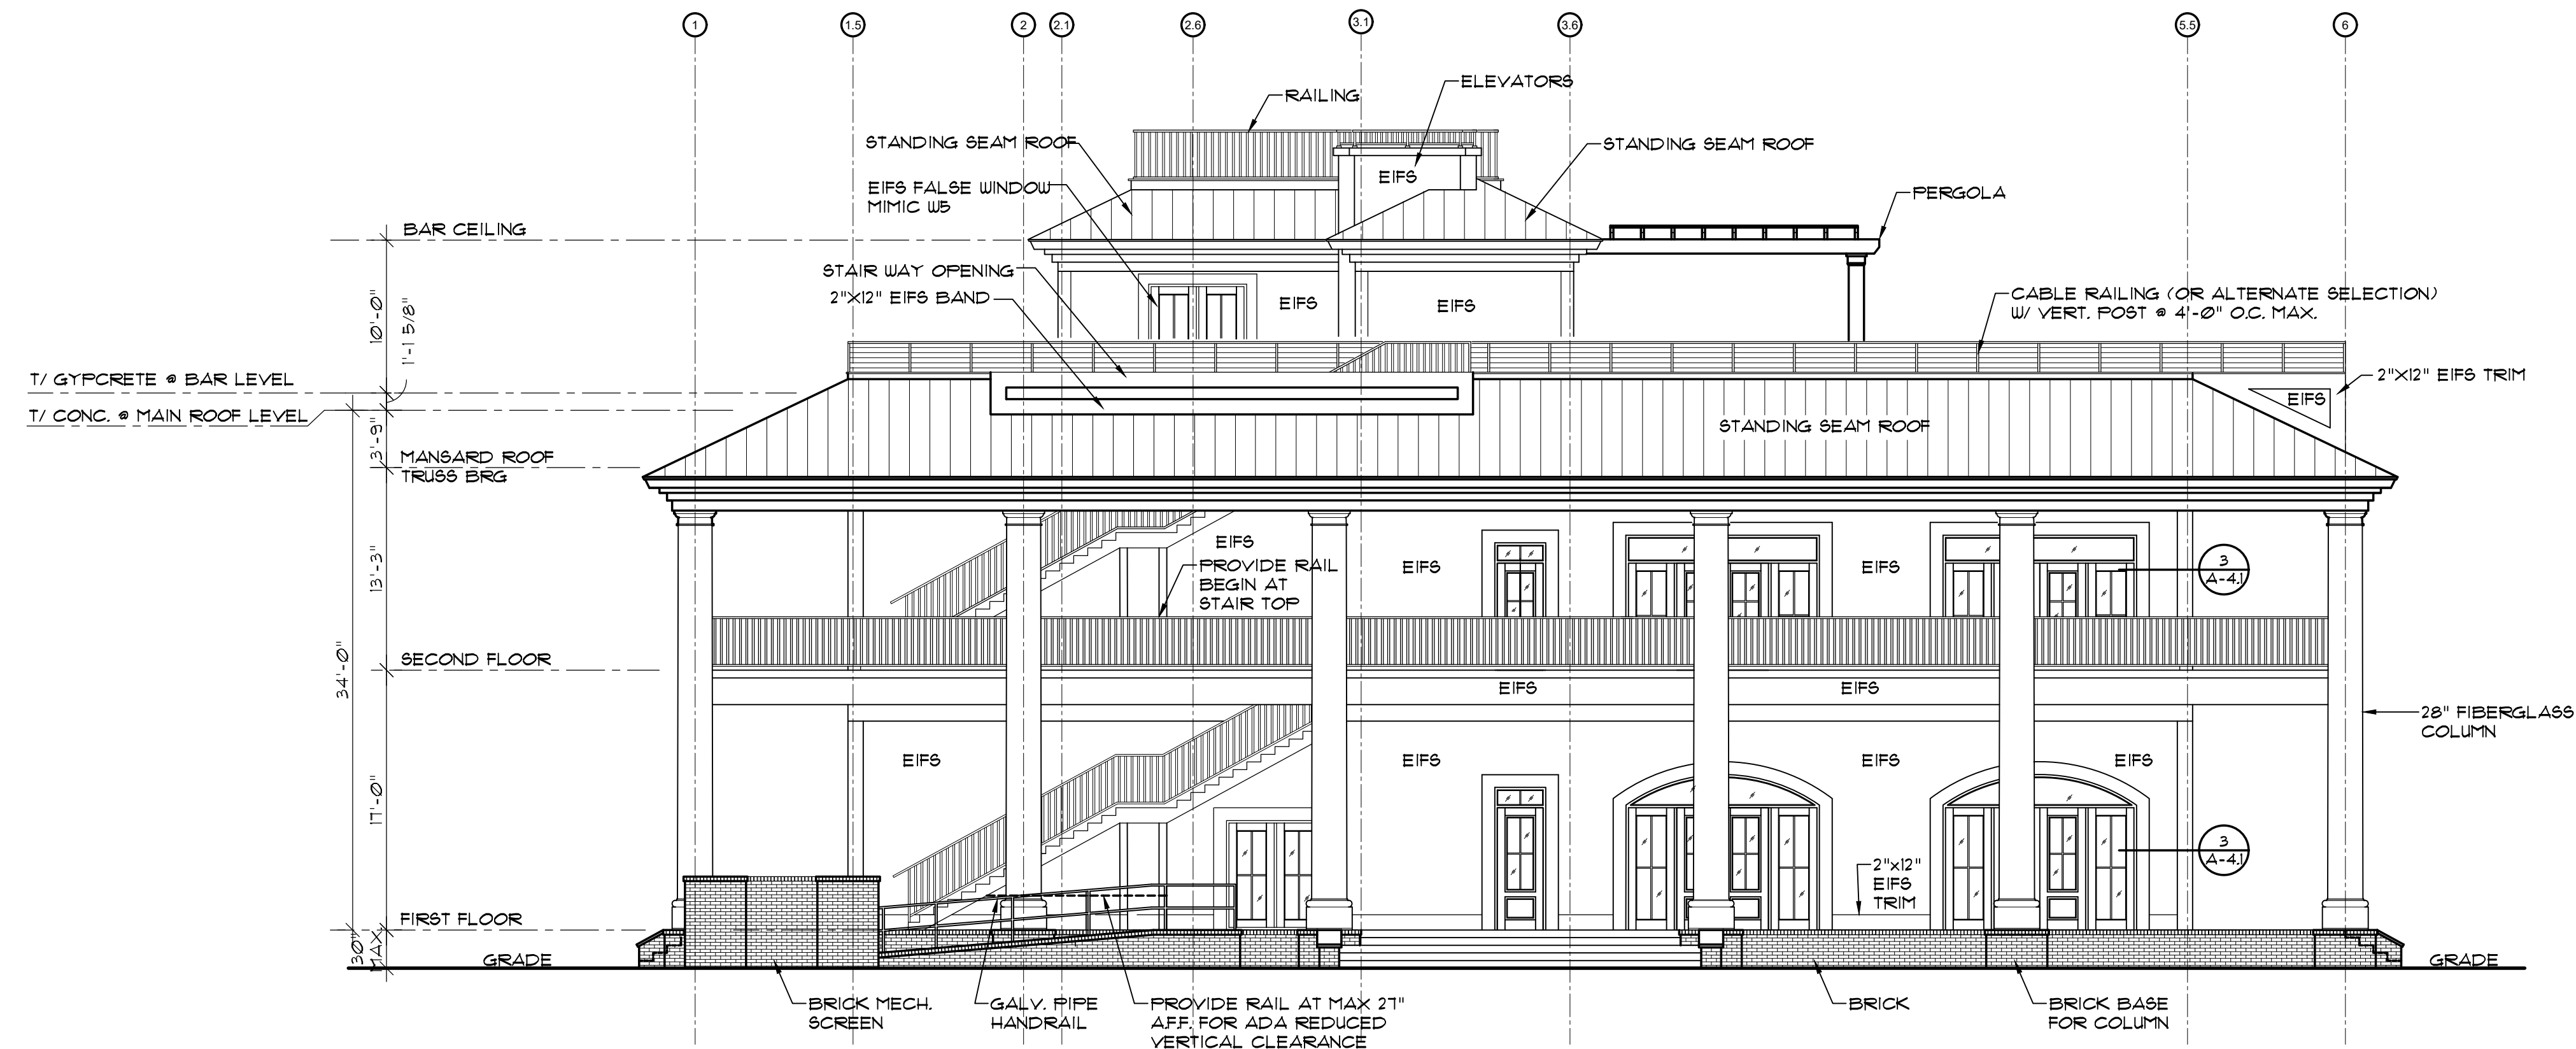

2 RIGHT SIDE ELEVATION
A-4 SCALE: 1/8"=1'-0"


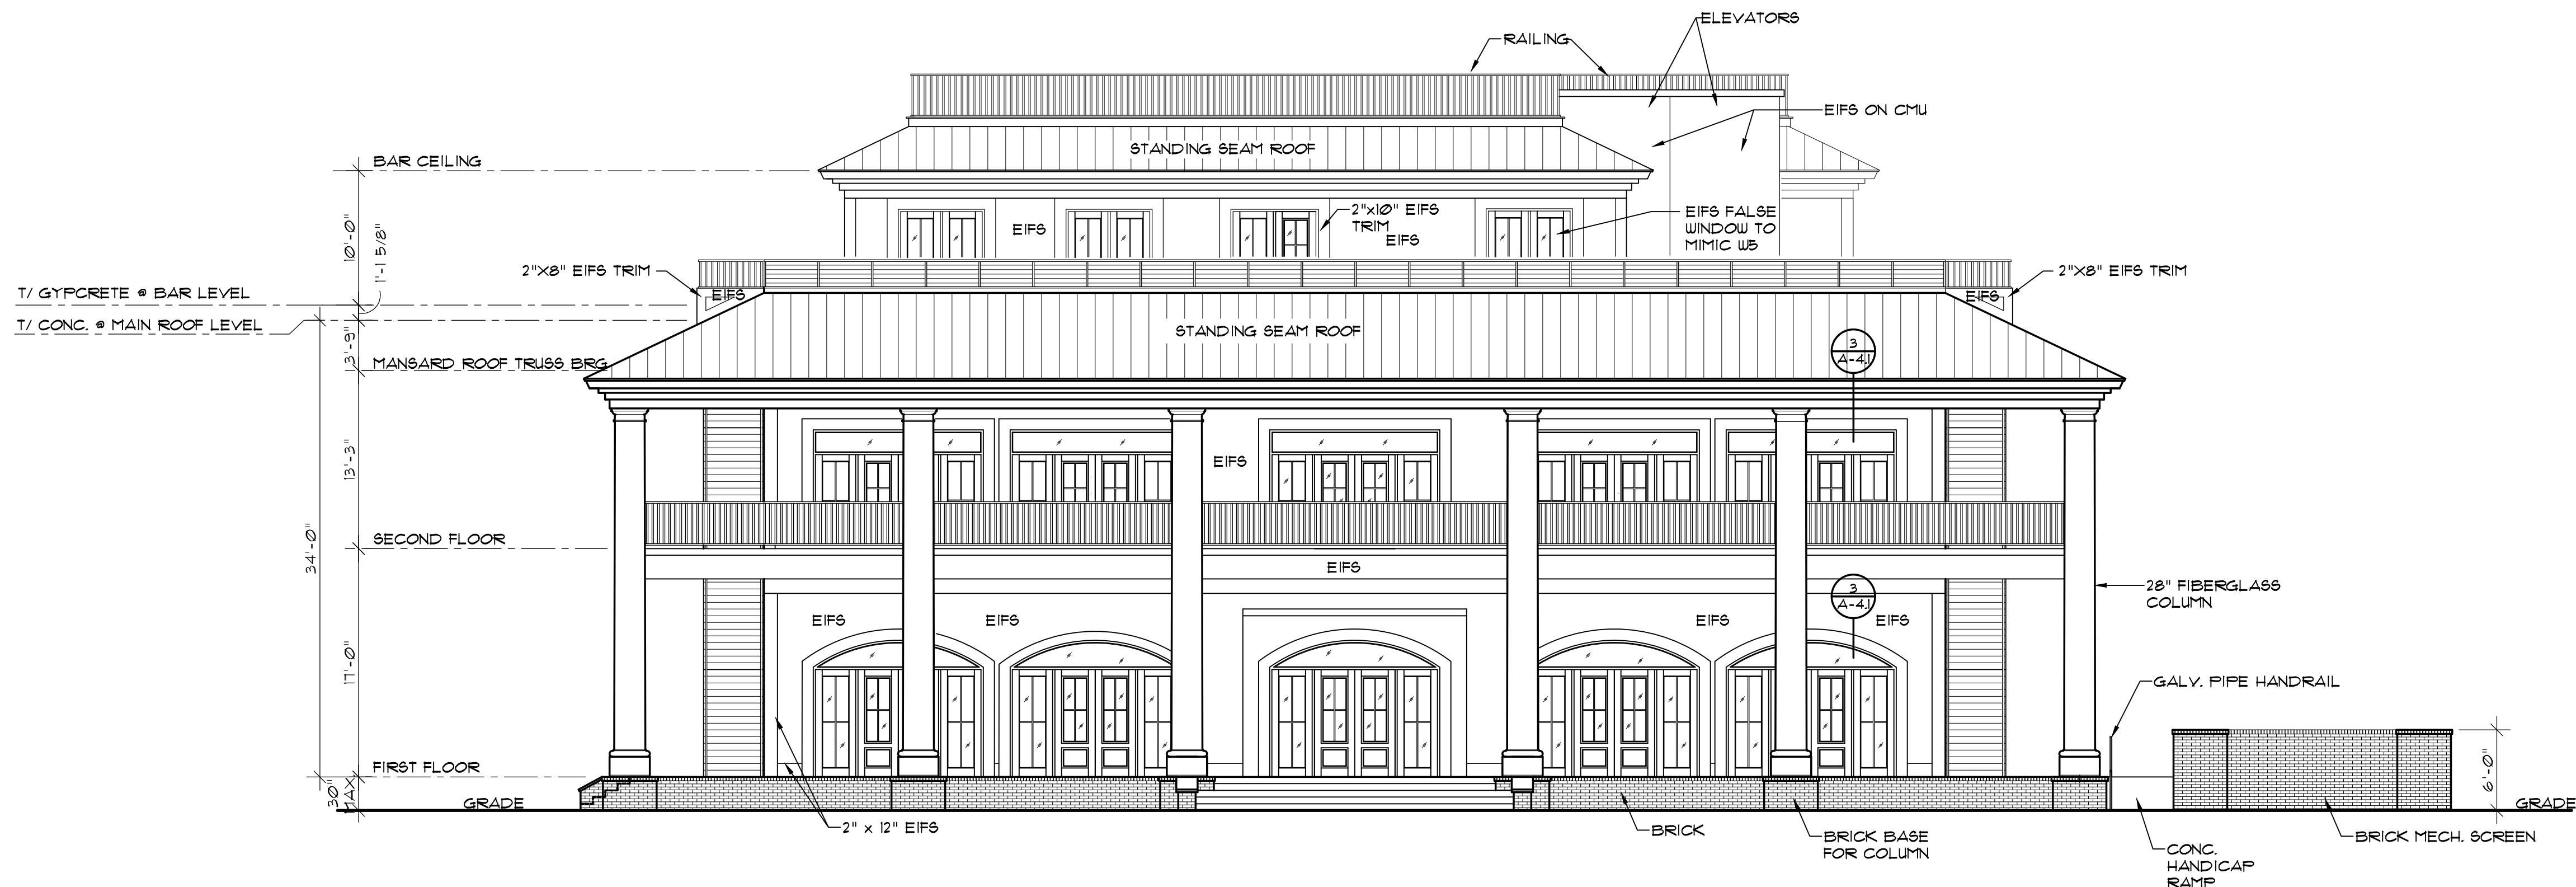


1 FRONT ELEVATION
A-4 SCALE: 1/8"=1'-0"

THESE DRAWING AND SPECIFICATIONS REPRESENT AN INSTRUMENT OF SERVICE AND AS SUCH SHALL REMAIN IN OWNERSHIP WITH THE ARCHITECT. USE OR REPRODUCTION BY ANY MEANS, IN WHOLE OR IN PART, WITHOUT THE ARCHITECT'S WRITTEN CONSENT, IS PROHIBITED.

THESE DRAWING AND SPECIFICATIONS REPRESENT AN INSTRUMENT OF SERVICE AND AS SUCH SHALL REMAIN IN OWNERSHIP WITH THE ARCHITECT. USE OR REPRODUCTION BY ANY MEANS, IN WHOLE OR IN PART, WITHOUT THE ARCHITECT'S WRITTEN CONSENT, IS PROHIBITED.

MOREHEAD CITY COUNTRY CLUB
CLUBHOUSE
MOREHEAD CITY, NORTH CAROLINA

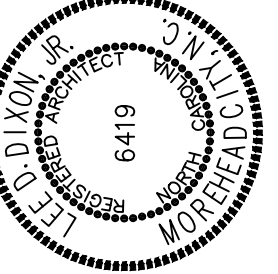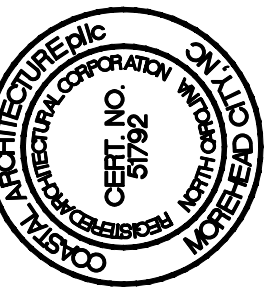

BUILDING SECTION

20010

ISSUED: 01/29/21


DWG BY: BLS

CKD BY: LDD

REVISIONS


SHEET NO.

A-5.1
OF

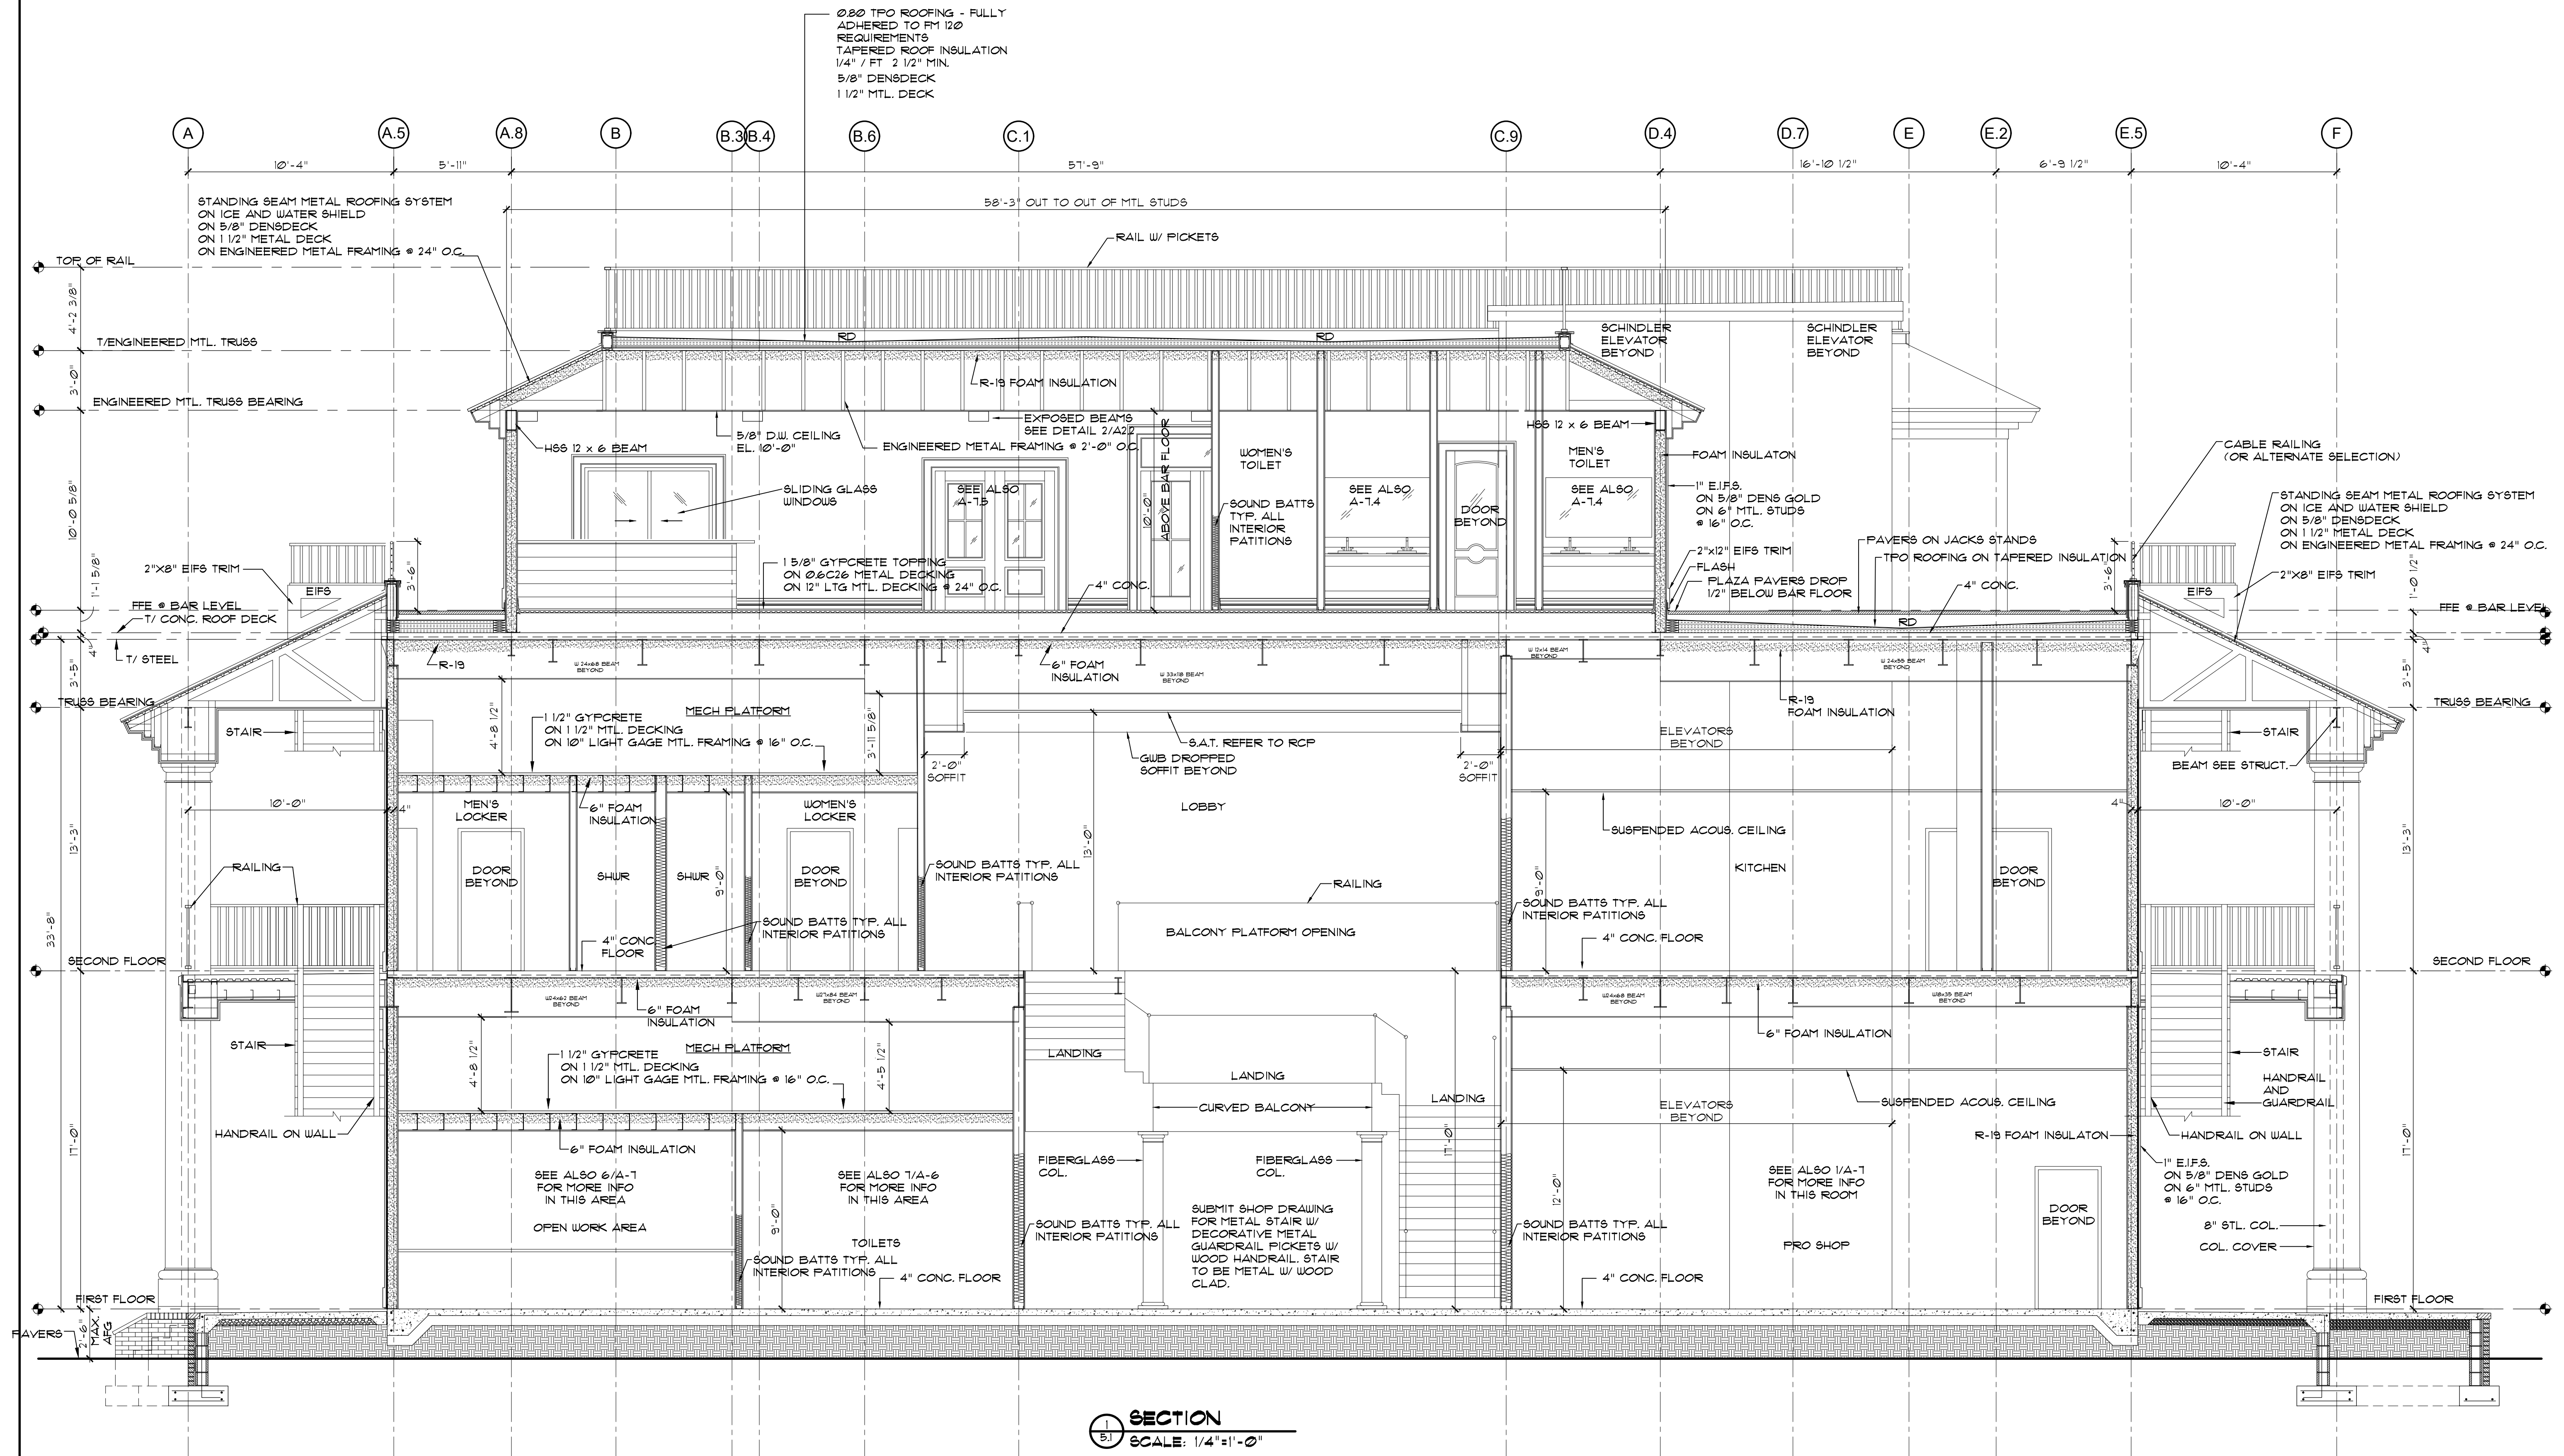

SECTION
SCALE: 1/4"=1'-0"

MOREHEAD CITY COUNTRY CLUB
CLUBHOUSE
MOREHEAD CITY, NORTH CAROLINA

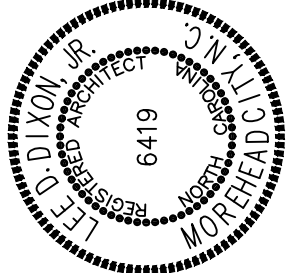

BUILDING SECTION

20010

ISSUED: 01/29/21


DWG BY: BLS

CKD BY: LDD

REVISIONS



SHEET NO.

A-5.2
OF

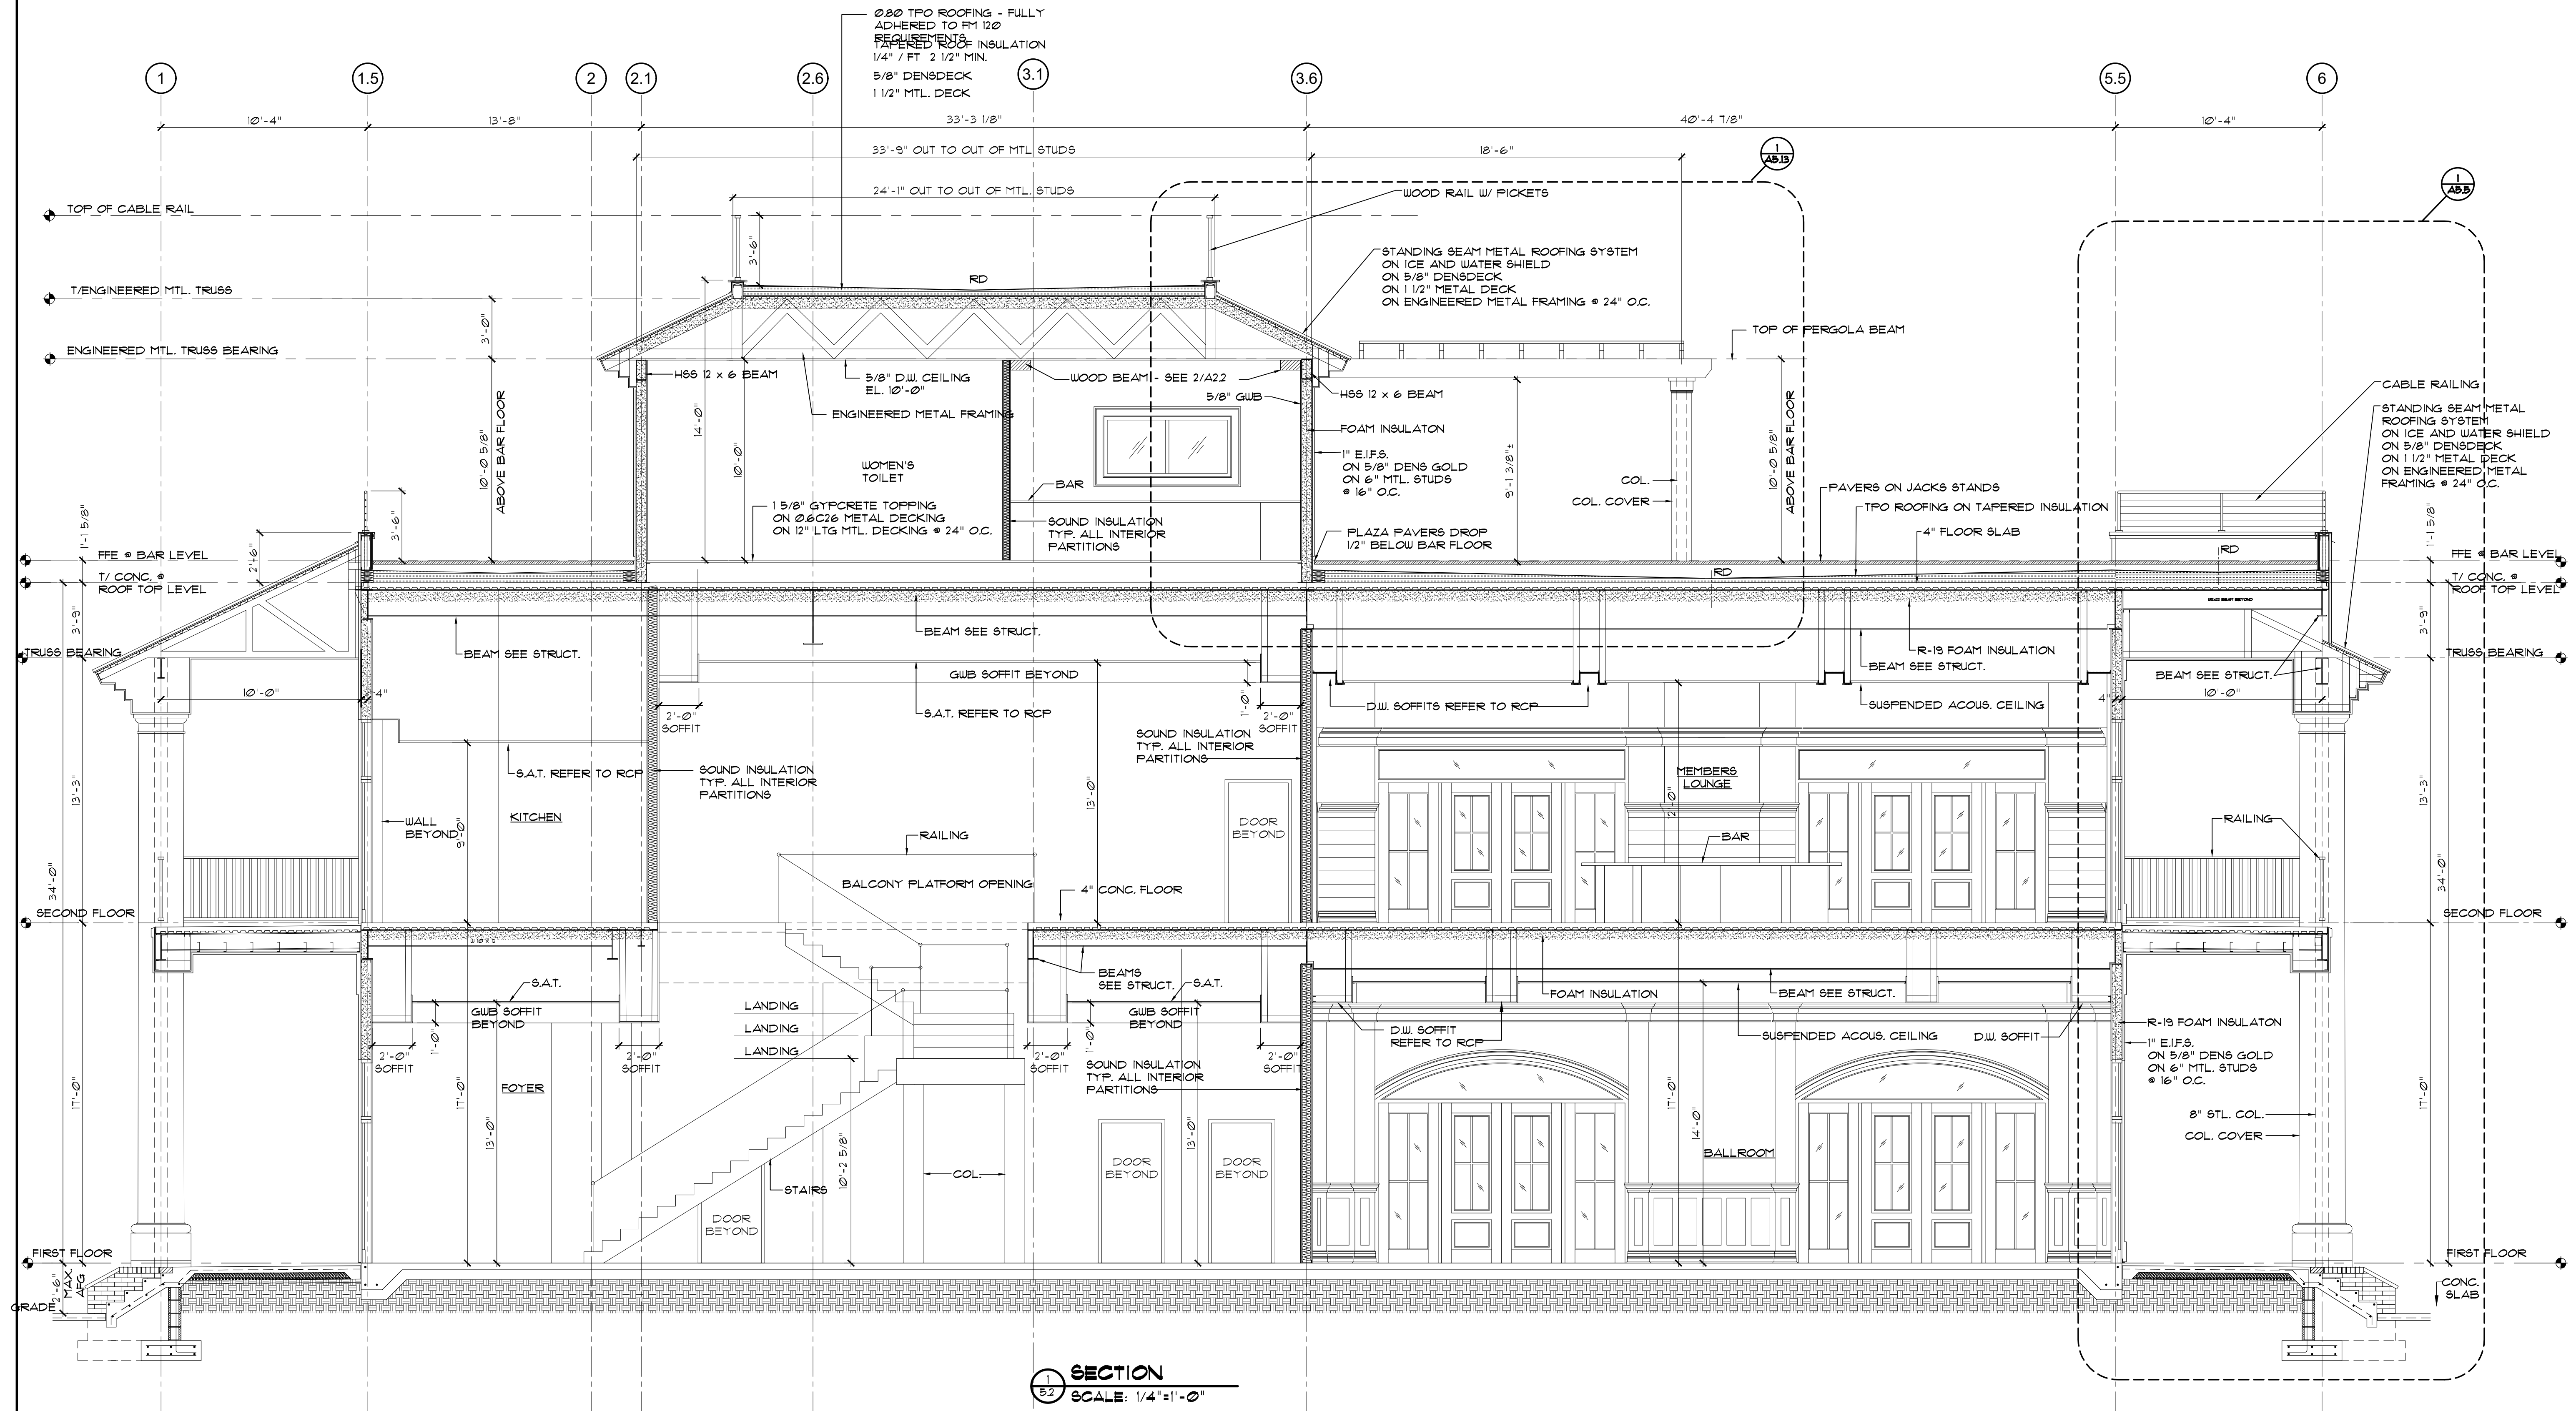

SECTION
SCALE: 1/4"=1'-0"

MOREHEAD CITY COUNTRY CLUB
CLUBHOUSE
MOREHEAD CITY, NORTH CAROLINA

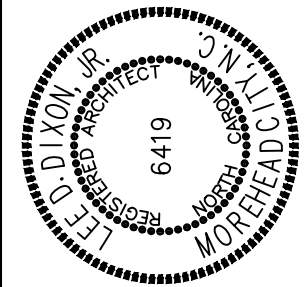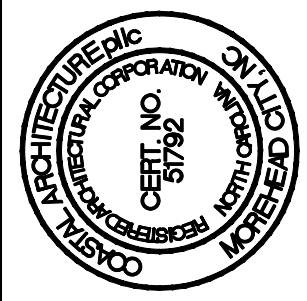

BUILDING SECTION

20010

ISSUED: 01/29/21

DWG BY: BLS


CKD BY: LDD

REVISIONS

SHEET NO.

A-5.10

OF

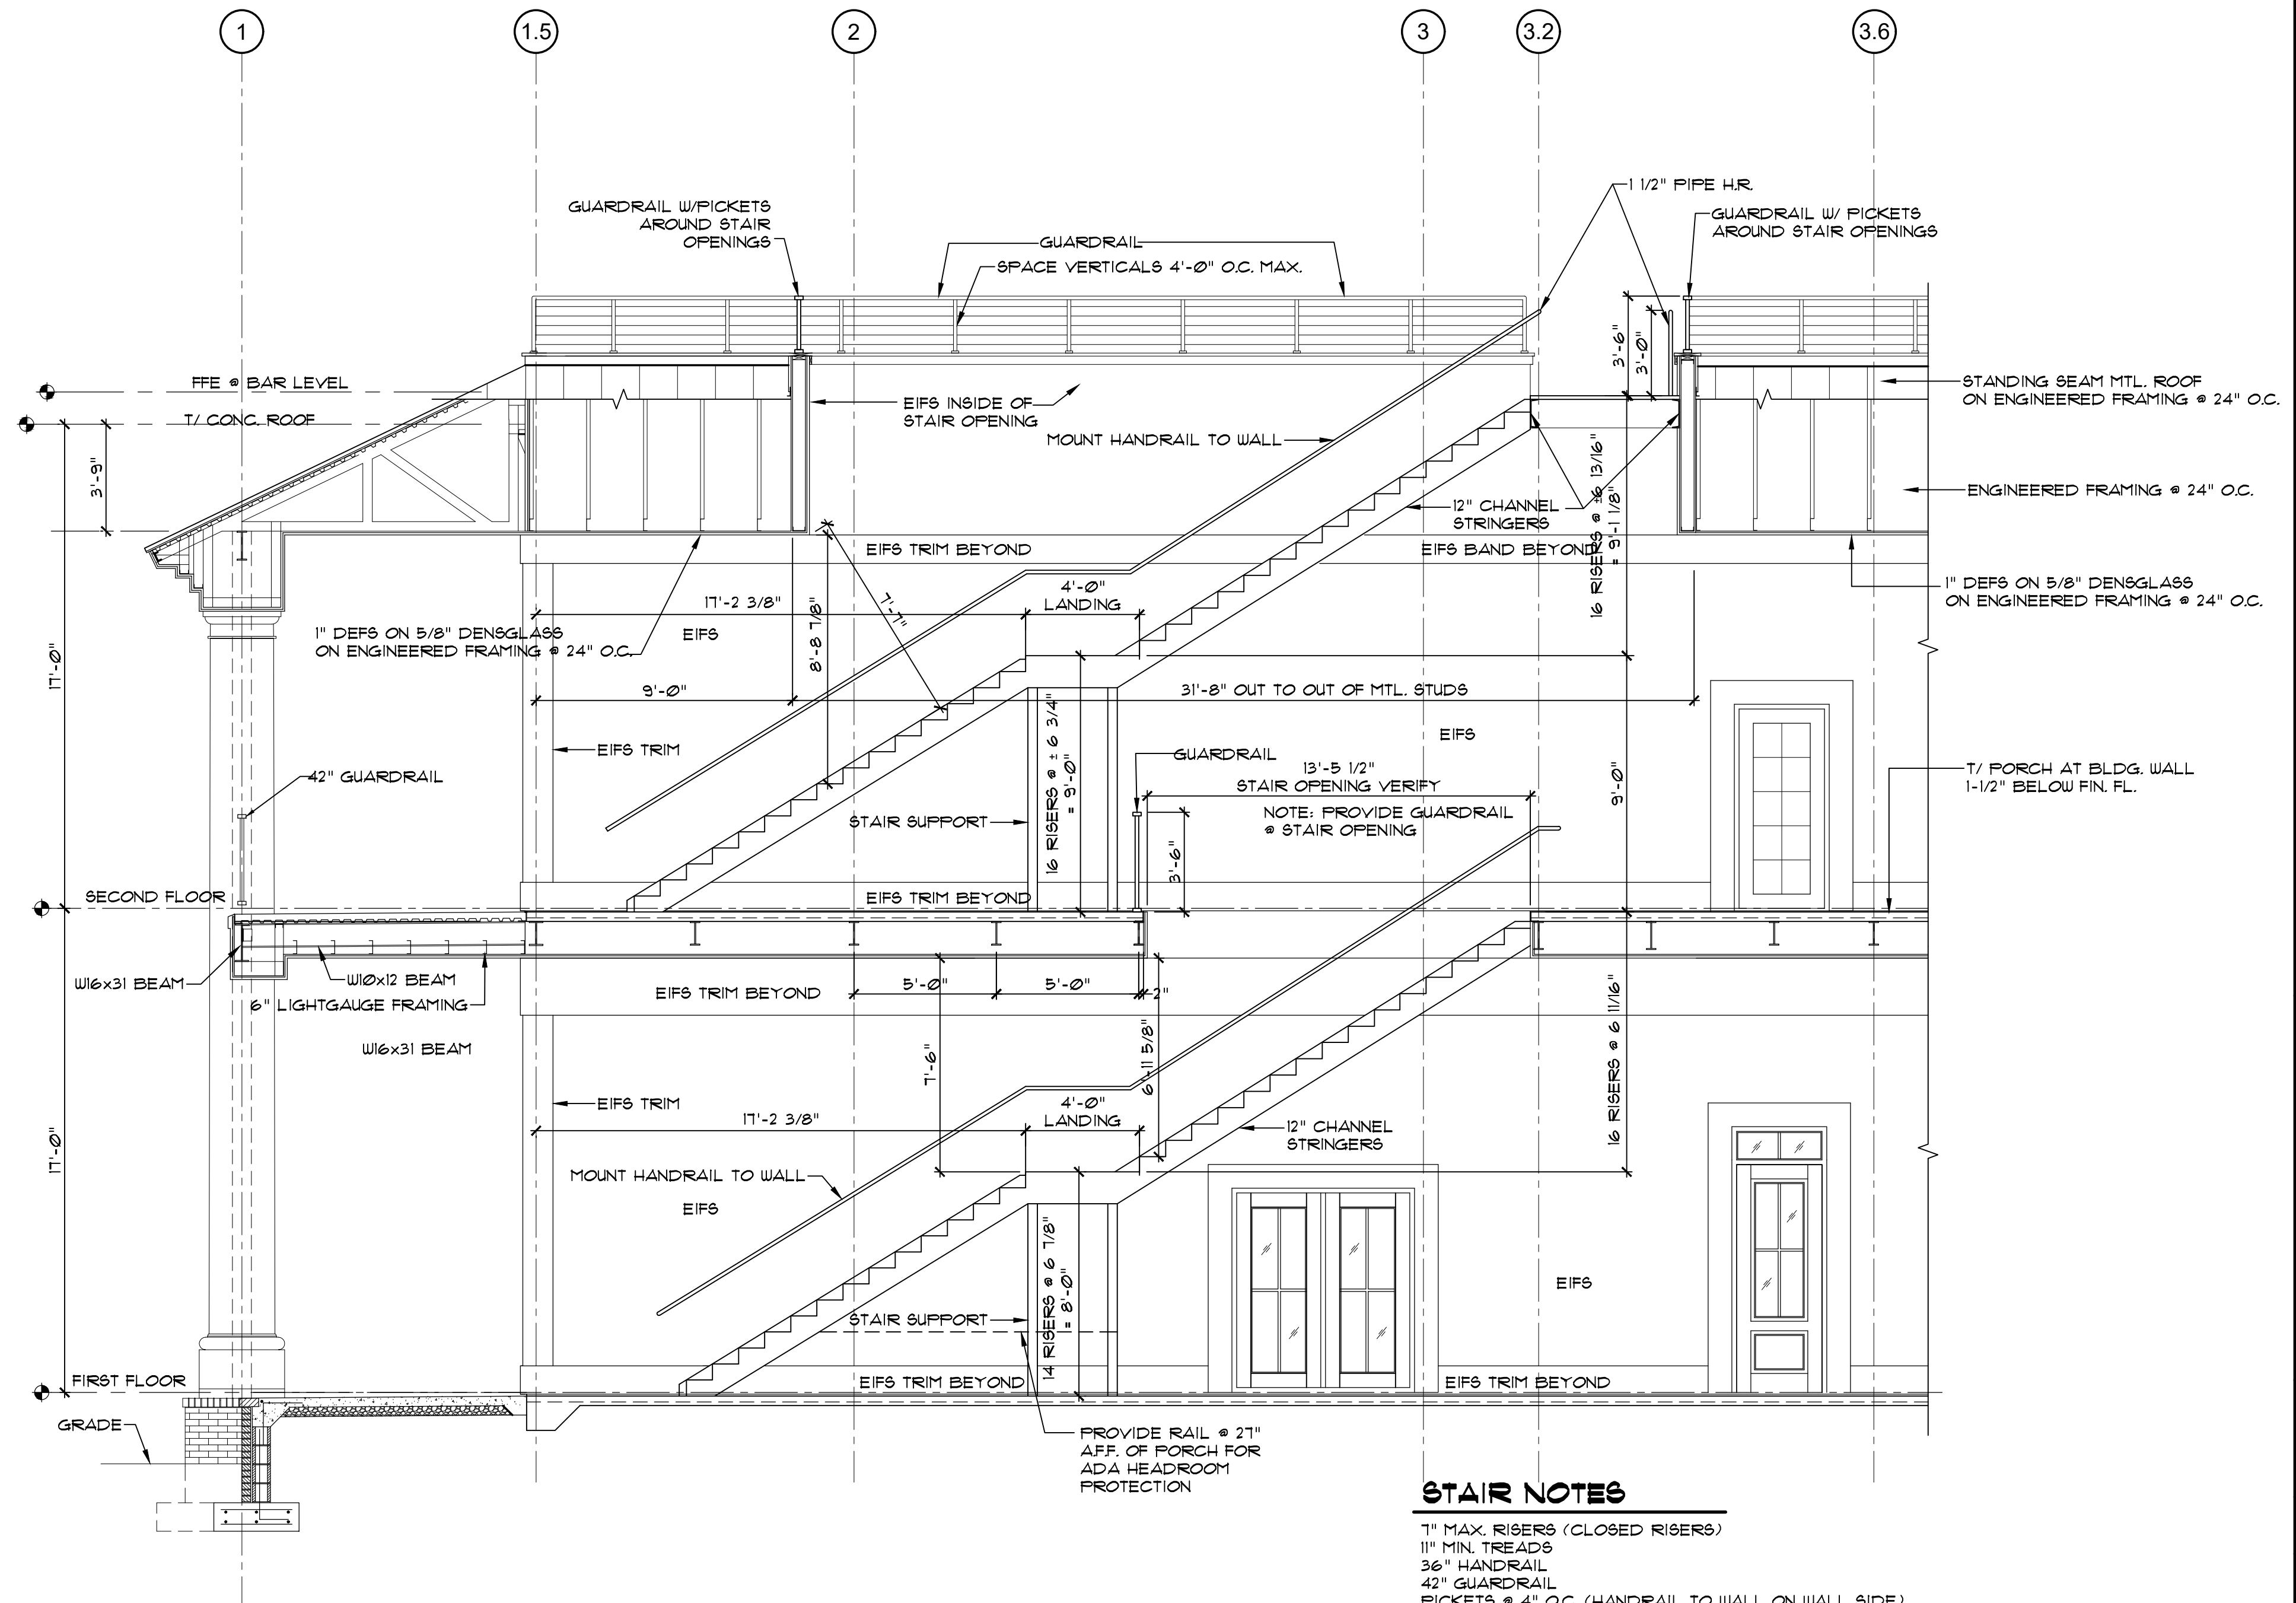


SCHEMATIC SECTION
SCALE: 1/4"=1'-0"

STAIR NOTES

- 1" MAX. RISERS (CLOSED RISERS)
11" MIN. TREADS
36" HANDRAIL
42" GUARDRAIL
PICKETS @ 4" O.C. (HANDRAIL TO WALL ON WALL SIDE)
NOTE: THIS SCHEMATIC STAIR SECTION IS TO BE CONSIDERED DIAGRAMMATIC ONLY
CONTRACTOR TO PRICE THE FOLLOWING OPTIONS
FOR THE EXTERIOR STAIR - PROVIDE SHOP DRAWINGS FOR FINAL APPROVAL
STEEL - GALV.
STEEL - EPOXY COATED
STEEL PAN - GALV. W/ CONCRETE TREADS
ALUMINUM
CONC. STAIRS
NON COMB WOOD

MOREHEAD CITY COUNTRY CLUB
CLUBHOUSE
MOREHEAD CITY, NORTH CAROLINA

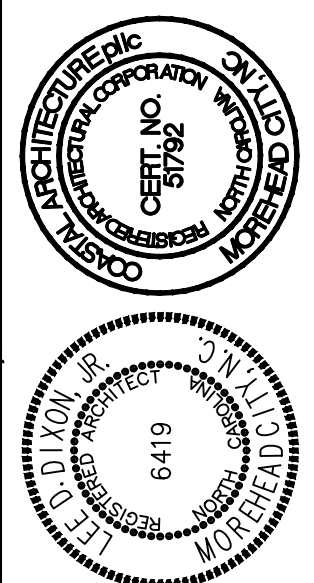

WALL SECTION


20010

ISSUED: 01/29/21
DWG BY: BLS
CKD BY: LDD


REVISIONS

SHEET NO.


A-5.12
OF

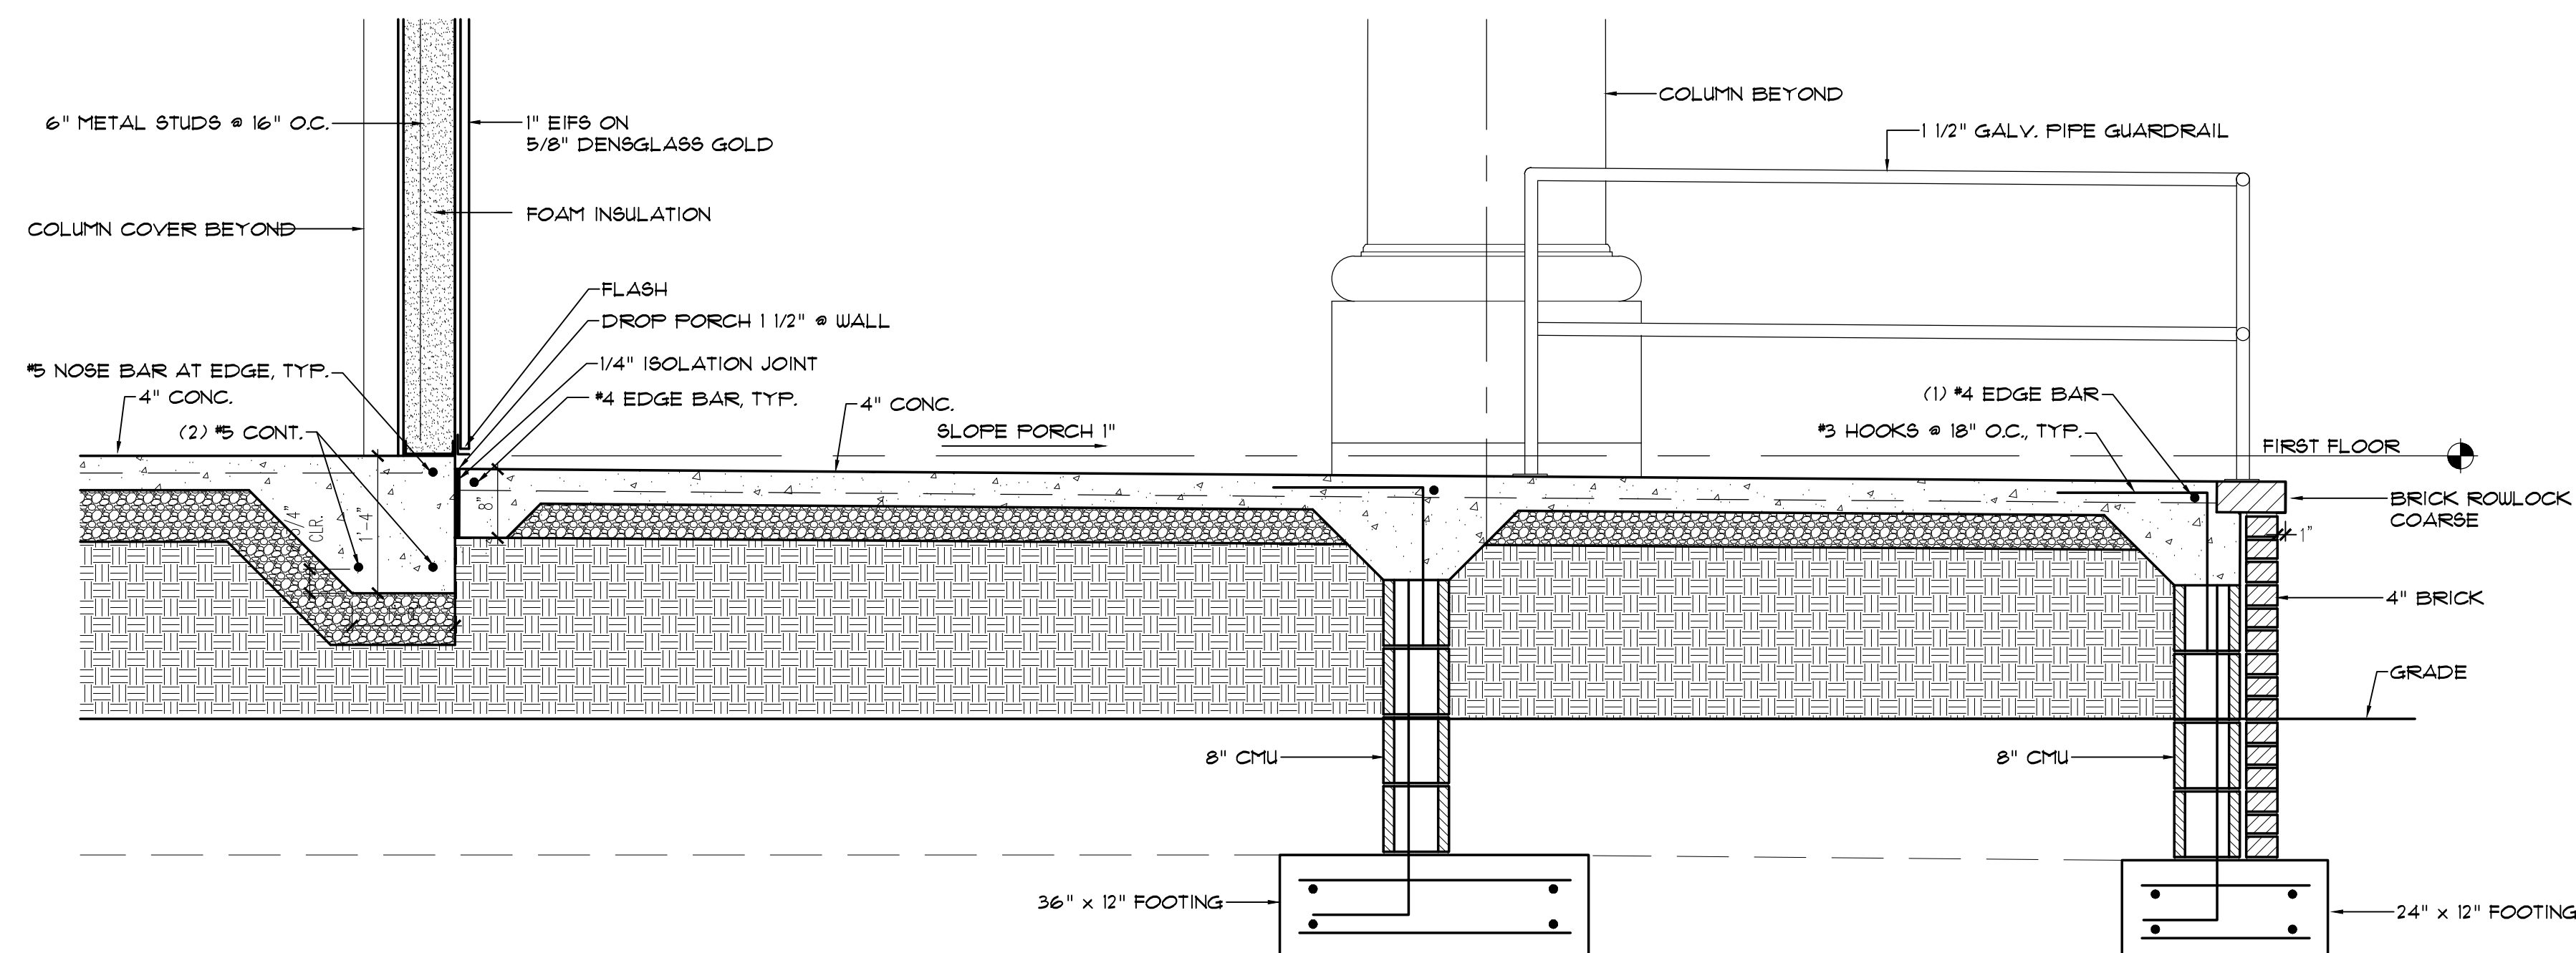


2 SECTION
SCALE: 3/4" = 1'-0"

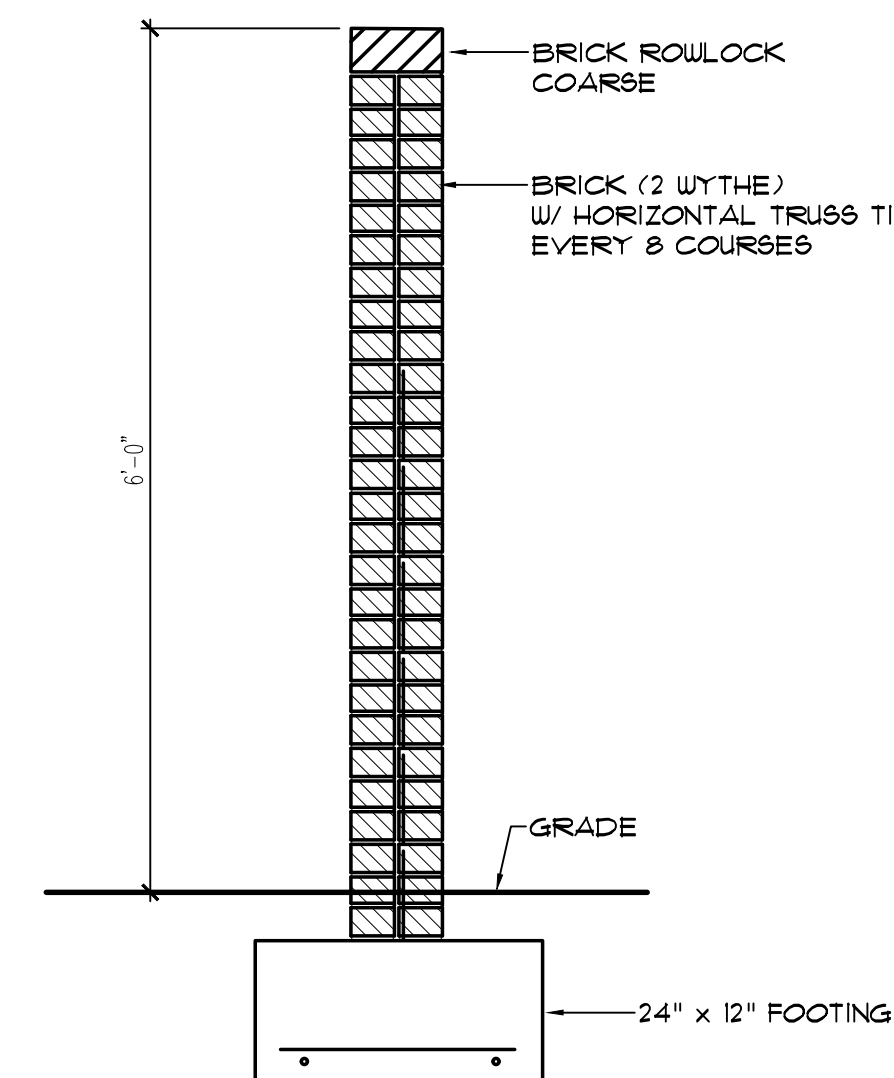

3 SECTION
SCALE: 3/4" = 1'-0"


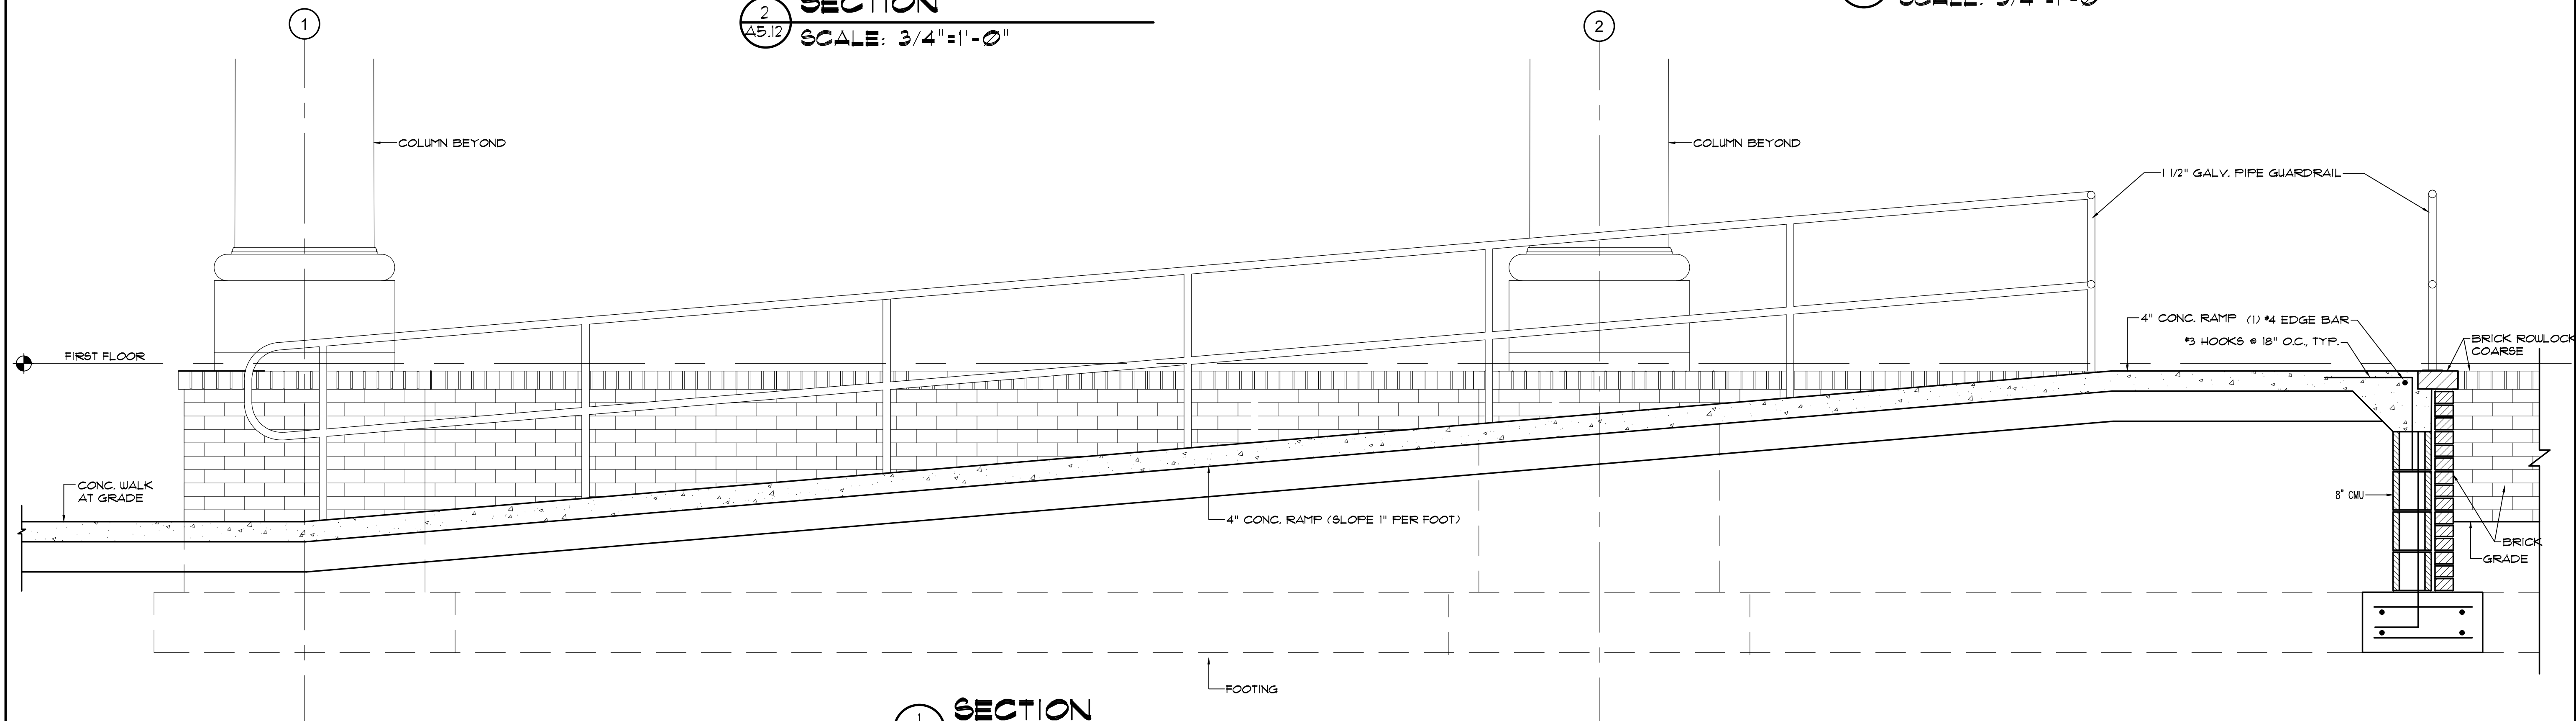


1 SECTION
SCALE: 3/4" = 1'-0"

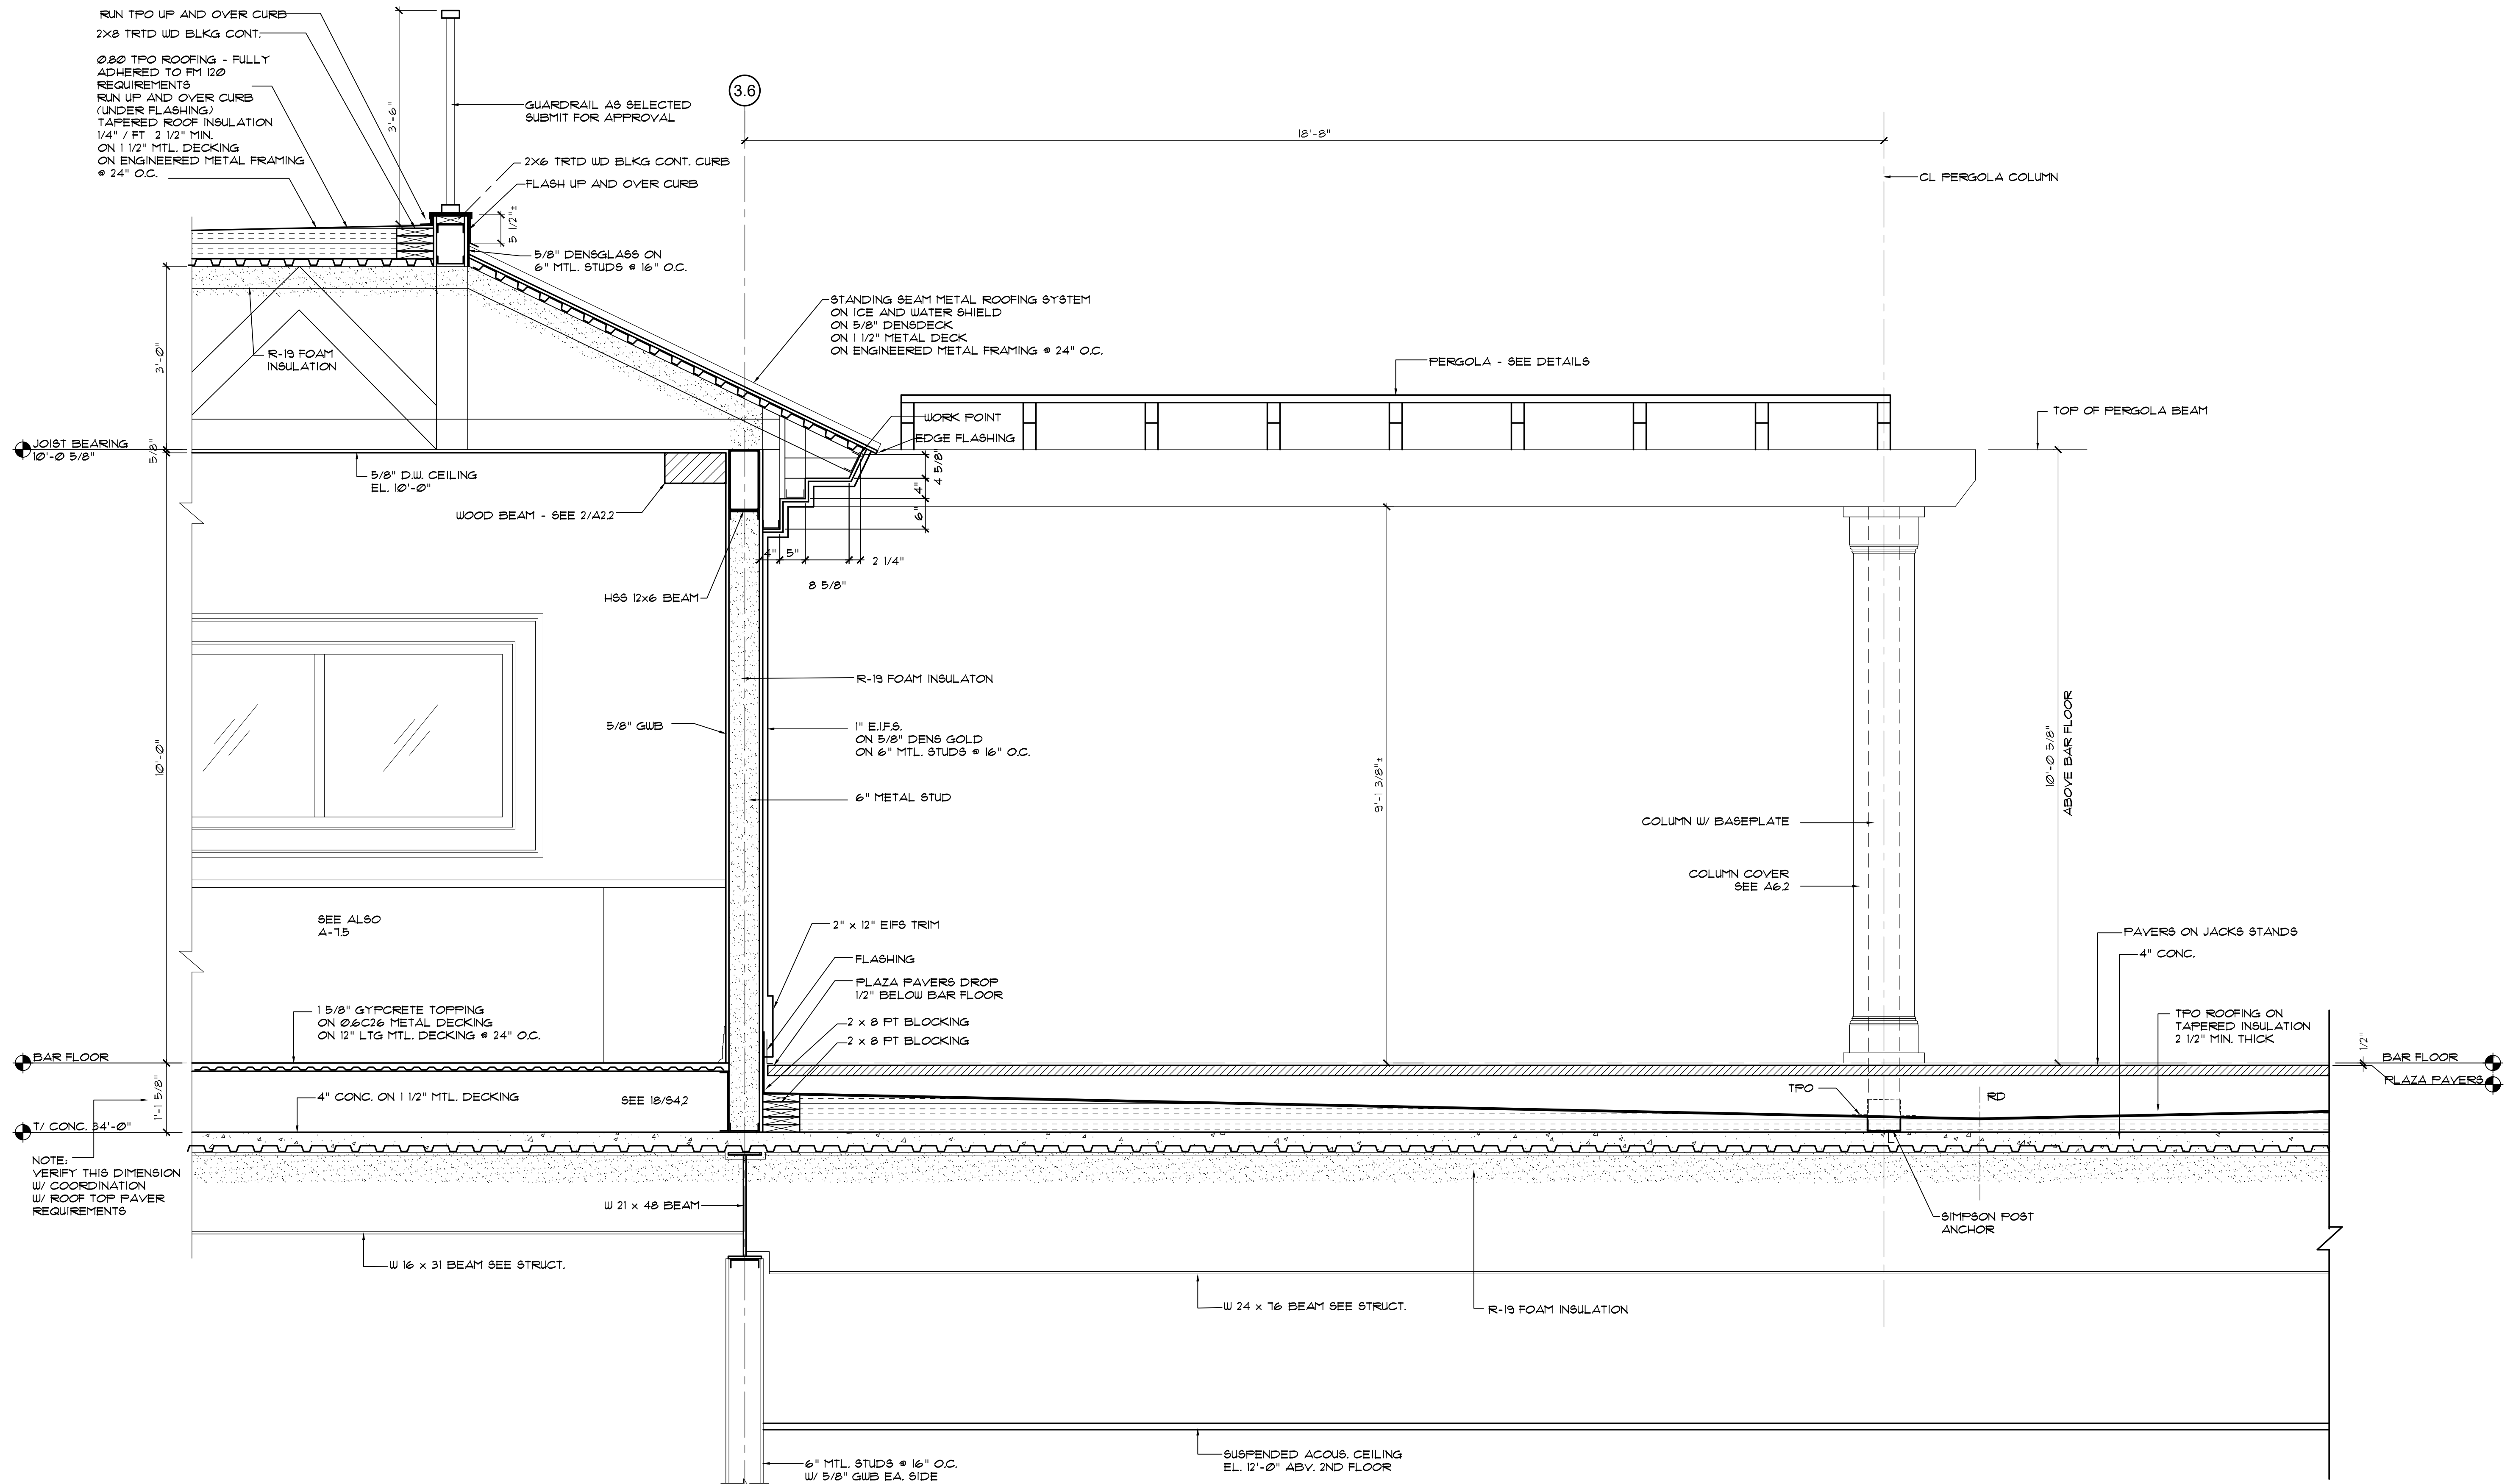

SECTION
SCALE: 3/4" = 1'-0"

MOREHEAD CITY COUNTRY CLUB
CLUBHOUSE
MOREHEAD CITY, NORTH CAROLINA

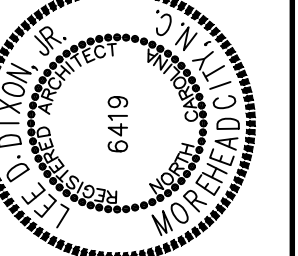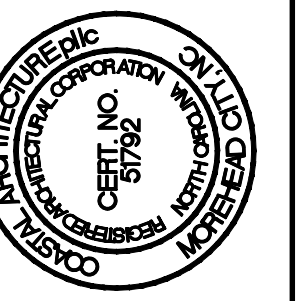

WALL SECTION

20010

ISSUED: 01/29/21

DWG BY: BLS

CKD BY: LDD



REVISIONS

SHEET NO.

A-5.13

OF

MOREHEAD CITY COUNTRY CLUB
CLUBHOUSE
MOREHEAD CITY, NORTH CAROLINA

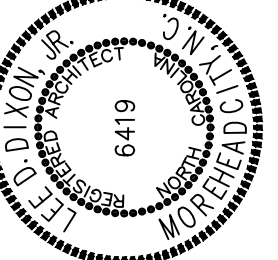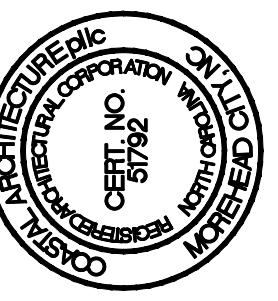

BUILDING SECTION

20010

ISSUED: 01/29/21


DWG BY: BLS

CKD BY: LDD


REVISIONS

SHEET NO.


A-5.14
OF

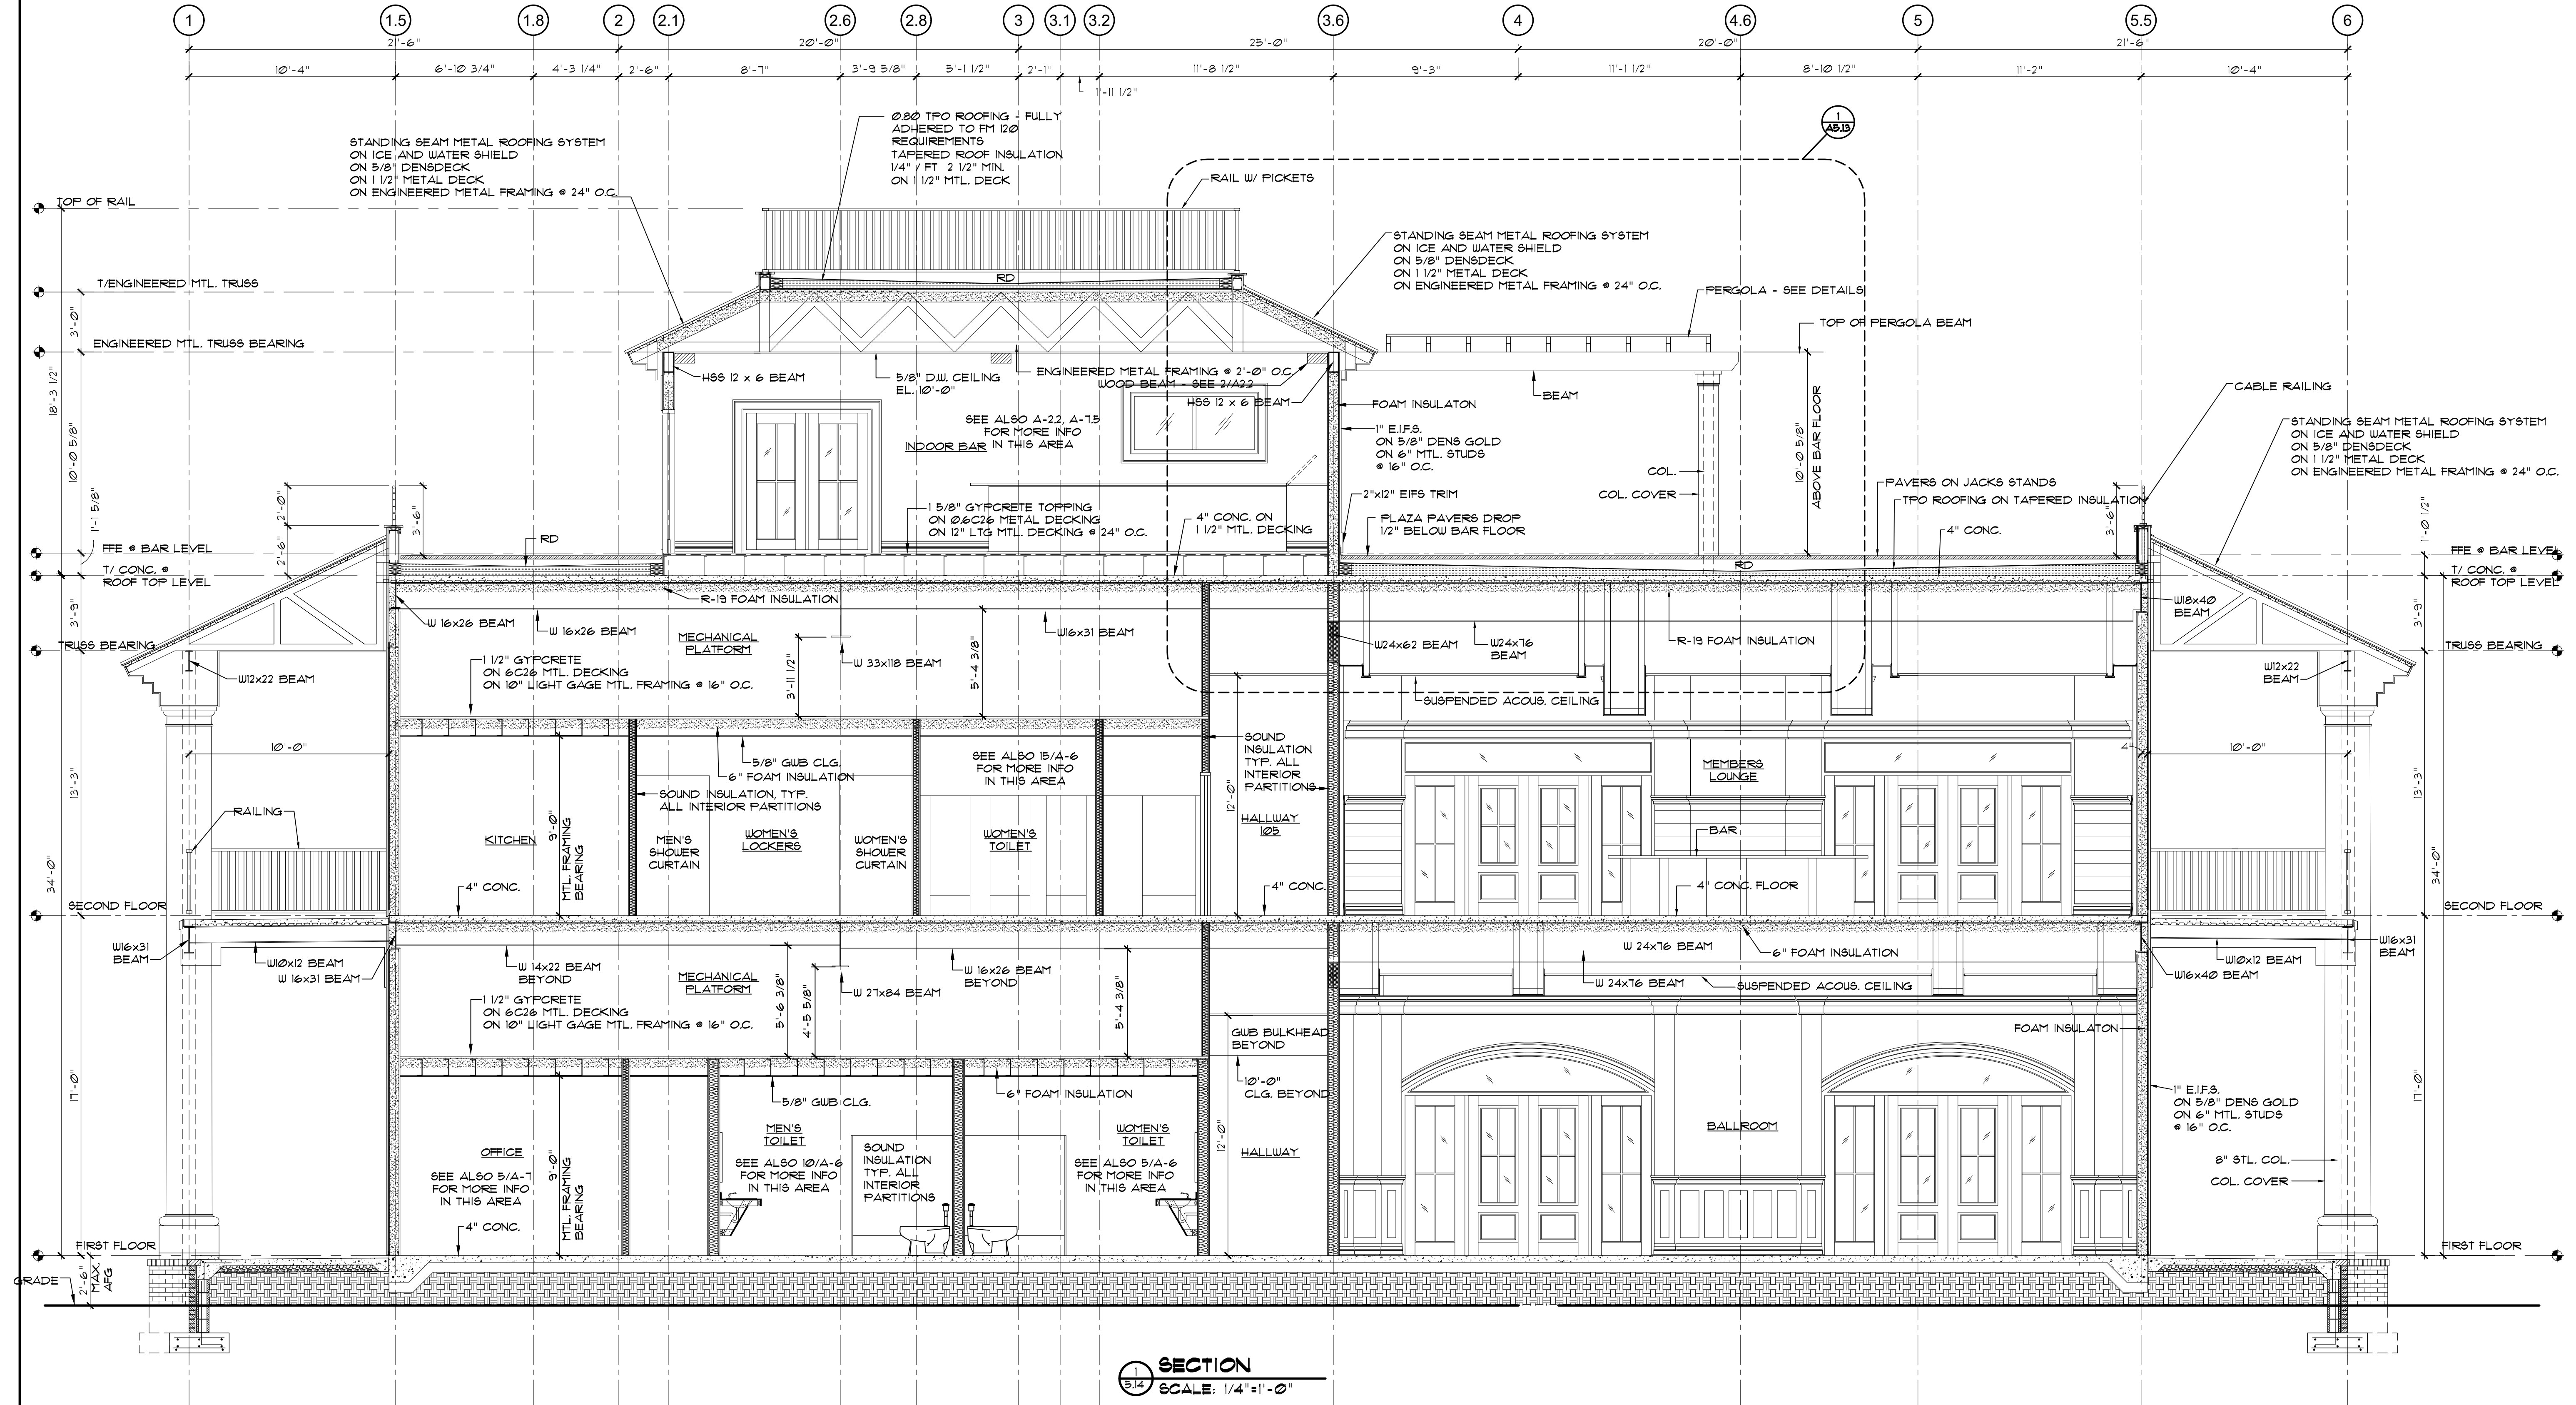


TOILET ACCESSORY SCHEDULE			
Mark	Item	Mtg. Ht.	Remarks
TA-1	FRAMELESS MIRROR 24"W X 60"H		
TA-2	FRAMELESS MIRROR 27"W X 60"H		
TA-3	FRAMELESS MIRROR 64"W X 36"H		
TA-4	FRAMELESS MIRROR 18"W X 30"H		
TA-5	TOILET PAPER HOLDER		TO BE SELECTED BY OWNER
TA-6	PAPER TUL DISP.	4'-0" MAX.	HEIGHT TO DISP. OUTLET OR DISPENSER LEVER
TA-7	HANDICAP SOAP DISPENSER	3'-6"	HEIGHT TO DISPENSER
TA-8	GRAB BAR 42" CONCEALED MOUNTING W/ SNAP FLANGE	3'-0" MAX.	HEIGHT TO CENTER
TA-9	GRAB BAR 36" CONCEALED MOUNTING W/ SNAP FLANGE	3'-0" MAX.	HEIGHT TO CENTER
TA-10	GRAB BAR 18" CONCEALED MOUNTING W/ SNAP FLANGE (VERTICAL)	3'-3"	HEIGHT TO BOTTOM, CENTER OF BAR @ 40" FROM REAR WALL
TA-11	GRAB BAR 24" CONCEALED MOUNTING W/ SNAP FLANGE	3'-0" MAX.	HEIGHT TO CENTER
TA-12	FOLDING SHOWER SEAT B-5181	17"-19"	HEIGHT FROM FLOOR TO TOP OF SEAT
TA-13	GRAB BAR B-6861	33"-36"	HEIGHT FROM FLOOR TO TOP OF GRIPPING SURFACE
NOTES: • MODEL NUMBERS ARE BOBRICK UON, BRADLEY & FRANKLIN ARE APPROVED EQUALS. SUBMIT CUT SHEETS FOR APPROVAL. • SUBMIT SHOP DRAWINGS FOR ALL TOILET PARTITION CONFIGURATIONS • ALL HANDRAILS SHALL BE BLOCKED TO SUPPORT A 250 LB. LOAD MINIMUM			

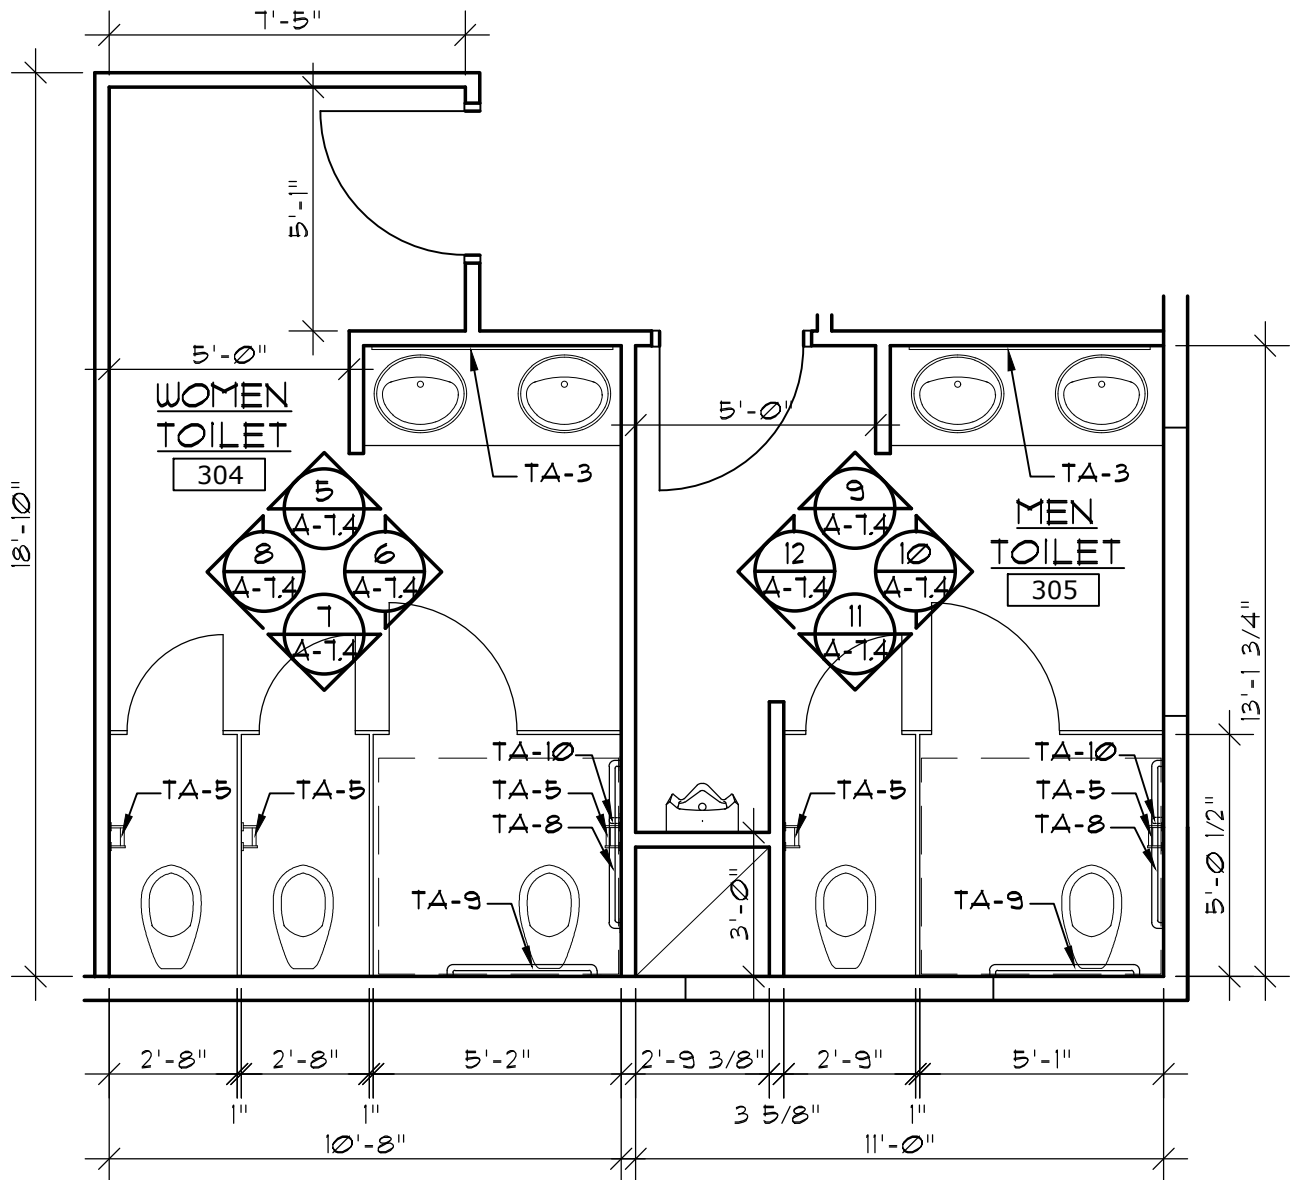


4
A-6
ROOF TOP TOILET
ENLARGED PLAN
SCALE: 1/4"=1'-0"

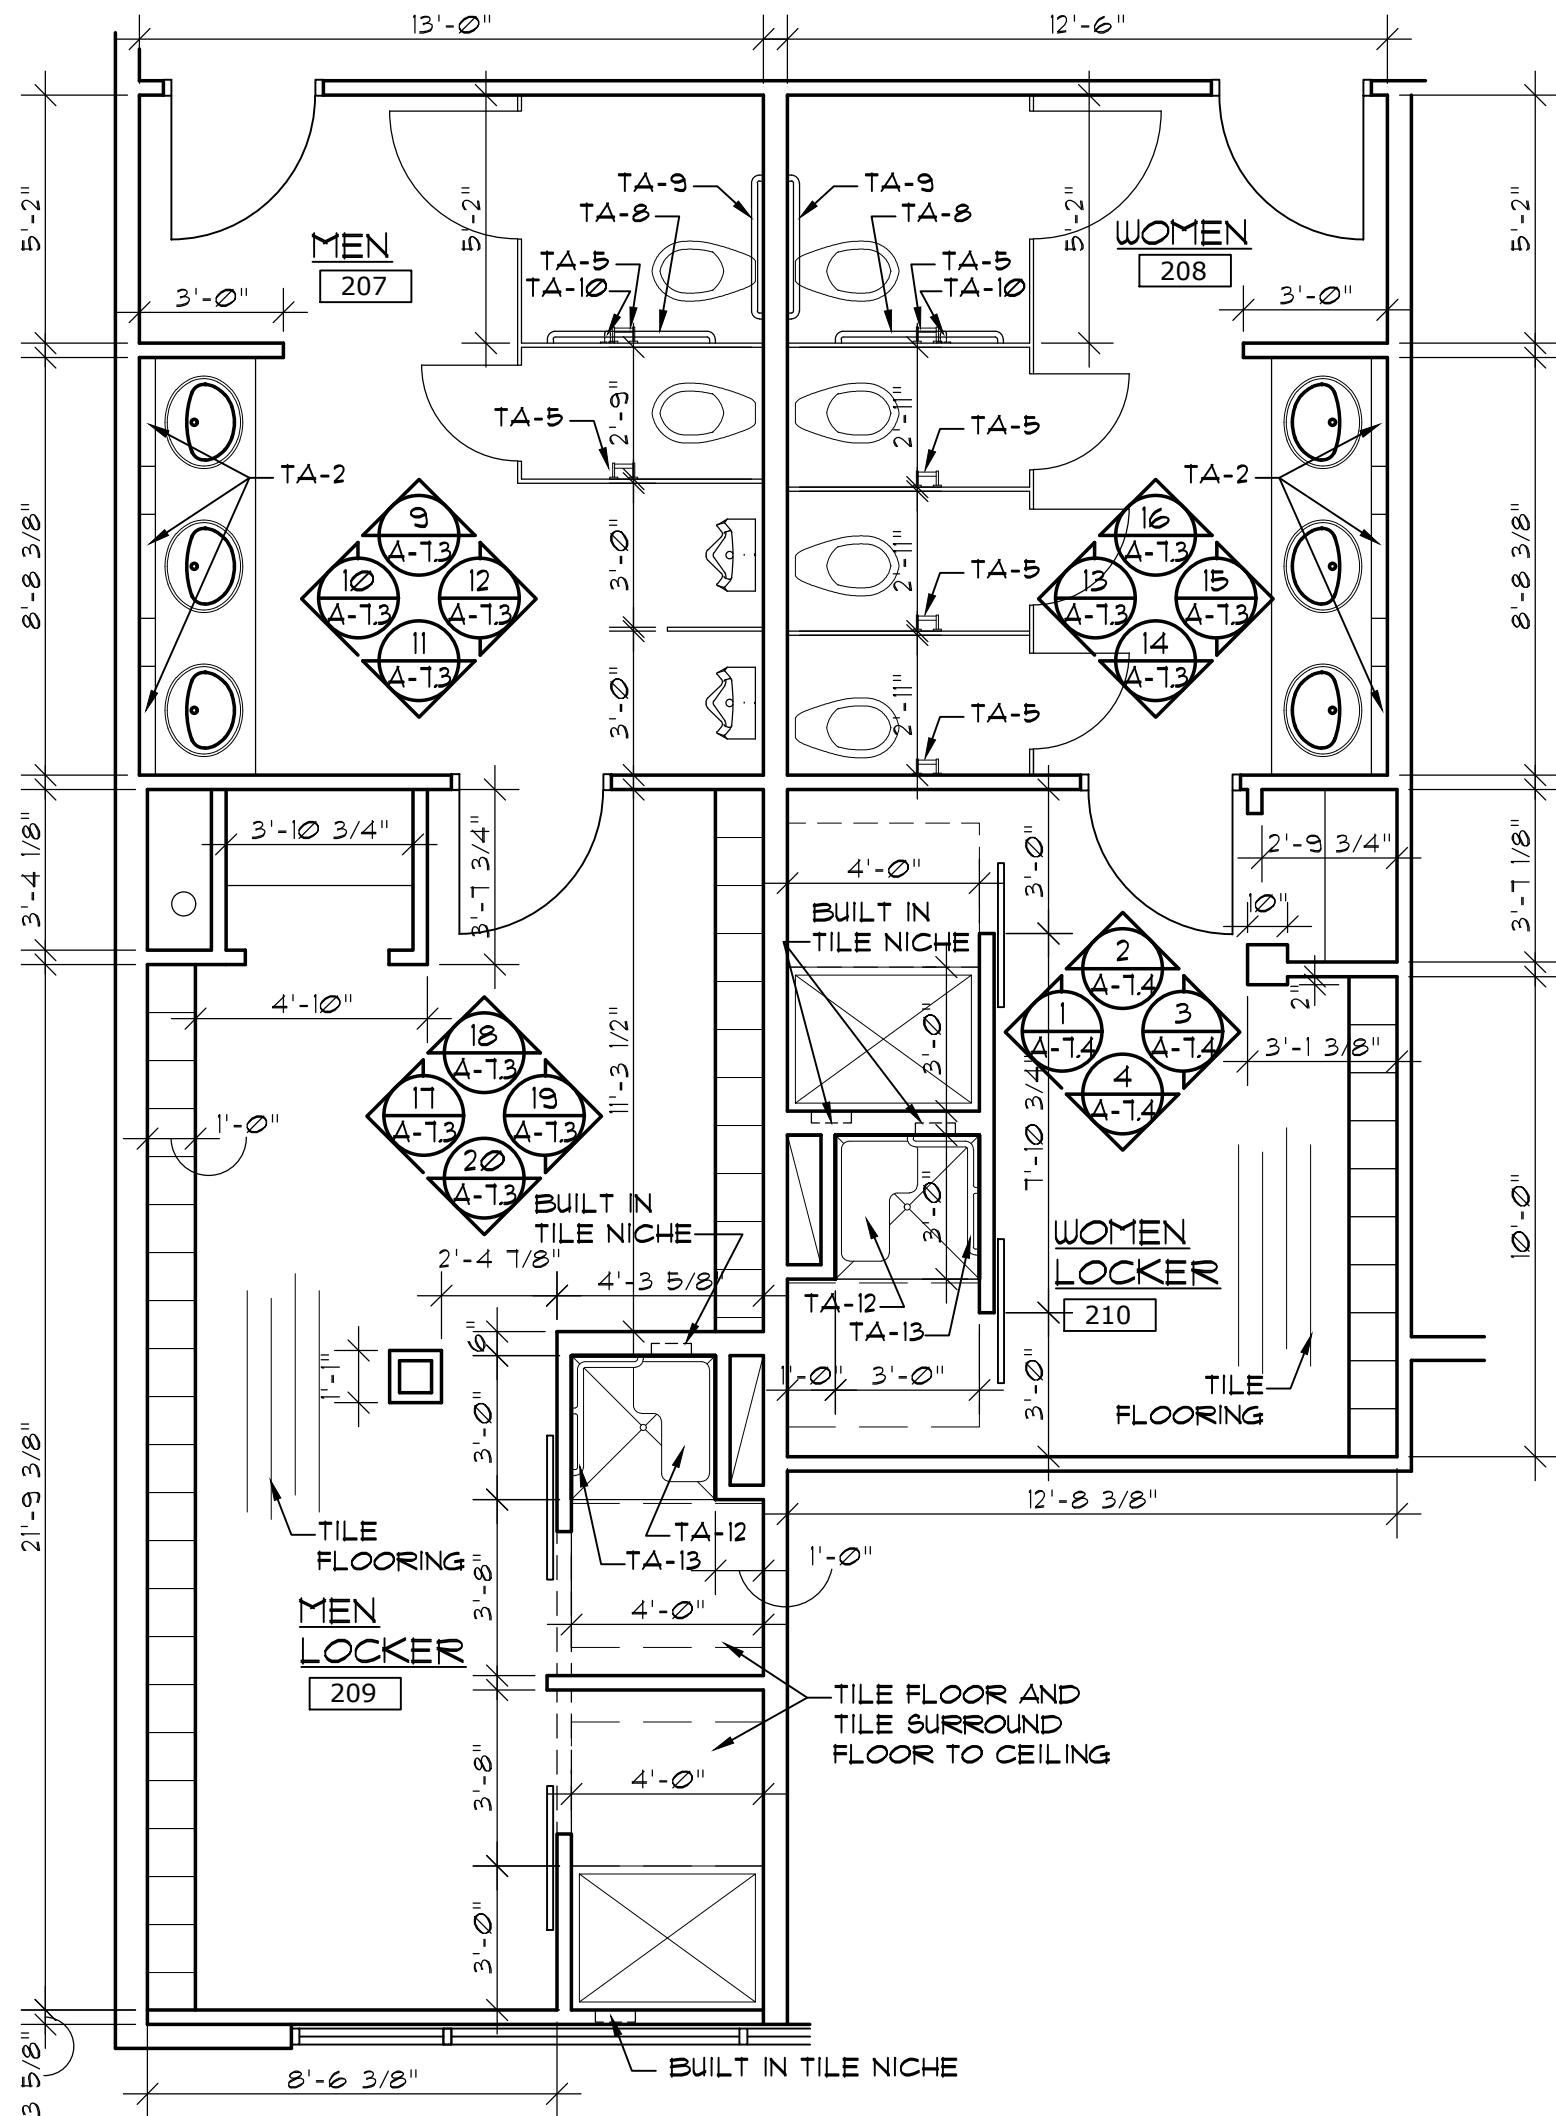


3
A-6
ENLARGED PLAN
SCALE: 1/4"=1'-0"

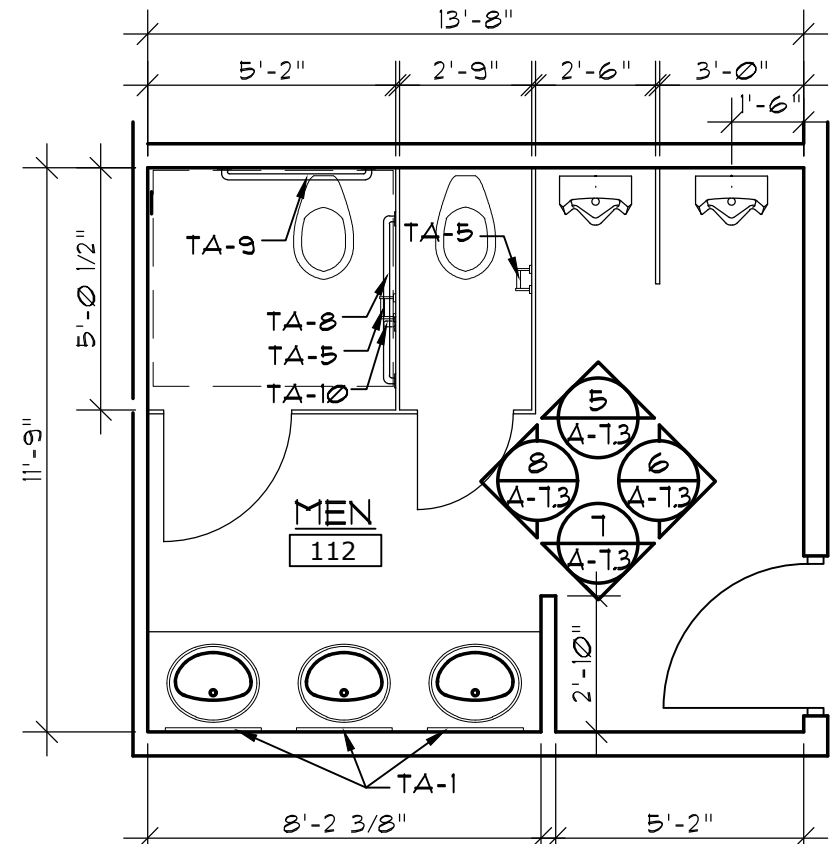






2
A-6
MEN TOILET 112
SCALE: 1/4"=1'-0"

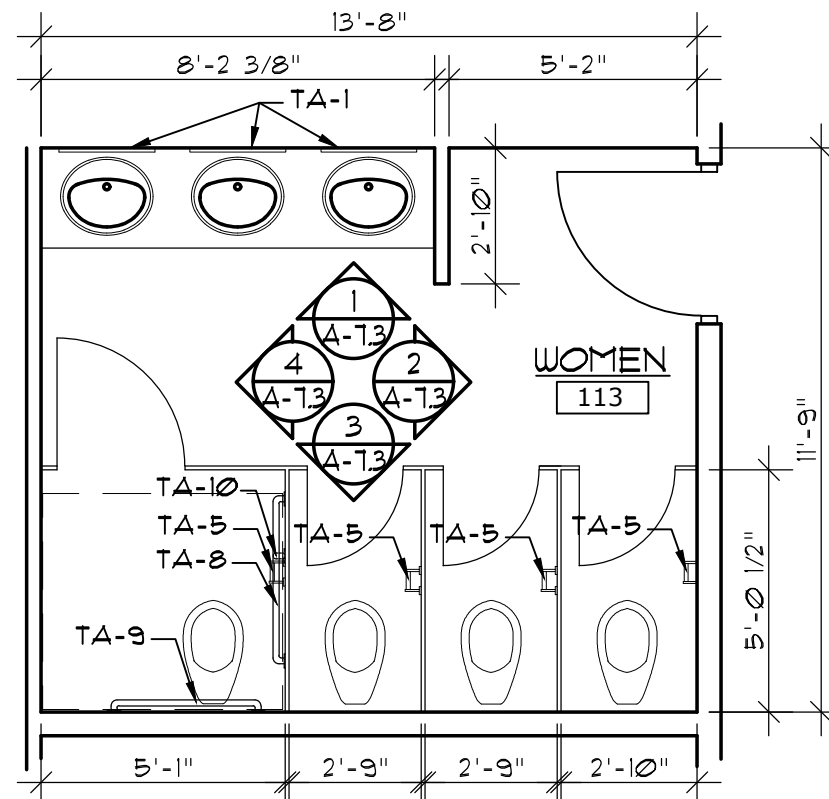


1
A-6
WOMEN TOILET 113
SCALE: 1/4"=1'-0"

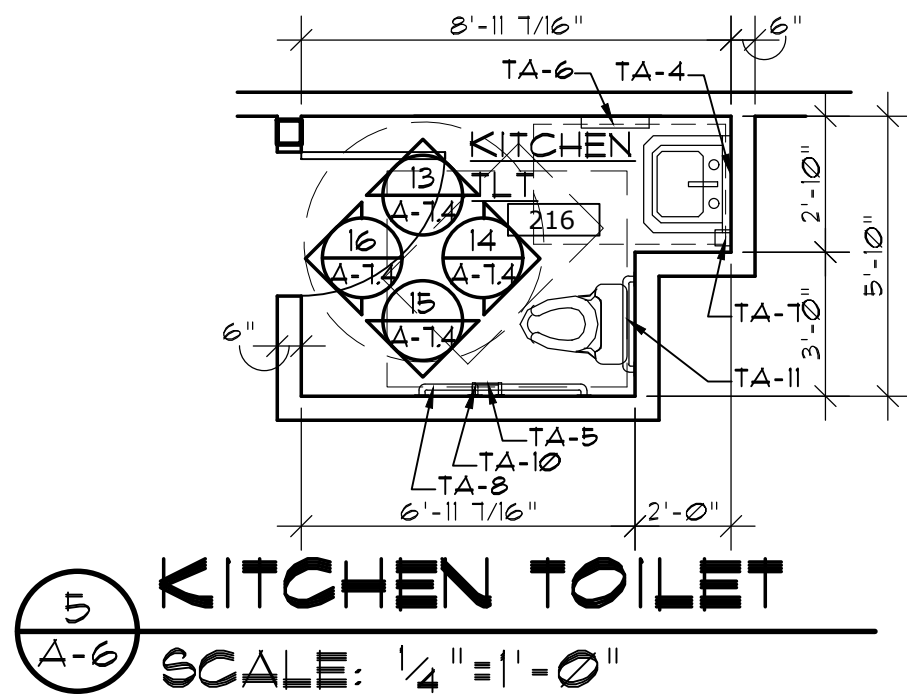


5
A-6
KITCHEN TOILET
SCALE: 1/4"=1'-0"

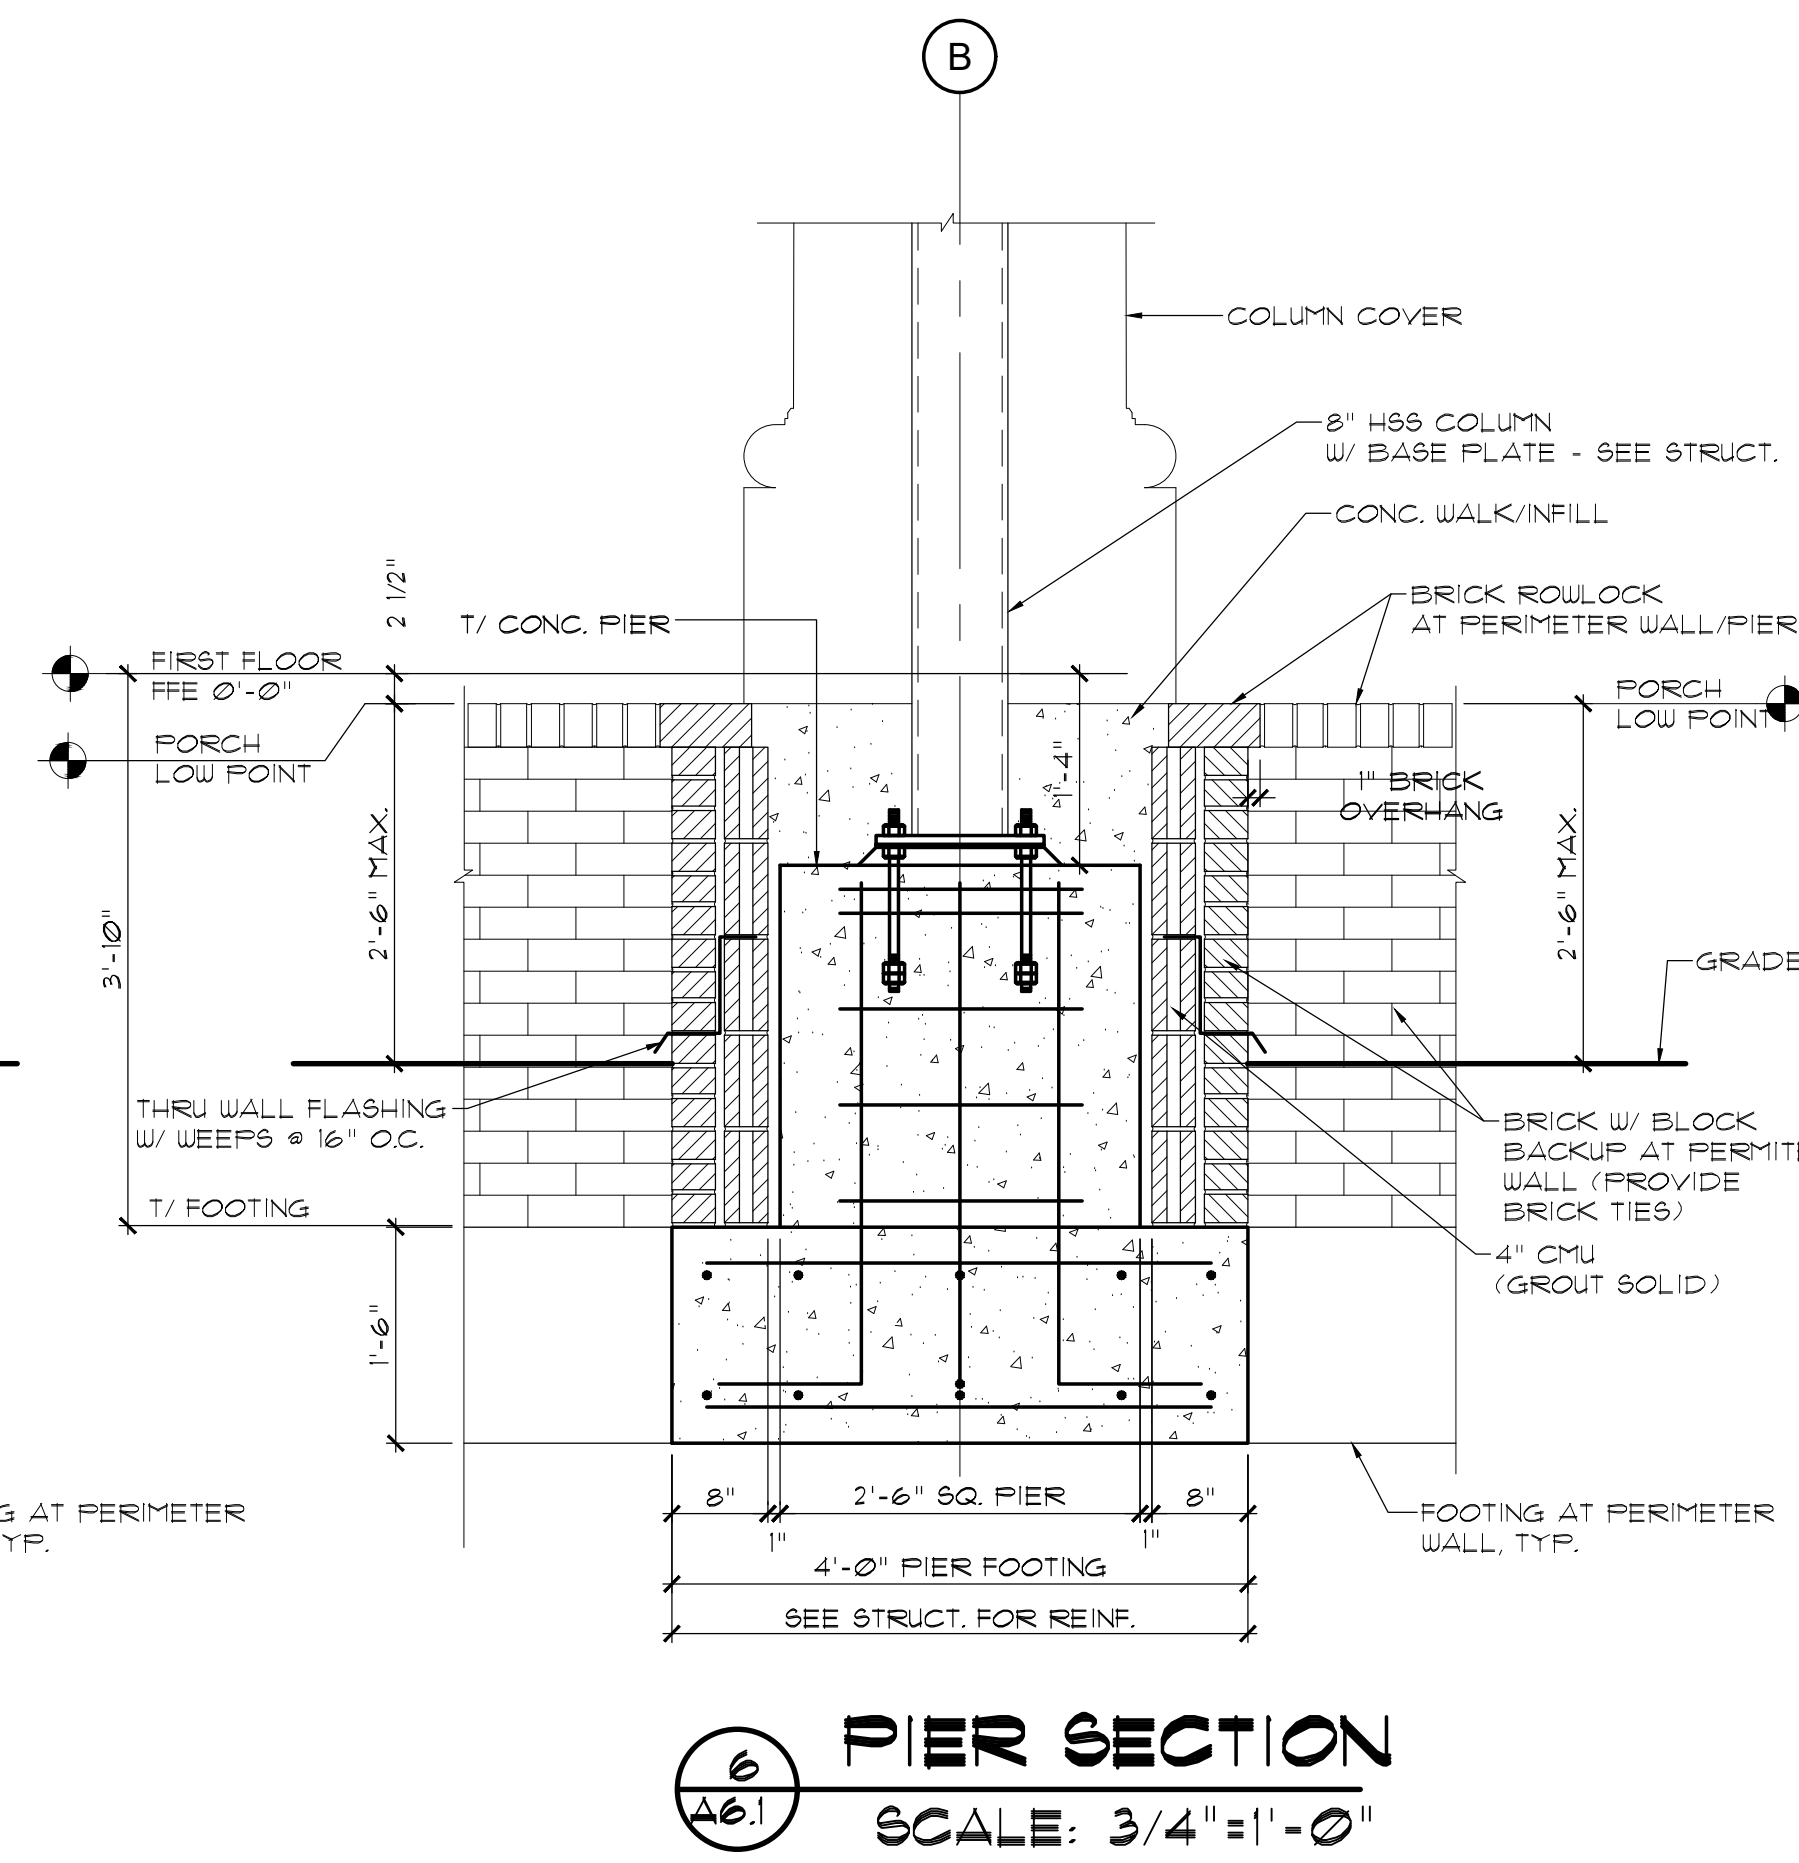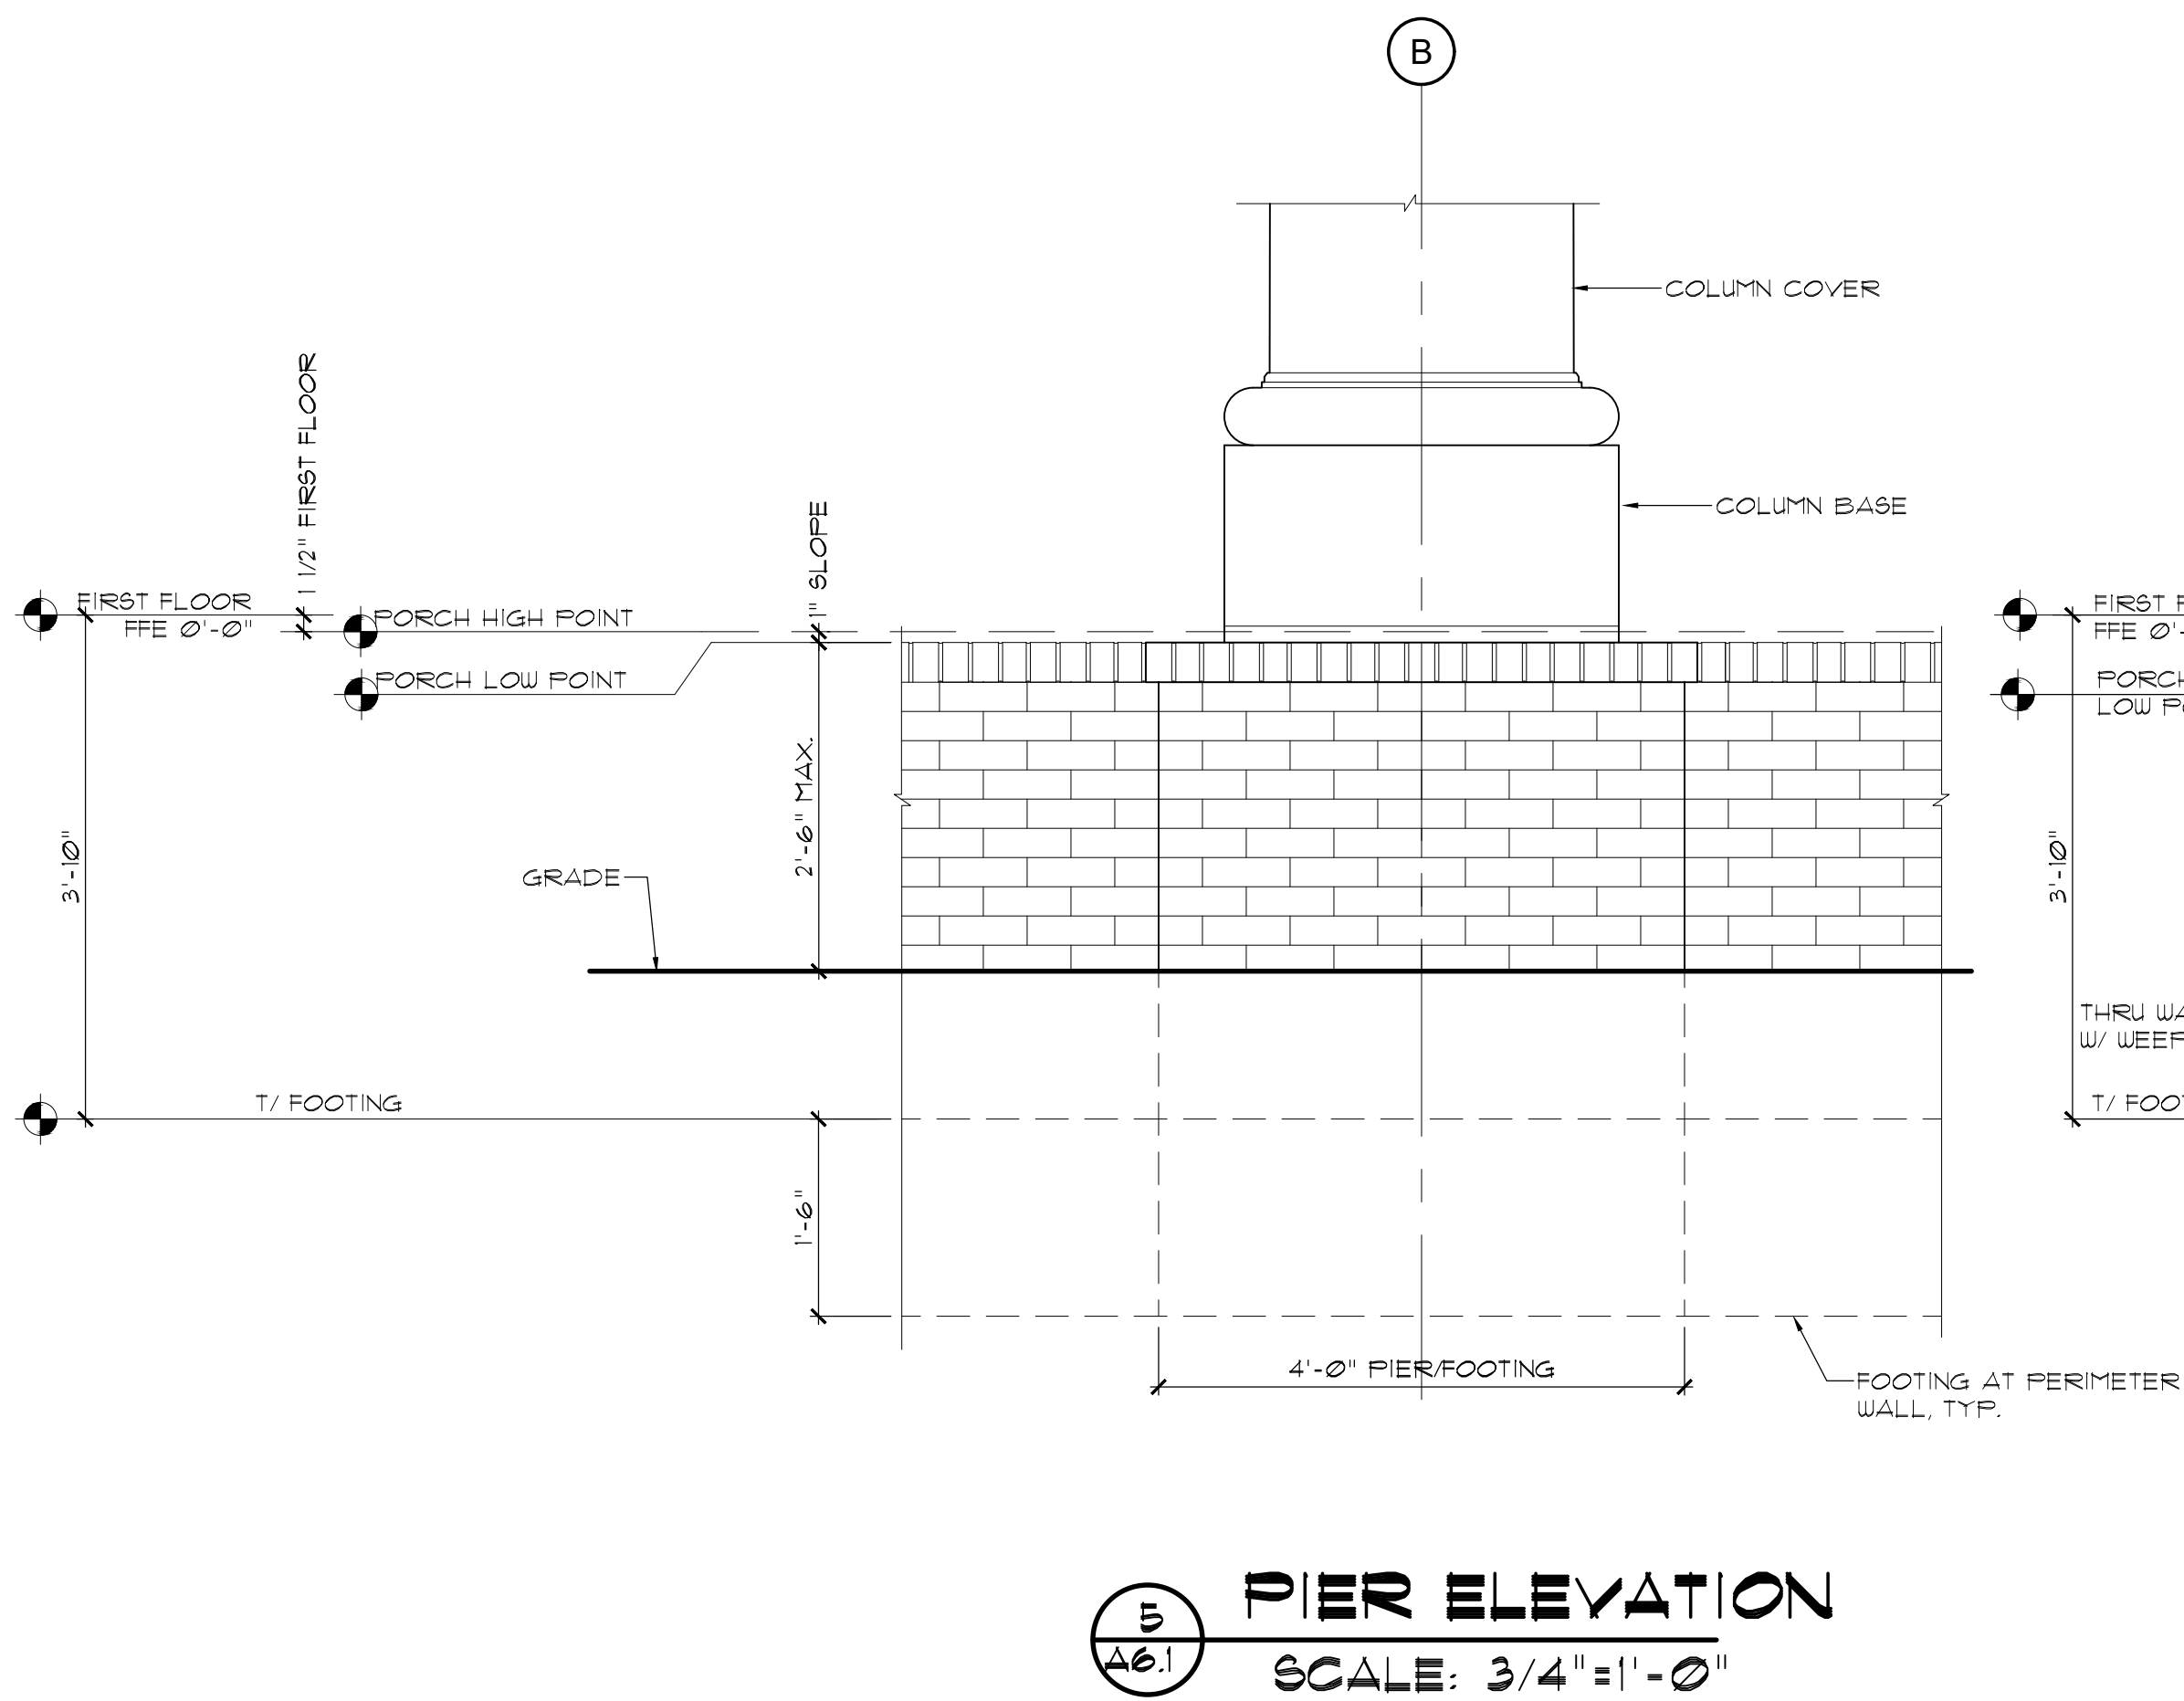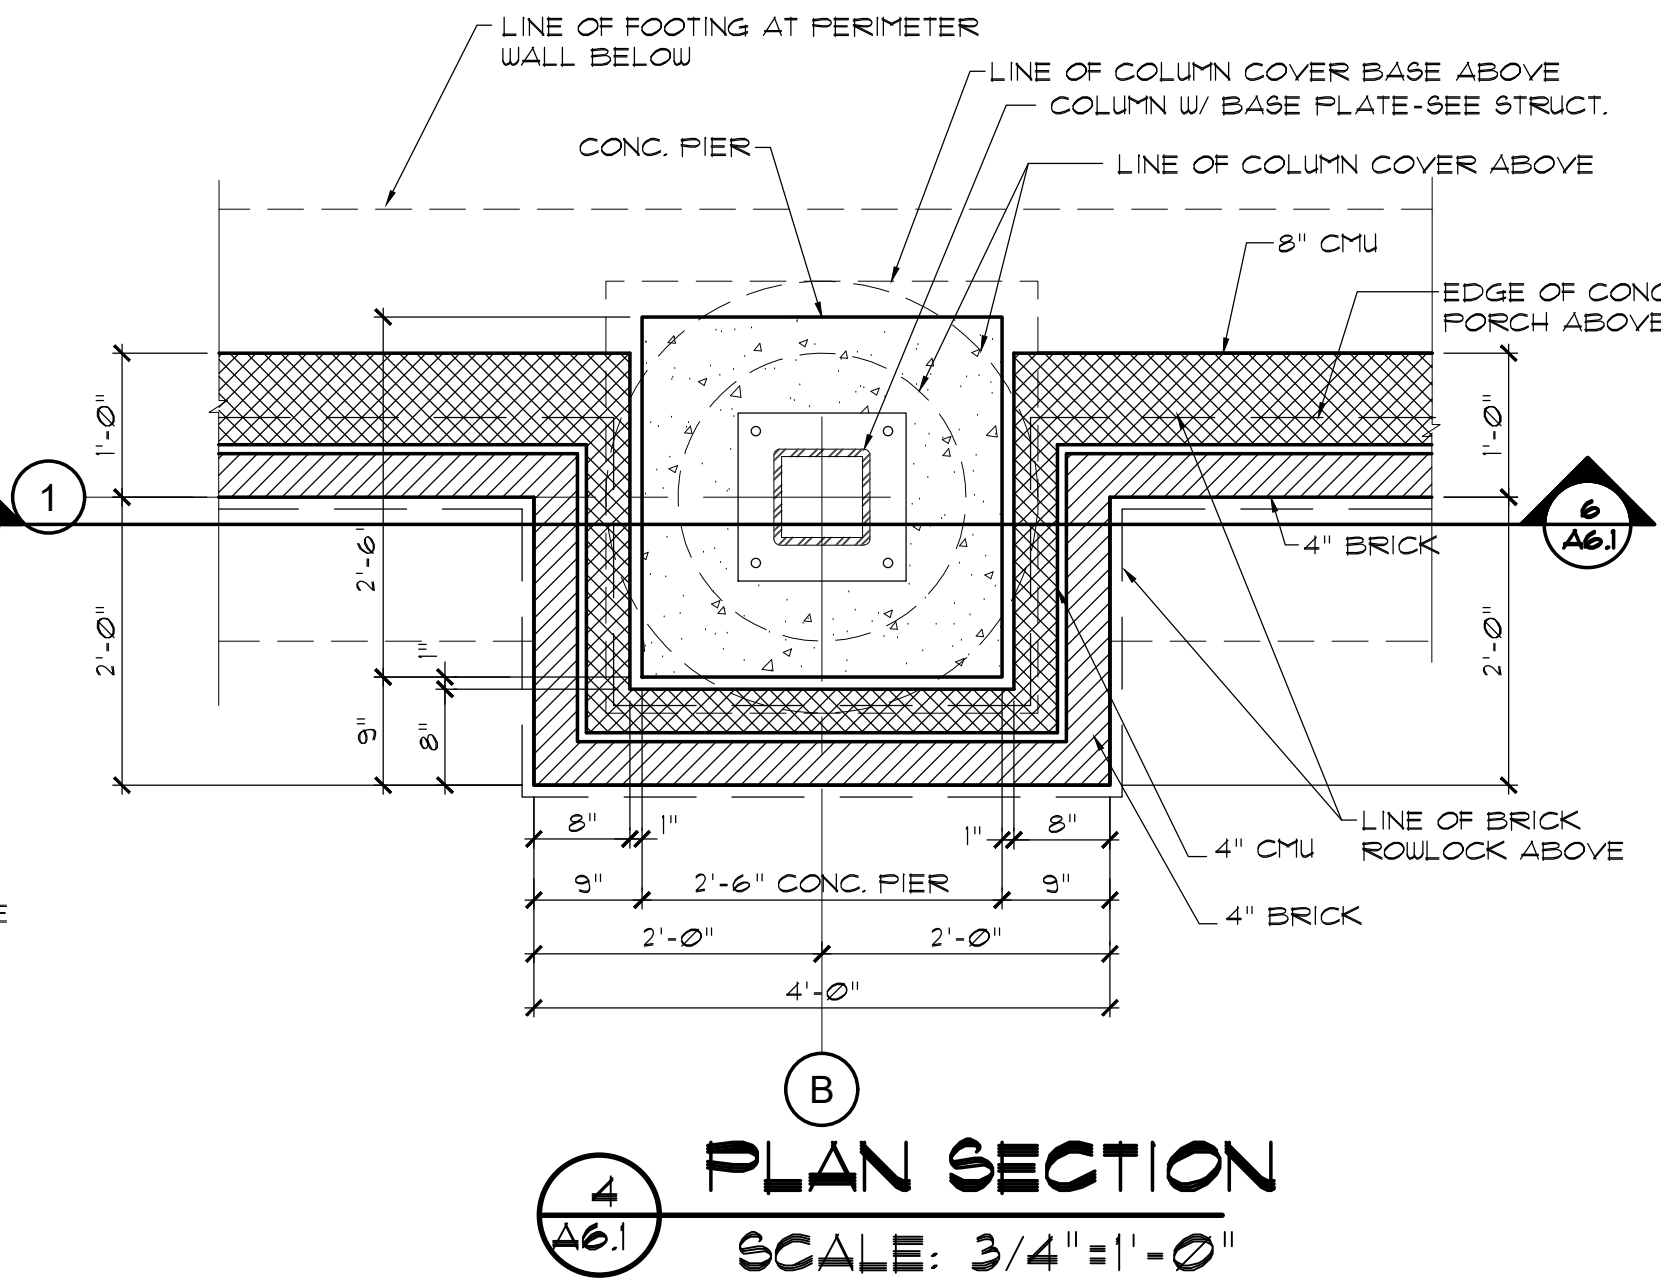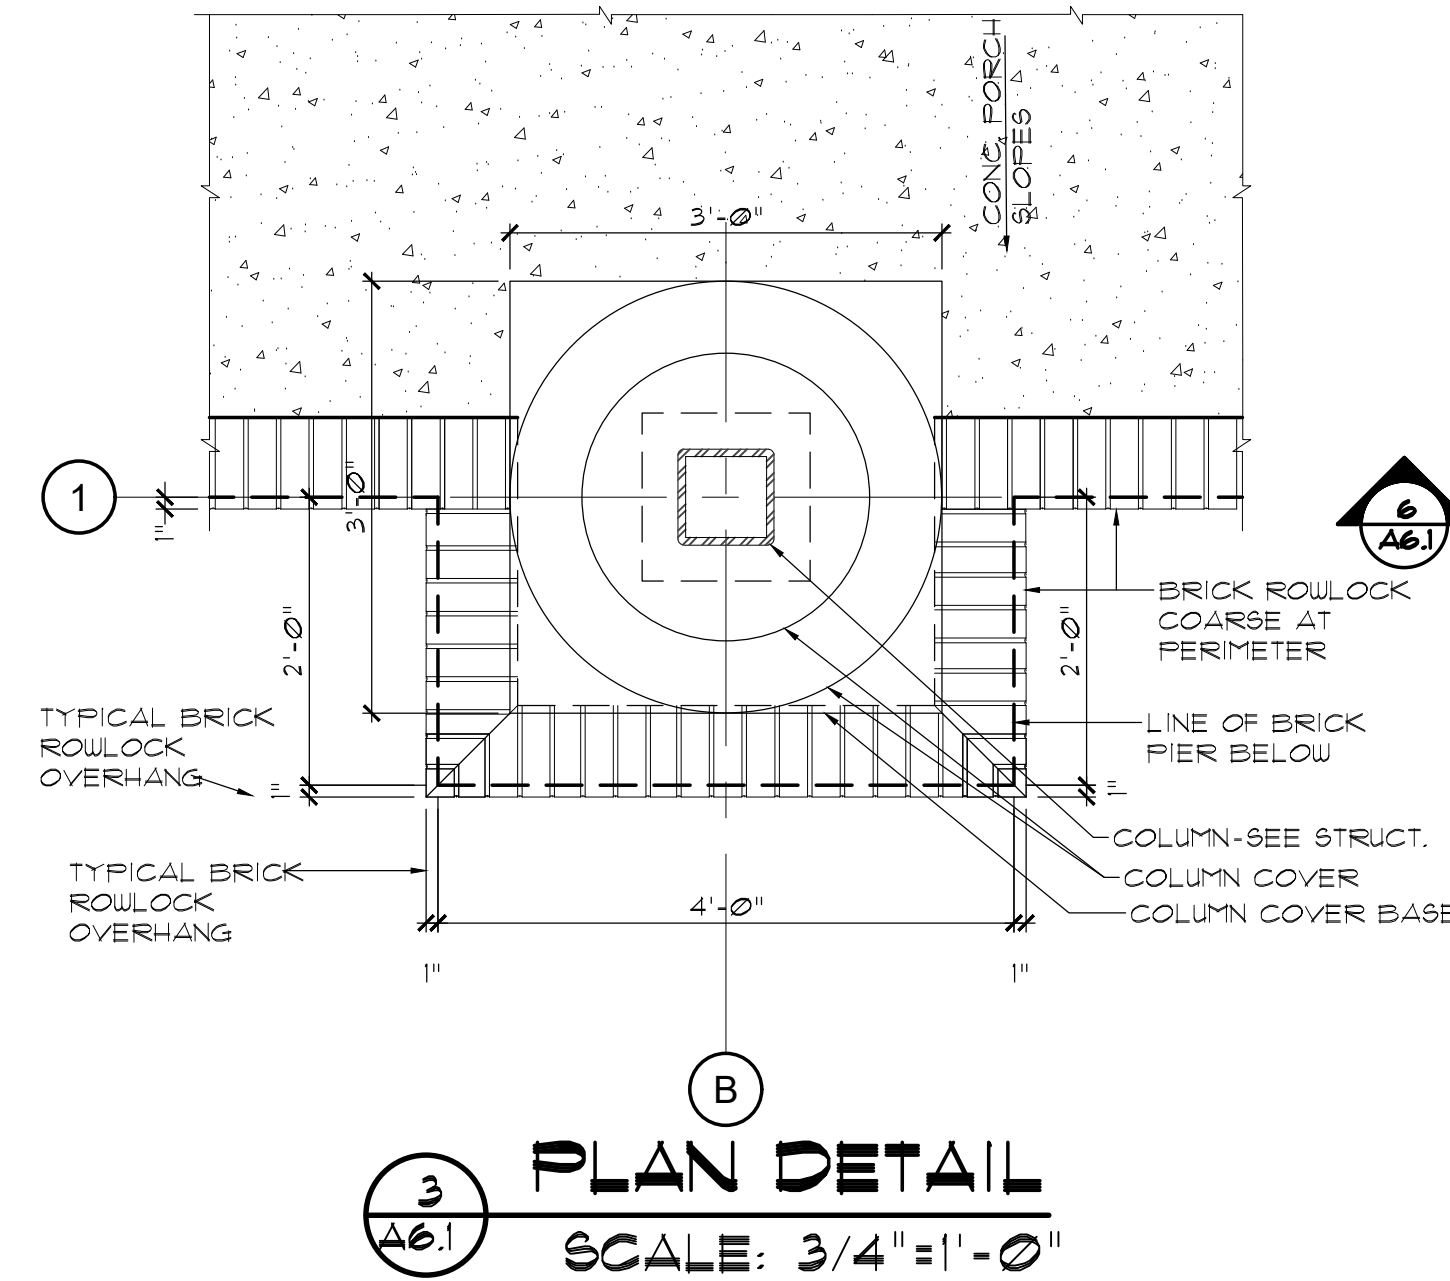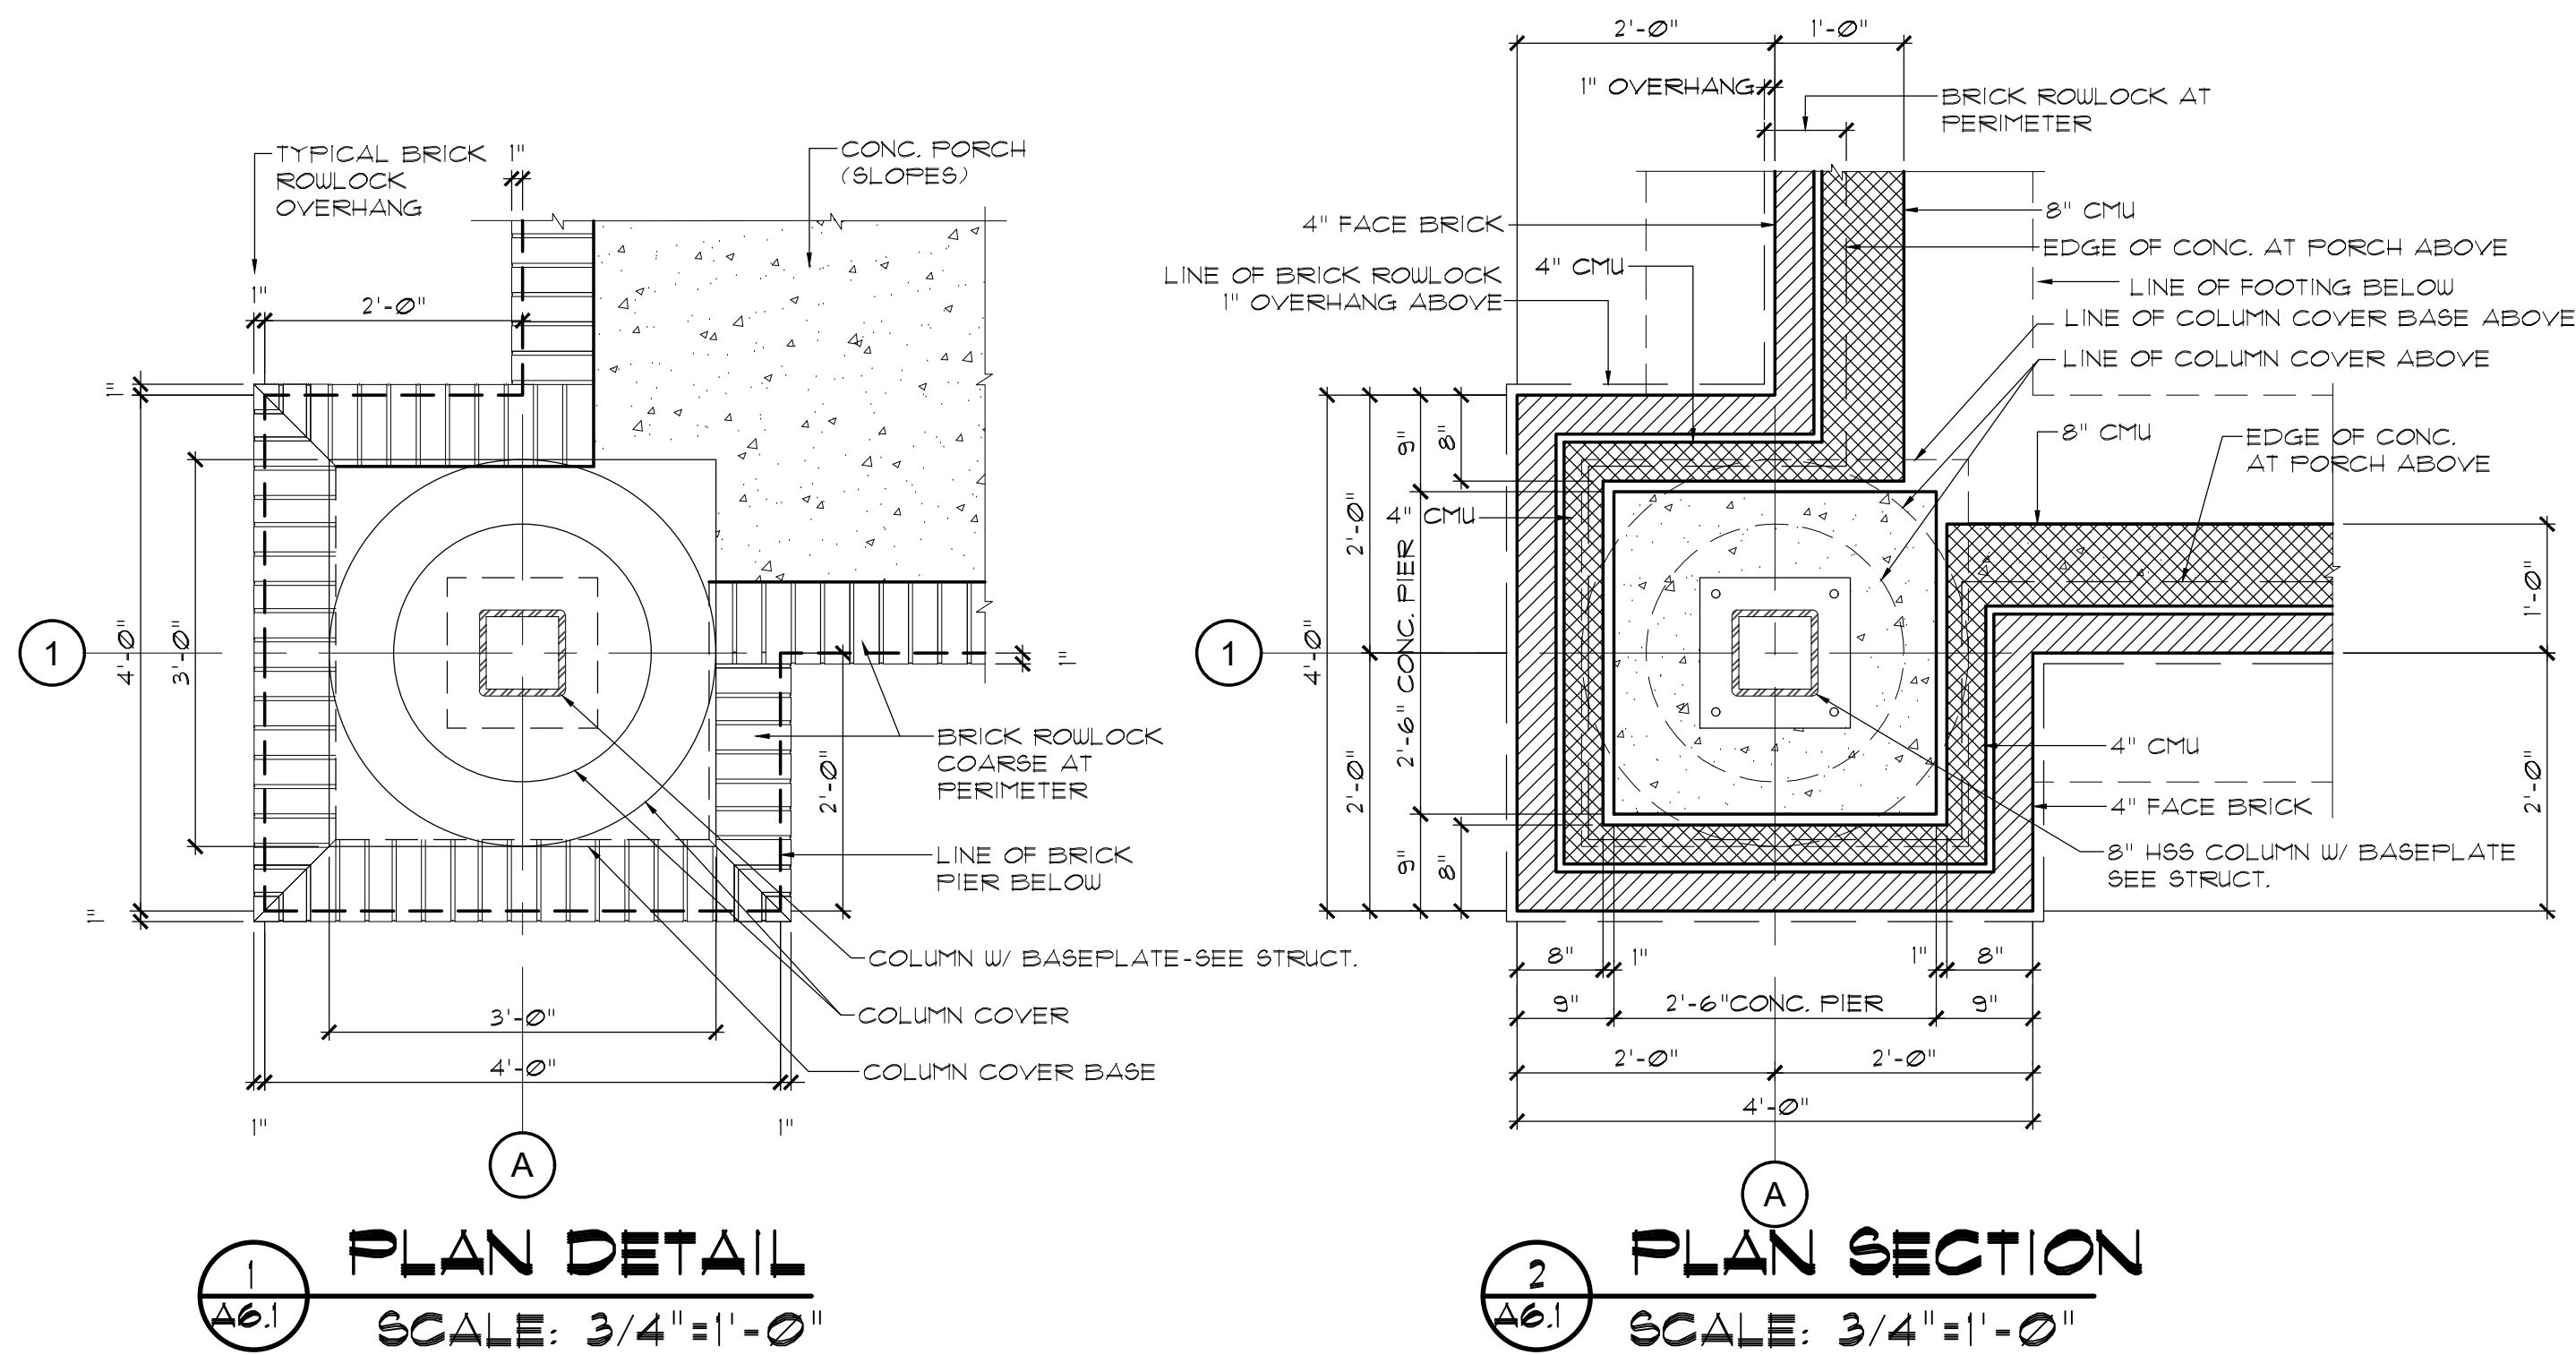


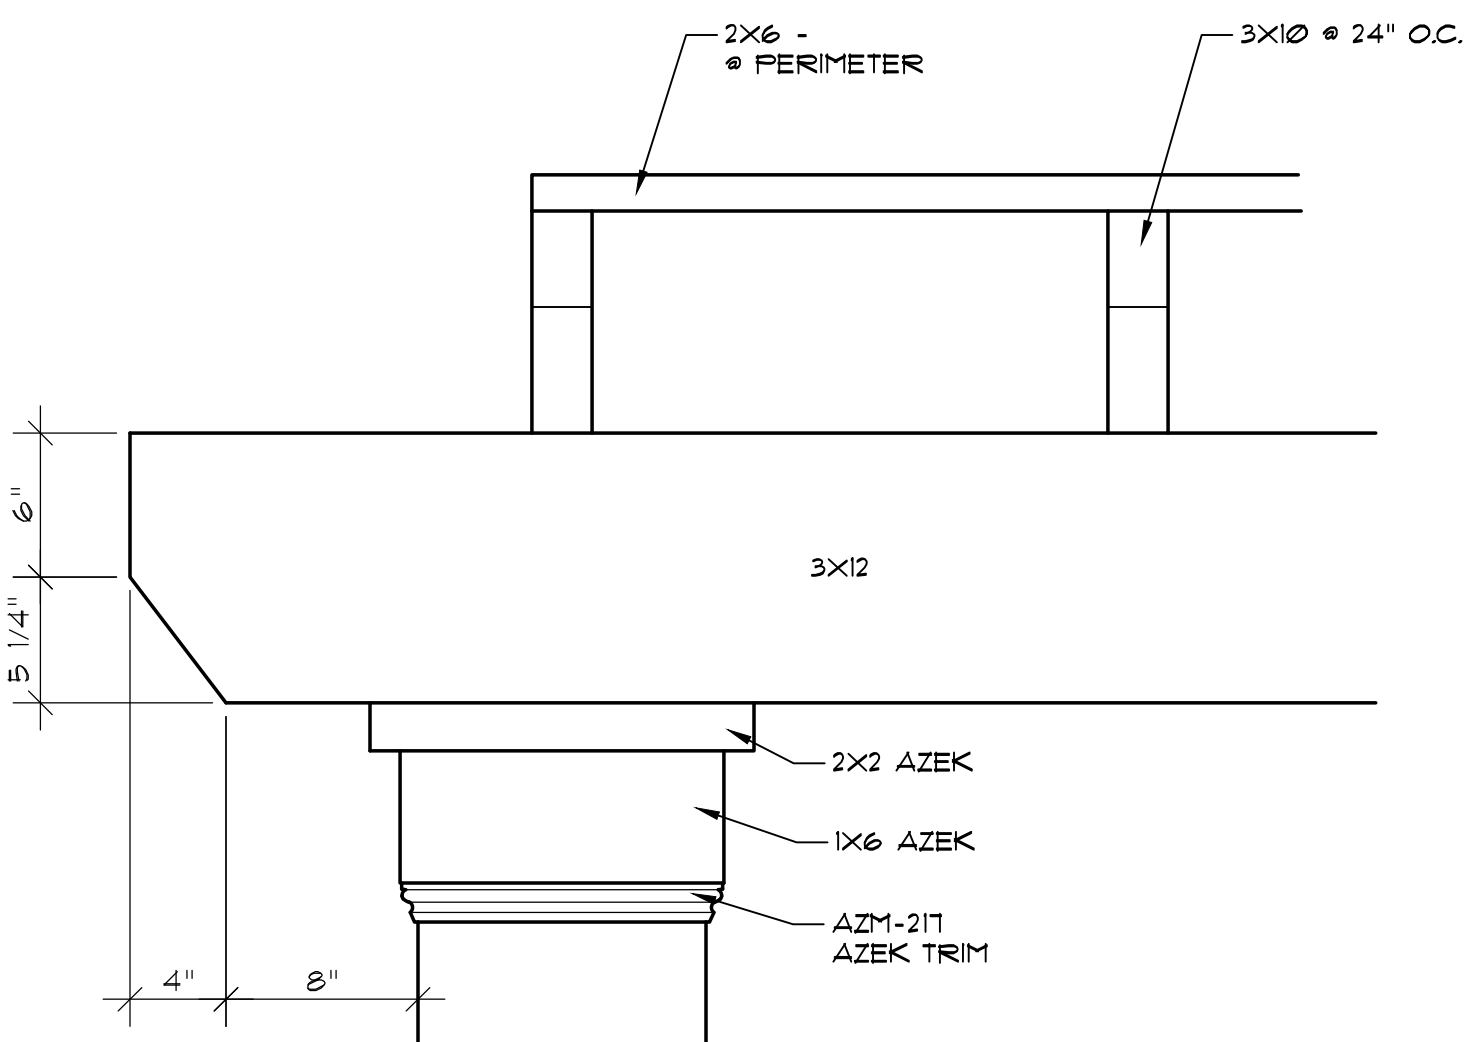


8 DETAIL @ PERGOLA & COLUMN
A-6.2 SCALE: 1 1/2"=1'-0"

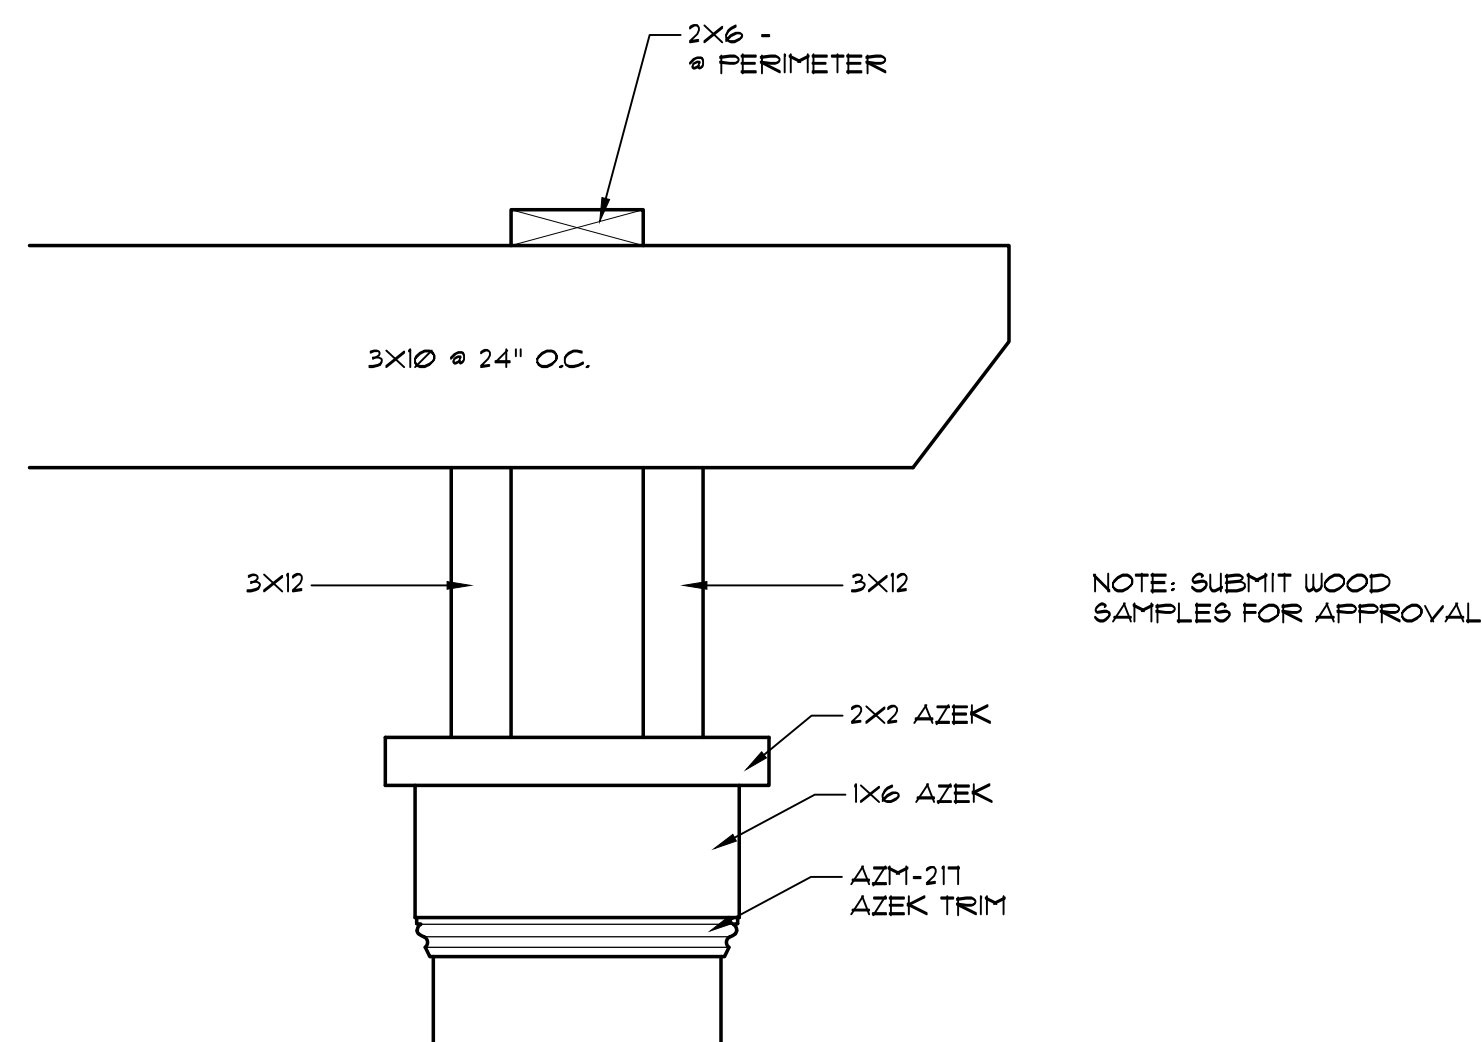

7 DETAIL @ PERGOLA & COLUMN
A-6.2 SCALE: 1 1/2"=1'-0"

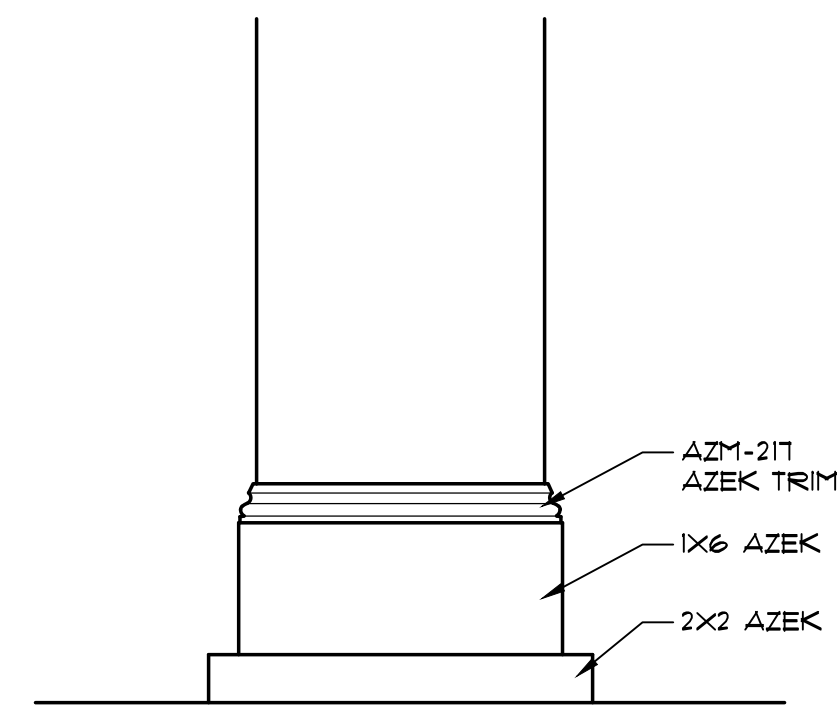


6 DETAIL @ COLUMN MOULDING
A-6.2 SCALE: 1 1/2"=1'-0"

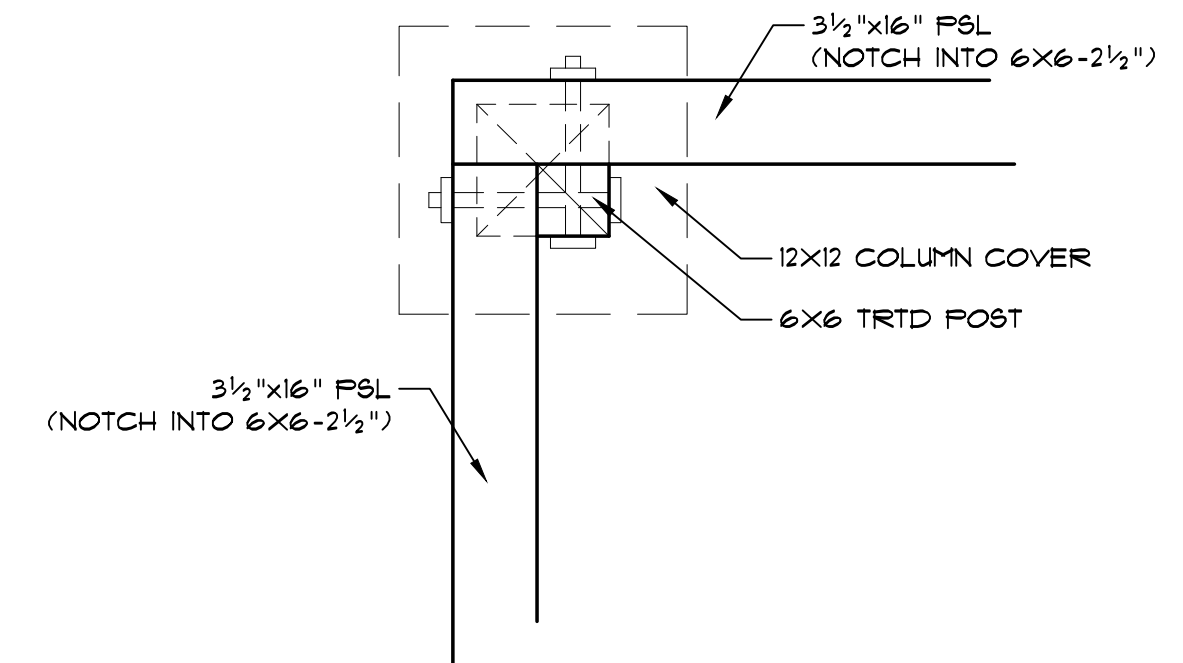


5 DETAIL @ PERGOLA
A-6.2 SCALE: 1 1/2"=1'-0"


NOTE: ALL WOOD/TRIM TO BE PAINTED

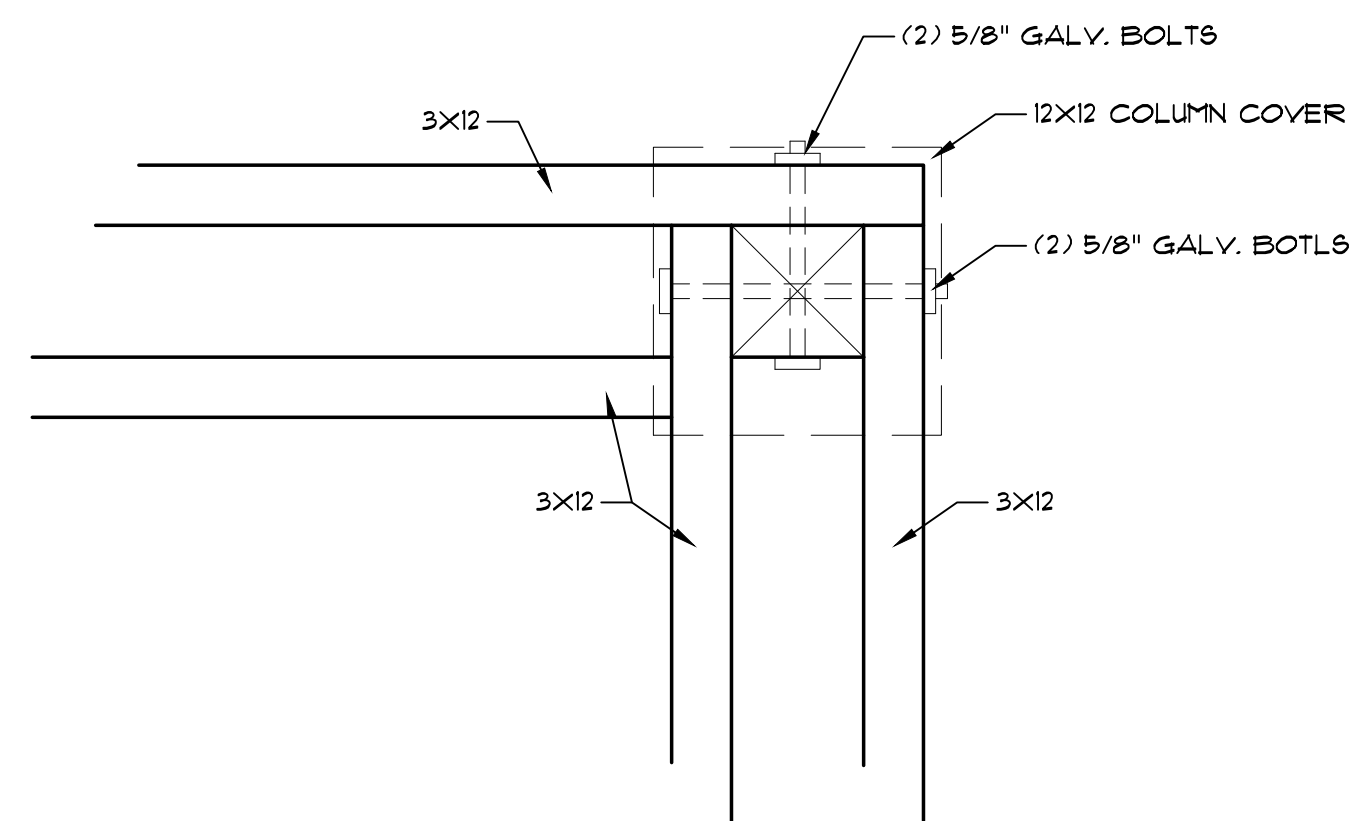


4 DETAIL @ PERGOLA COLUMN
A-6.2 SCALE: 1 1/2"=1'-0"

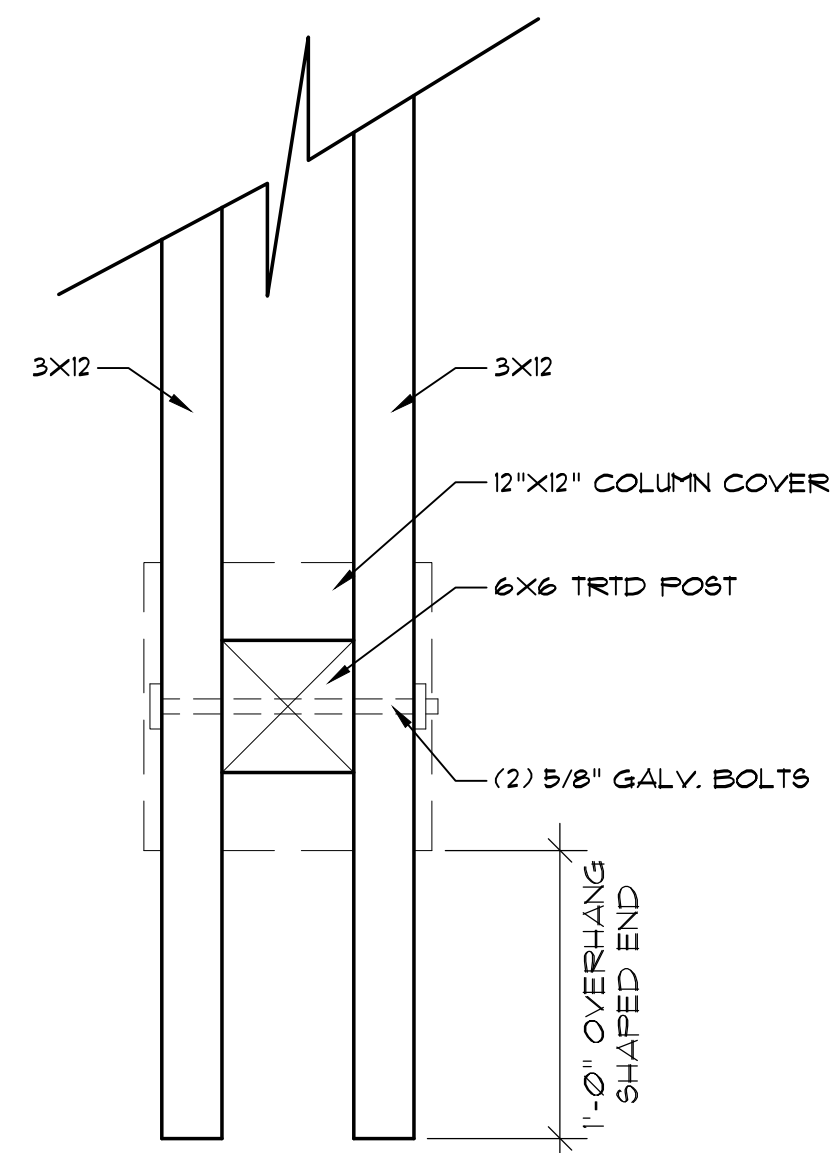


3 DETAIL @ PERGOLA COLUMN
A-6.2 SCALE: 1 1/2"=1'-0"

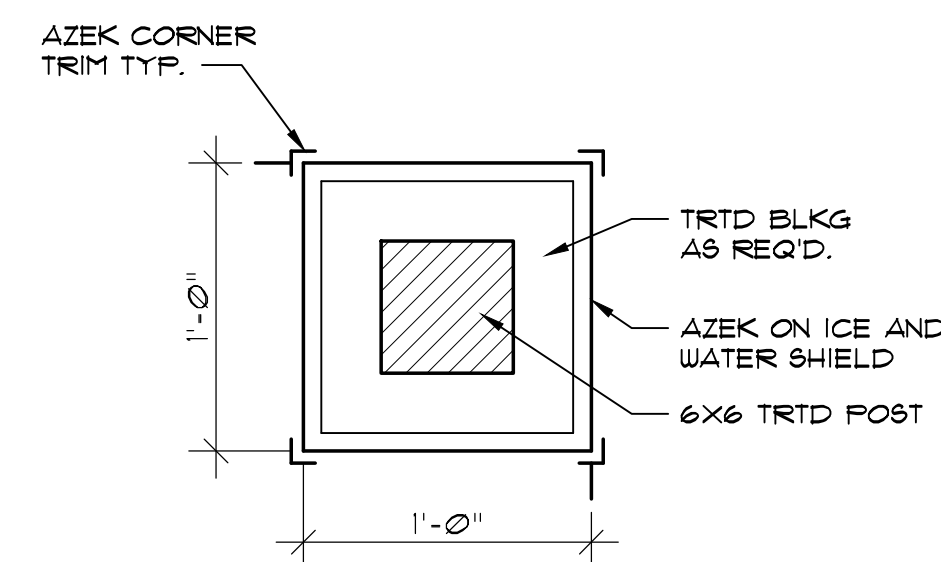


2 DETAIL @ COLUMN
A-6.2 SCALE: 1 1/2"=1'-0"

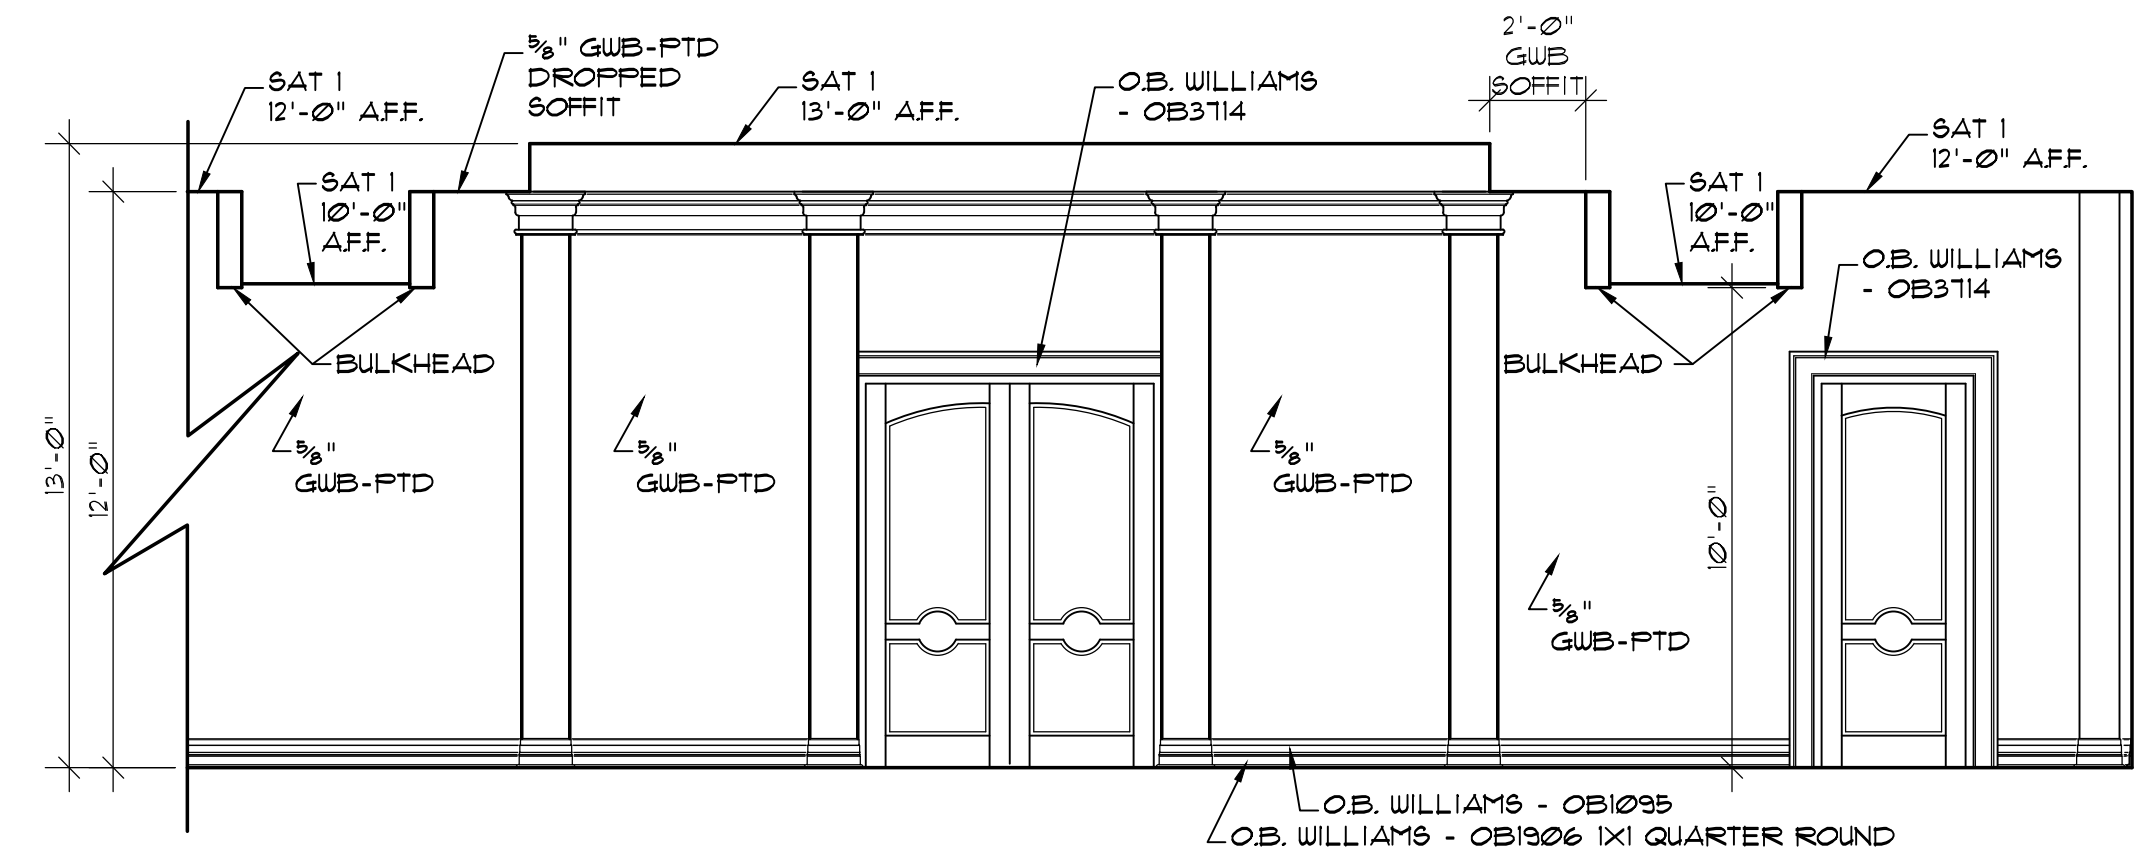


11 BALLROOM ENTRY DOORS ELEVATION
SCALE: 1/4"=1'-0"

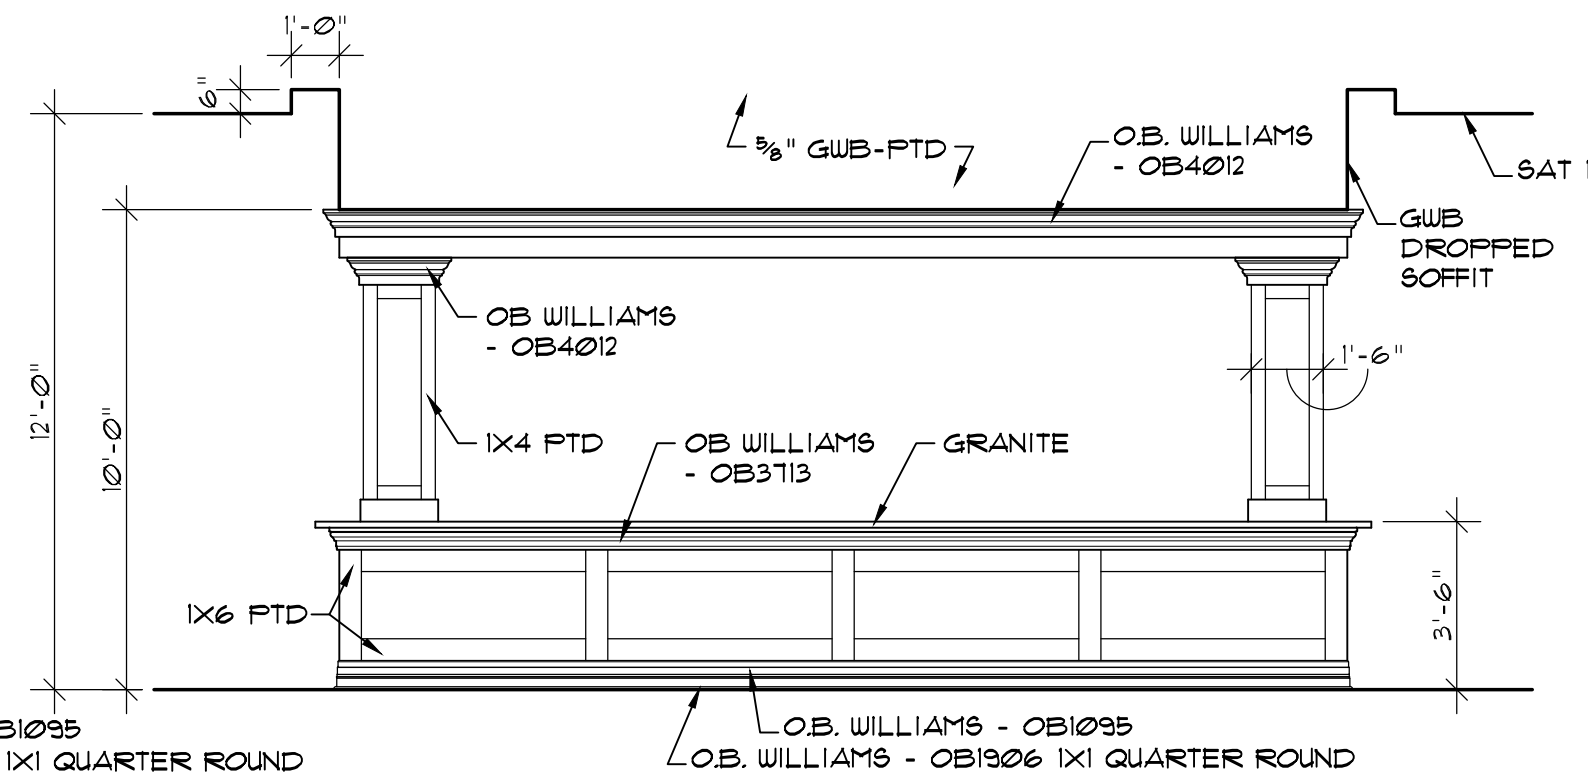


12 MEMBER BAR ELEVATION
SCALE: 1/4"=1'-0"

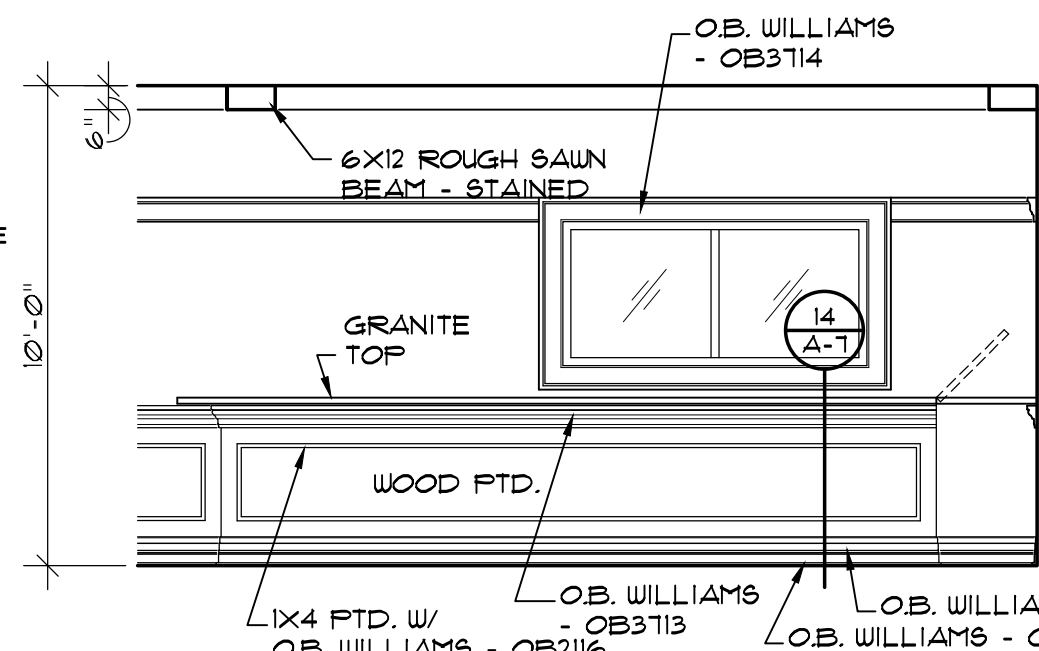


13 ROOF TOP BAR ELEVATION
SCALE: 1/4"=1'-0"

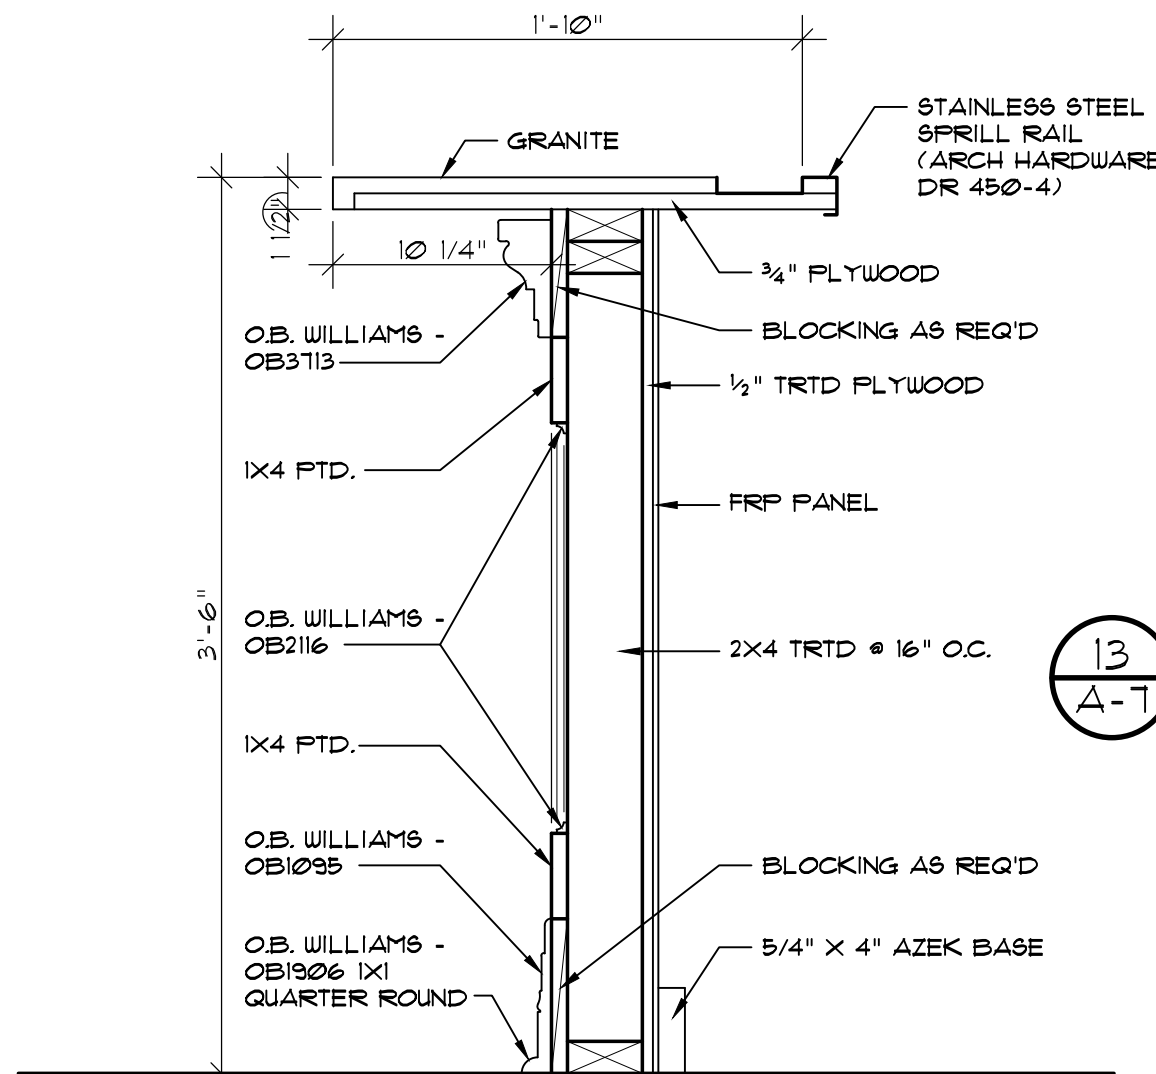

14 ROOF TOP BAR DETAIL
SCALE: 1/2"=1'-0"

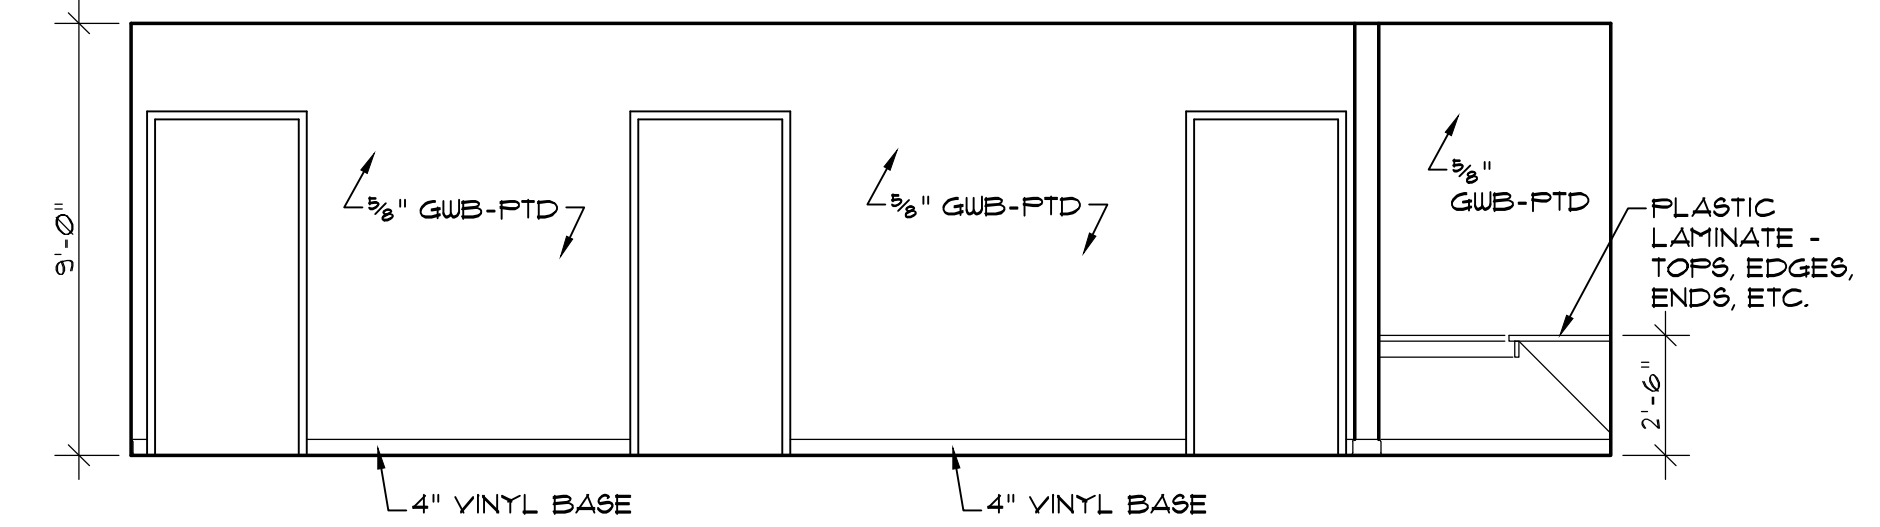


8 OFFICE WORK AREA ELEVATION
SCALE: 1/4"=1'-0"

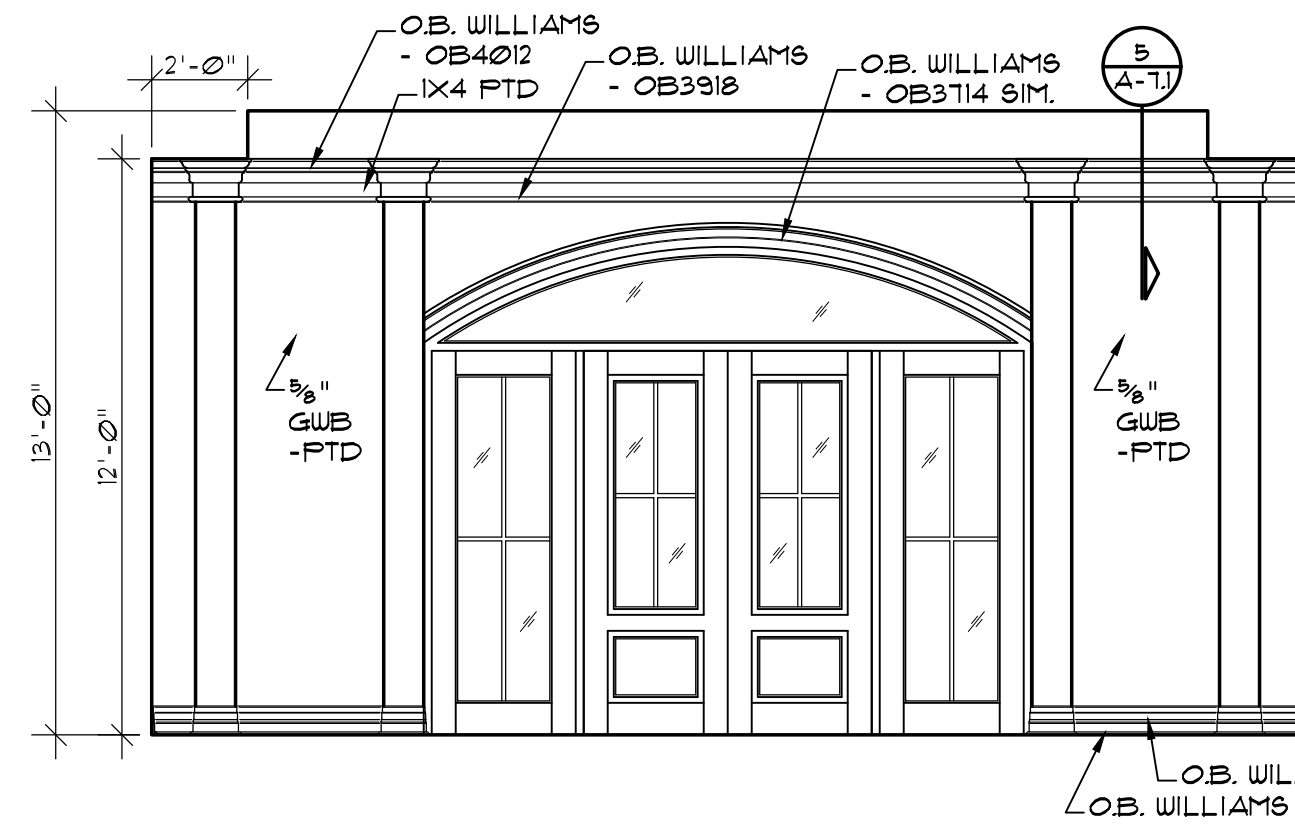


9 FOYER ENTRY ELEVATION
SCALE: 1/4"=1'-0"




10 FOYER ENTRY ELEVATION
SCALE: 1/4"=1'-0"

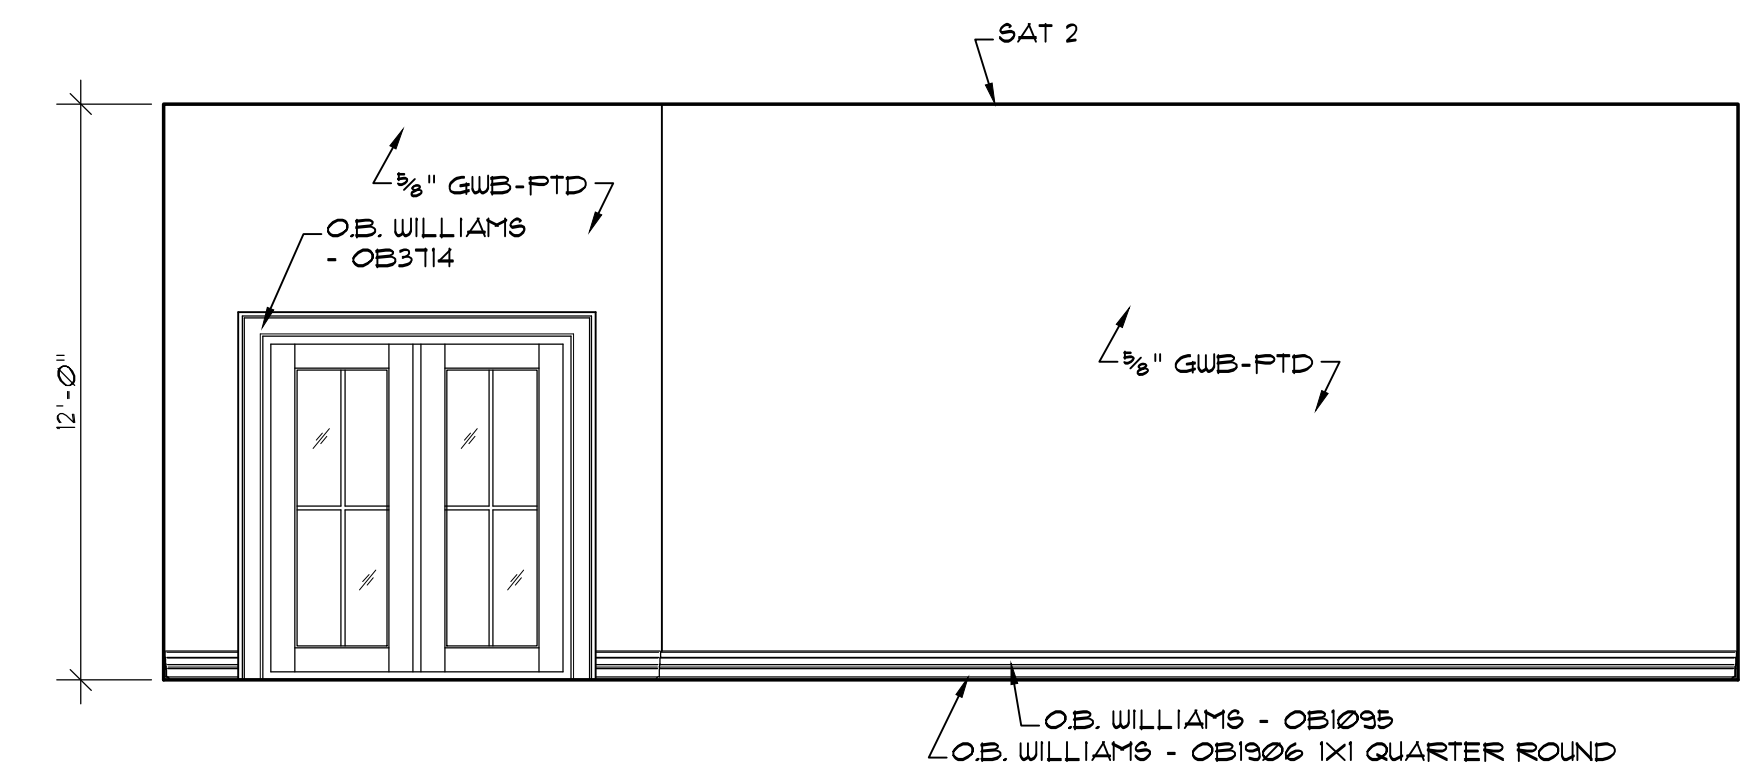


4 PRO SHOP ELEVATION
SCALE: 1/4"=1'-0"

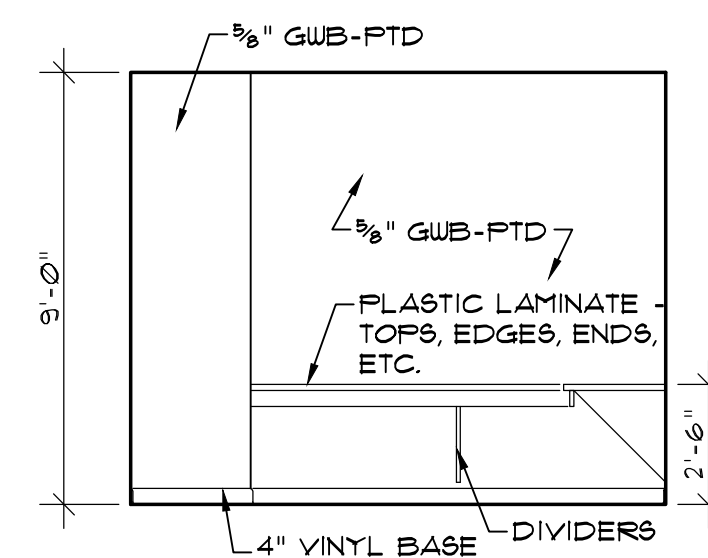


5 OFFICE ELEVATION
SCALE: 1/4"=1'-0"

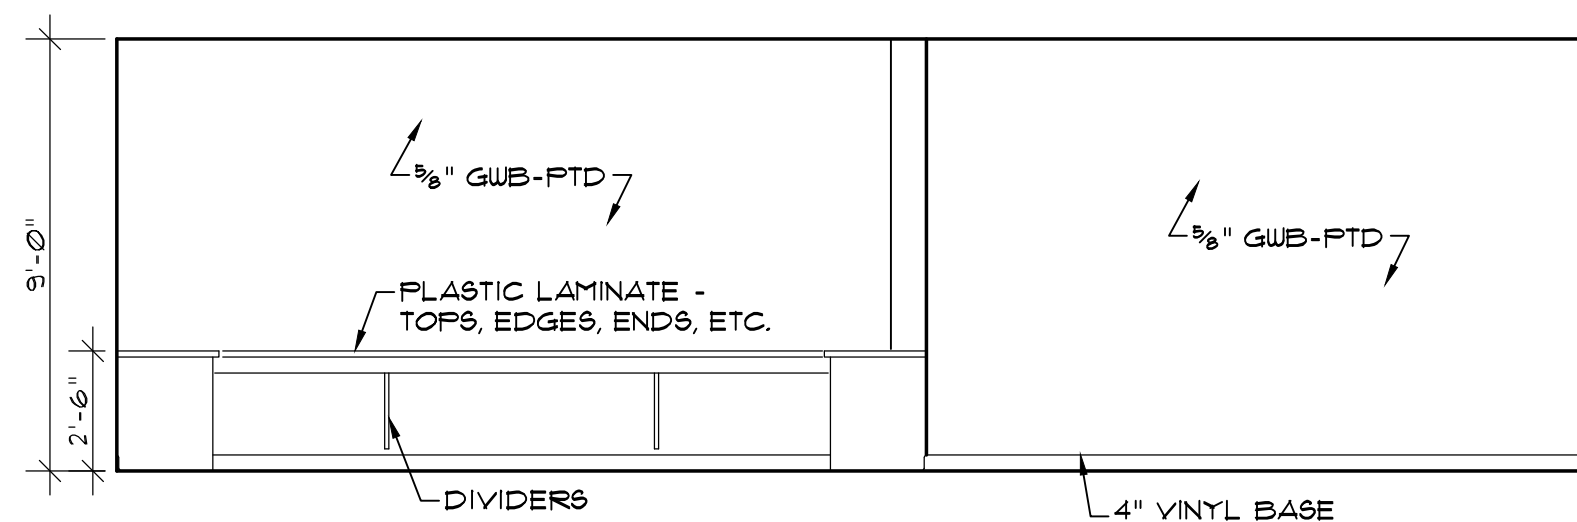


6 OFFICE ELEVATION
SCALE: 1/4"=1'-0"

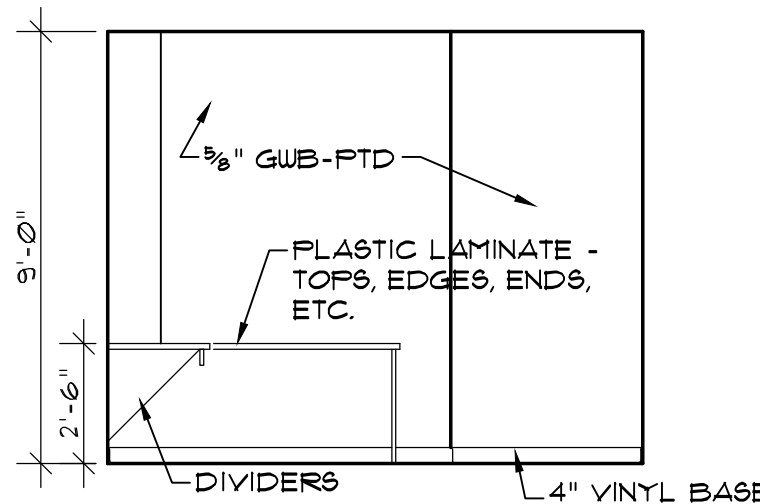


7 OFFICE ELEVATION
SCALE: 1/4"=1'-0"

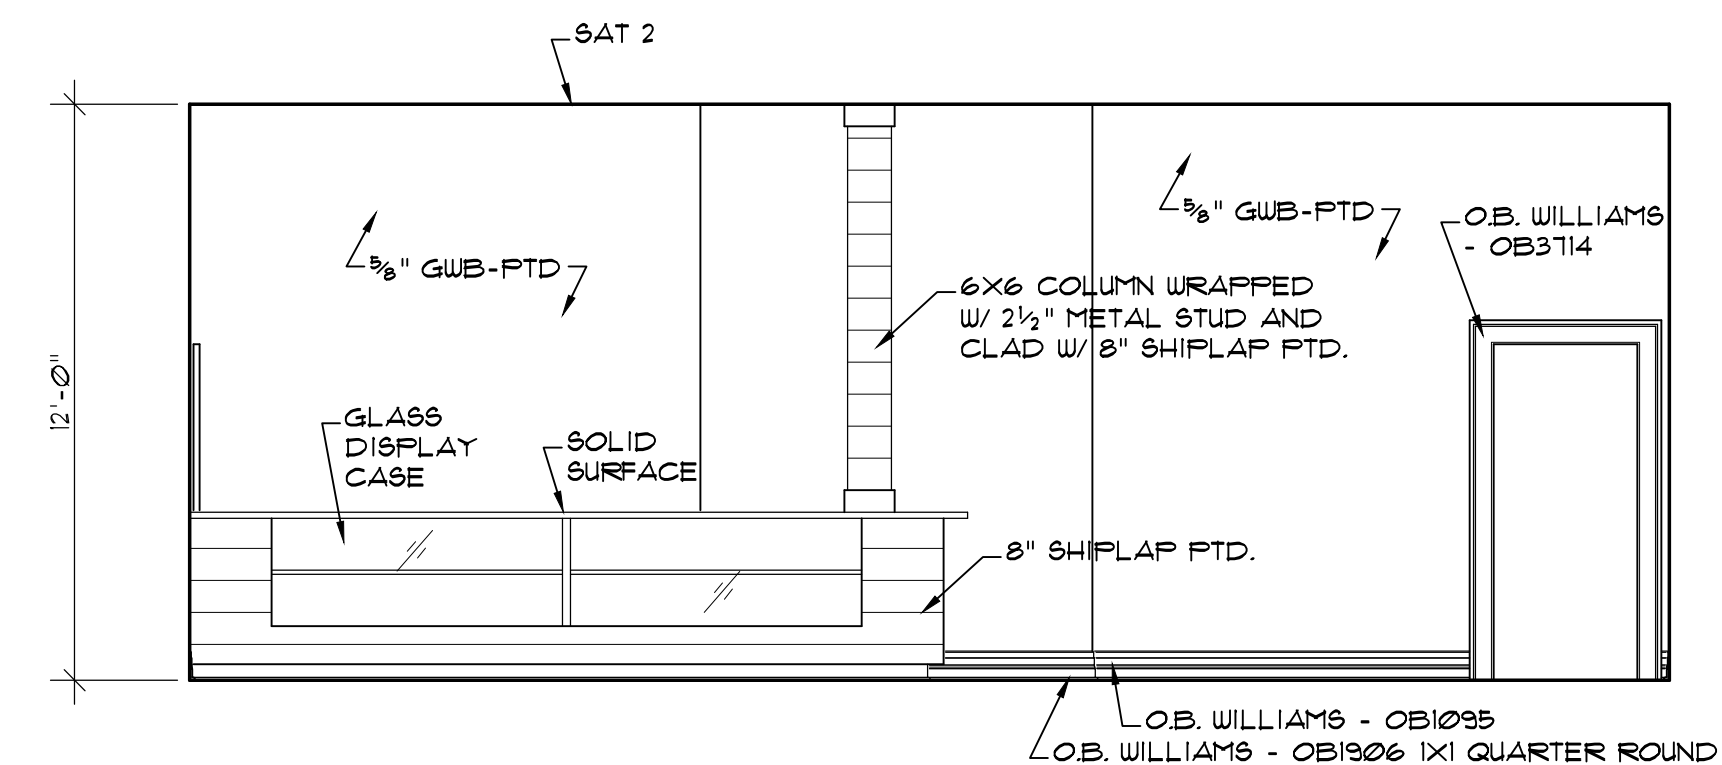


1 PRO SHOP ELEVATION
SCALE: 1/4"=1'-0"

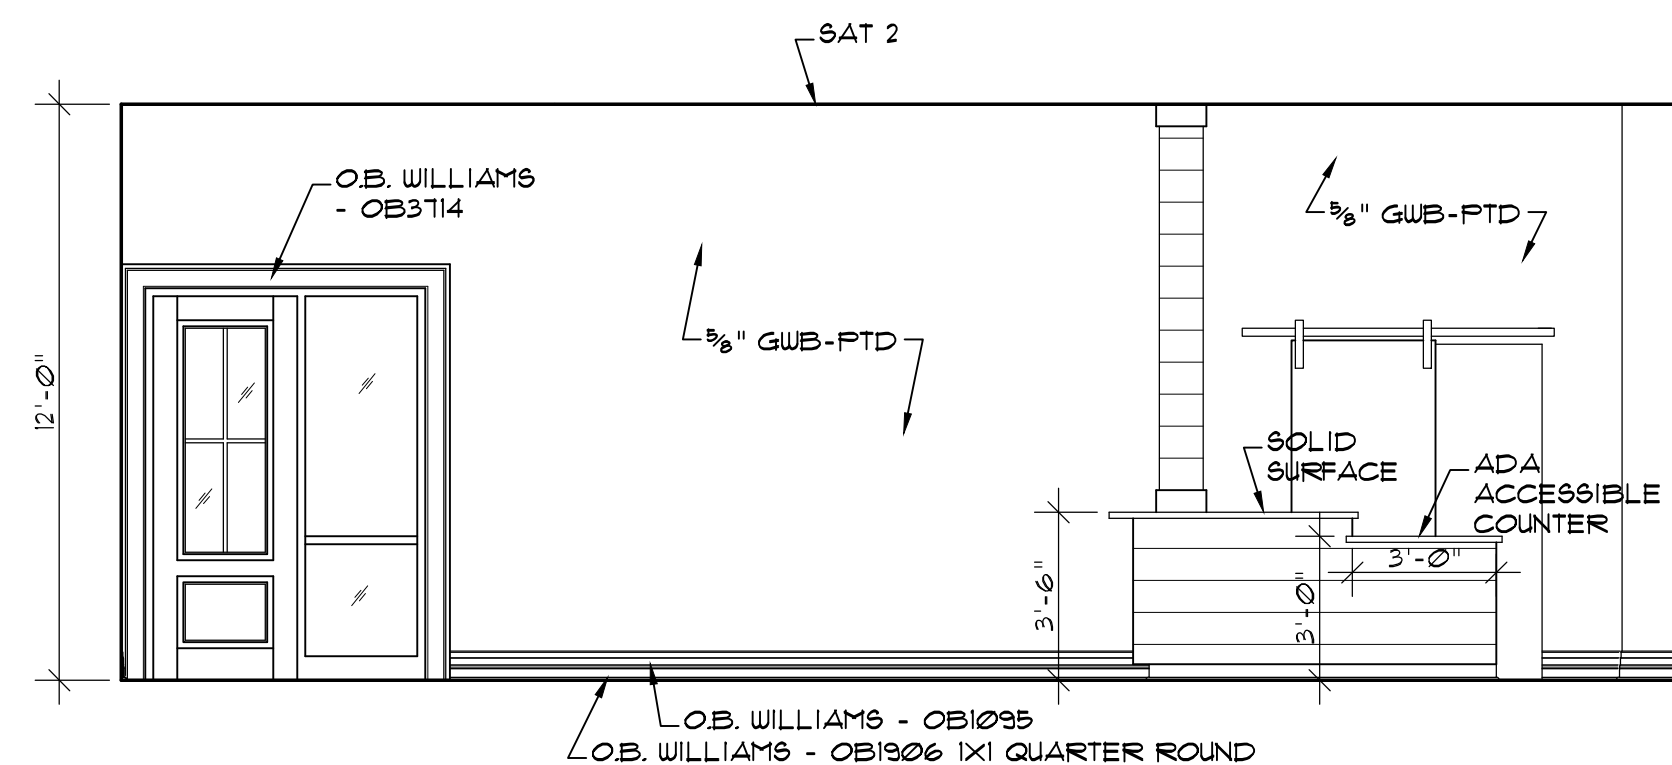


2 PRO SHOP ELEVATION
SCALE: 1/4"=1'-0"

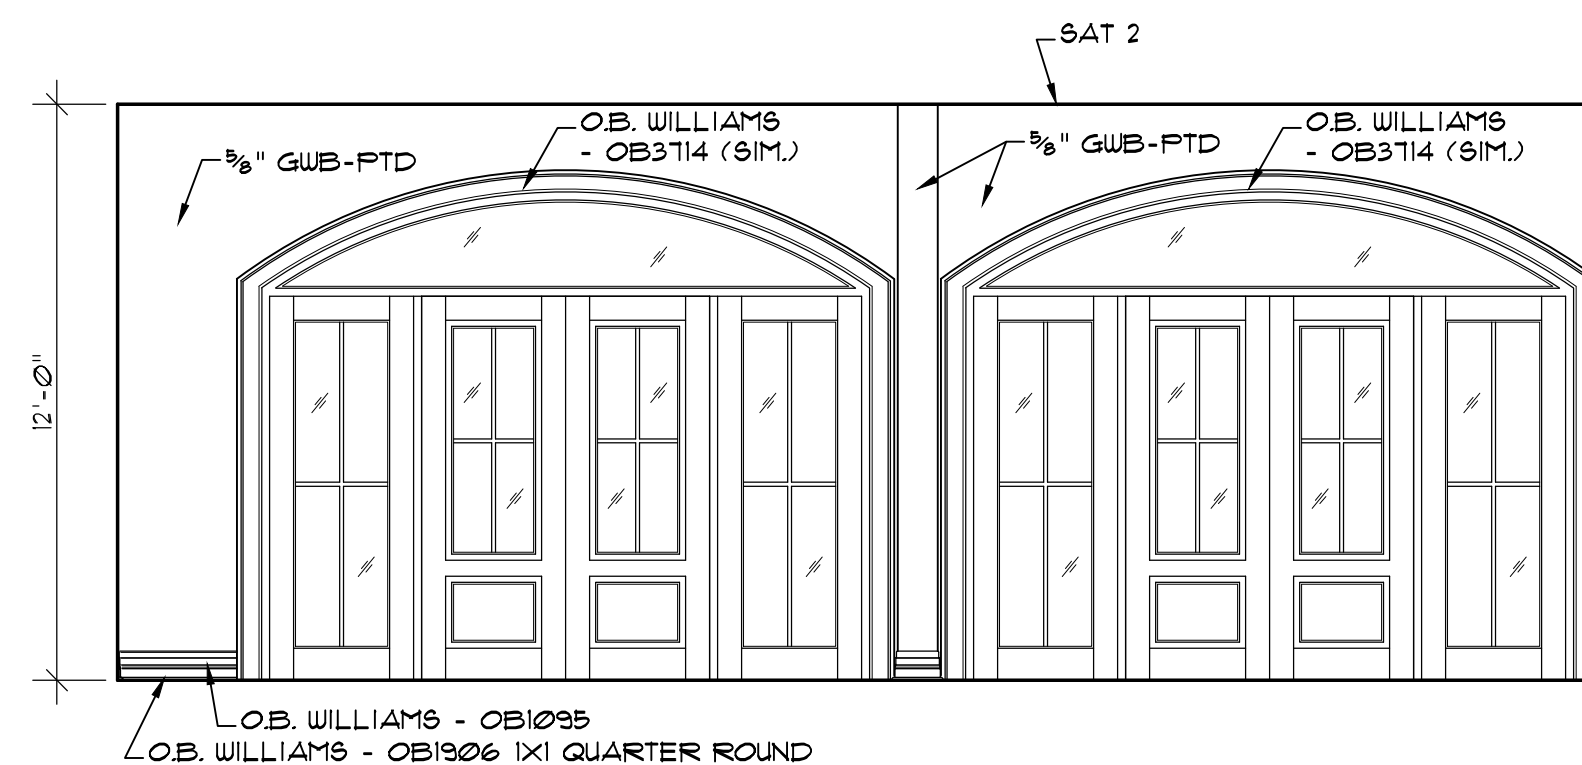


3 PRO SHOP ELEVATION
SCALE: 1/4"=1'-0"

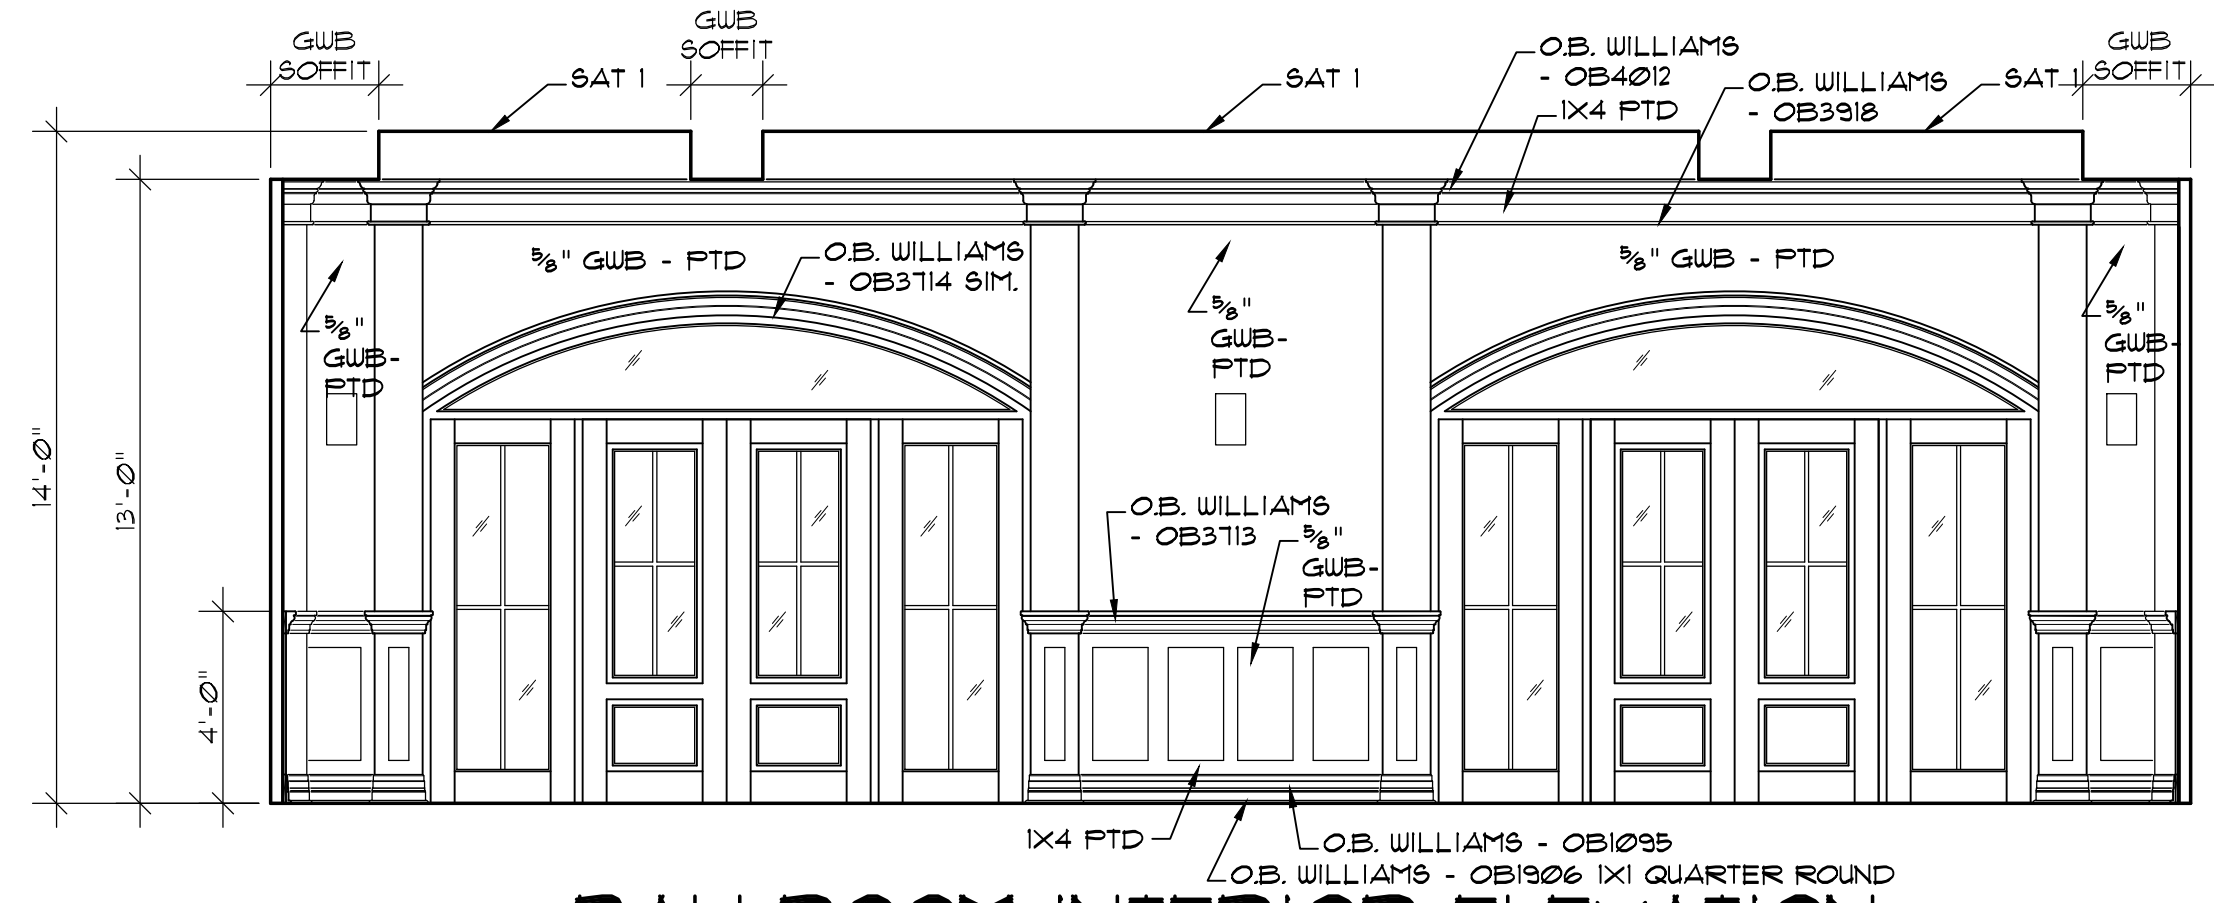


4 BALLROOM INTERIOR ELEVATION
SCALE: 1/4" = 1'-0"

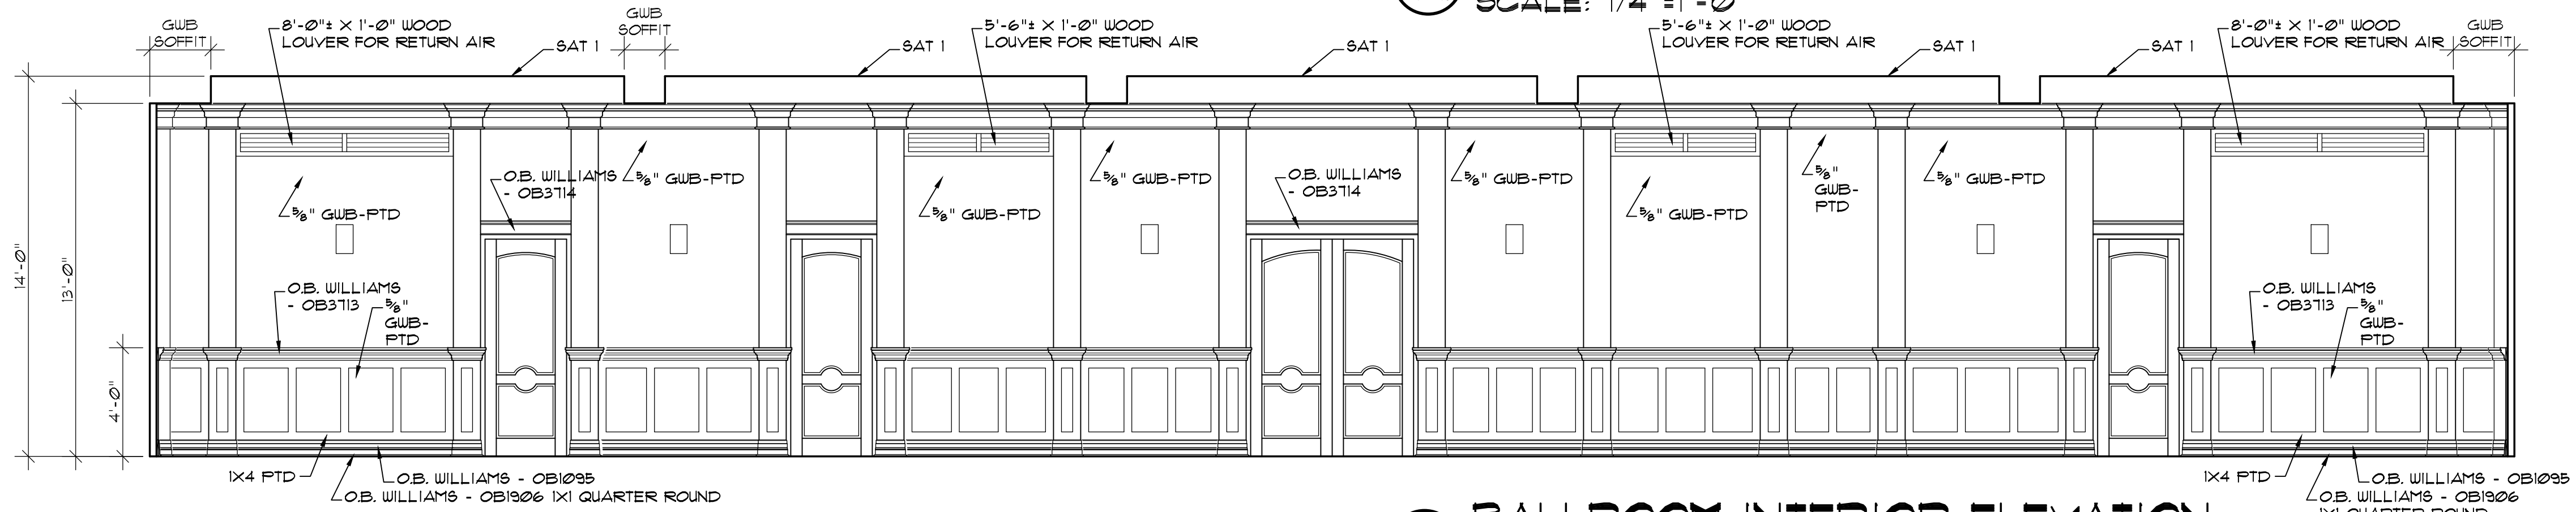


3 BALLROOM INTERIOR ELEVATION
SCALE: 1/4" = 1'-0"

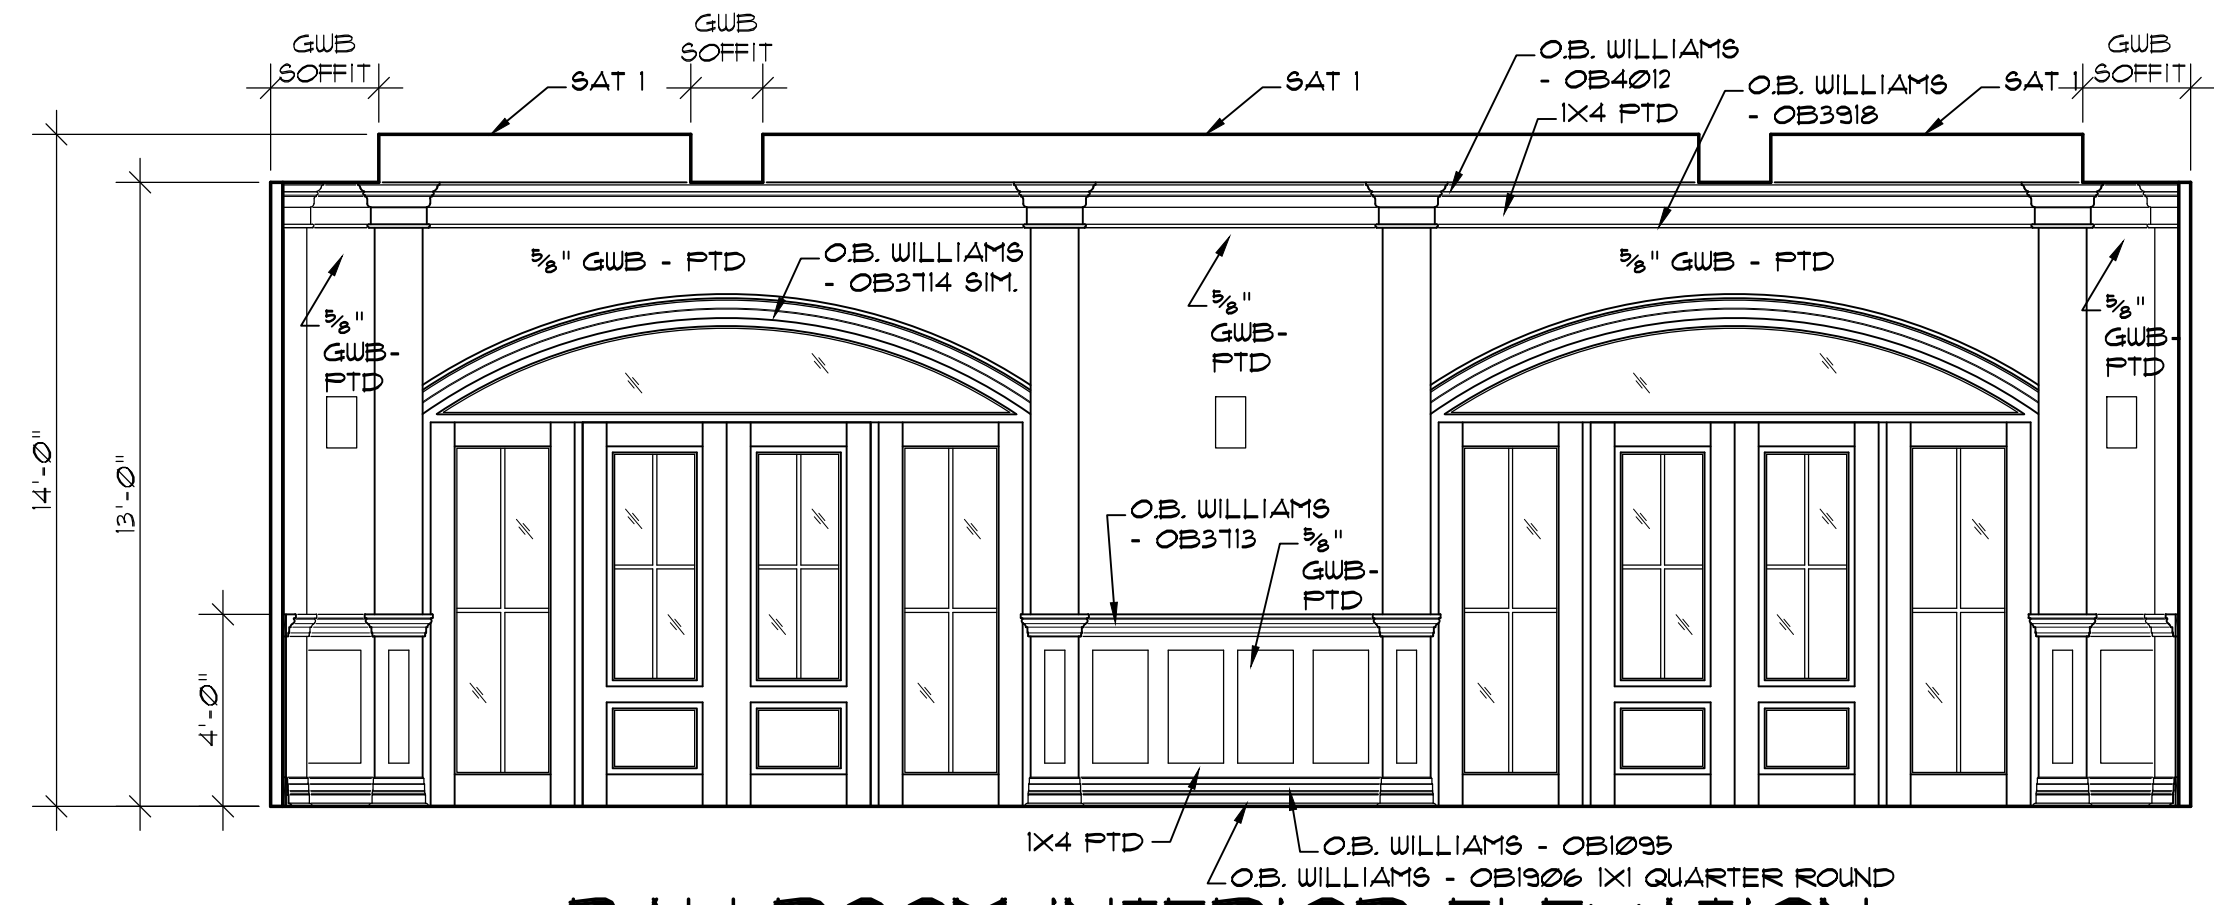


2 BALLROOM INTERIOR ELEVATION
SCALE: 1/4" = 1'-0"

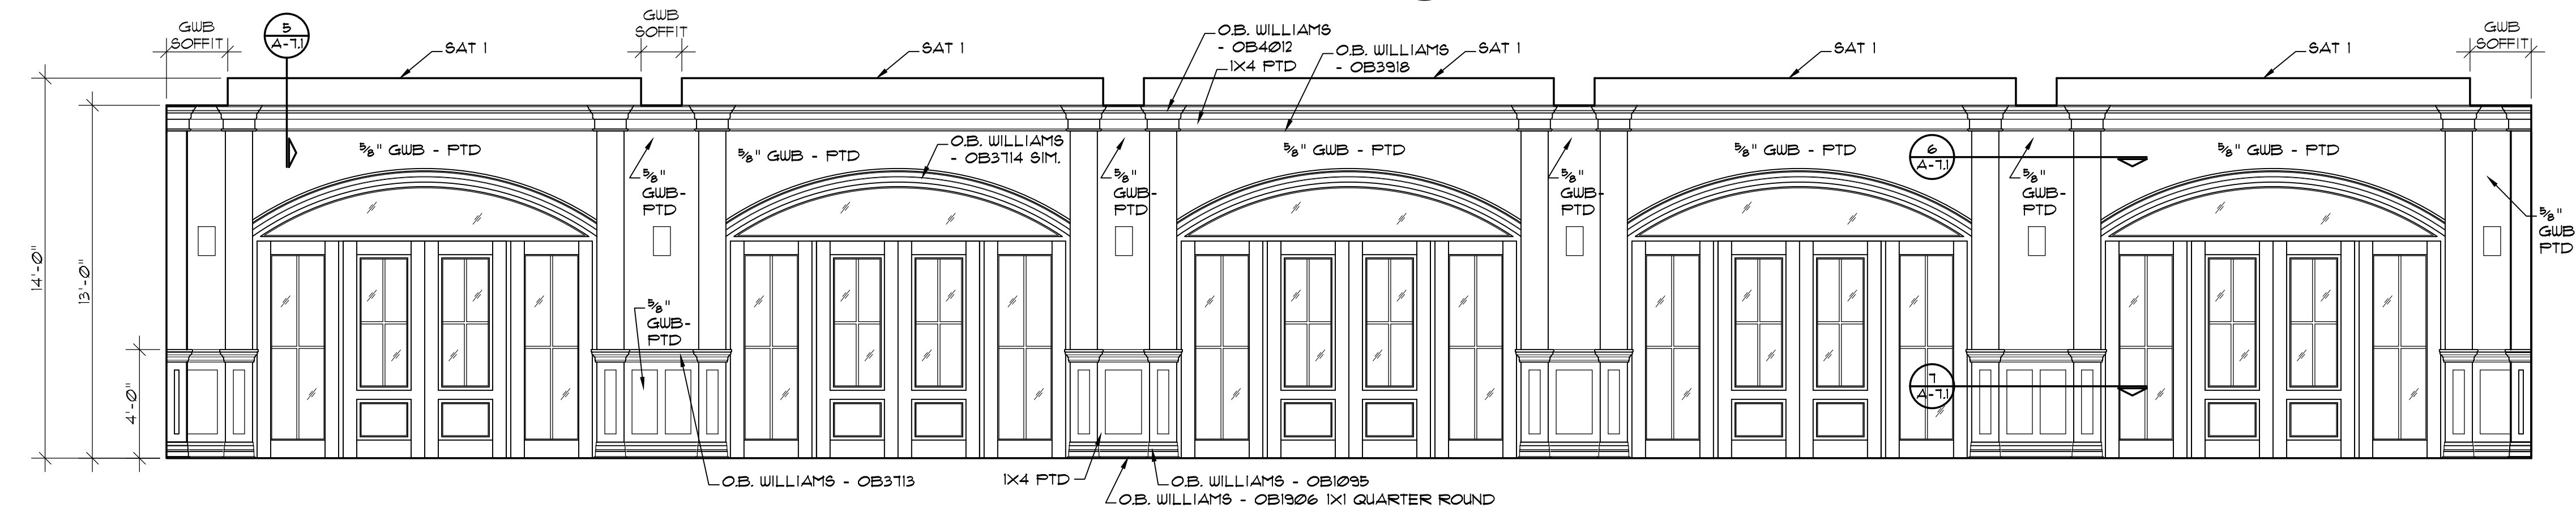


1 BALLROOM INTERIOR ELEVATION
SCALE: 1/4" = 1'-0"

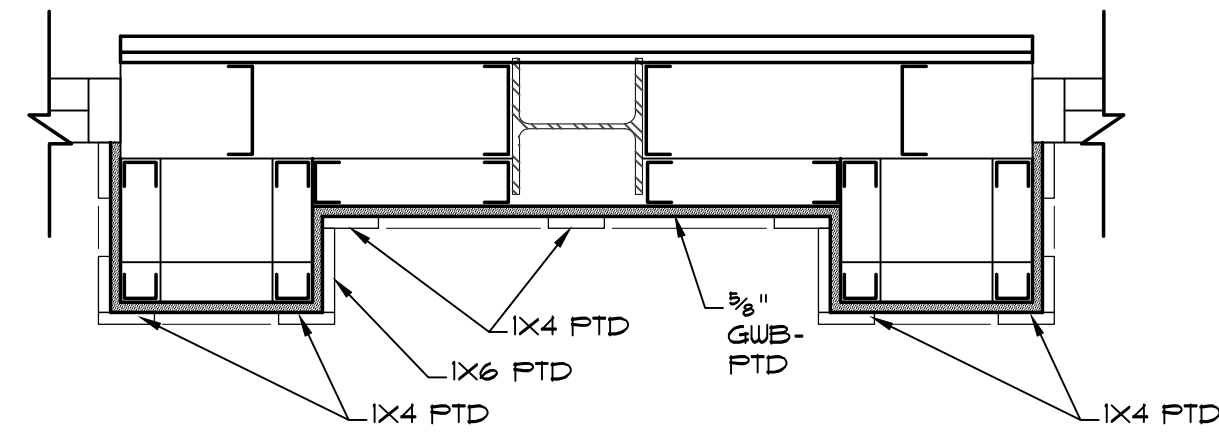

1 COLUMN BUMP DETAIL
SCALE: 1" = 1'-0"

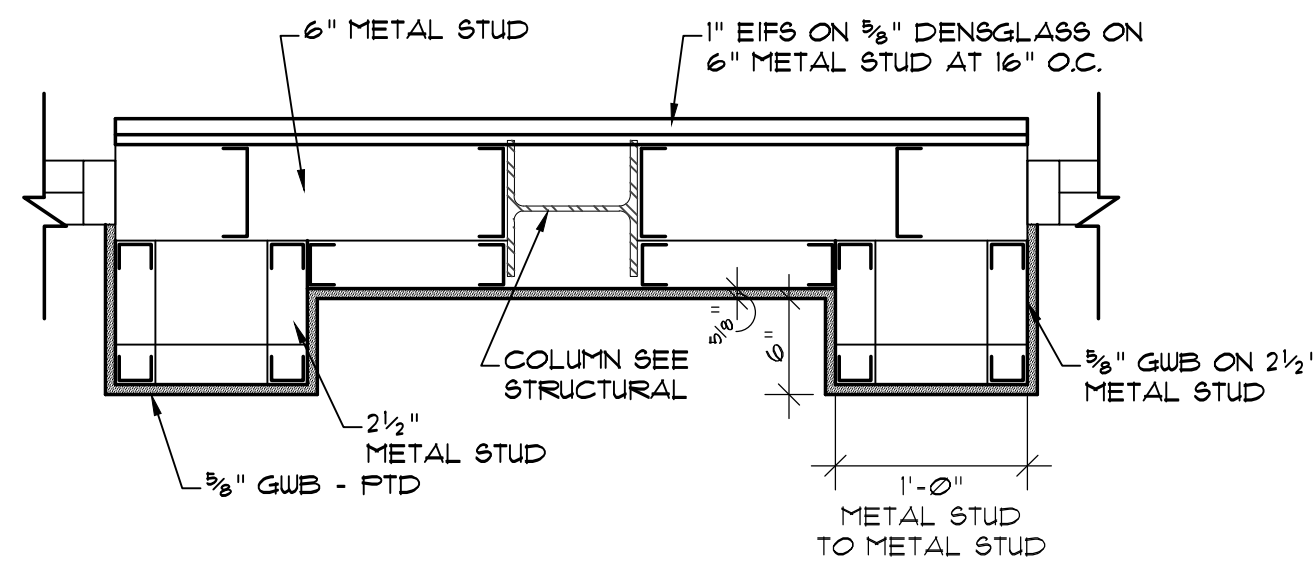


6 COLUMN BUMP DETAIL
SCALE: 1" = 1'-0"

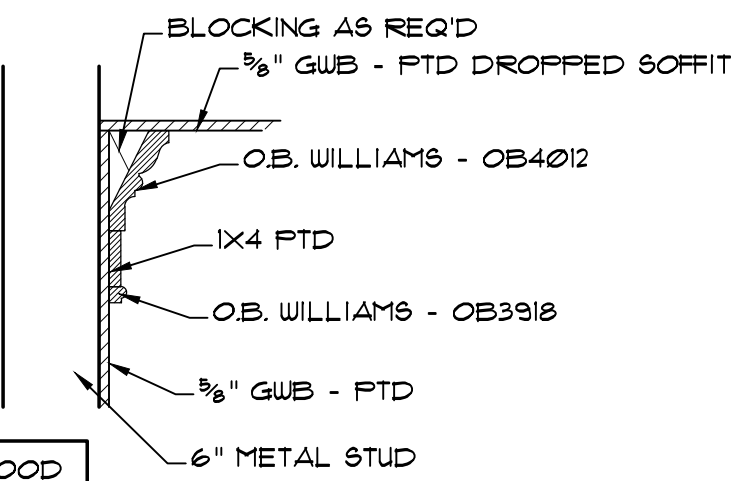


5 CROWN MOULDING DETAIL
SCALE: 1" = 1'-0"

NOTE: ALL TRIM TO BE POPLAR WOOD


NOTE: ALL TRIM TO BE POPLAR WOOD

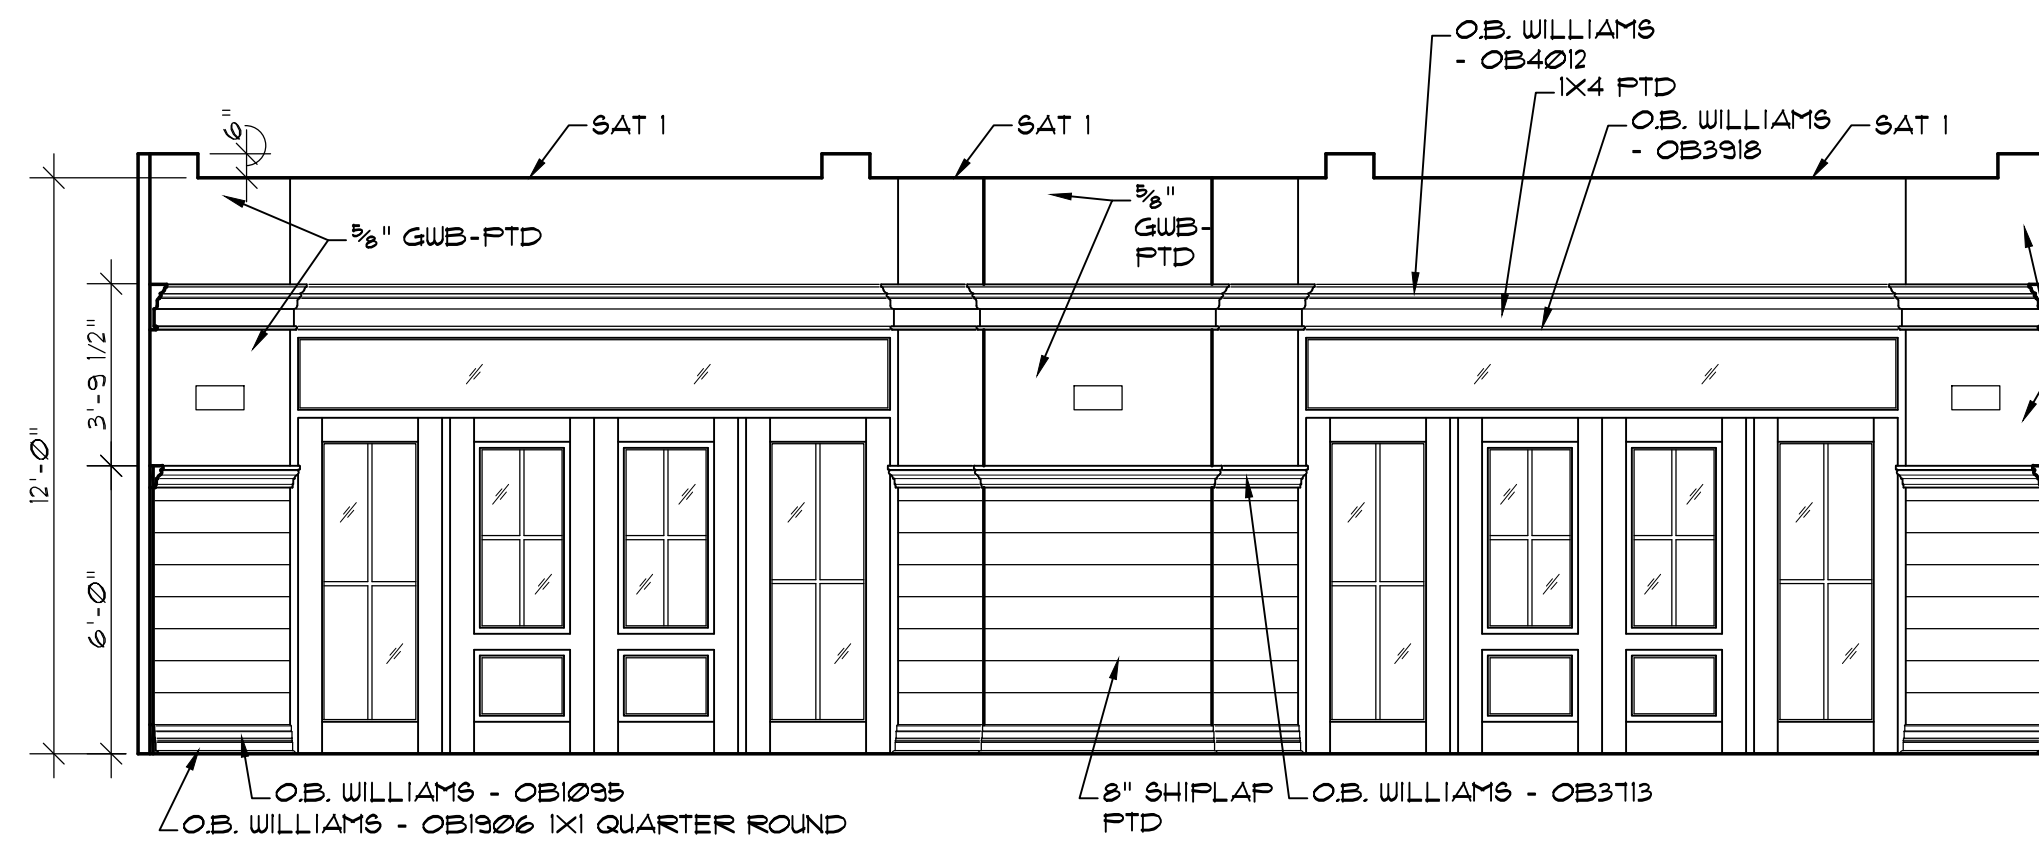


8 MEMBER BAR INTERIOR ELEVATION
A-7.2 SCALE: 1/4"=1'-0"

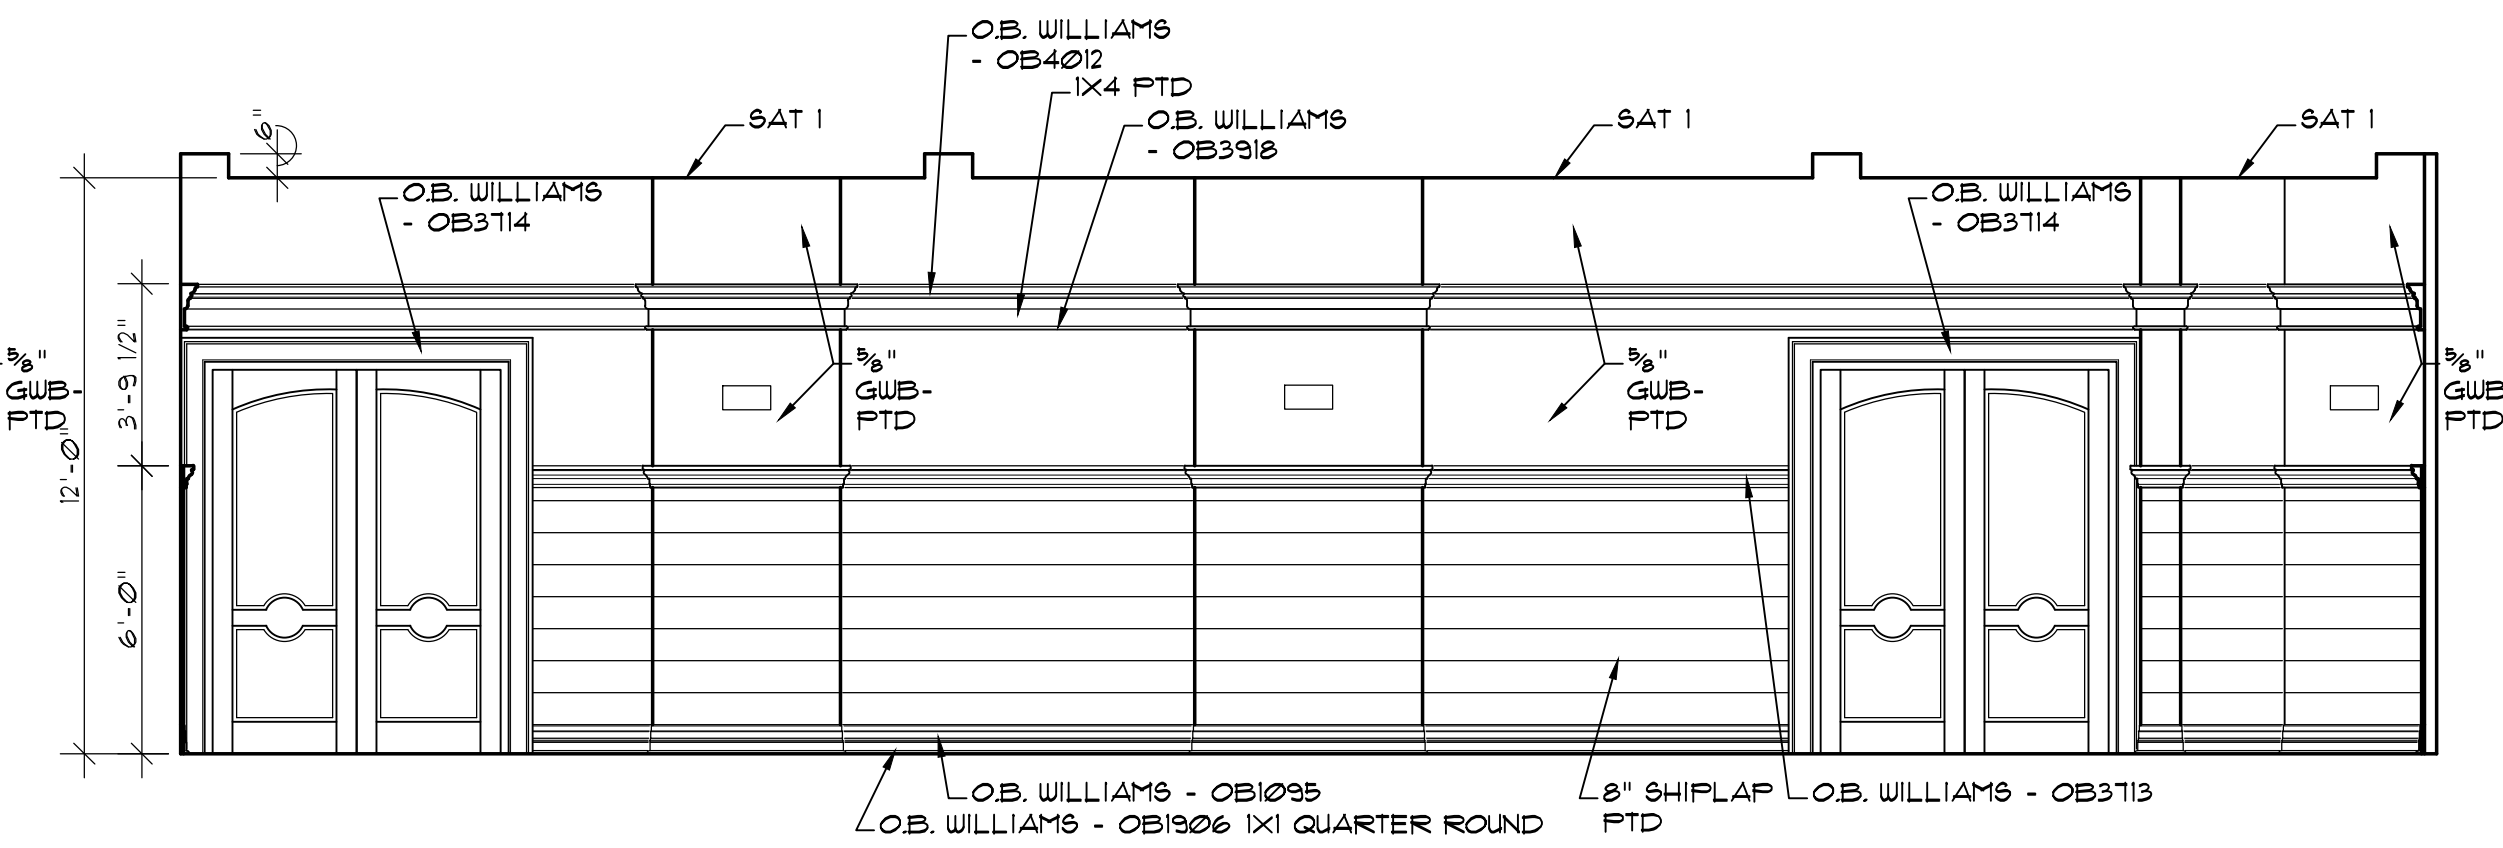


7 MEMBER BAR INTERIOR ELEVATION
A-7.2 SCALE: 1/4"=1'-0"

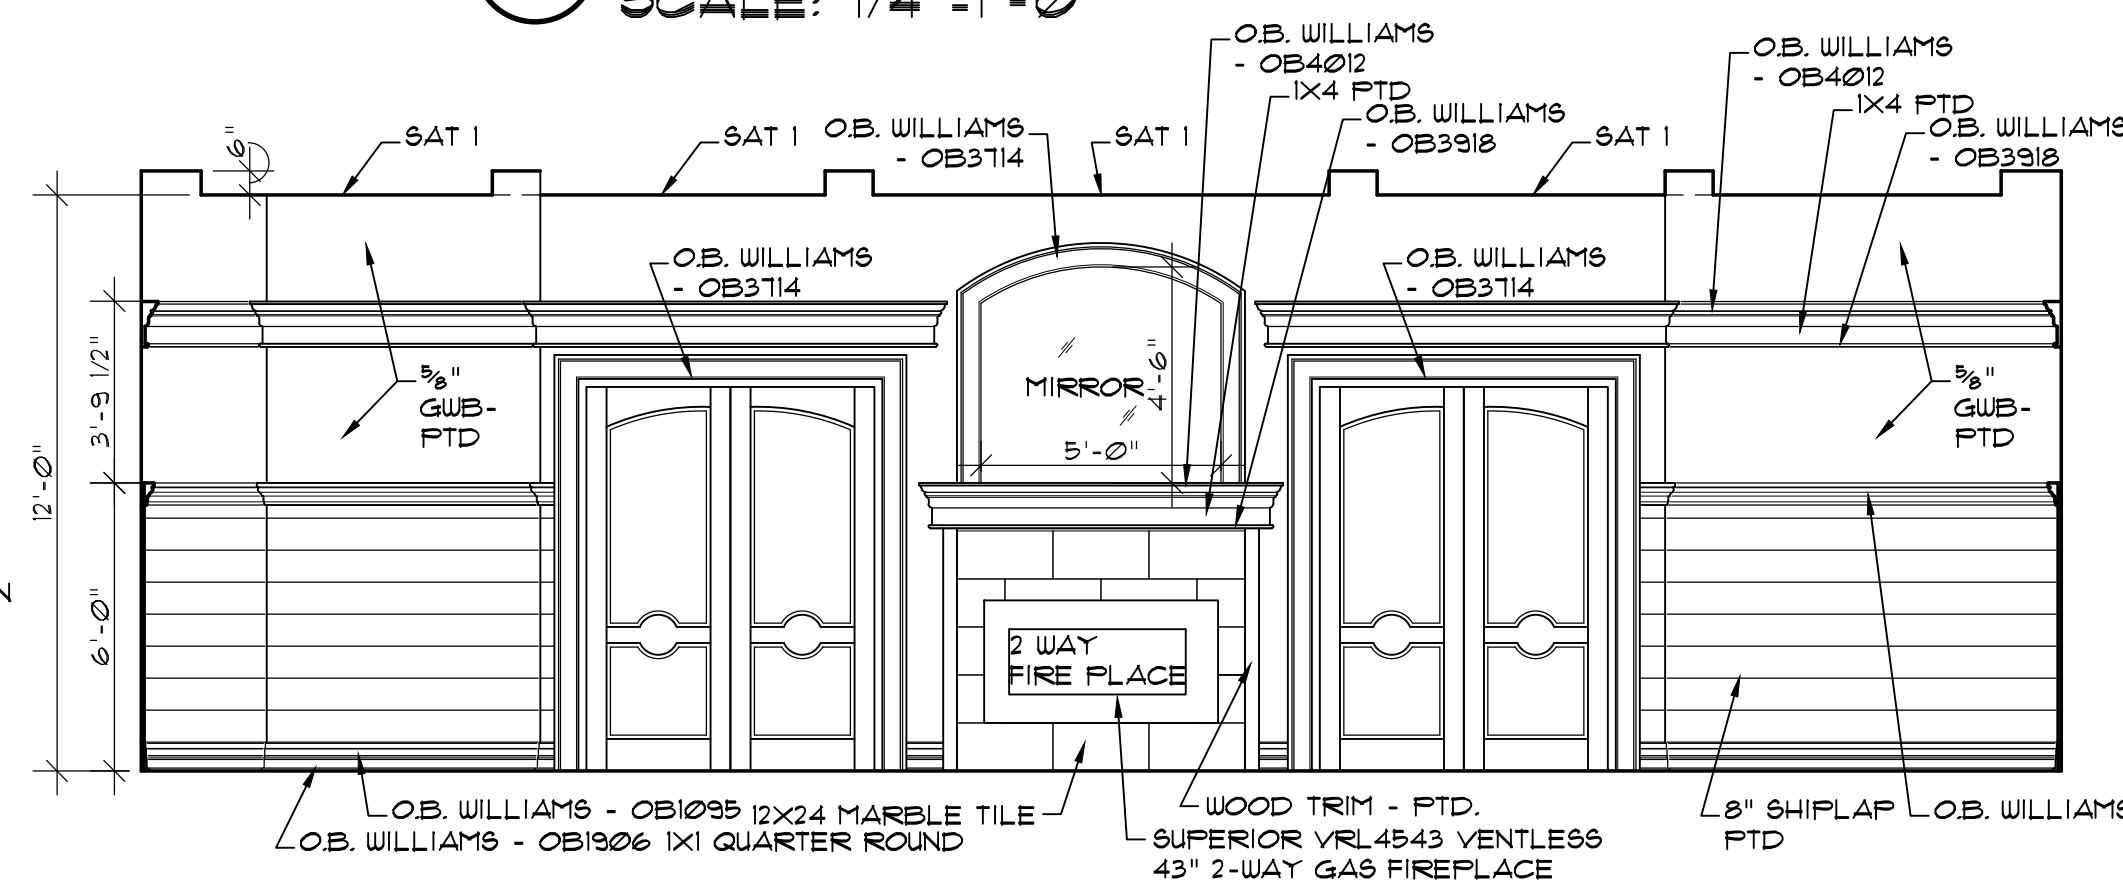


6 MEMBER BAR INTERIOR ELEVATION
A-7.2 SCALE: 1/4"=1'-0"

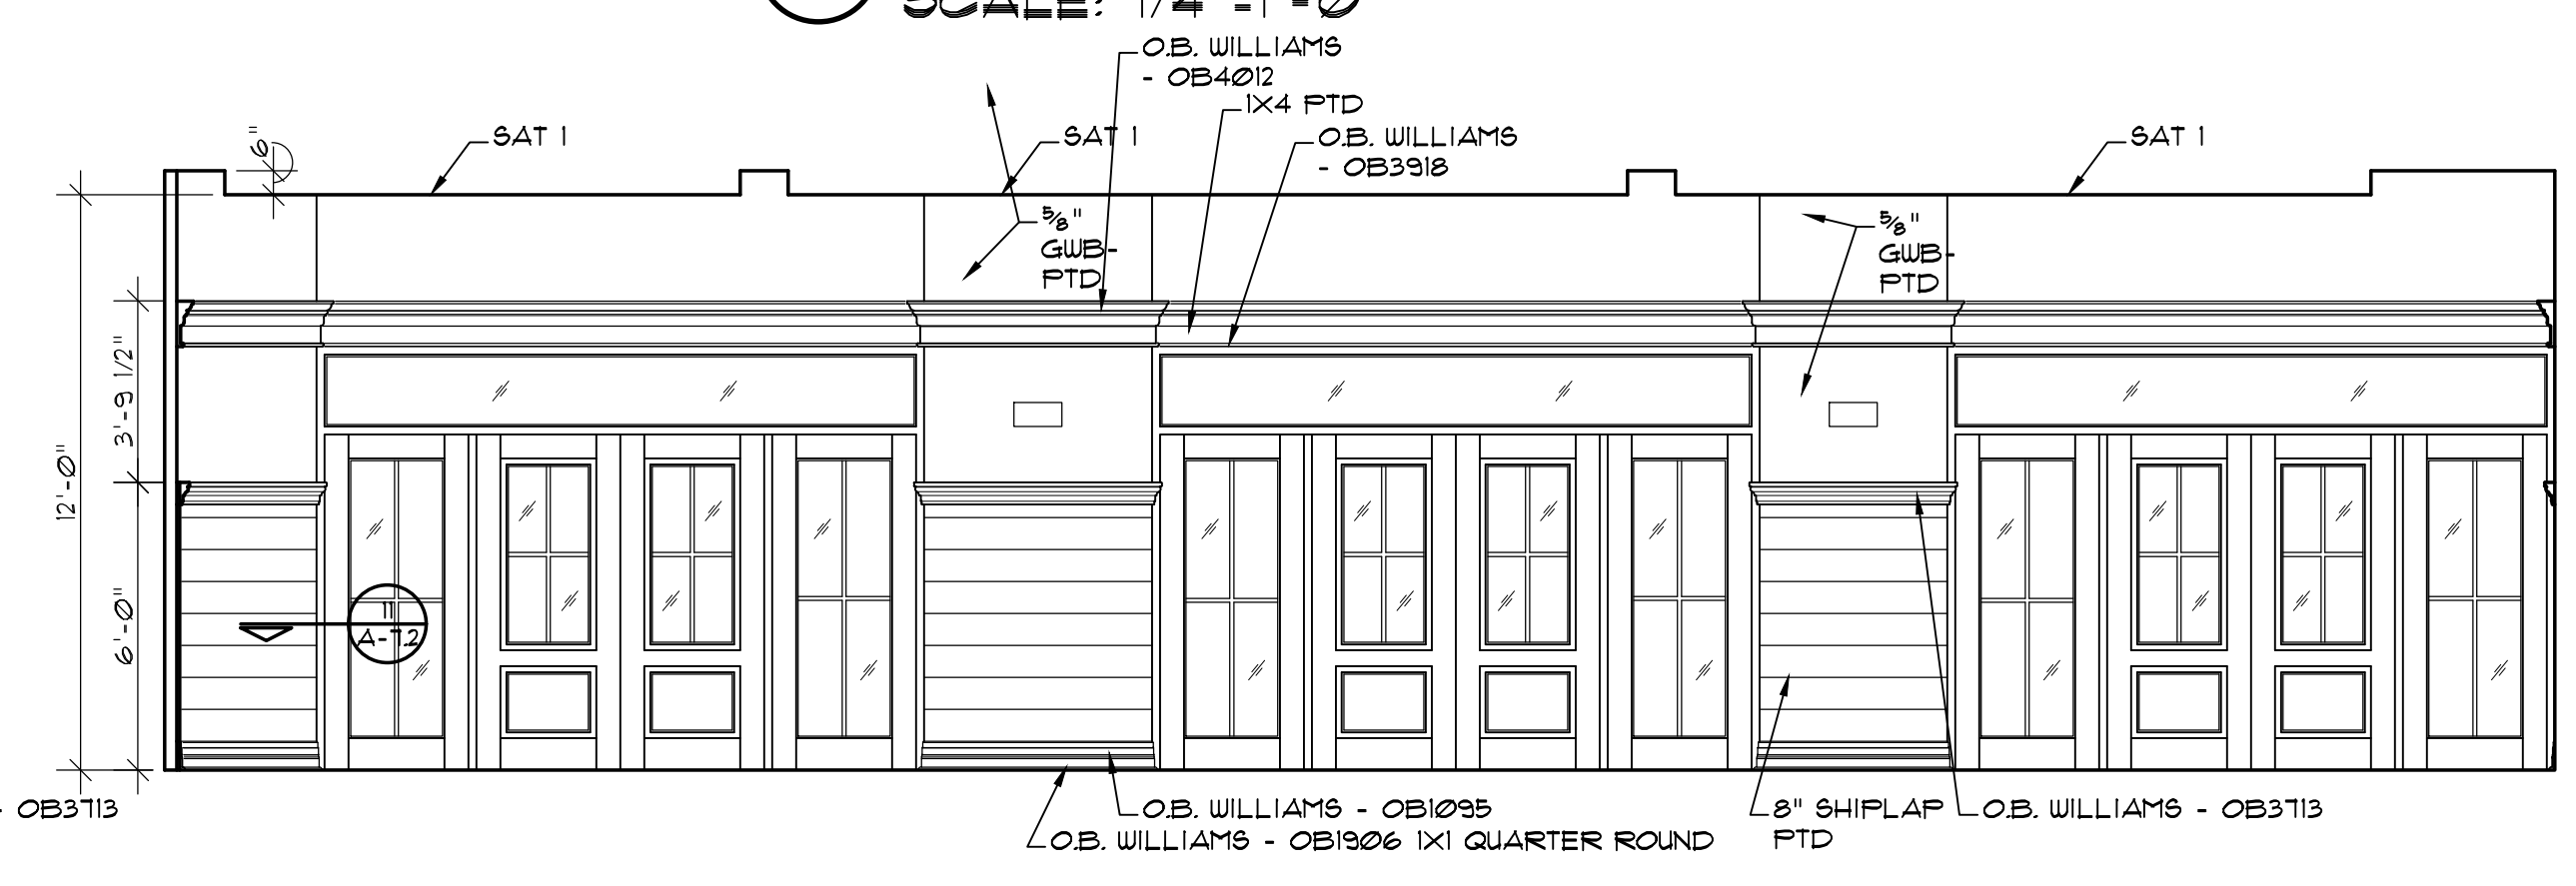


5 MEMBER BAR INTERIOR ELEVATION
A-7.2 SCALE: 1/4"=1'-0"

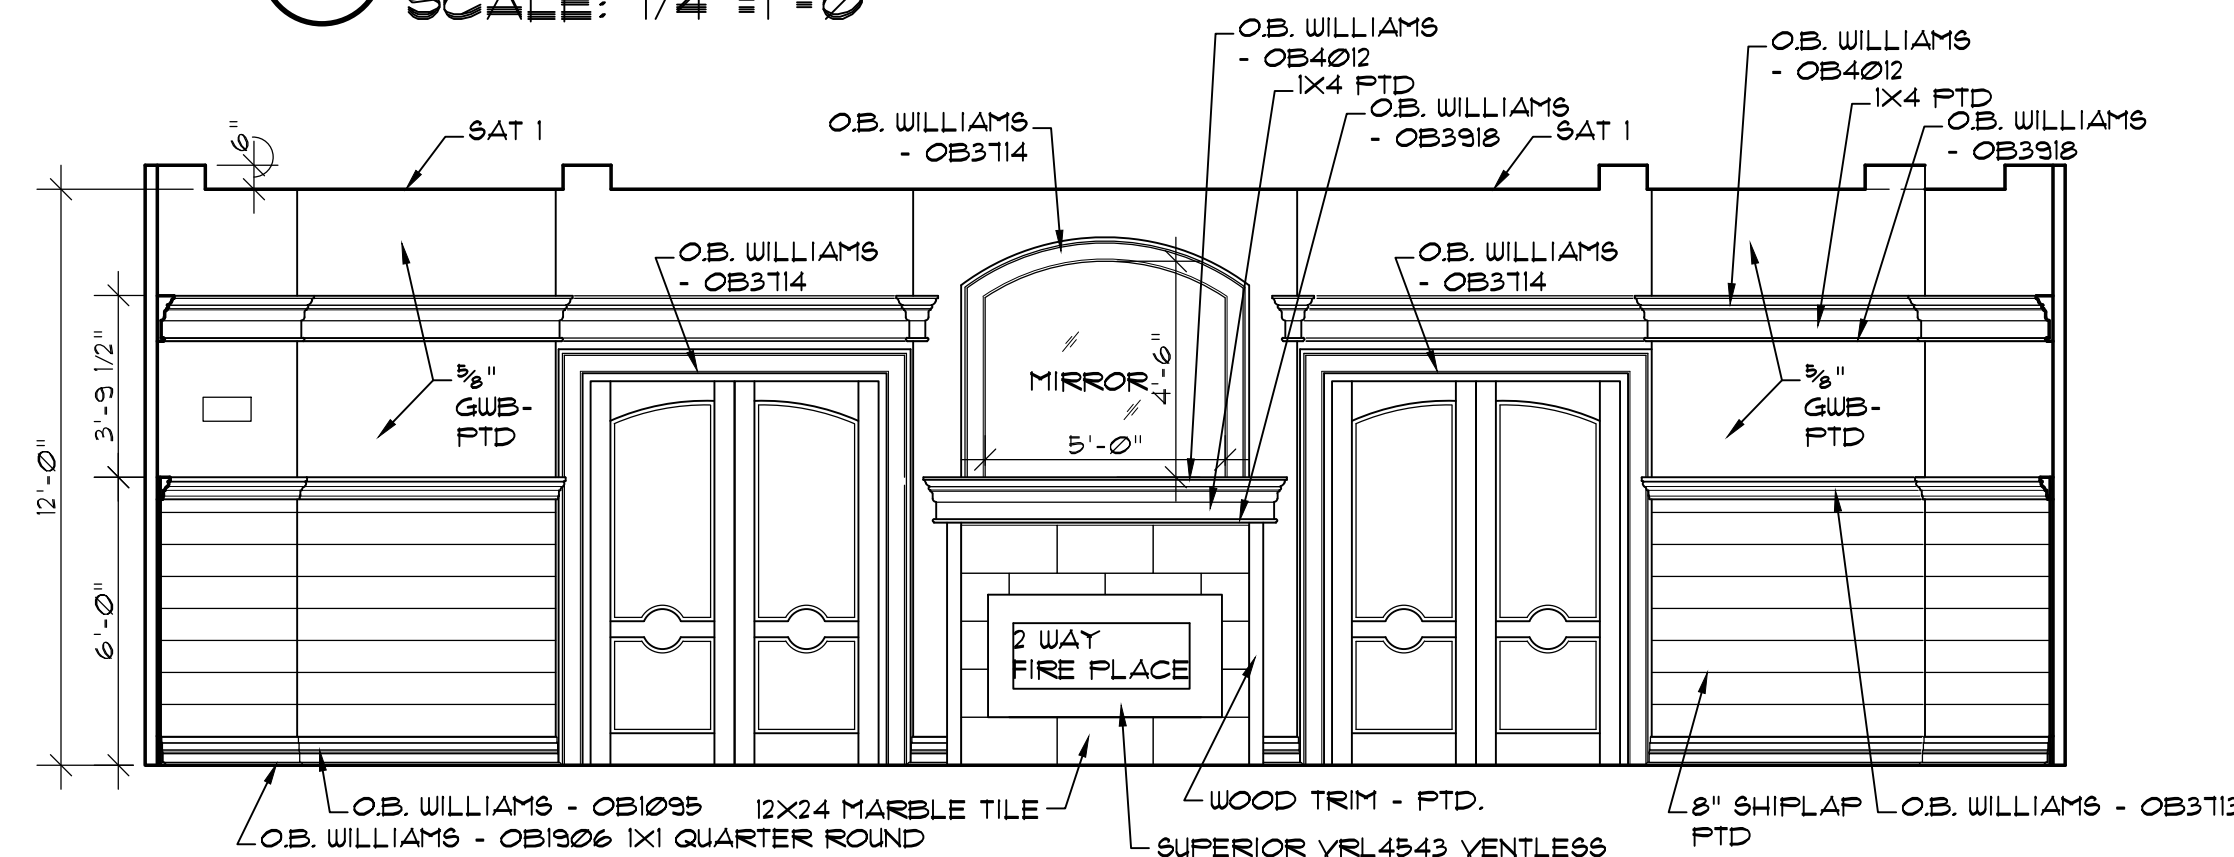


4 MEMBER LOUNGE INTERIOR ELEVATION
A-7.2 SCALE: 1/4"=1'-0"

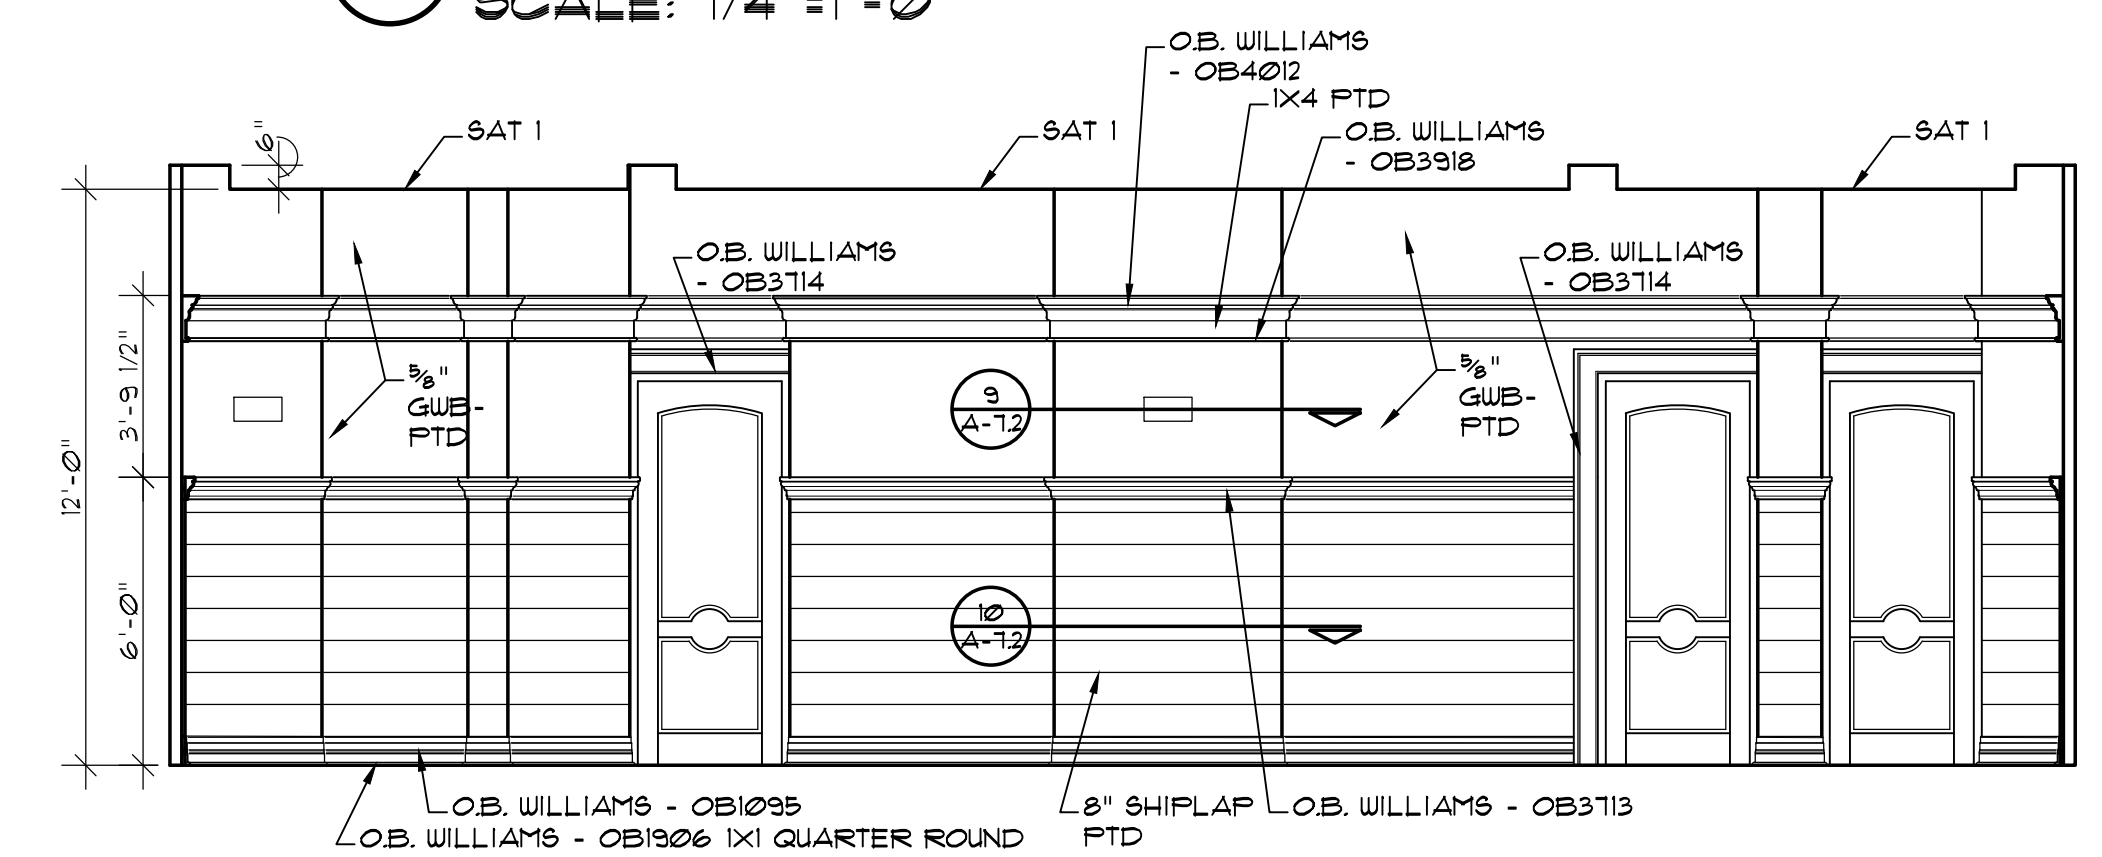


3 MEMBER LOUNGE INTERIOR ELEVATION
A-7.2 SCALE: 1/4"=1'-0"

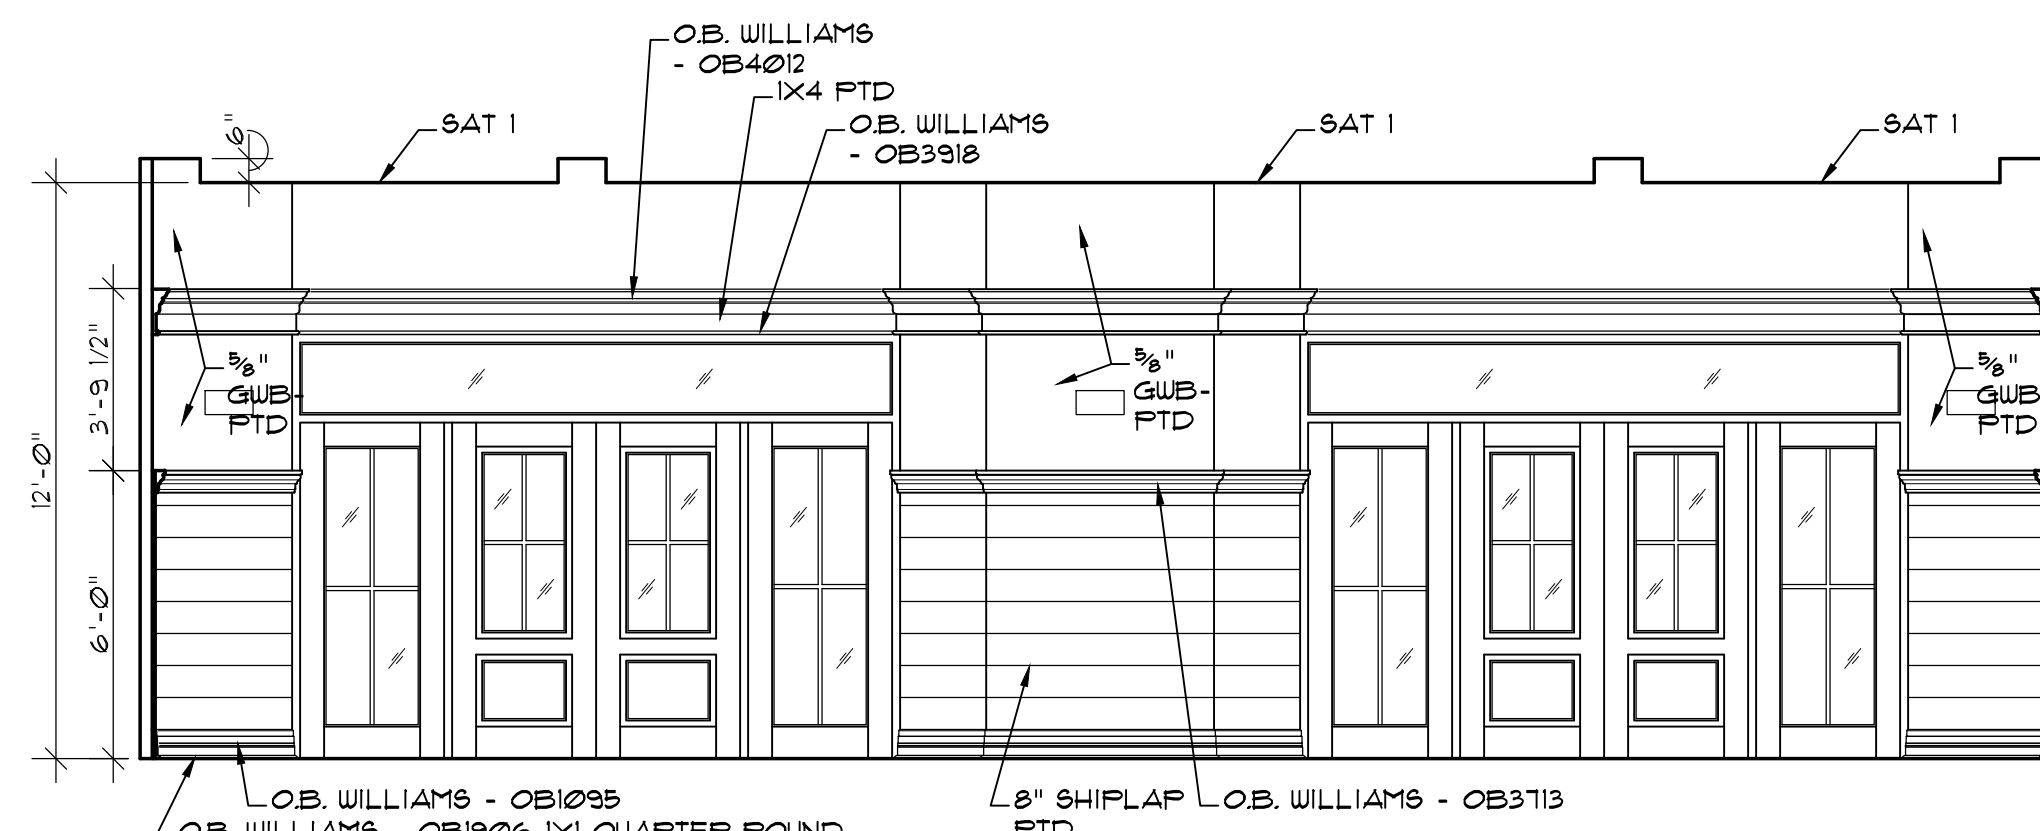


2 MEMBER LOUNGE INTERIOR ELEVATION
A-7.2 SCALE: 1/4"=1'-0"

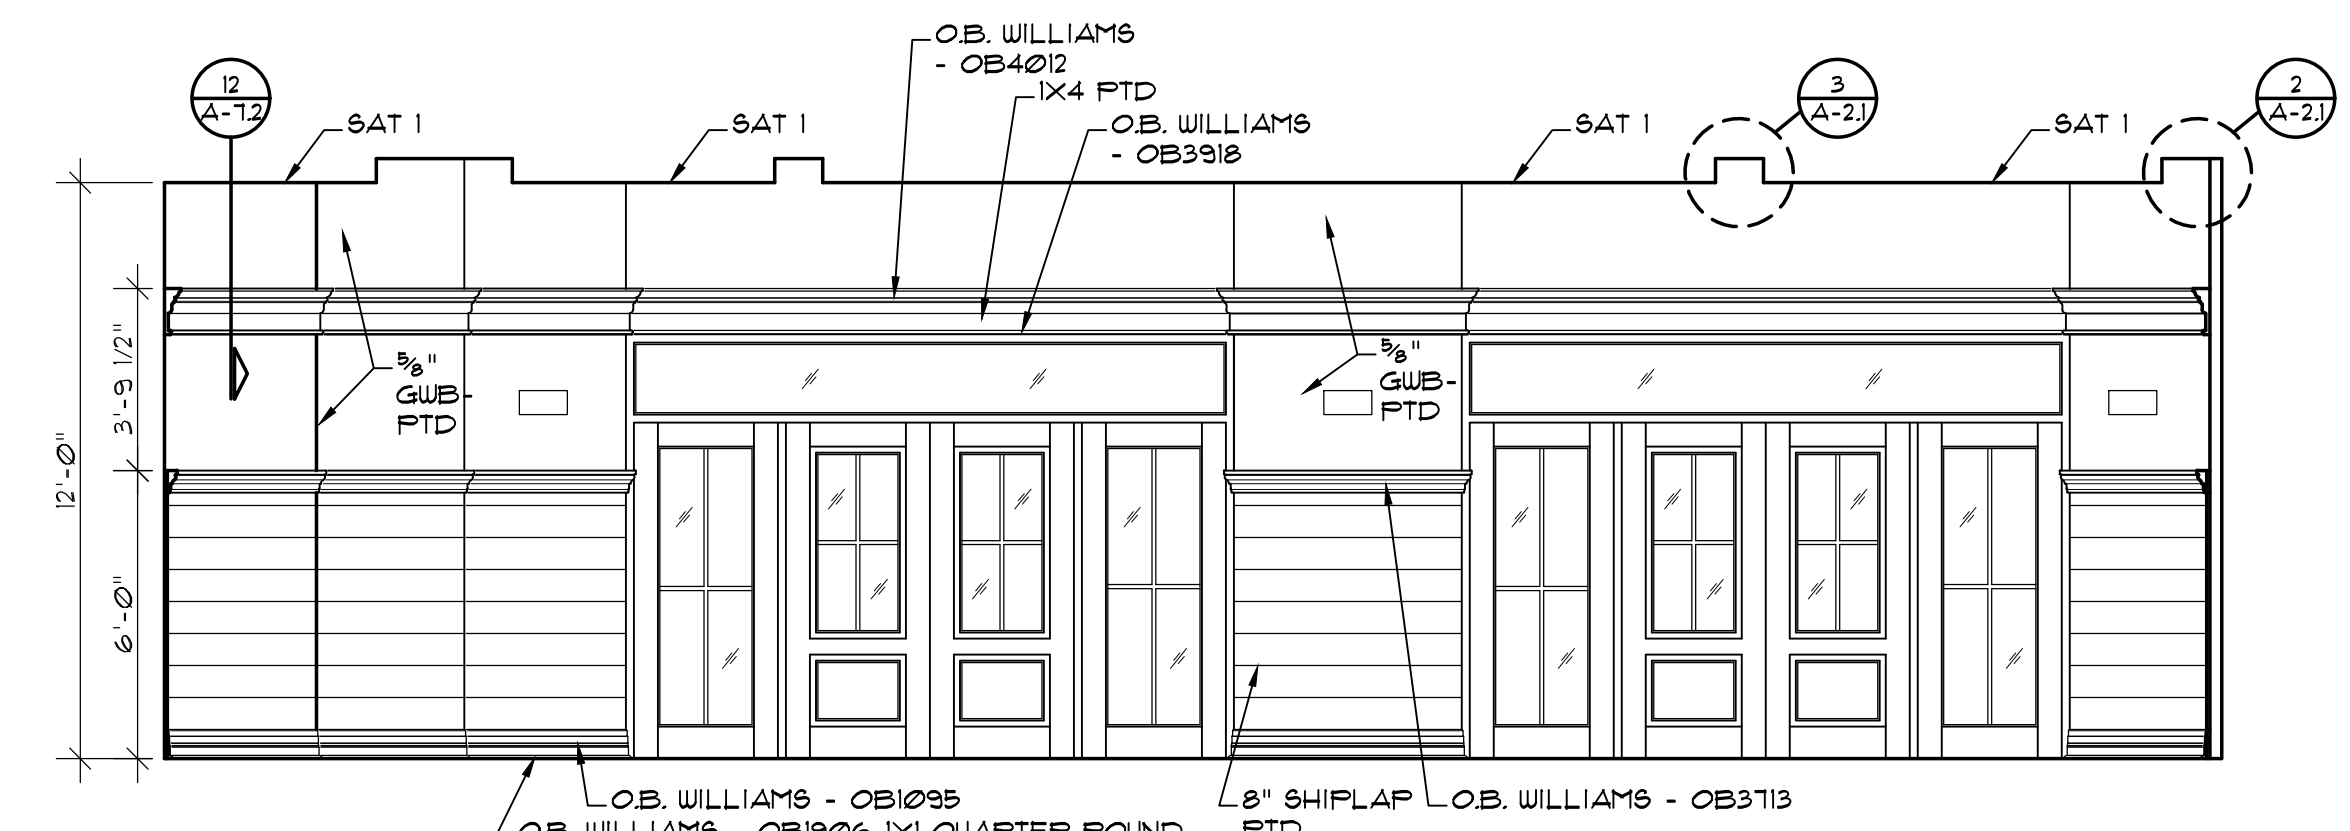


1 MEMBER LOUNGE INTERIOR ELEVATION
A-7.2 SCALE: 1/4"=1'-0"

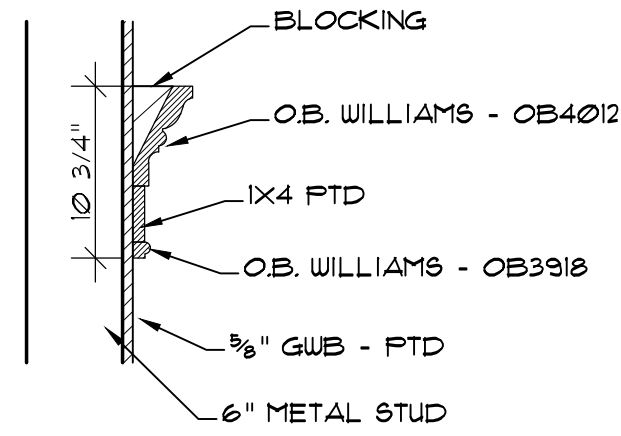


12 MOULDING DETAIL
A-7.2 SCALE: 1"=1'-0"

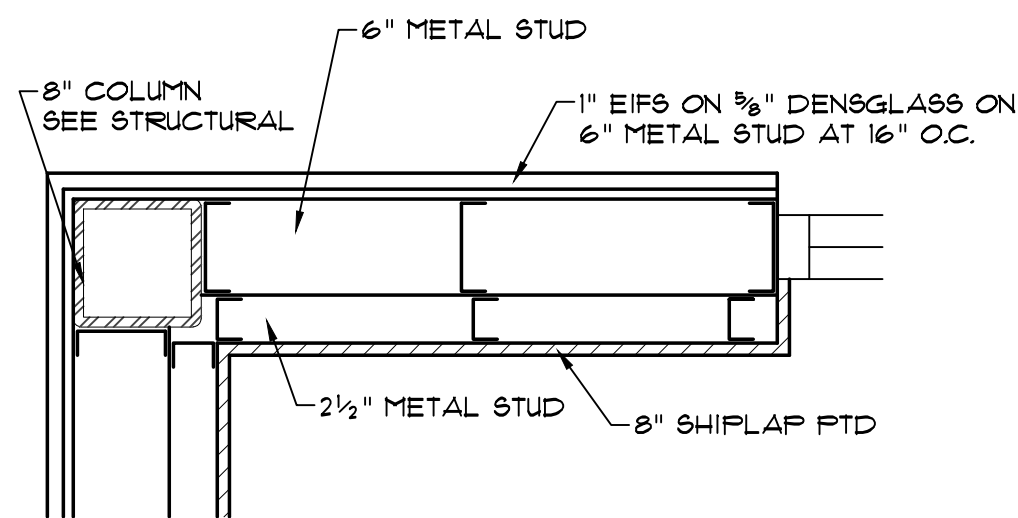

11 DETAIL
A-7.2 SCALE: 1"=1'-0"

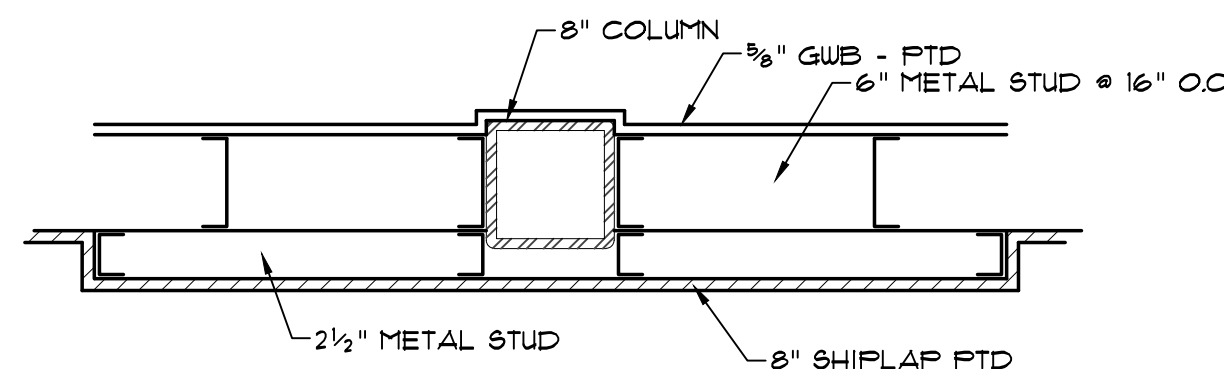


10 DETAIL @ SHIPLAP
A-7.2 SCALE: 1"=1'-0"

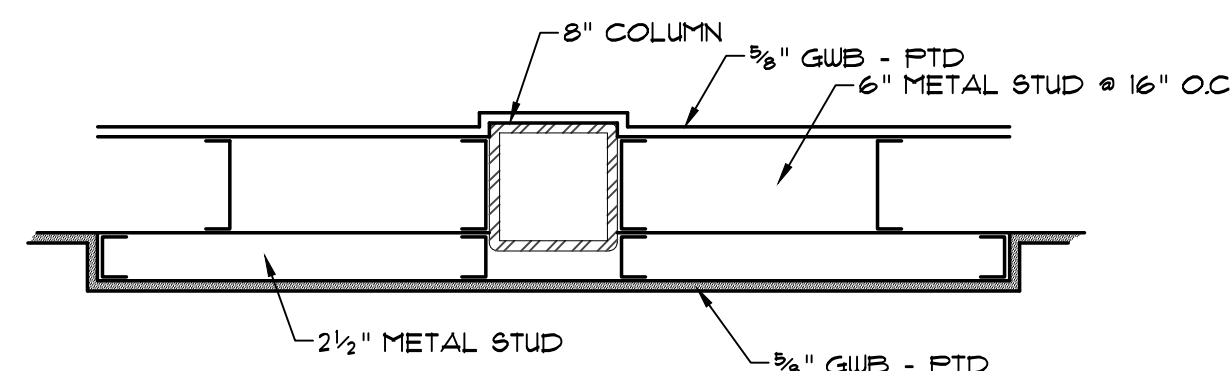


9 DETAIL @ GUB
A-7.2 SCALE: 1"=1'-0"


NOTE: ALL TRIM TO BE POPLAR WOOD

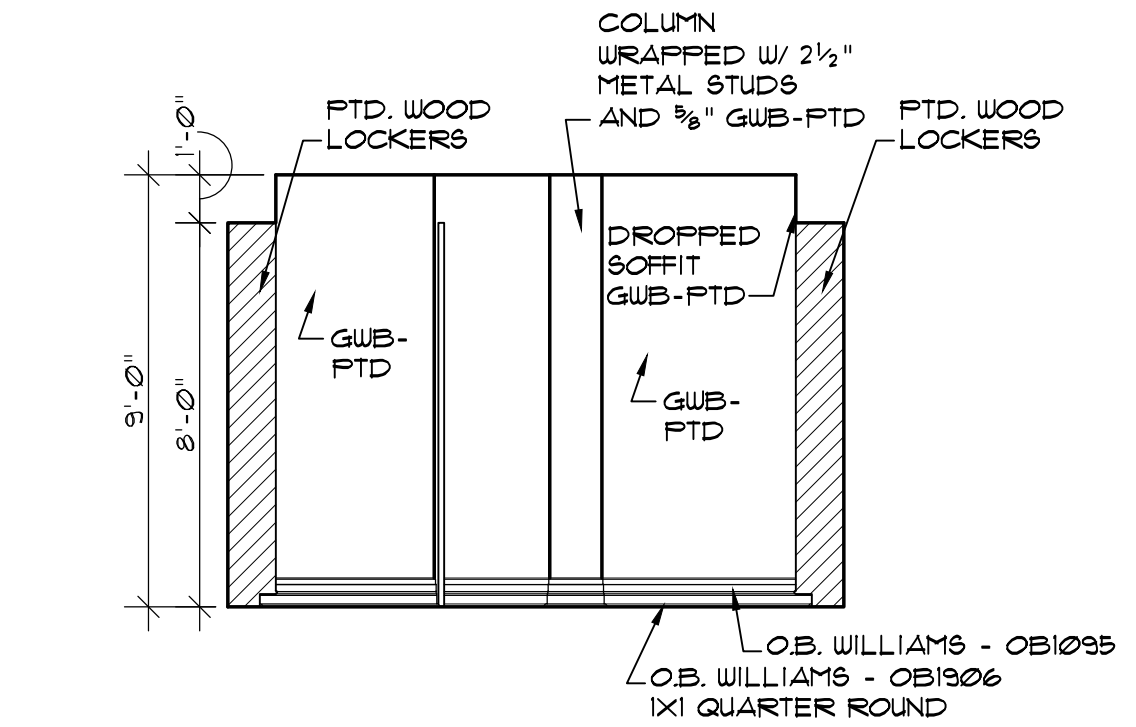


20 MEN LOCKER ROOM 209
A-7.3 SCALE: 1/4" = 1'-0"

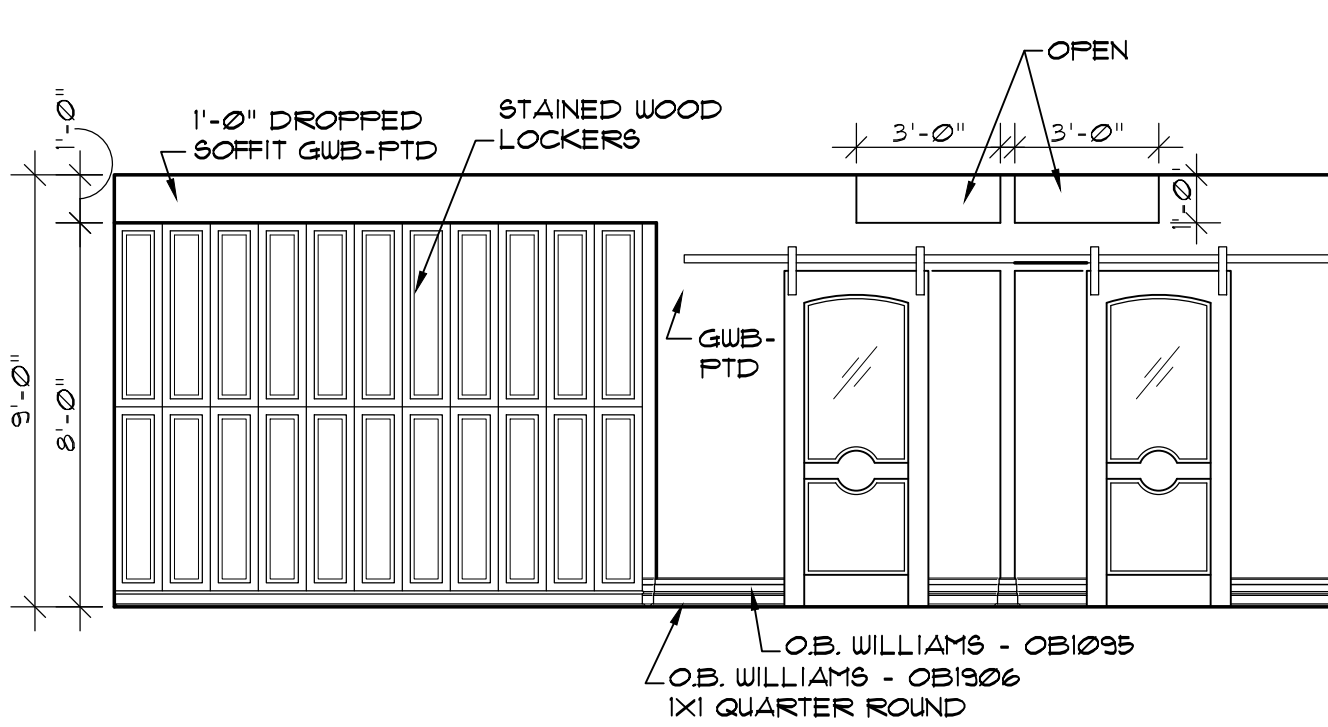


19 MEN LOCKER ROOM 209
A-7.3 SCALE: 1/4" = 1'-0"

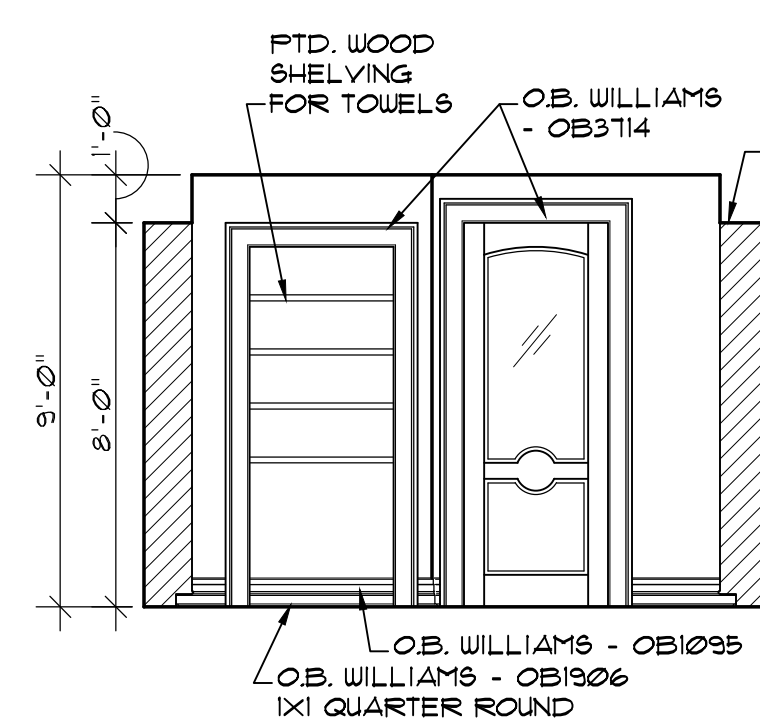


18 MEN LOCKER ROOM 209
A-7.3 SCALE: 1/4" = 1'-0"

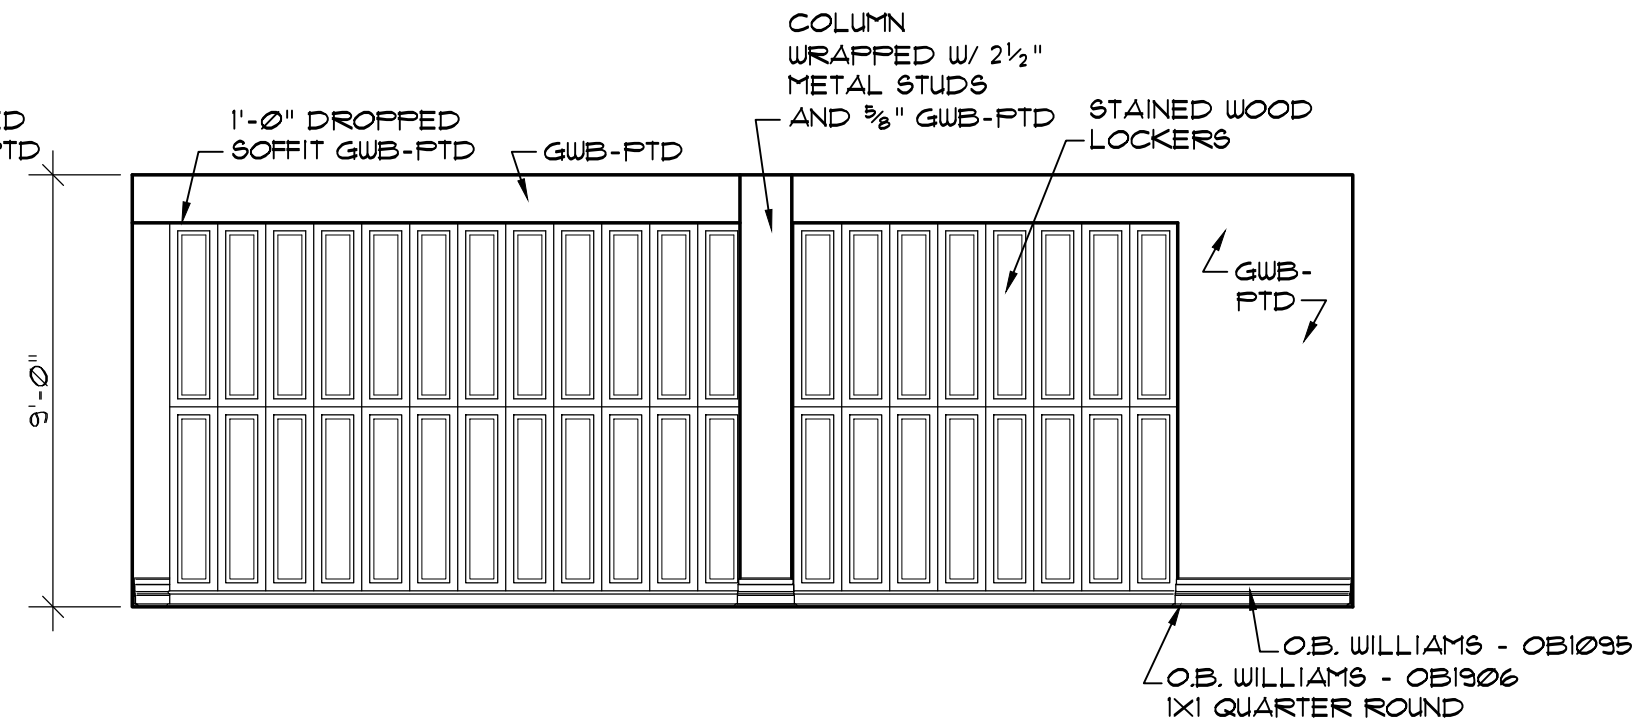



17 MEN LOCKER ROOM 209
A-7.3 SCALE: 1/4" = 1'-0"

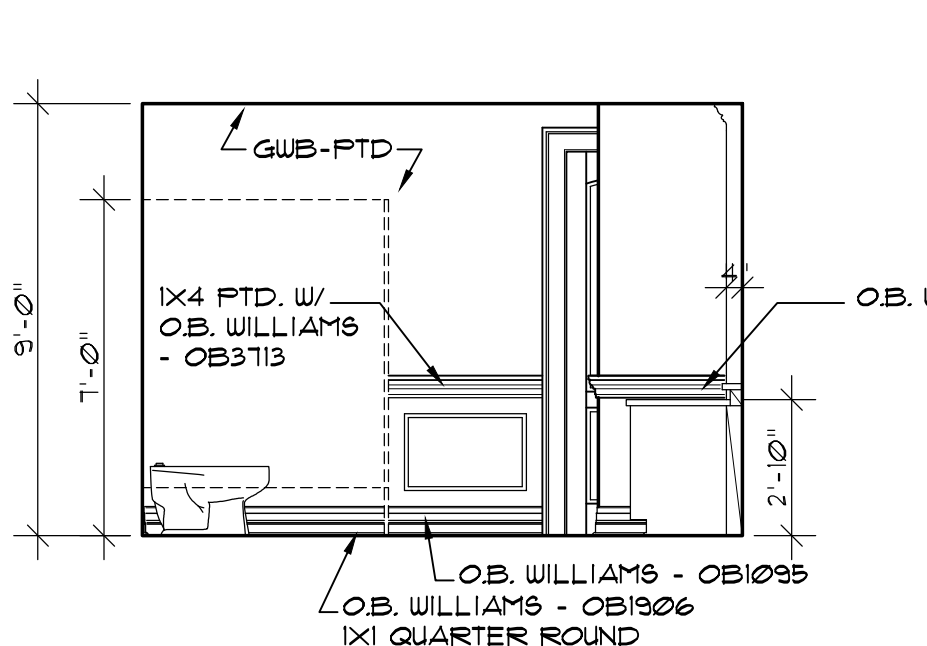


16 WOMEN TOILET 208
A-7.3 SCALE: 1/4" = 1'-0"

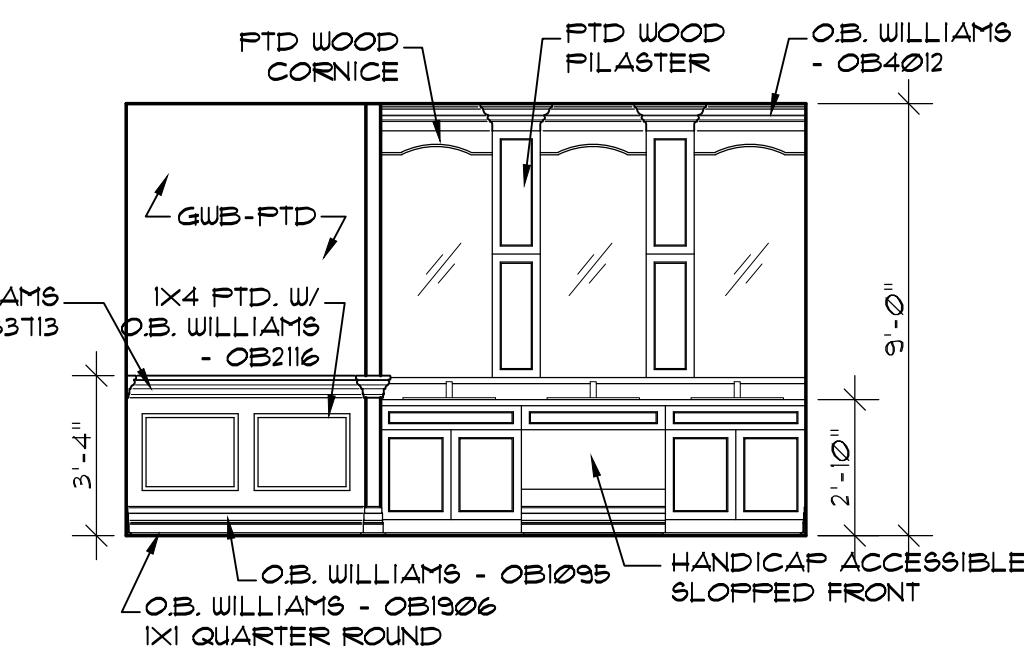


15 WOMEN TOILET 208
A-7.3 SCALE: 1/4" = 1'-0"

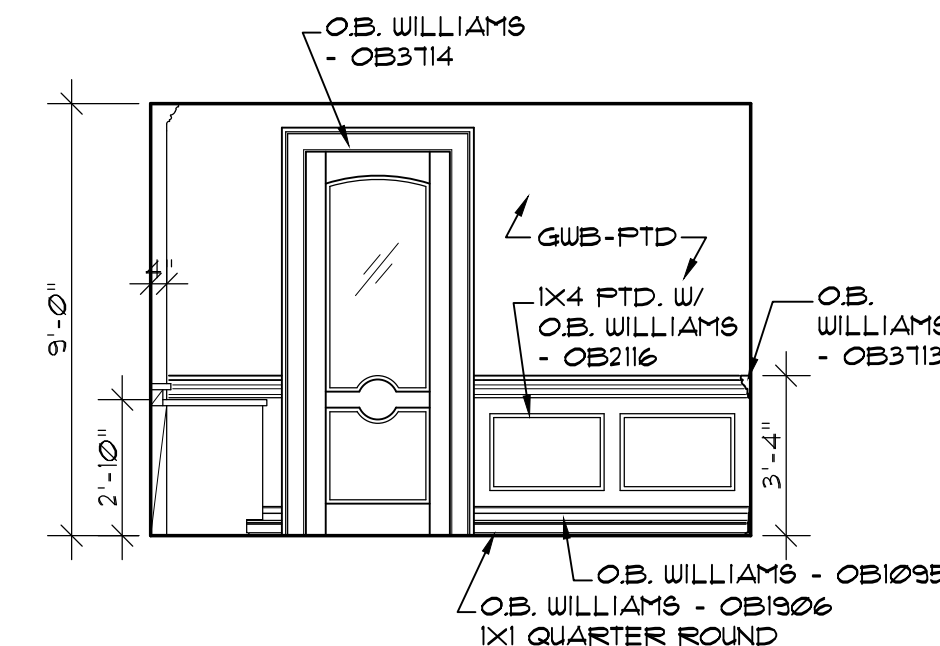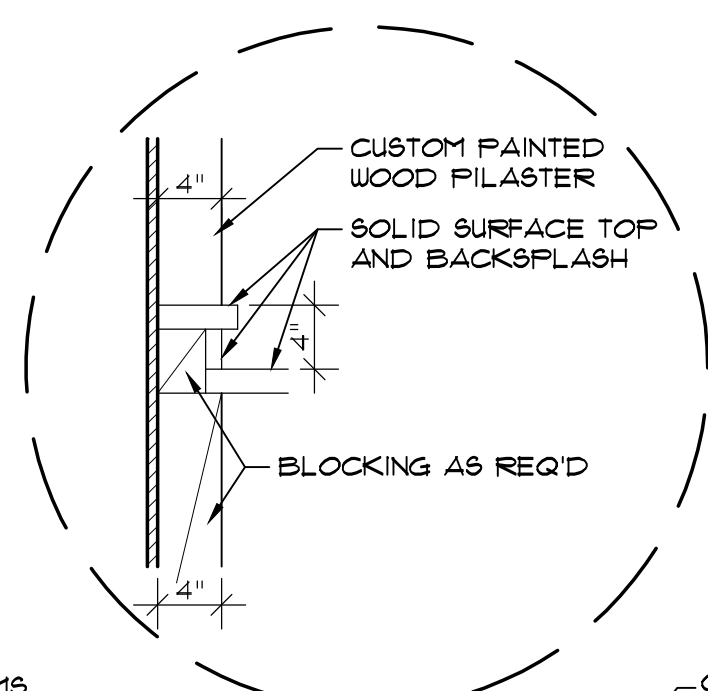


14 WOMEN TOILET 208
A-7.3 SCALE: 1/4" = 1'-0"

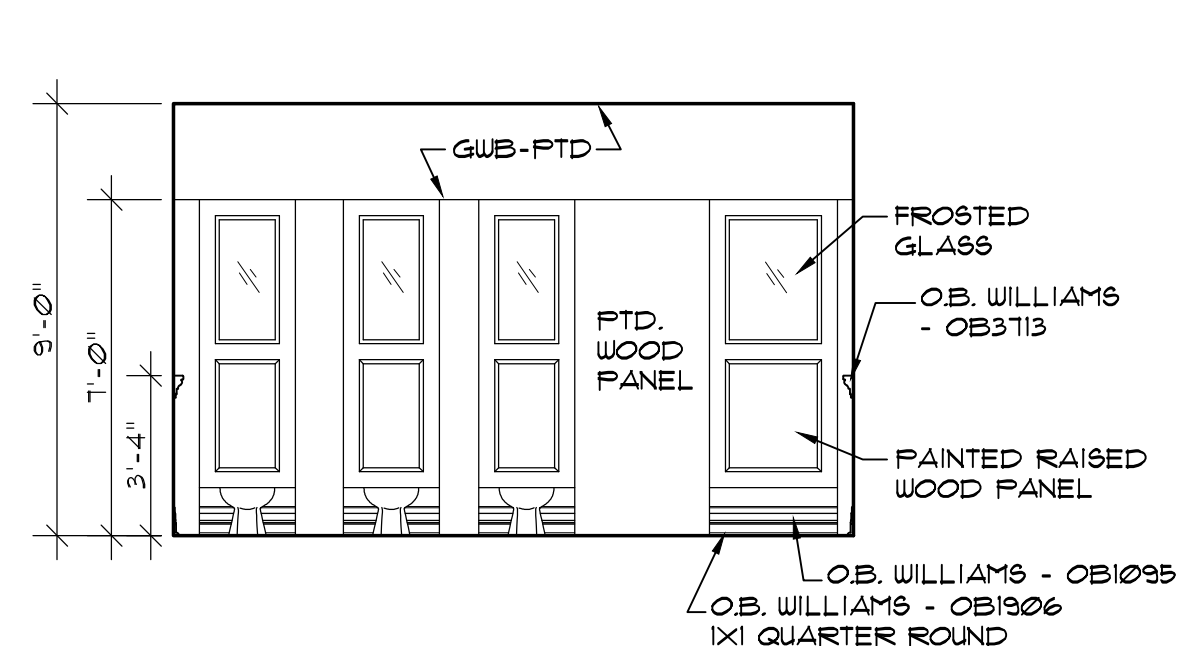


13 WOMEN TOILET 208
A-7.3 SCALE: 1/4" = 1'-0"

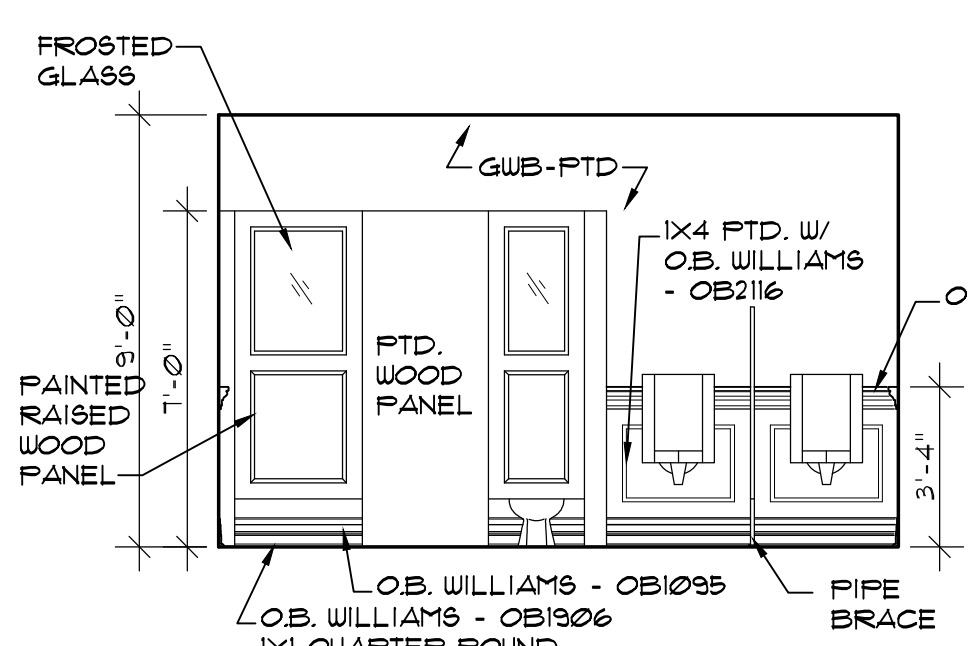


12 MEN TOILET 207
A-7.3 SCALE: 1/4" = 1'-0"

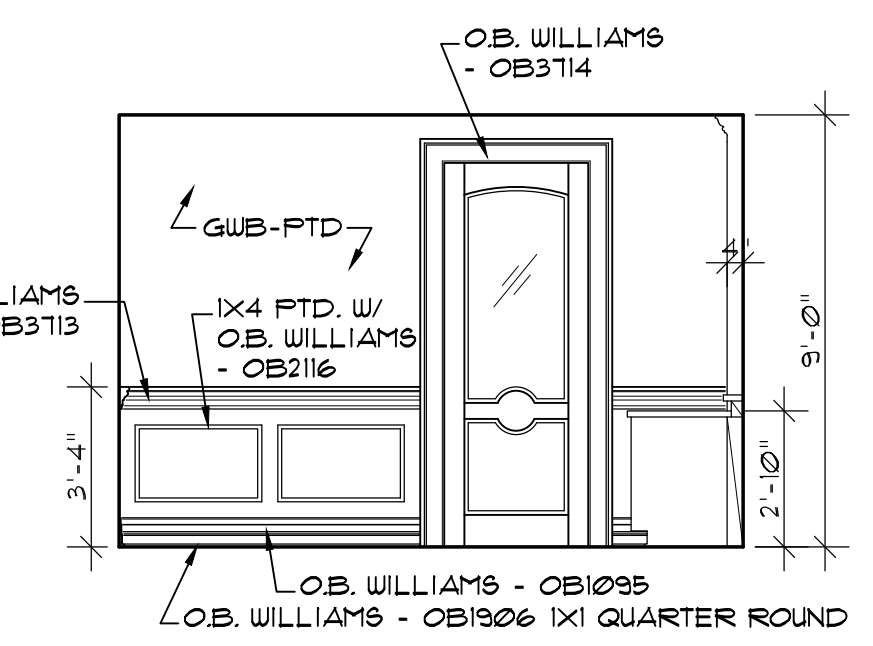


11 MEN TOILET 207
A-7.3 SCALE: 1/4" = 1'-0"

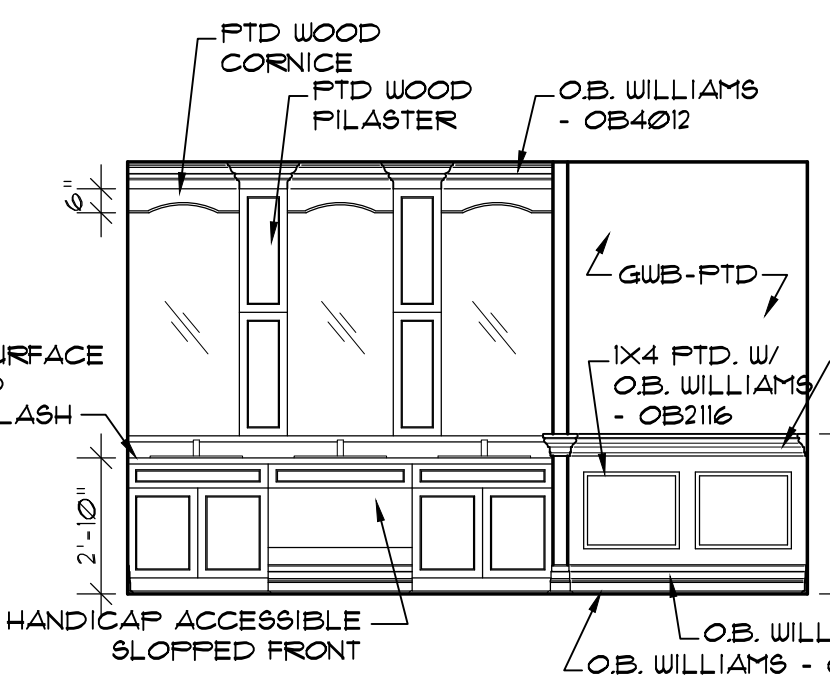


10 MEN TOILET 207
A-7.3 SCALE: 1/4" = 1'-0"

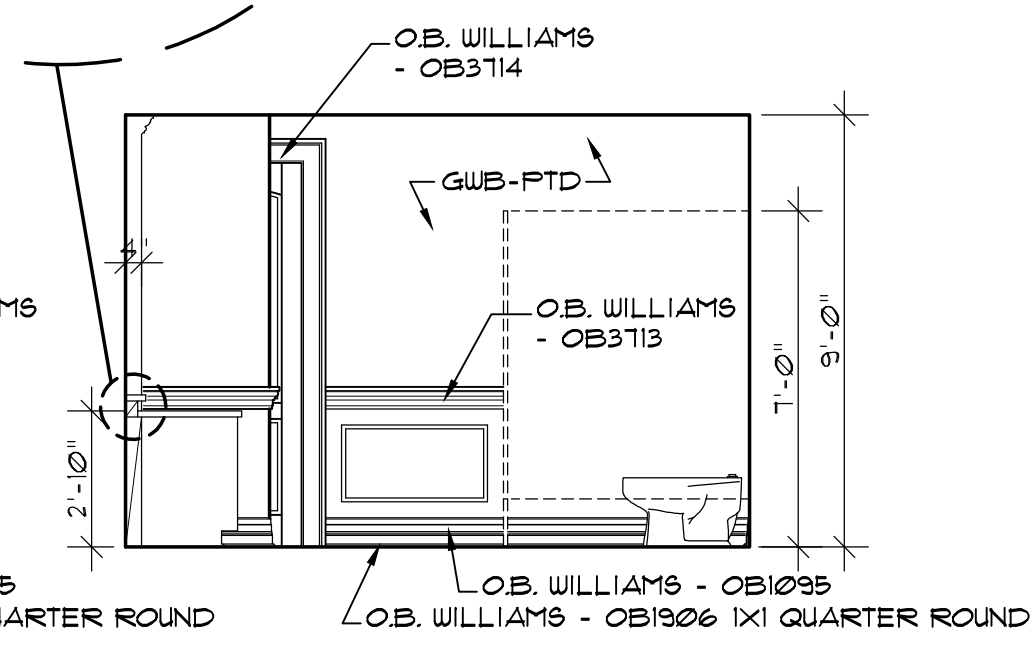


9 MEN TOILET 207
A-7.3 SCALE: 1/4" = 1'-0"

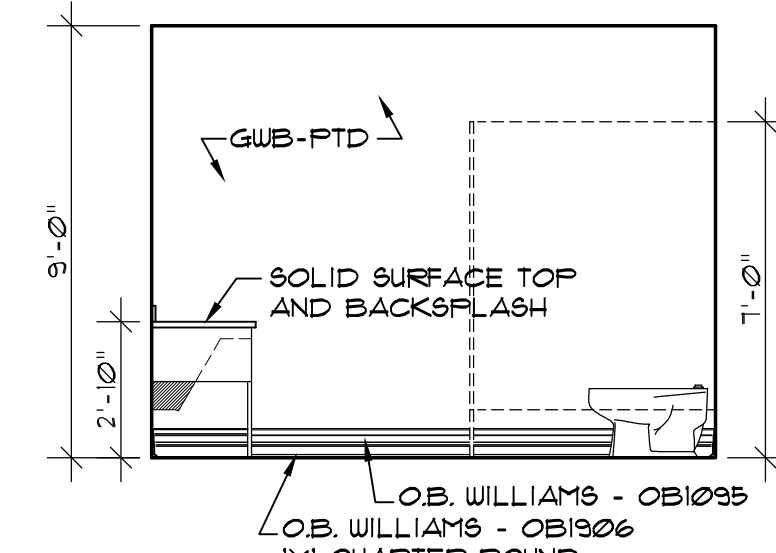


8 MEN TOILET 112
A-7.3 SCALE: 1/4" = 1'-0"

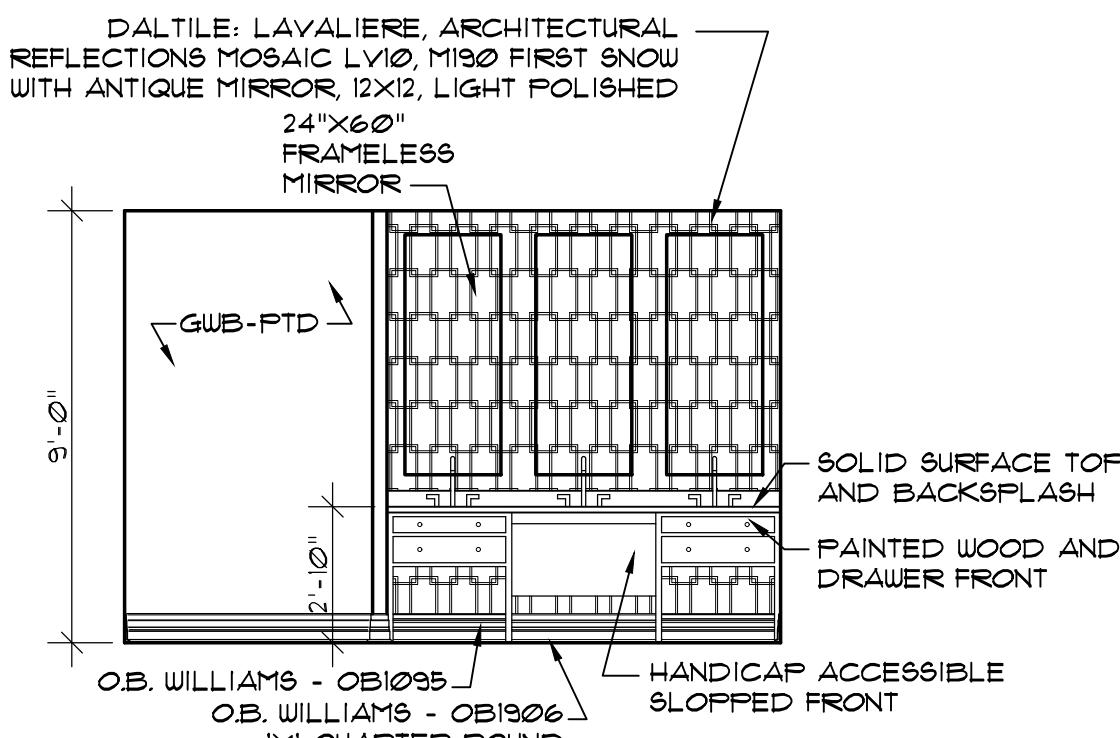


7 MEN TOILET 112
A-7.3 SCALE: 1/4" = 1'-0"

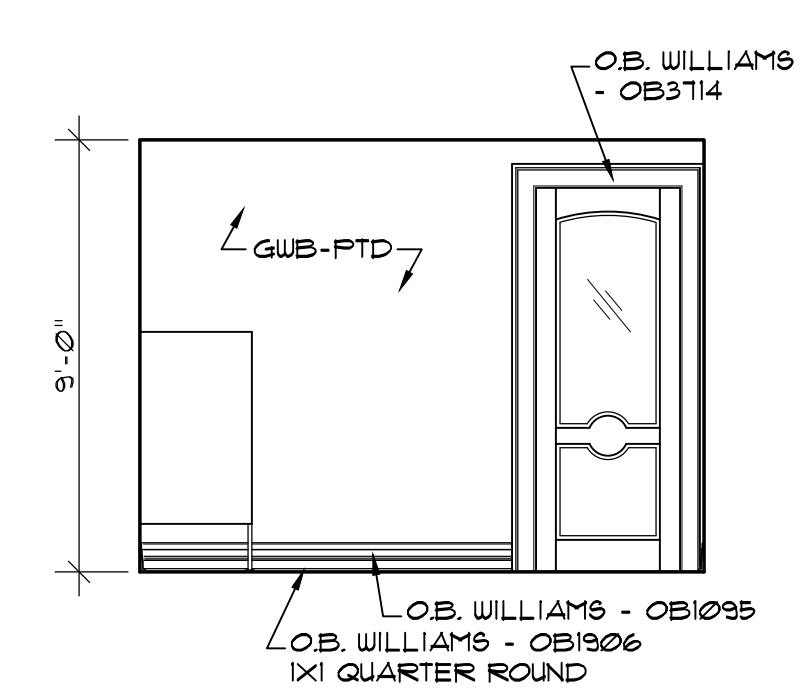


6 MEN TOILET 112
A-7.3 SCALE: 1/4" = 1'-0"

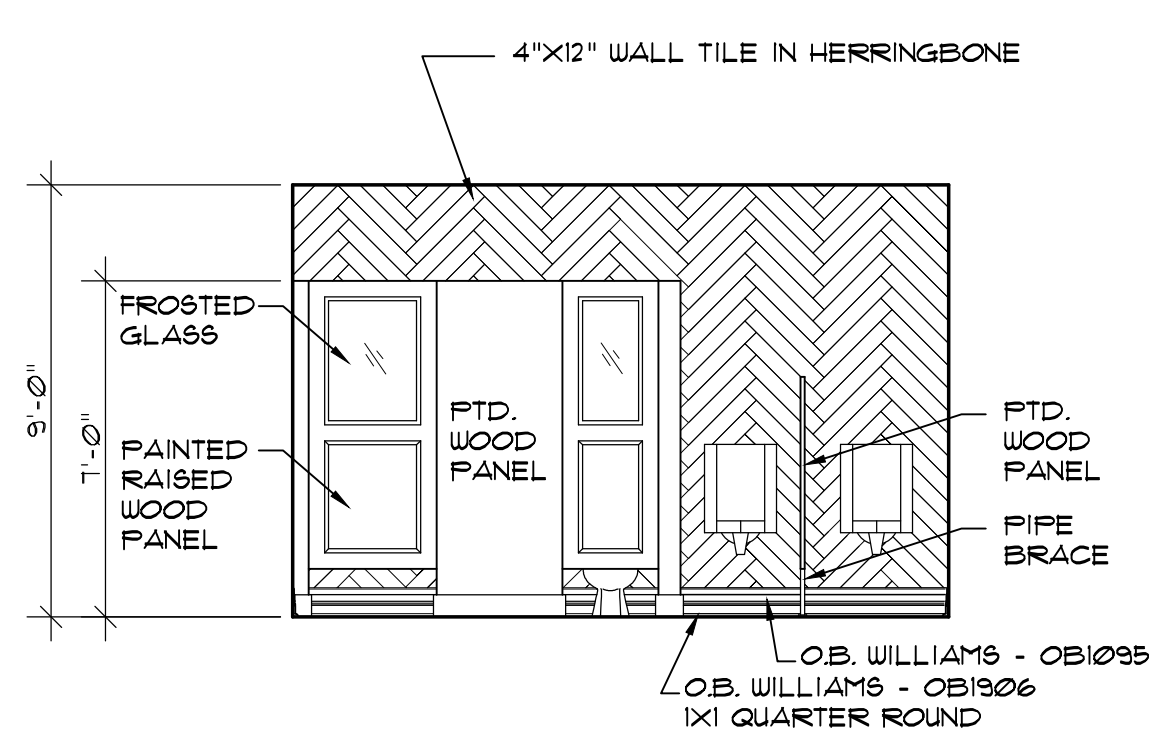


5 MEN TOILET 112
A-7.3 SCALE: 1/4" = 1'-0"

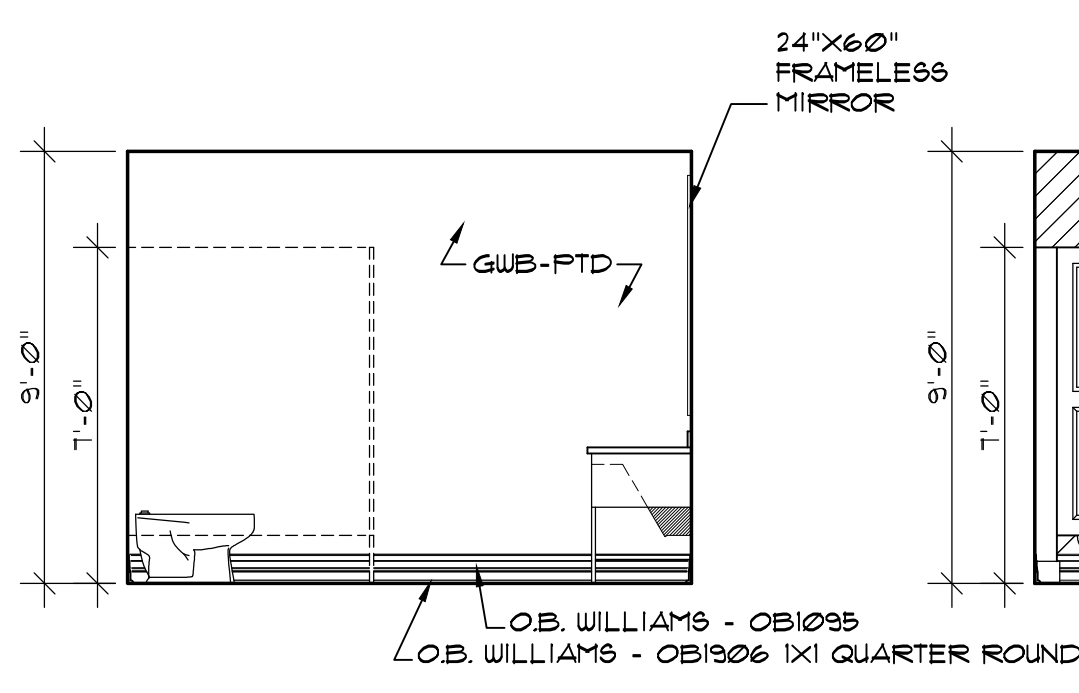


4 WOMEN TOILET 113
A-7.3 SCALE: 1/4" = 1'-0"

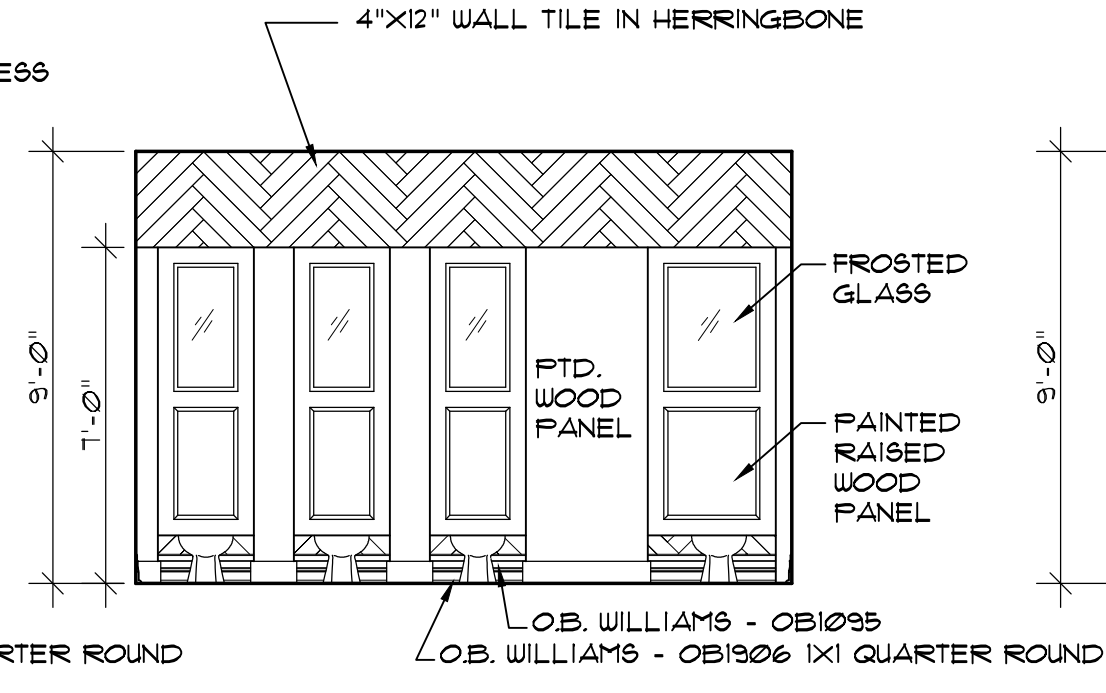


3 WOMEN TOILET 113
A-7.3 SCALE: 1/4" = 1'-0"

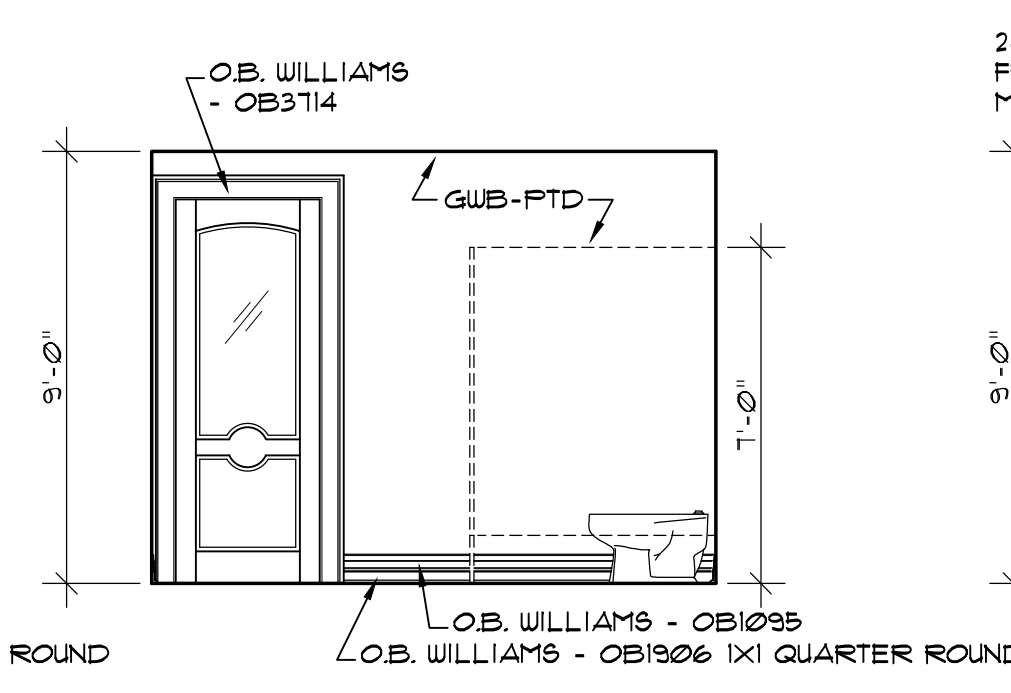


2 WOMEN TOILET 113
A-7.3 SCALE: 1/4" = 1'-0"

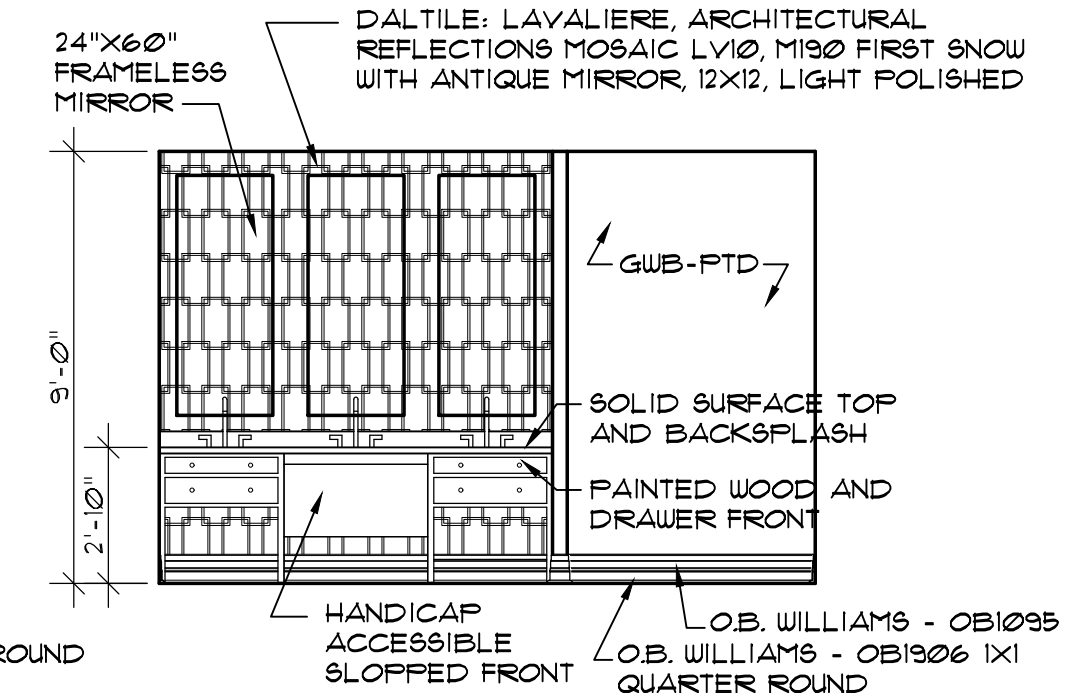


1 WOMEN TOILET 113
A-7.3 SCALE: 1/4" = 1'-0"

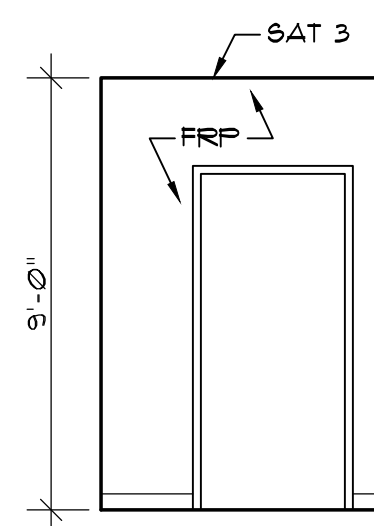


16 KITCHEN TOILET 216
A-7.4 SCALE: 1/4" = 1'-0"

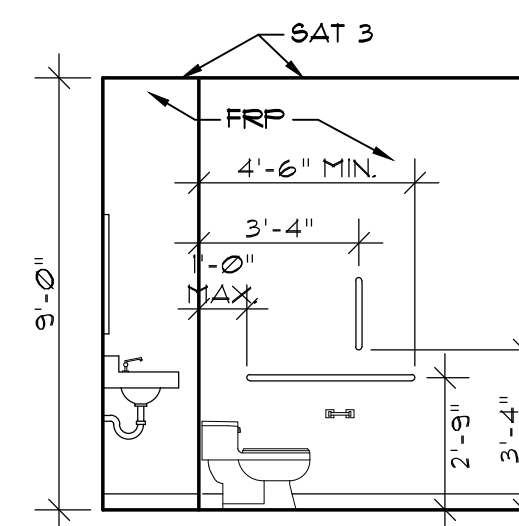


15 KITCHEN TOILET 216
A-7.4 SCALE: 1/4" = 1'-0"

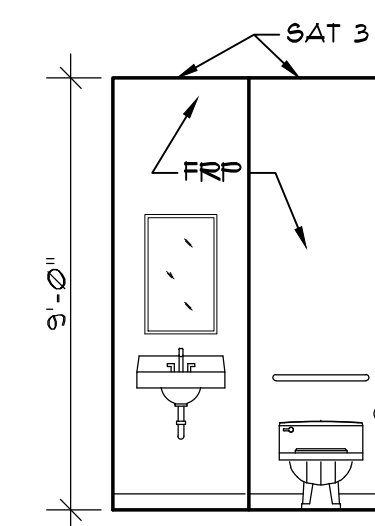


14 KITCHEN TOILET 216
A-7.4 SCALE: 1/4" = 1'-0"

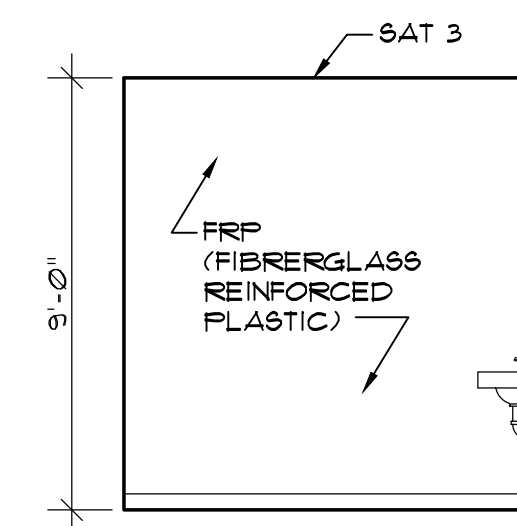


13 KITCHEN TOILET 216
A-7.4 SCALE: 1/4" = 1'-0"

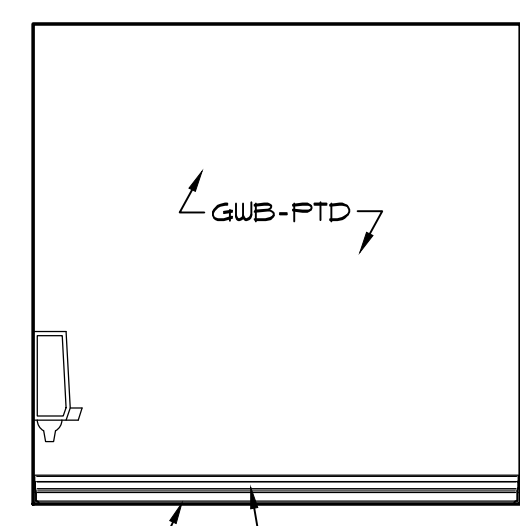


12 MEN TOILET 305
A-7.4 SCALE: 1/4" = 1'-0"

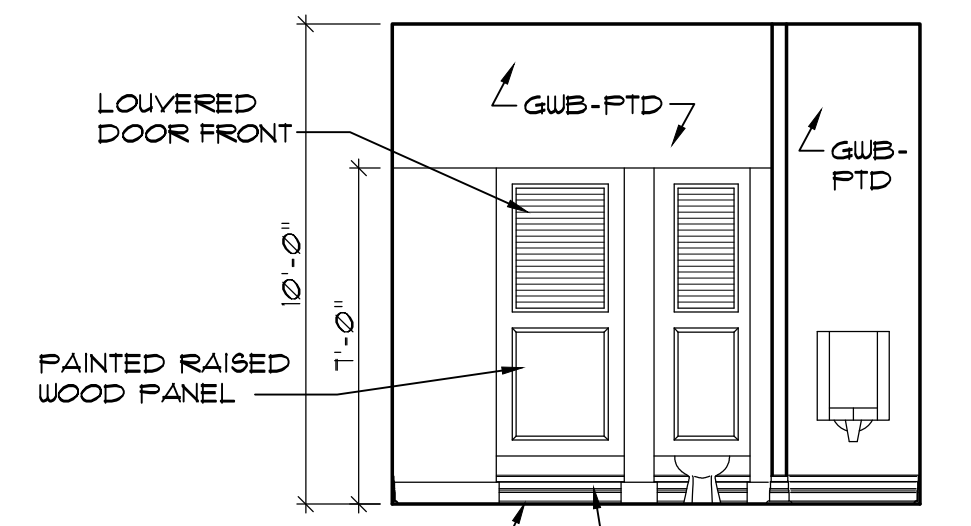


11 MEN TOILET 305
A-7.4 SCALE: 1/4" = 1'-0"

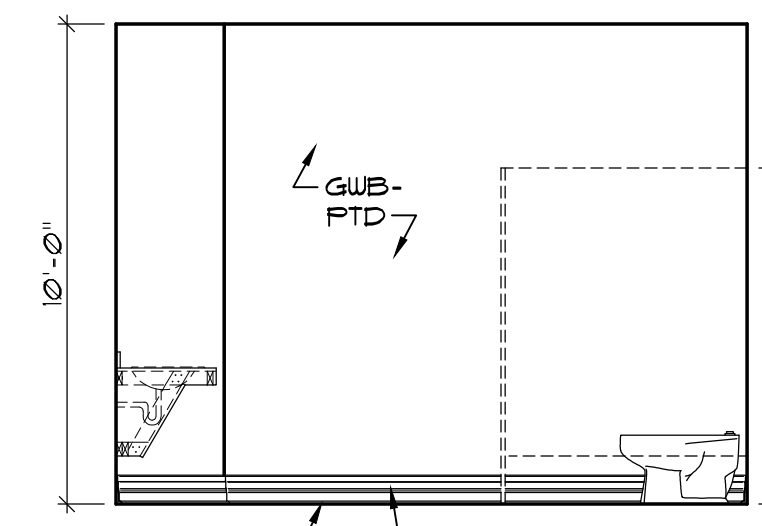


10 MEN TOILET 305
A-7.4 SCALE: 1/4" = 1'-0"

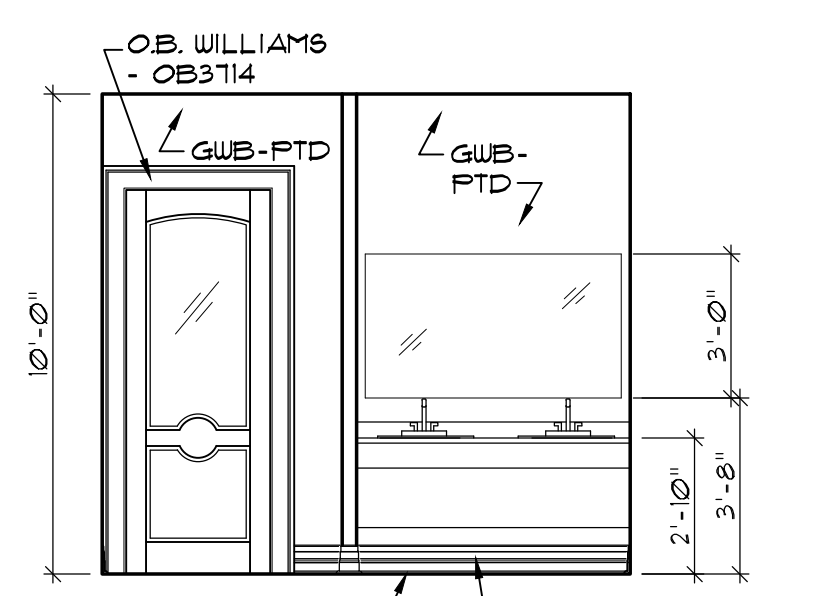


9 MEN TOILET 305
A-7.4 SCALE: 1/4" = 1'-0"

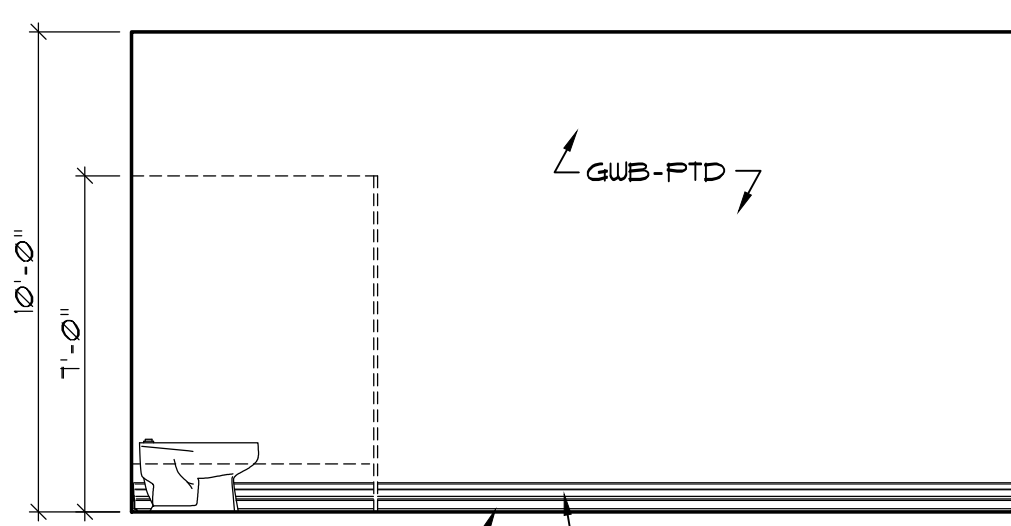


8 WOMEN TOILET 304
A-7.4 SCALE: 1/4" = 1'-0"

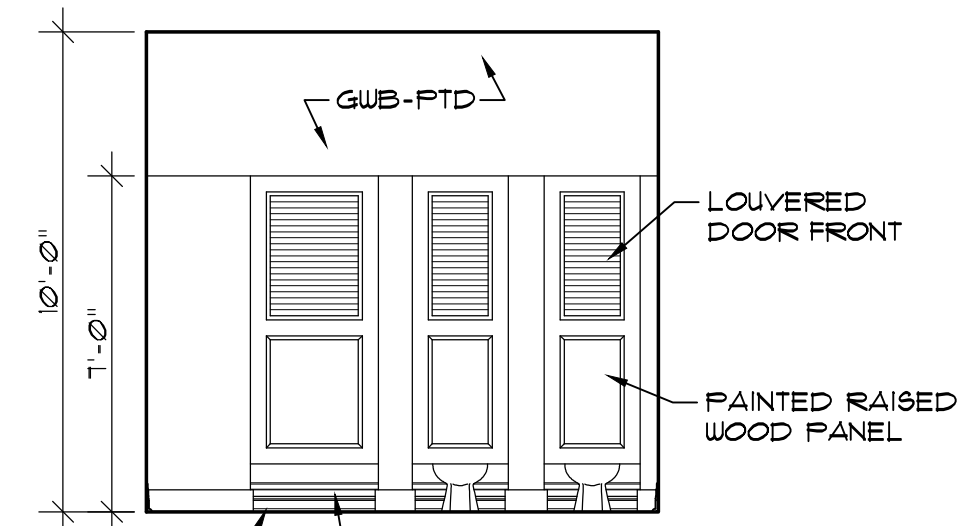


7 WOMEN TOILET 304
A-7.4 SCALE: 1/4" = 1'-0"

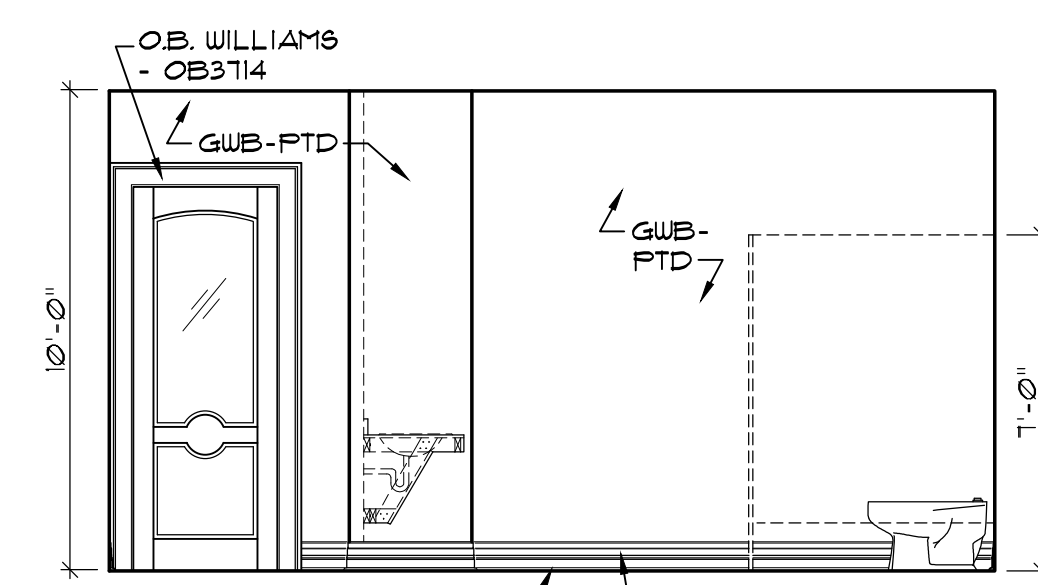


6 WOMEN TOILET 304
A-7.4 SCALE: 1/4" = 1'-0"

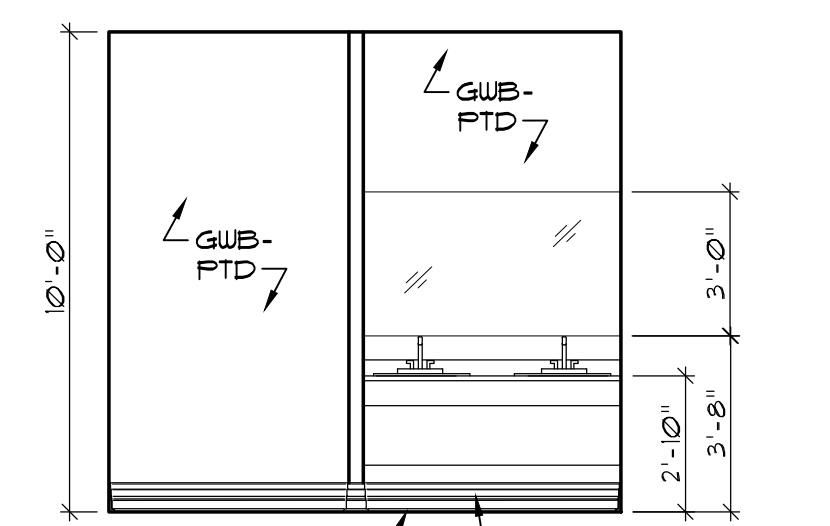


5 WOMEN TOILET 304
A-7.4 SCALE: 1/4" = 1'-0"

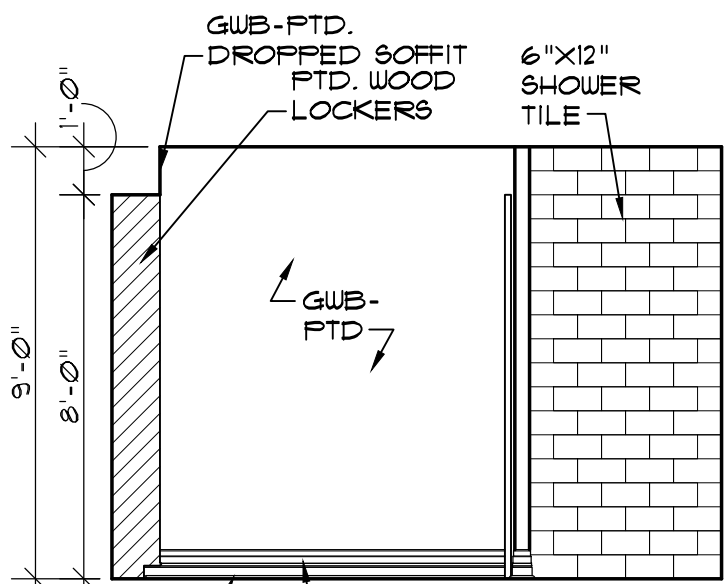


4 WOMEN LOCKER ROOM 210
A-7.4 SCALE: 1/4" = 1'-0"

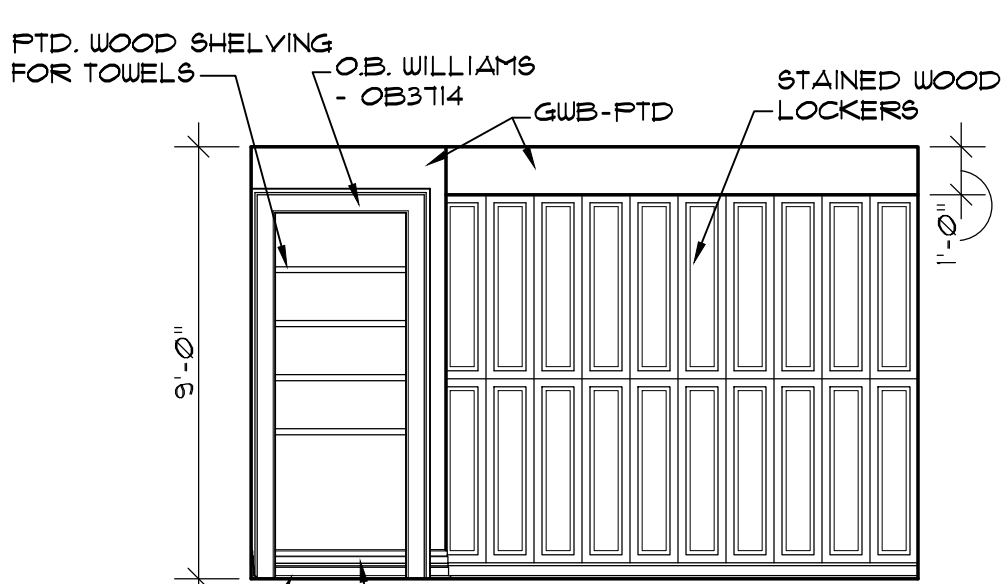


3 WOMEN LOCKER ROOM 210
A-7.4 SCALE: 1/4" = 1'-0"

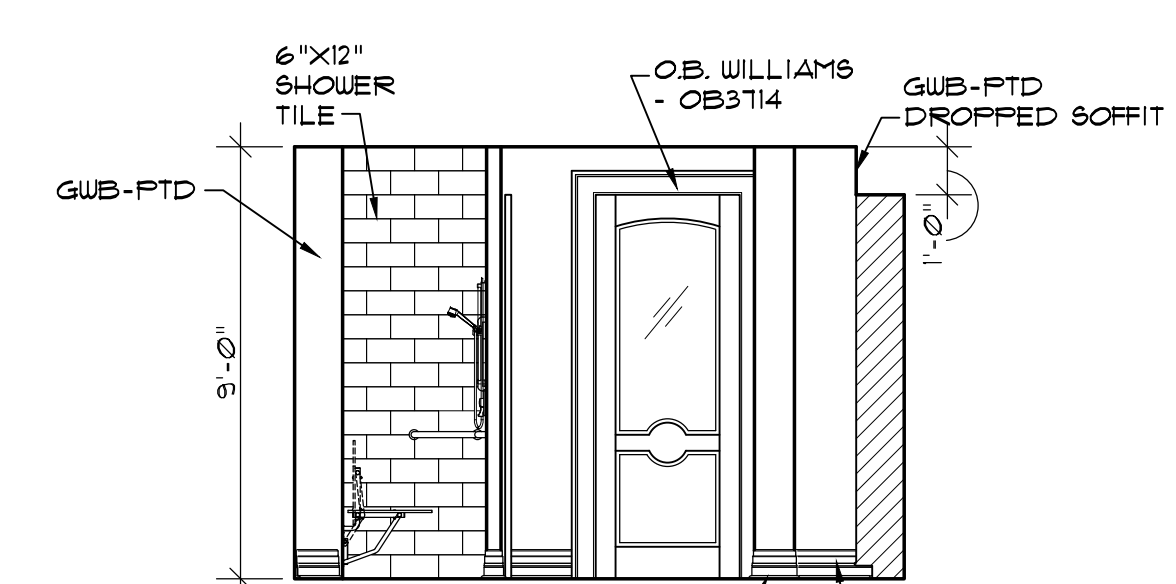


2 WOMEN LOCKER ROOM 210
A-7.4 SCALE: 1/4" = 1'-0"

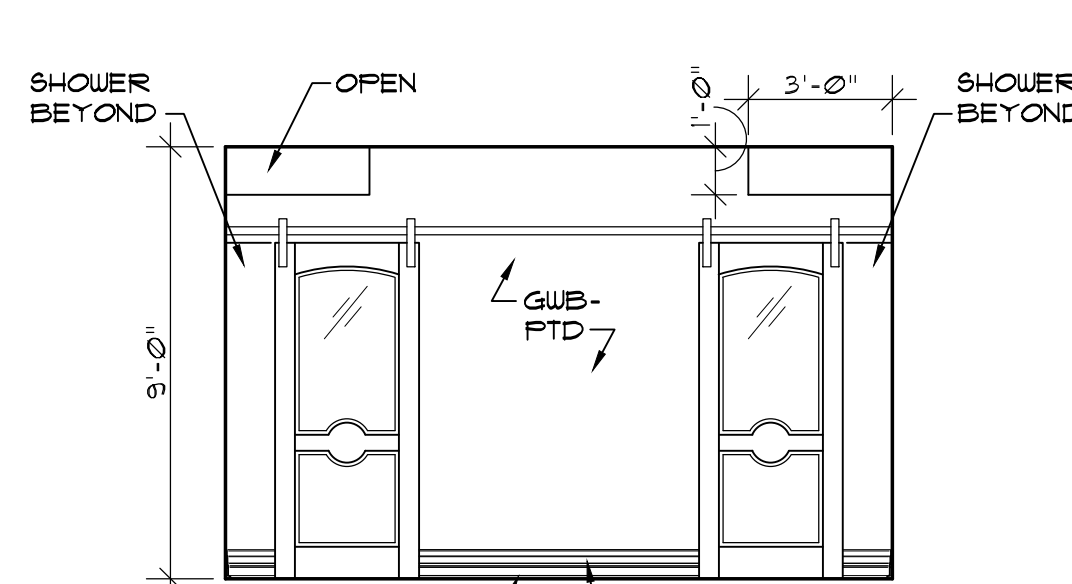


1 WOMEN LOCKER ROOM 210
A-7.4 SCALE: 1/4" = 1'-0"

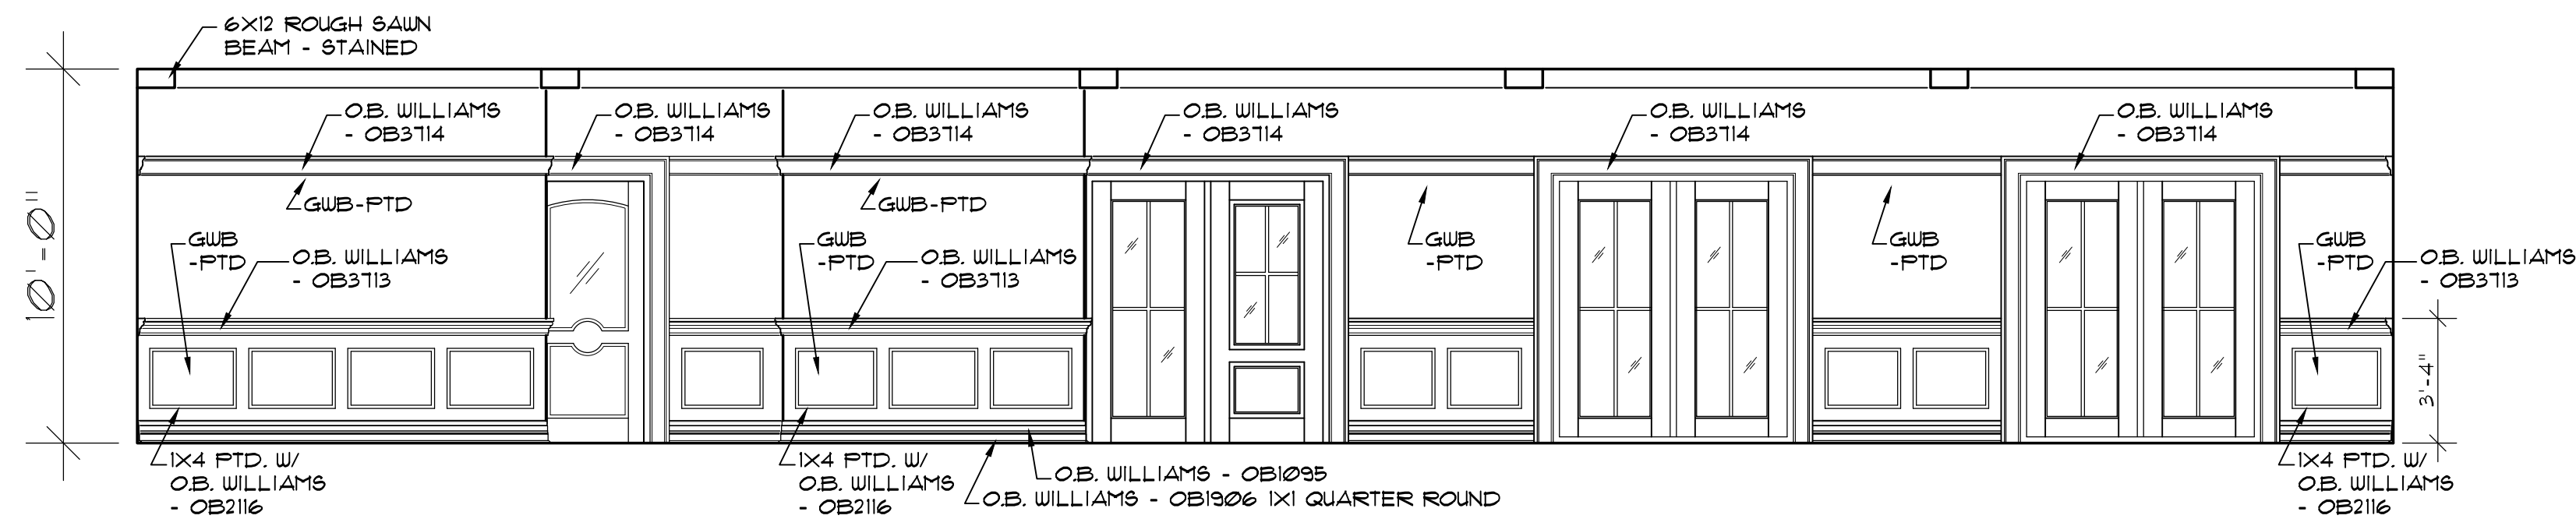


4
A-7.5
ROOF TOP BAR ELEVATION
SCALE: 1/4" = 1'-0"

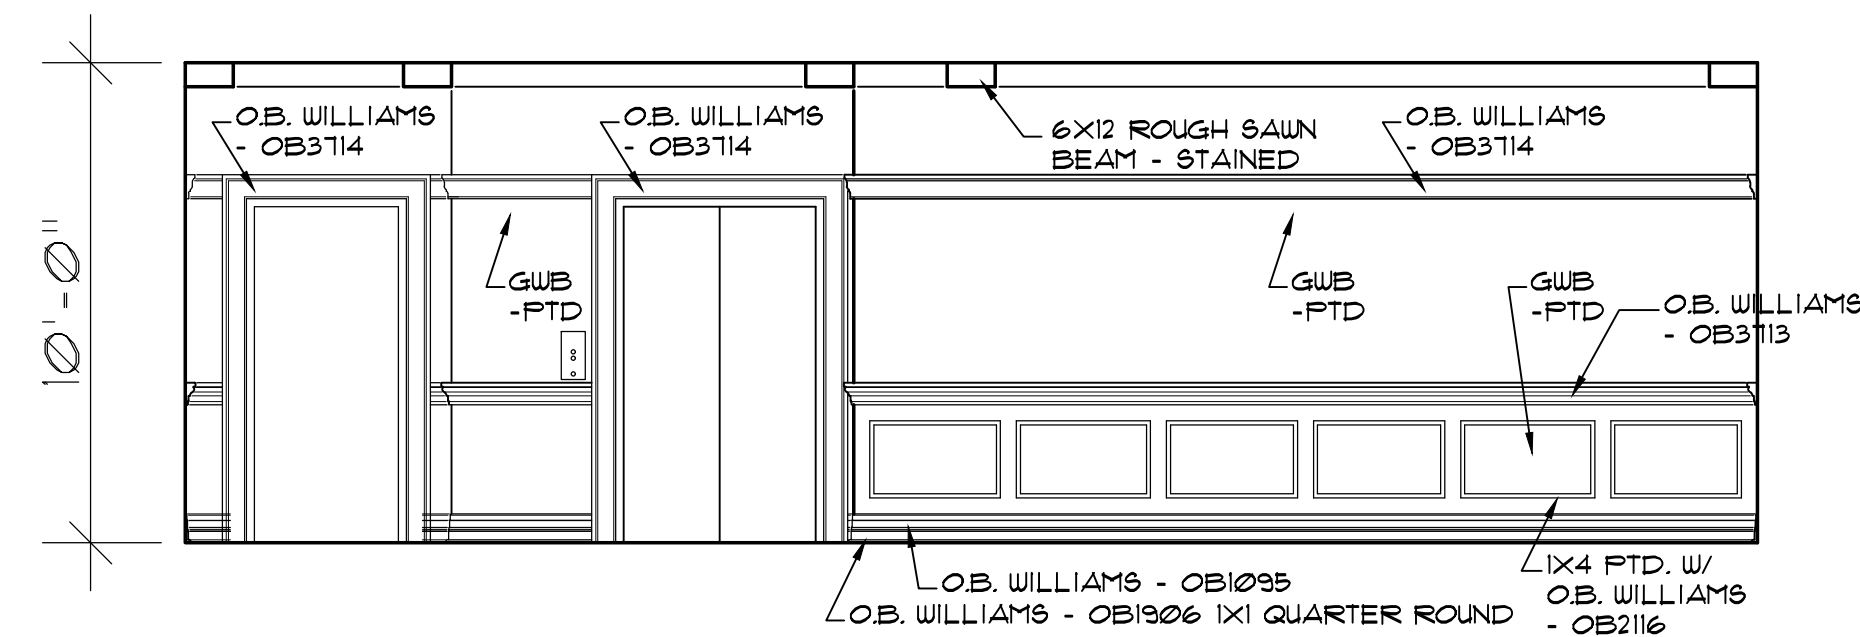

3
A-7.5
ROOF TOP BAR ELEVATION
SCALE: 1/4" = 1'-0"

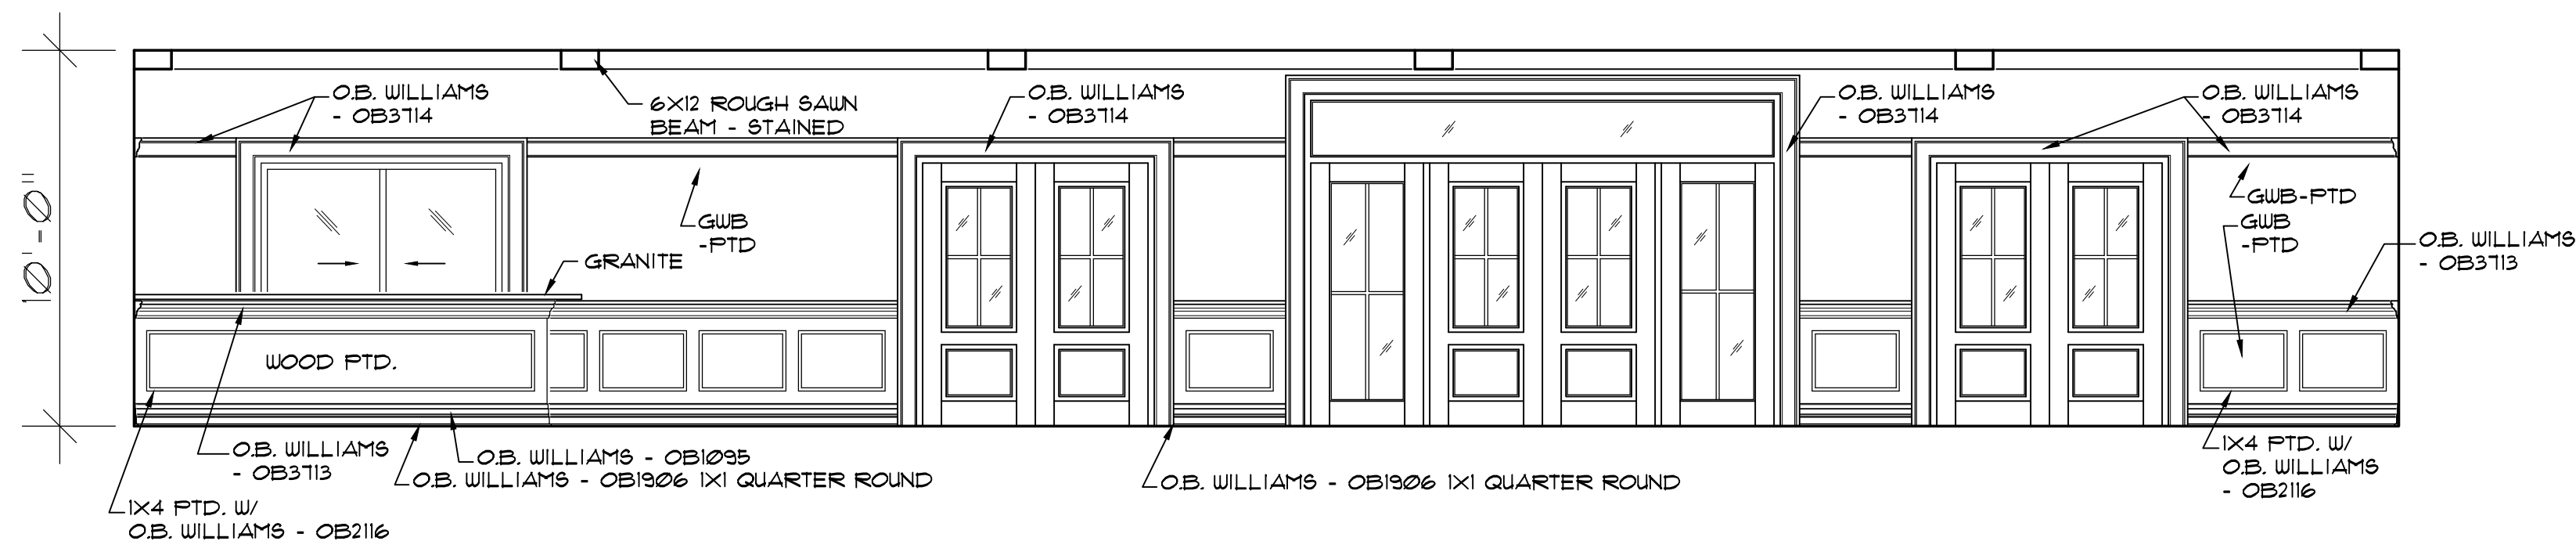

2
A-7.5
ROOF TOP BAR ELEVATION
SCALE: 1/4" = 1'-0"

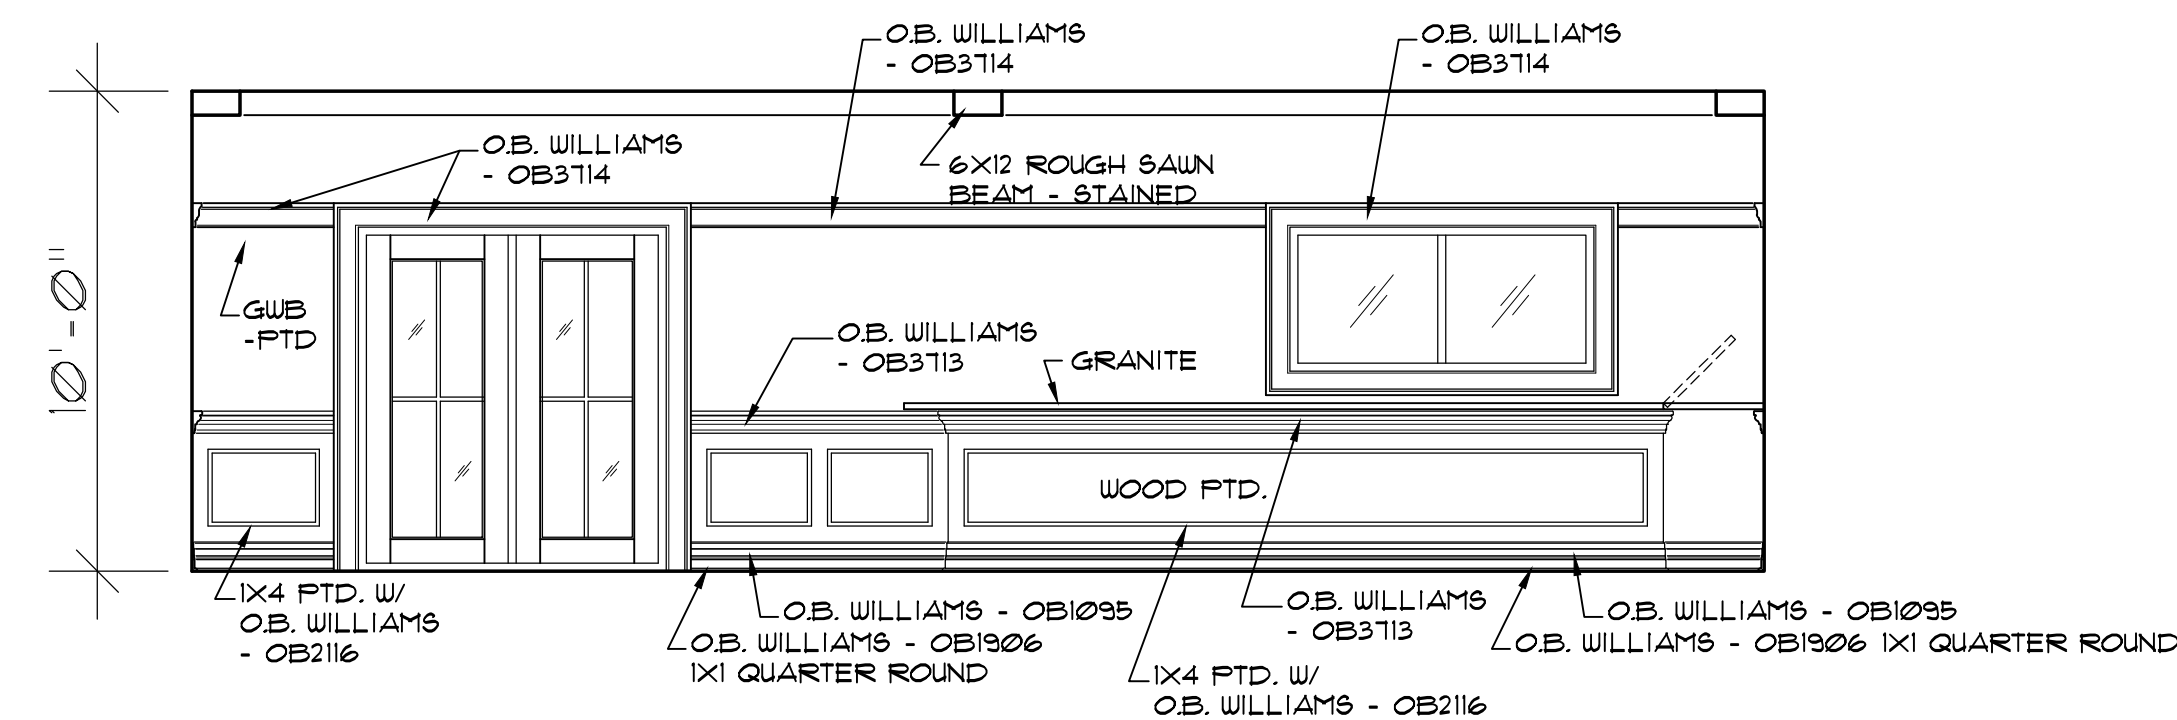


1
A-7.5
ROOF TOP BAR ELEVATION
SCALE: 1/4" = 1'-0"

KITCHEN EQUIPMENT SCHEDULE				
MK.	QTY	DESCRIPTION	MANUFACTURER	COMMENTS
1	1	6 FT x 12 FT WALK-IN BEER COOLER	BY VENDOR	
2	LOT	WALK-IN SHELVING	BY VENDOR	SEE PLAN FOR SIZES
3	LOT	FREESTANDING WIRE DRY STORAGE SHELVING	METRO :	SEE PLAN FOR SIZES
4	2	EMPLOYEE LOCKERS	BY OWNER	
5	1	6 FT x 15 FT WALK-IN COOLER / FREEZER	BY VENDOR	---
6	LOT	COMBO WALK-IN SHELVING	BY VENDOR	SEE PLAN FOR SIZES
7	1	WATER HEATER (GAS)	BY GENERAL CONTRACTOR	---
8	2	2-DOOR REACH-IN REFRIGERATOR	TRUE :	ON CASTERS
9	1	2-DOOR REACH-IN FREEZER	TRUE :	ON CASTERS
10	1	S/S 30" x 48" WORKTABLE W/ UNDERSHLF	ADVANCE TABCO :	---
11	2	S/S WALLMOUNT HANDSINK W/ SINK	ADVANCE TABCO :	---
12	3	SPLASHGUARDS S/S PREP	ADVANCE TABCO :	---
13	2	S/S WALLMOUNT SPLASHGUARDS	BY GENERAL CONTRACTOR	---
14	5	S/S 18" x 60" WALLMOUNT SHELF	ADVANCE TABCO :	MOUNT AT 60"
15	1	S/S 24" x 60" WORKTABLE W/ CASTERS	ADVANCE TABCO :	ON CASTERS
16	1	1-DOOR REFRIGERATOR	TRUE :	ON CASTERS
17	1	S/S 3-COMPARTMENT SINK W/ 24" DRAINBOARD	ADVANCE TABCO :	24" x 24" x 14"
18	1	S/S 15" x 96" WALLMOUNT SHELF W/ POT RACK	ADVANCE TABCO :	BOWLS MOUNT AT 60"
19	LOT	FREESTANDING WIRE DRYING RACKS	METRO :	SEE PLAN FOR SIZES
20	1	HIGH TEMP DISHMACHINE W/ VAPORVENT	PUREFORCE :	---
21	1	S/S 72" CLEAN RIGHT-HAND DISHTABLE	ADVANCE TABCO :	---
22	1	S/S 42" WALLMOUNT RACK	ADVANCE TABCO :	---
23	1	S/S SOILED LEFT HAND DISHTABLE W/ LANDING	ADVANCE TABCO :	---
24	1	CASTERS	CAMBRO	MODEL PER OWNER
25	1	UTILITY CART ON CASTERS	TURBO AIR	MODEL PER OWNER
26	1	ICE MACHINE WITH BIN	MANITOWOC :	---
27	1	18 FT EXHAUST HOOD W/ REMOTE	BY CAPTIVEAIRE	SEE HOOD DRAWINGS
28	1	COOK & HOLD CABINET	ALTO-SHAAM :	ON CASTERS
29	1	6-BURNER RANGE WITH OVEN (GAS)	AMERICAN RANGE :	ON CASTERS
30	1	62" REFRIGERATED CHEF BASE	TRUE :	ON CASTERS
31	1	60" FLAT GRIDDLE (GAS)	AMERICAN RANGE :	ON ITEM
32	2	60" SALAMANDER BROILER (GAS)	AMERICAN RANGE :	WALL MOUNTED
33	4	DEEP FRYER (GAS)	AMERICAN RANGE :	ON CASTERS
34	2	BREADING STATION	ADVANCE TABCO :	---
35	1	18 FT EXHAUST HOOD W/ REMOTE	NSLAG-302-X BY CAPTIVEAIRE	SEE HOOD DRAWINGS
36	1	CONVECTION OVEN (GAS)	BLODGETT :	ON CASTERS
37	1	52" REFRIGERATED CHEF	TRUE :	ON CASTERS
38	1	48" FLAT GRIDDLE (GAS)	AMERICAN RANGE :	ON ITEM
39	1	BROASTER PRESSURE DEEP FRYER (GAS)	ARMG-48	#37
40	1	S/S WALLMOUNT HAND	ADVANCE TABCO :	---
41	1	1-DOOR REACH-IN FREEZER	TRUE :	ON CASTERS
42	1	S/S 30" x 60" WORKTABLE W/ DROP-IN	ADVANCE TABCO :	---
43	2	2-DOOR WORKTOP REFRIGERATOR	TRUE :	ON CASTERS
44	1	S/S 15" x 96" WALLMOUNT SHELF	ADVANCE TABCO :	MOUNT AT 60"
45	2	S/S 18" x 96" LOW DISH SHELVING	ADVANCE TABCO :	A.T.F.
46	2	S/S 15" x 144" PASSTHRU SHELF W/ OVERSHLF	ADVANCE TABCO :	---
47	3	48" IR HEAT LAMP	PA-18-144 APW WYOTT :	ON ITEM
48	1	BAG-IN-BOX W/ CARBON DIOXIDE	DL-46 BY VENDOR	#46
49	1	CANISTERS	BERNER INT'L :	---
50	1	FAN 40 QT	AS-222-SS ROBERT :	---
51	2	COFFEE BREWER	HL-400 BY VENDOR	ON ITEM
52	2	TEA BREWER /	BY VENDOR	#43
53	1	DRAFT BEER REFRIGERATED LINE GLYCOL CHILLER	MICROMATIC :	CUSTOM INSTALL
54	1	NITROGEN GENERATOR WITH TANK	MMP4301 NITRO-DRAUGHT :	---
55	1	3-WELL HOT HOLDING TABLE	ADVANCE TABCO :	W/ UNDERSHLF
56	2	66" REFRIGERATED PREP TABLE	TSW-36-120 TRAUJSEN :	ON CASTERS
57	---	NOT USED	TS066HT	---
58	---	NOT USED		---
59	---	NOT USED		---
60	---	NOT USED		---

NOTE:
ALL EQUIPMENT BRAND NAMES, SPECIFIC HARDWARE AND CONNECTION DETAILS SHALL BE VERIFIED WITH THE EQUIPMENT DEALER AND OWNER PRIOR TO BIDDING, PURCHASE OR INSTALLATION. GENERAL CONTRACTOR SHALL FIELD VERIFY ALL DIMENSIONS PRIOR TO EQUIPMENT ROUGH-IN.

NOTE:
VERIFY WALK-IN COOLER AND WALK-IN FREEZER SPECIFICATIONS AND REQUIREMENTS
VERIFY DRAFT BEER REFRIGERATION SYSTEM SPECIFICATIONS AND REQUIREMENTS.

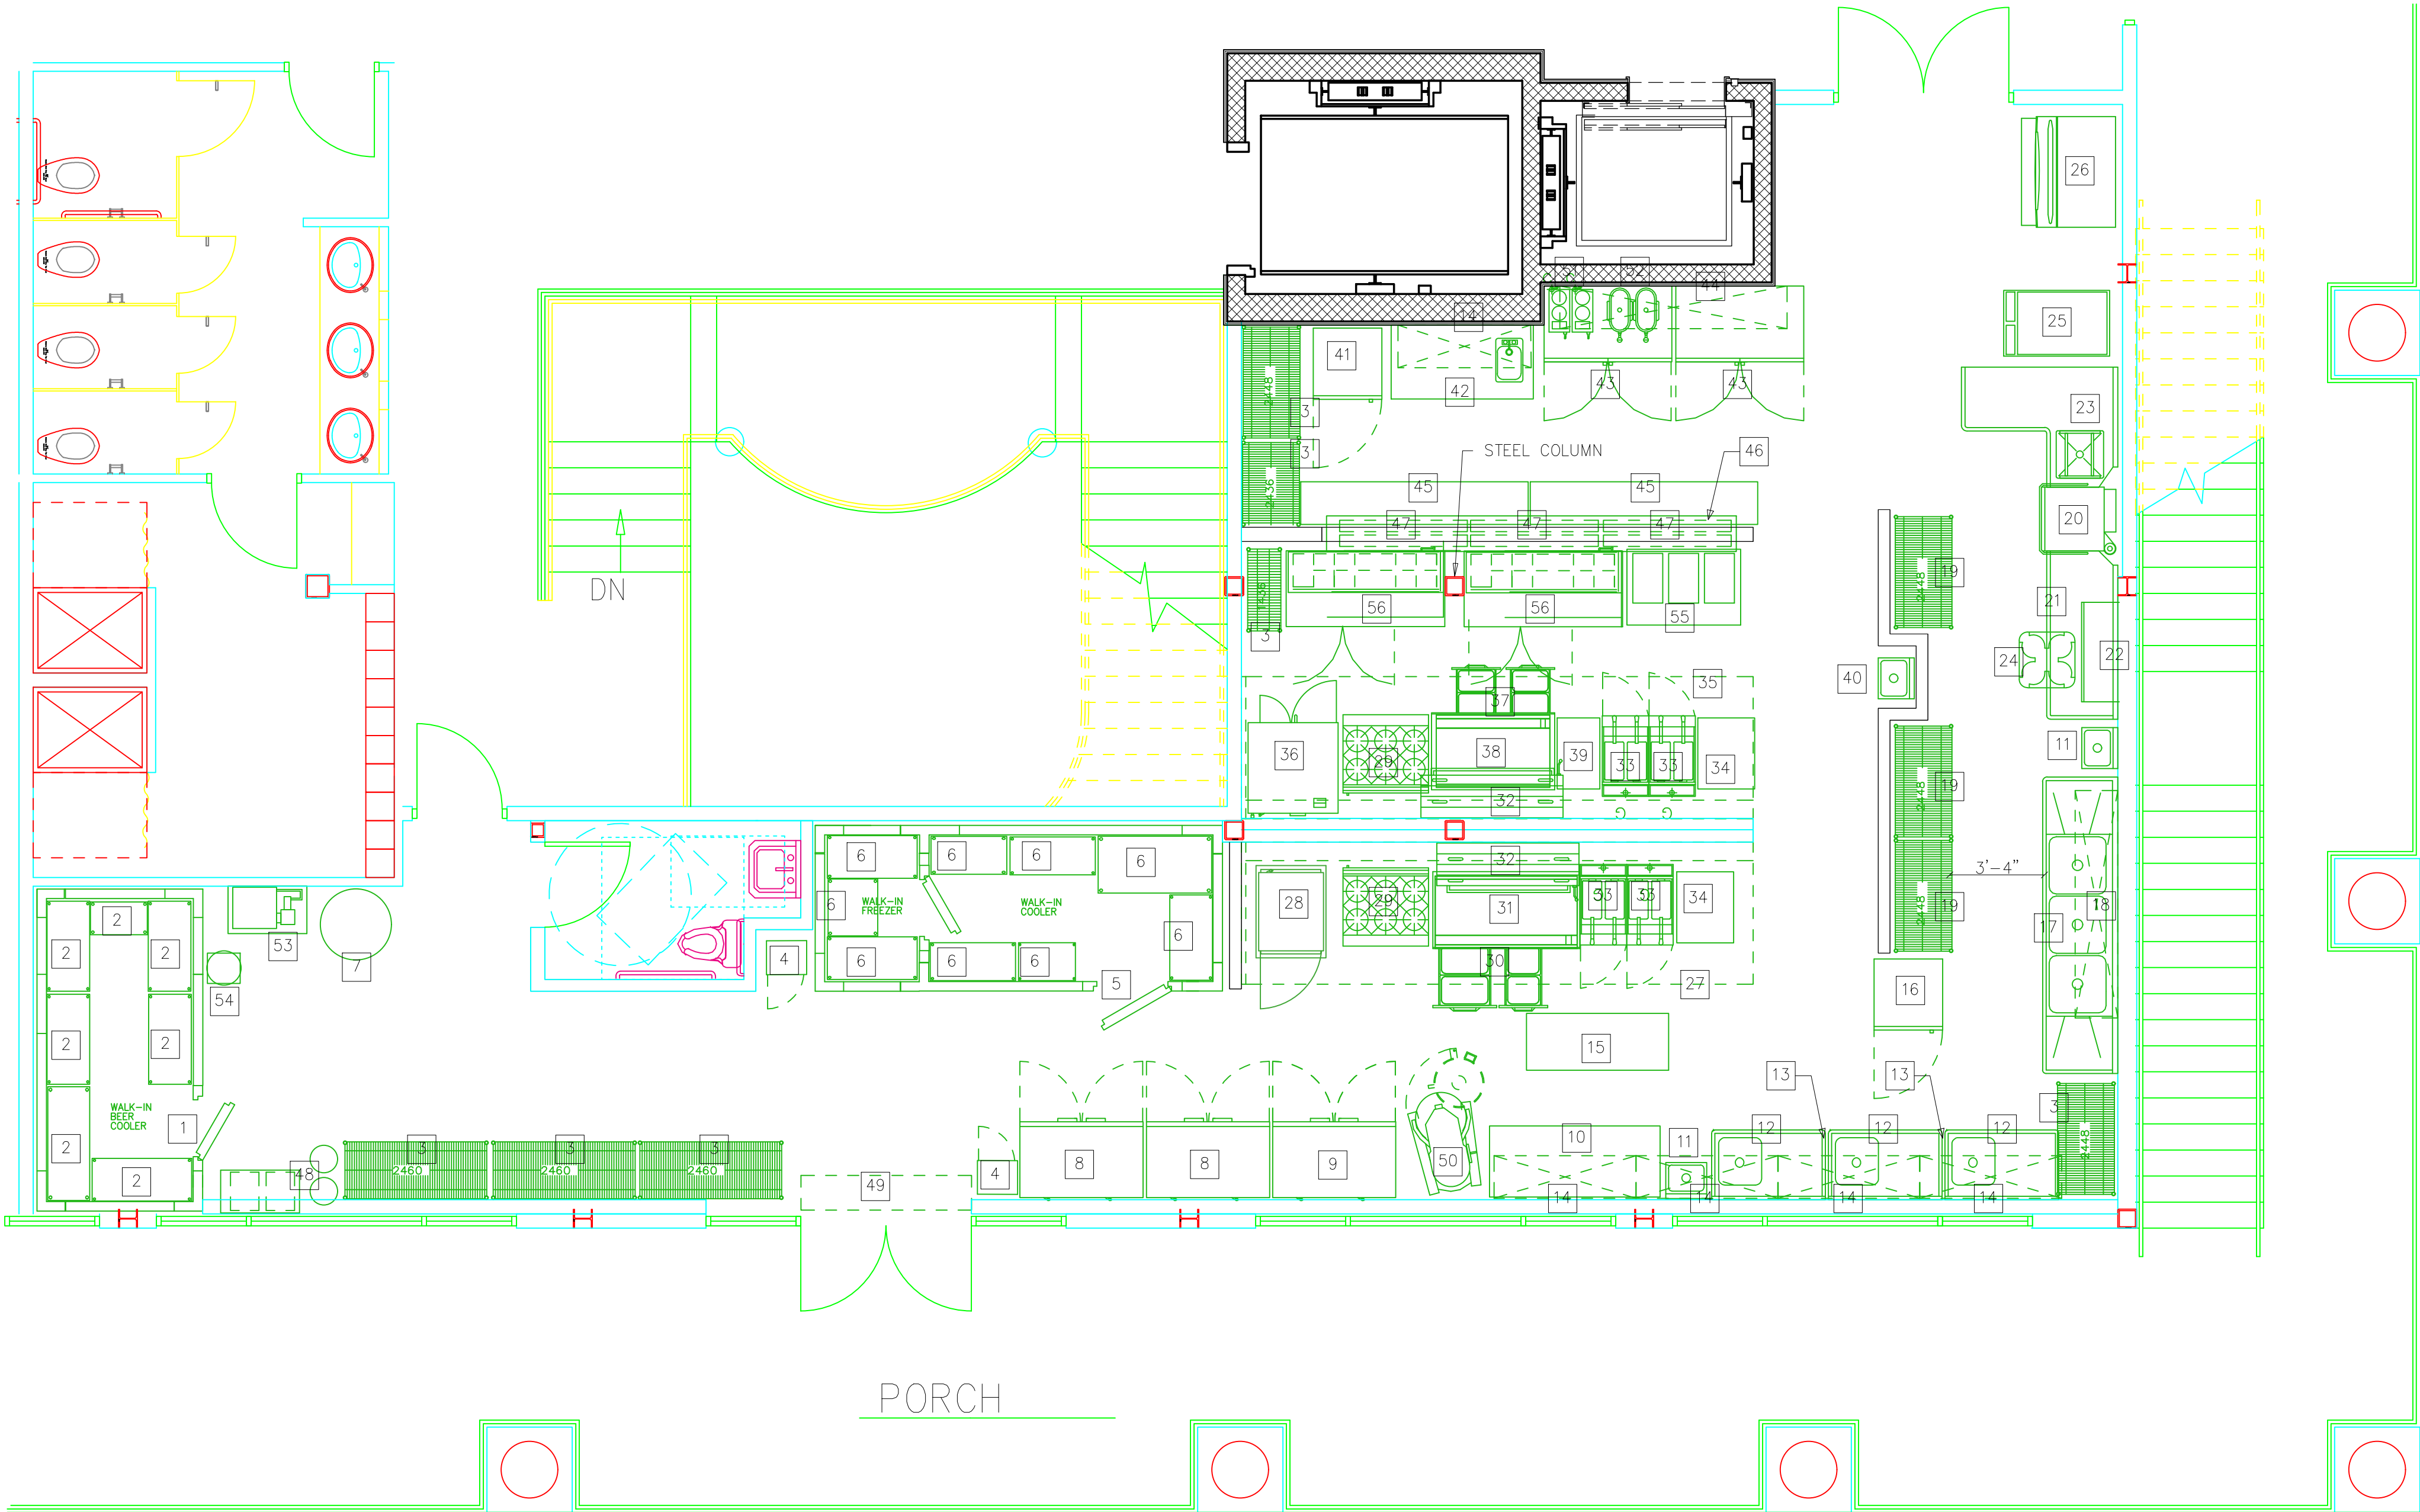

1
K-1.0

ENLARGED KITCHEN PLAN

SCALE:
1/4"=1'-0"

Coastal
Architecture

- Architectural Design
- Planning
- Interiors

Member of the American
Institute of Architects

Lee D. Dixon, Jr., AIA
252-247-2121
lee@coastalarchitecture.net

4206 Bridges St. Ext.,
Morehead City, NC
28557

www.CoastalArchitecture.net

MOREHEAD CITY COUNTRY CLUB
CLUBHOUSE
MOREHEAD CITY, NORTH CAROLINA


ENLARGED KITCHEN PLAN

20010

ISSUED: 1/29/21
DWG BY: MES
CKD BY: LDD

REVISIONS

SHEET NO.
K-1.0
OF

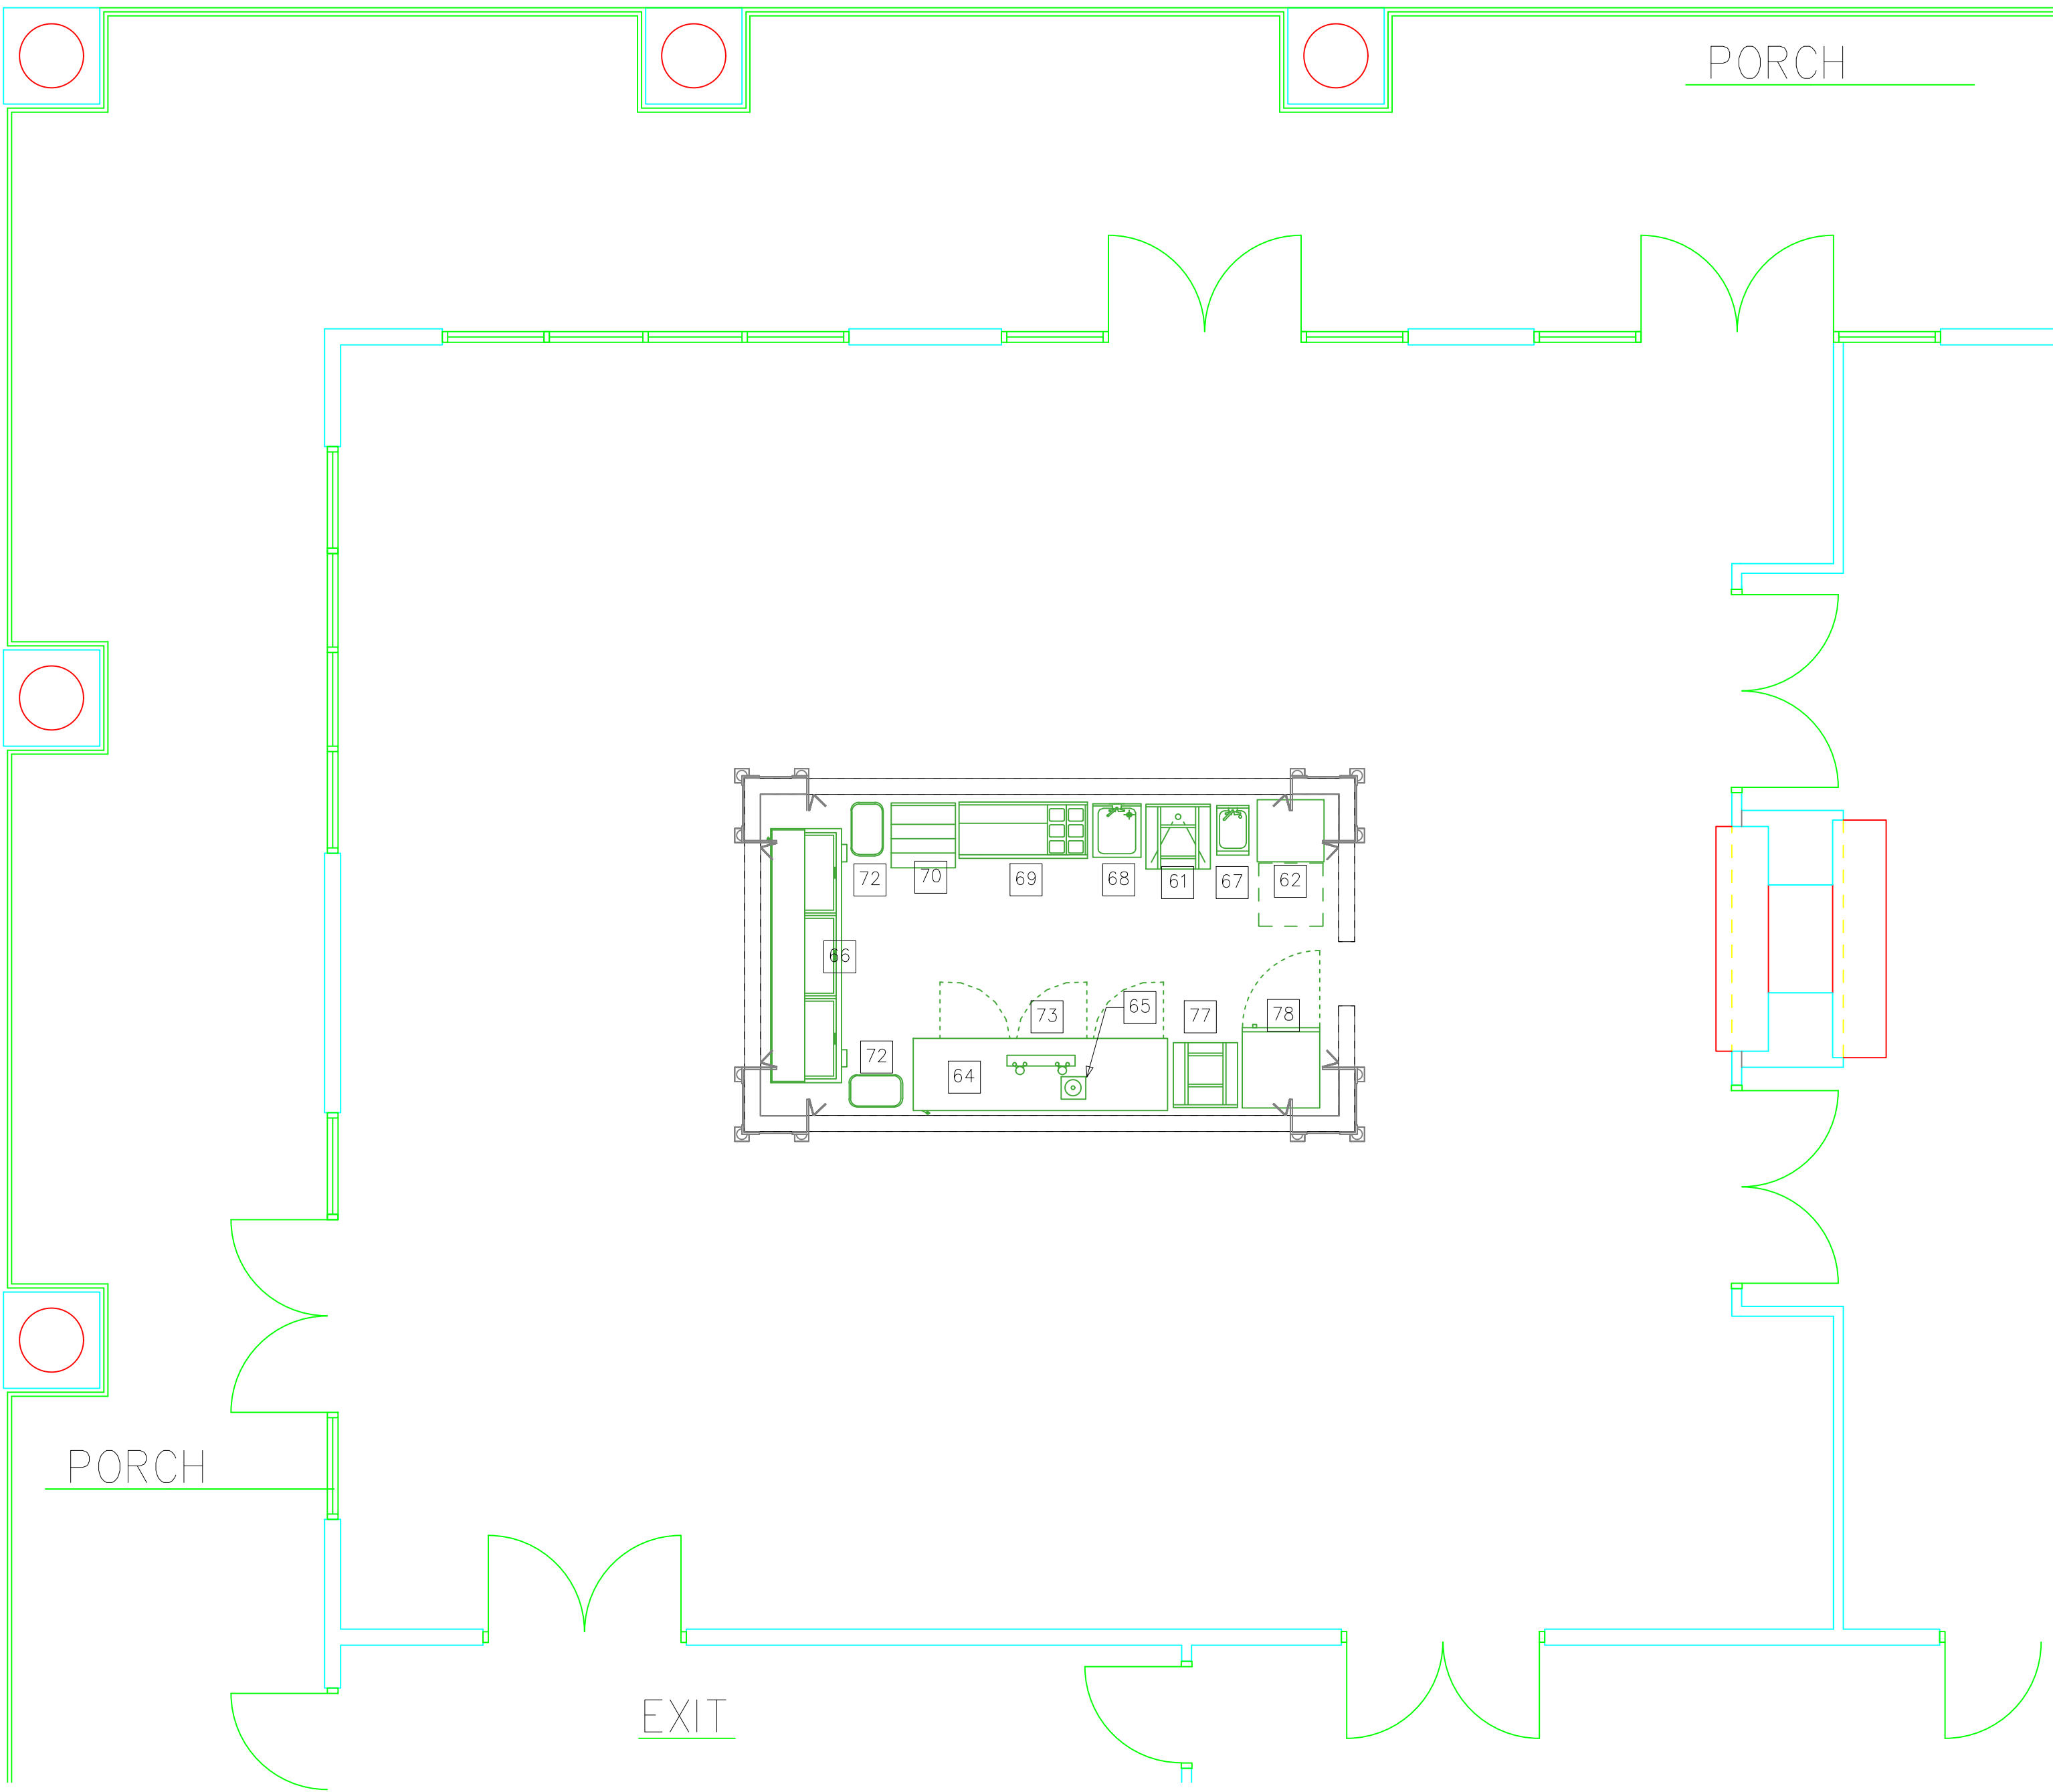


1
K-1.1

MEMBERS BAR PLAN

SCALE:
1/4"=1'-0"

BAR EQUIPMENT SCHEDULE				
MK.	QTY	DESCRIPTION	MANUFACTURER	COMMENTS
61	2	S/S SOILED GLASS RACK	SUPREME METAL :	WITH DRAIN
62	2	UNDERCOUNTER GLASS WASHER	CRCR-24-CT	---
63	1	2-DOOR UNDERCOUNTER REFRIGERATOR	TRUE :	NSF-7 OPEN
64	LOT	POINT OF SALE	TUC-48	FOOD VERIFY LOCATIONS
65	2	GLASS RINSER / DIP	MICROMATIC :	IN COUNTER
66	1	94" DEEP WELL BOTTLE	DR-MET-T-24OR-Z	---
67	2	COOLER	DW94	---
68	1	S/S BAR HAND	ADVANCE TABCO :	---
69	1	S/S 18" BAR HAND	SC-12-19-S	---
70	2	STORAGE	ADVANCE TABCO :	---
71	1	DISPLAY	PRHSC-19-18	---
72	LOT	S/S 36" ICE WELL W/ COLD	ADVANCE TABCO :	---
73	1	TRASH RECEPTACLE	LD-1824	---
74	1	94" DIRECT DRAFT BEER	PRI-19-36-10XD	---
75	1	COOLER	BY OWNER	---
76	1	S/S BAR DUMP	BEVERAGE-AIR :	---
77	2	48" DEEP WELL BOTTLE	DB94	---
78	1	COOLER	SL-RS-12	---
79	---	NOT USED	BEVERAGE-AIR :	ON CASTERS
80	---	NOT USED	DW45	DECK MOUNTED
81	---	NOT USED	MICROMATIC :	---
82	---	NOT USED	METRO-T-8PSSKR	---
83	---	NOT USED	SUPREME METAL :	---
84	---	NOT USED	CRCR-24	---
85	---	NOT USED	TRUE :	NSF-7 OPEN
86	---	NOT USED	TWT-27	FOOD
87	---	NOT USED	---	---
88	---	NOT USED	---	---

NOTE:
ALL EQUIPMENT BRAND NAMES, SPECIFIC HARDWARE AND CONNECTION DETAILS SHALL BE VERIFIED WITH THE EQUIPMENT DEALER AND OWNER PRIOR TO BIDDING, PURCHASE OR INSTALLATION. GENERAL CONTRACTOR SHALL FIELD VERIFY ALL DIMENSIONS PRIOR TO EQUIPMENT ROUGH-IN.

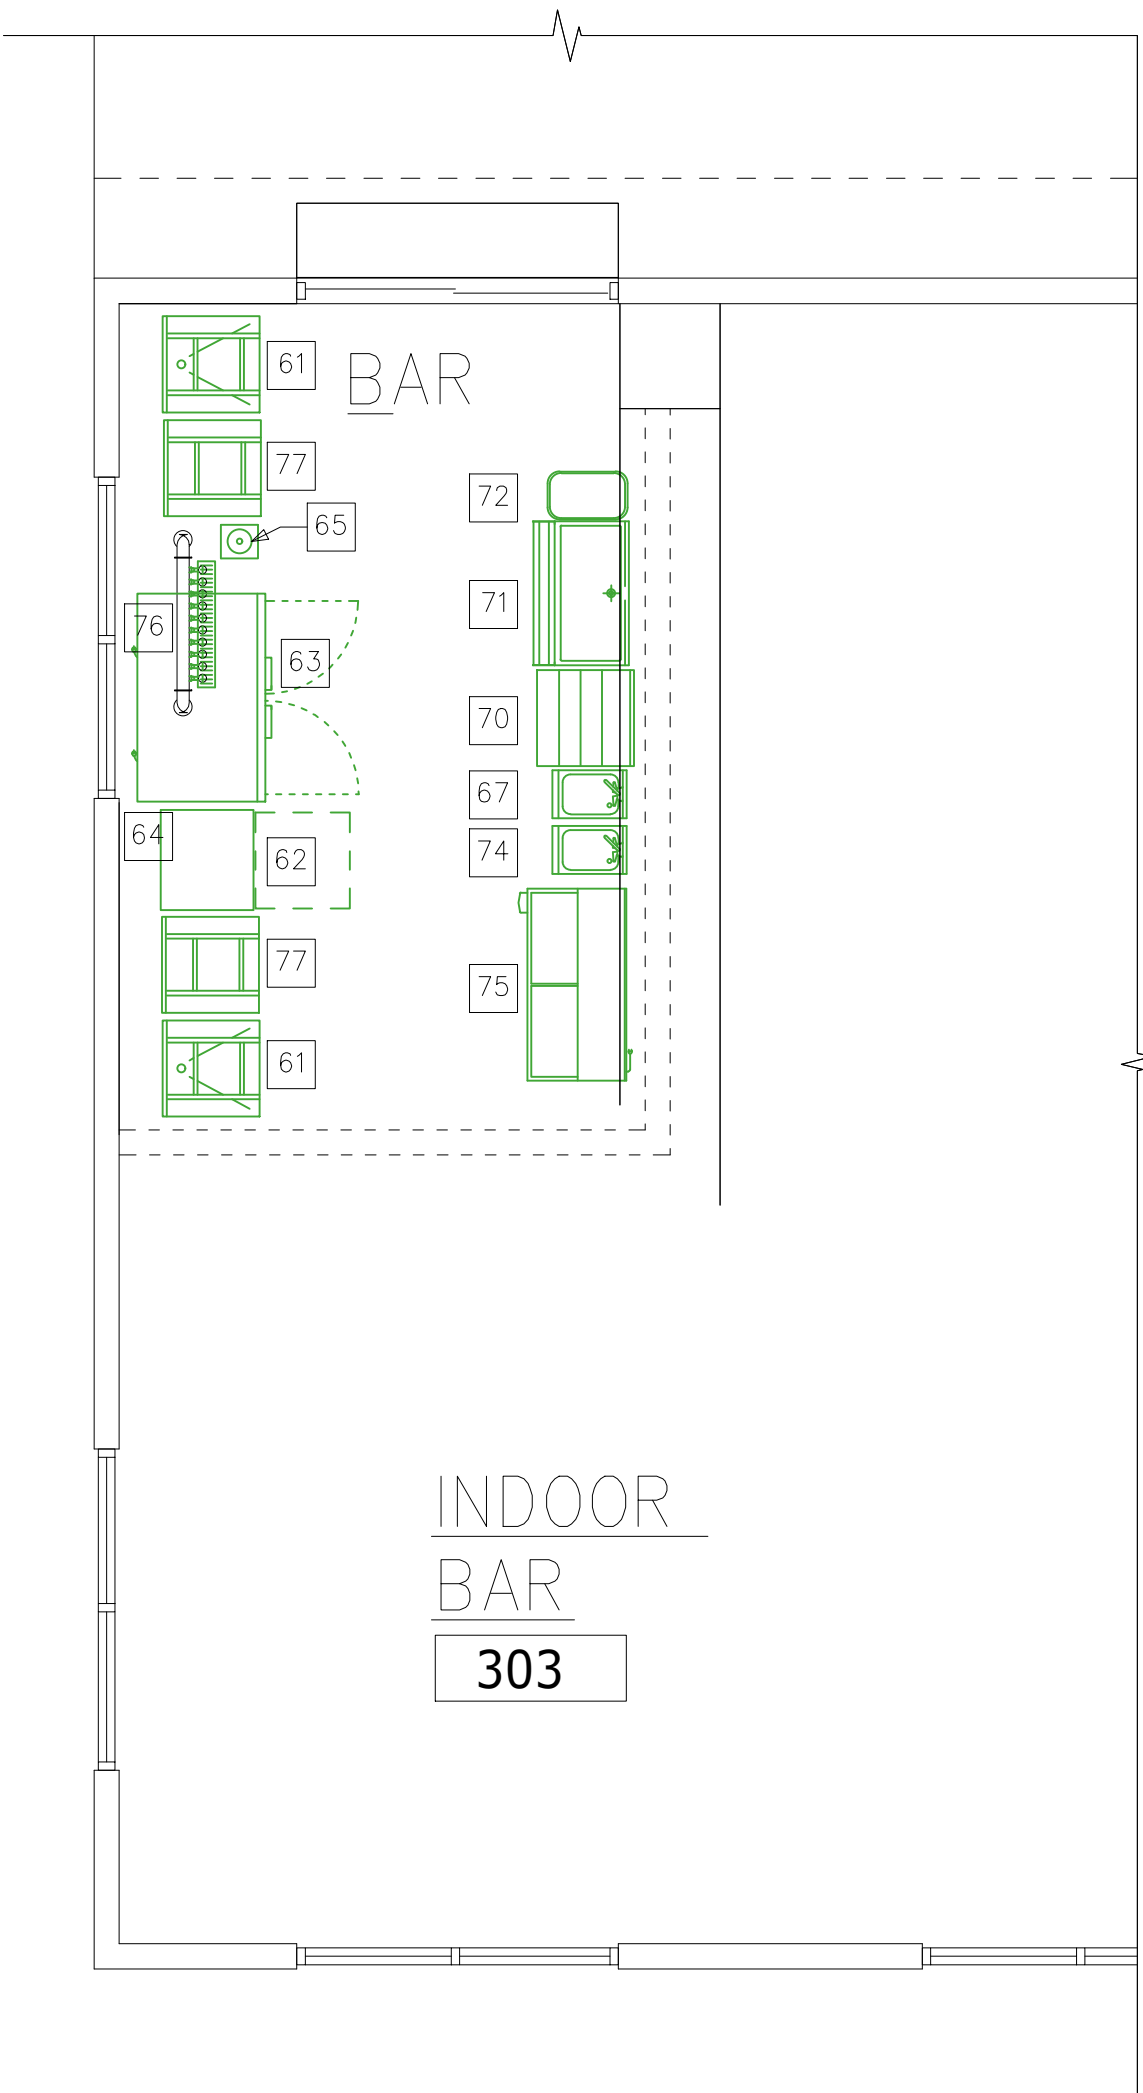

1
K-1.1

ROOF BAR PLAN

SCALE:
1/4"=1'-0"

Coastal
Architecture

- Architectural Design
- Planning
- Interiors

Member of the American
Institute of Architects

Lee D. Dixon, Jr., AIA
252-247-2121
lee@coastalarchitecture.net

4206 Bridges St. Ext.,
Morehead City, NC
28557
www.CoastalArchitecture.net

MOREHEAD CITY COUNTRY CLUB
CLUBHOUSE
MOREHEAD CITY, NORTH CAROLINA

ENLARGED BAR PLAN

20010

ISSUED: 01/29/21
DWG BY: MES
CKD BY: LDD

REVISIONS

SHEET NO.
K-1.1
OF