



ADD (3) NEW RECEPTACLE IN LOFT AS PER BD-3

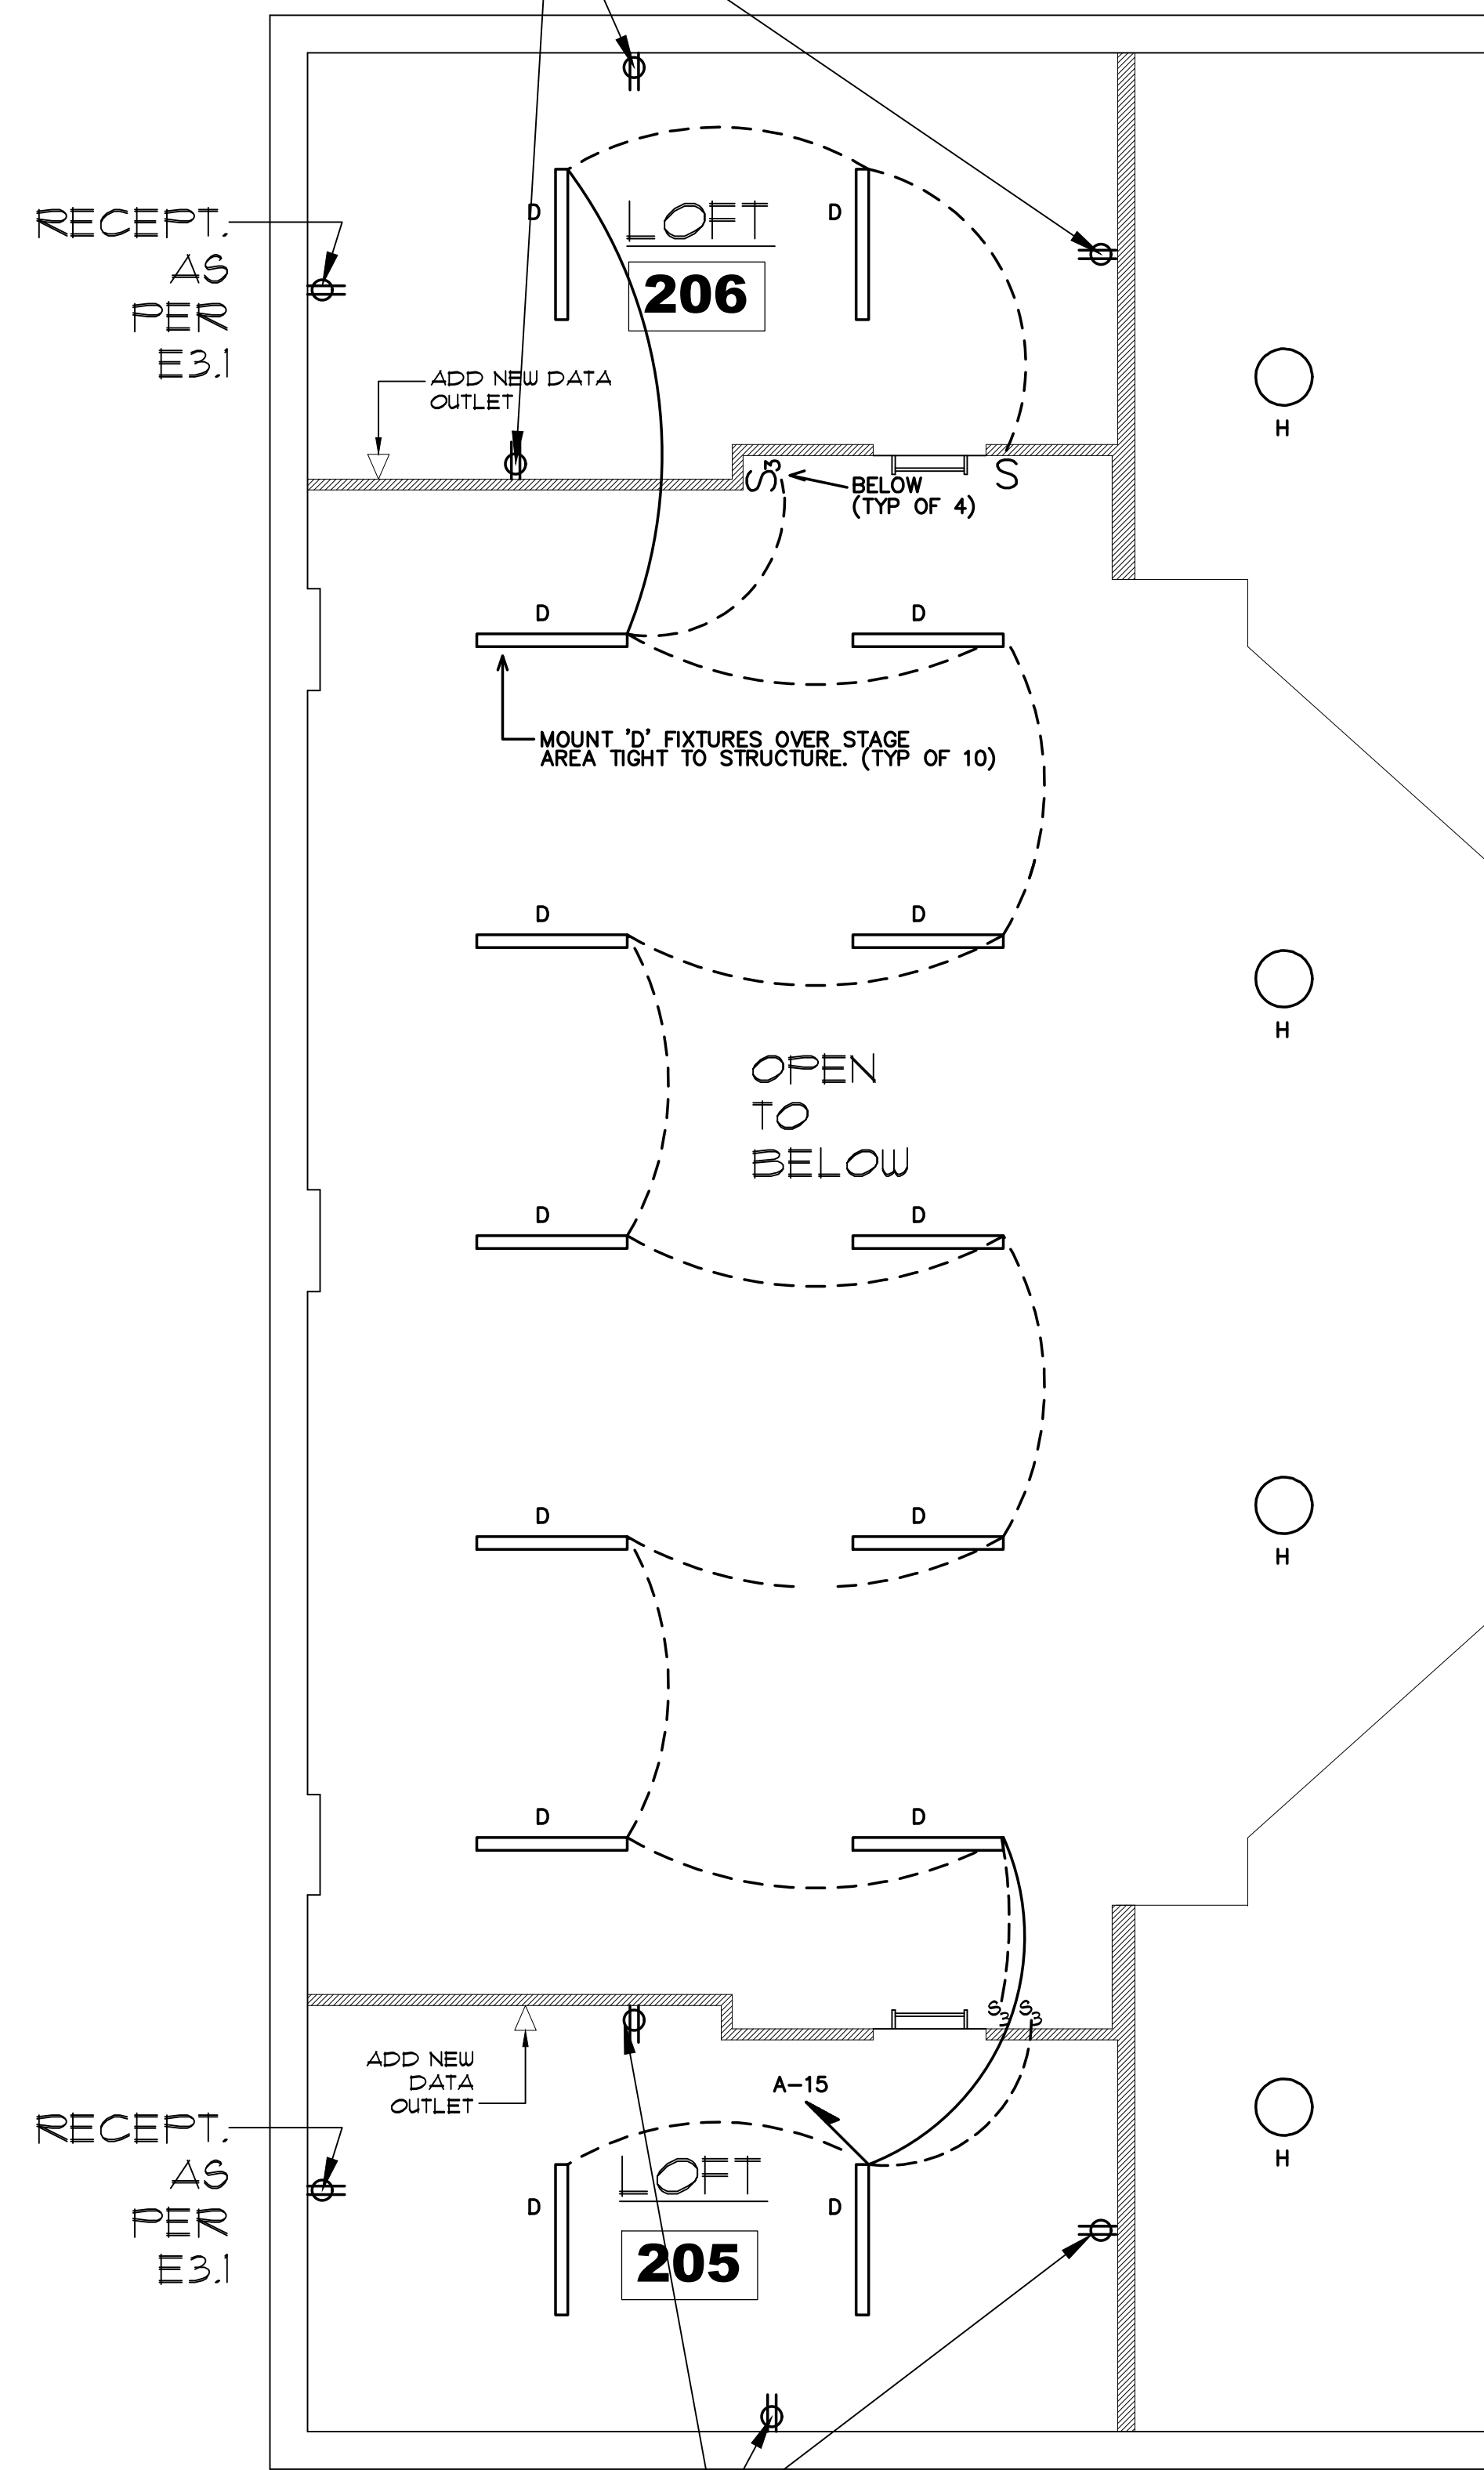


ADD (3) NEW RECEPTACLE IN LOFT AS PER BD-3

**2** REVISED STAGE LOFT PARTIAL ELECTRICAL PLAN  
 5D-32 SCALE: 1/4"=1'-0"

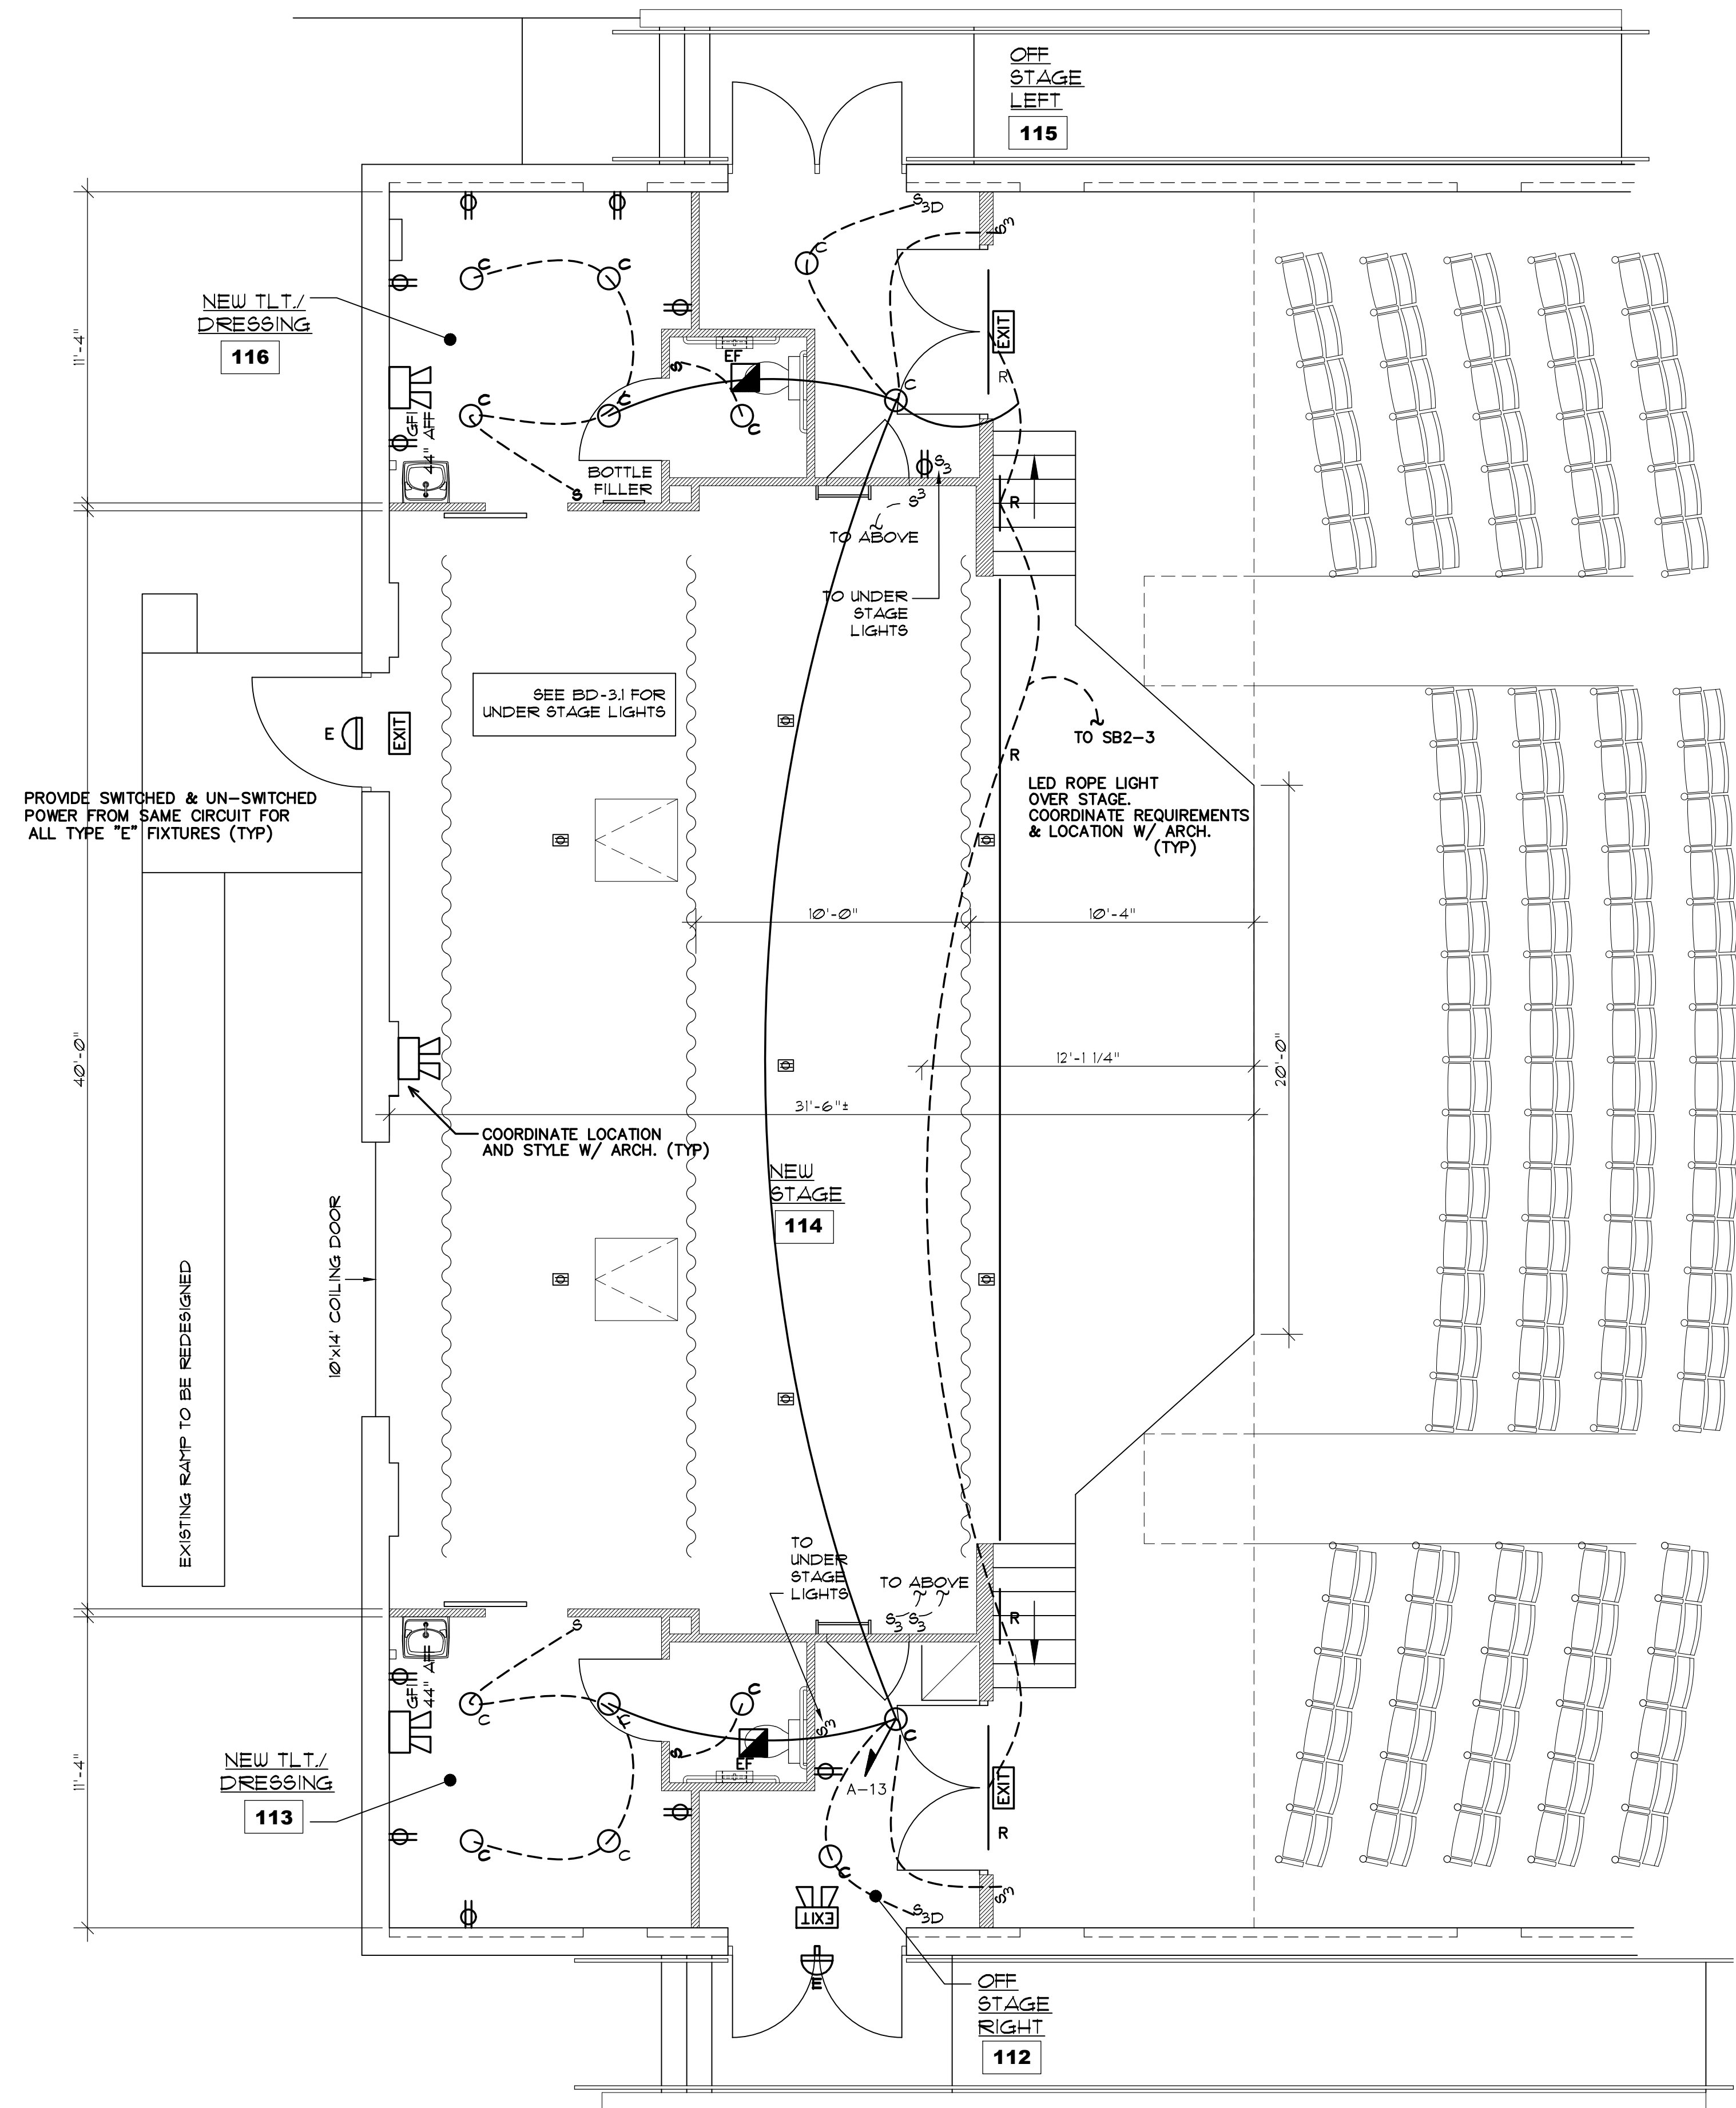

**1** REVISED STAGE FIRST FLOOR PARTIAL ELECTRICAL PLAN  
 5D-32 SCALE: 1/4"=1'-0"

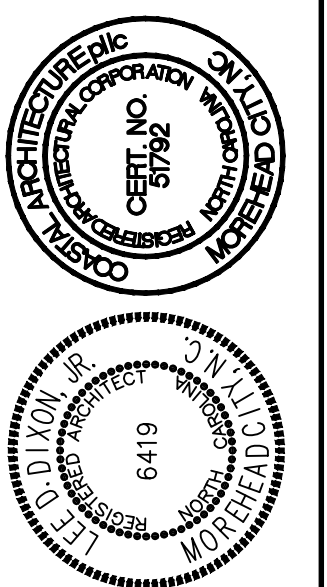

REVISED STAGE ELECTRICAL PLAN

**24034**

ISSUED: 11 DEC 24

DWG BY: SKC

CKD BY: LDD

REVISIONS

PERMIT 08/19/24

SHEET NO.

**BD-3.2**

OF