


COLUMBUS COUNTY
SHERIFF'S OFFICE
WHITEVILLE, NORTH CAROLINA

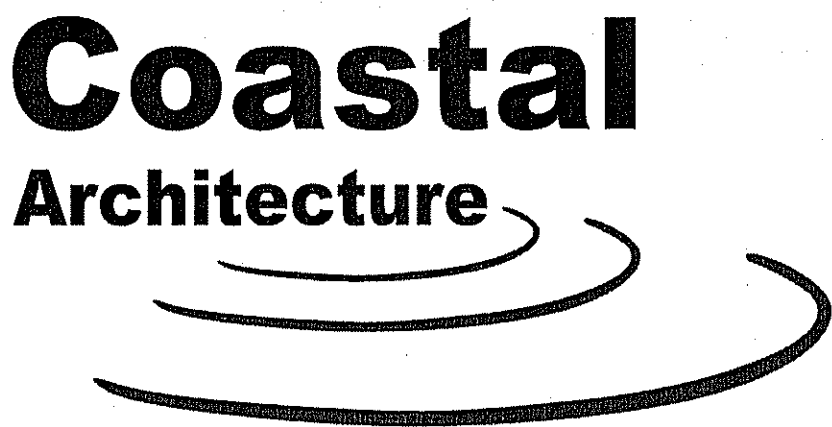

USE OF Coastal Architecture, DRAWINGS, SPECIFICATIONS AND OTHER DOCUMENTS
The Drawings, Specifications and other documents prepared by Coastal Architecture, the Designer, for this project are instruments of service for use solely with respect to this project and, unless otherwise provided, the Designer shall be deemed the author of these documents and shall retain all common law, statutory and other reserved rights, including copyright protection. The Owner shall be permitted to retain copies of the Designer's drawings, Specifications, and other documents for information and reference in connection with the Owner's use and occupancy of this project. No portions in part or in whole of the Drawings, Specifications and other documents shall be duplicated or used by the Owner or others for additions to this Project, completion of this Project by others, or on other Projects without written consent by the Designer.

THESE DRAWING AND SPECIFICATIONS REPRESENT AN INSTRUMENT OF SERVICE AND AS SUCH SHALL REMAIN IN OWNERSHIP WITH THE ARCHITECT. USE OR REPRODUCTION BY ANY MEANS, IN WHOLE OR IN PART, WITHOUT THE ARCHITECT'S WRITTEN CONSENT, IS PROHIBITED.

DRAWING LIST

CS-1	COVER SHEET
G-1	GENERAL DATA
G-2	LIFE SAFETY PLAN
G-3	U.L. DETAILS
G-4	COMCHECK
△ C-1	COVER SHEET
C-2	EXISTING CONDITIONS AND DEMOLITION PLAN
C-3	SITE PLAN
C-4	UTILITY PLAN
C-5	GRADING PLAN
C-6	LANDSCAPE PLAN
C-7	PROPOSED IMPERVIOUS BREAKDOWN PLAN
C-8	DETAILS
A-1	FLOOR PLAN
A-1.1	ROOF PLAN
A-2	REFLECTED CEILING PLAN
A-3	DOOR, WINDOW, AND ROOM FINISH SCHEDULES
A-3.1	DOOR AND WINDOW ELEVATIONS
A-4	EXTERIOR ELEVATIONS
A-5	BUILDING SECTIONS
A-5.1	WALL SECTIONS
A-5.2	WALL SECTIONS
A-5.3	WALL SECTIONS
A-5.4	WALL SECTIONS
A-6	ENLARGED PLANS
A-7	INTERIOR ELEVATIONS
A-8	DETAILS
SK-1.1	PEMB FOOTINGS
P-1	PLUMBING SPECIFICATIONS
P-2	DWV PLAN
P-3	WATER PLAN
P-4	NATURAL GAS
P-5	DWV/ WATER RISERS
P-6	NATURAL GAS RISER
P-7	EXISTING BUILDING- NATURAL GAS PLAN
M-1	HVAC SCHEDULES
M-2	HVAC PLAN
M-3	HVAC SPECIFICATIONS & DETAILS
E-1	ELECTRICAL SPECS
E-2	LIGHTING PLAN
E-3	POWER PLAN
E-4	PANELS & RISER
FA-1	FIRE ALARM NOTES/ RISER
FA-2	FIRE ALARM PLAN

Coastal
Architecture

• Architectural
Design

• Planning

• Interiors

AIA


Member of the American
Institute of Architects

Lee D. Dixon, Jr., AIA
252-247-2127
lee@coastalarchitecture.net

4206 Bridges St. Ext.,
Suite C
Morehead City, NC
28557

www.CoastalArchitecture.net

COLUMBUS COUNTY
SHERIFF'S OFFICE
WHITEVILLE, NORTH CAROLINA

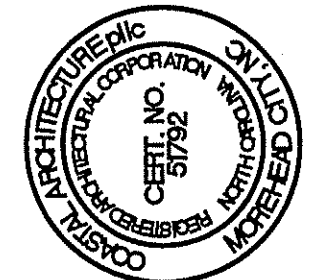

COVER SHEET

23029

ISSUED: 12.12.2024

DWG BY: MSG

CKD BY: LDD

REVISIONS

2	3.17.2025
---	-----------

SHEET NO.
CS-1
OF

(EXCEPT ONE- AND TWO-FAMILY DWELLINGS AND TOWNHOUSES)

CONTACT:					
DESIGNER	FIRM	NAME	LICENSE #	TELEPHONE #	E-MAIL
Architectural	Coastal Architecture	Lee Dixon	6419	(252) 247-2127	lee@coastalarchitecture.net
Civil				()	()
Electrical	Burke Design Group	Ben Burke	22038	(919) 771-1916	benburke@nc.rr.com
				()	()
Fire Alarm	Burke Design Group	Ben Burke	22038	(919) 771-1916	benburke@nc.rr.com
Humbing				()	()
Mechanical	Burke Design Group	Ben Burke	22038	(919) 771-1916	benburke@nc.rr.com
				()	()
Sprinkler-Standards				()	()
Structural	FDR	Heath Hendrick		(919) 427-0501	HHendrick@fdr-eng.com
Retaining Walls > 5 feet High				()	()
Other				()	()

(*) Other should include firms and individuals such as truss, precast, pre-engineered, interior designers, etc.)

CONSTRUCTED: (date) _____ CURRENT USE(S) (Ch. 3): B, S-1, A-3
 RENOVATED: (date) _____ PROPOSED USE(S) (Ch. 3): B, S-1, A-3
 OCCUPANCY CATEGORY (Table 1604.5): Current: B, S-1, A-3 RISK CATEGORY: IV 

Floor	Existing (sq ft)	New (sq ft)	Subtotal
3rd Floor			
2nd Floor			
Mezzanine			
1st Floor	10,500	20,450	30,950
Basement			
TOTAL		20,450	30,950

Floors slab on grade

Description of assembly: _____

U-Value of total assembly: _____

R-Value of insulation: _____

Horizontal/vertical requirement: _____

slab heated: _____

Pile size, type, and capacity _____

SIGN LOCATION
TO BE FIELD VERIFIED
W/ ARCHITECT

THESE DRAWING AND SPECIFICATIONS REPRESENT AN INSTRUMENT OF SERVICE AND AS SUCH SHALL REMAIN IN OWNERSHIP WITH THE ARCHITECT. USE OR REPRODUCTION BY ANY MEANS, IN WHOLE OR IN PART, WITHOUT THE ARCHITECT'S WRITTEN CONSENT, IS PROHIBITED.

www.CoastalArchitecture.net

**COLUMBUS COUNTY
SHERIFF'S OFFICE
WHITEVILLE, NORTH CAROLINA**



OF

	3 5/8" METAL STUDS @ 16" O.C. INTERIOR W/ 5/8" GWB EACH SIDE FROM FLOOR TO 6" ABOVE CEILING (TYP) NON LOADBEARING WALL WITH SOUND INSULATION		8" CMU (2 HR RATED) NON LOADBEARING WALL FROM FLOOR TO ROOF DECK ABOVE (TYP.) AND 3 5/8" METAL STUDS @ 16" O.C. INTERIOR NON LOADBEARING WALL FROM FLOOR TO ROOF DECK ABOVE (TYP.) W/ 5/8" GWB ON OFFICE OR HALL SIDE WITH SOUND INSULATION
	3 5/8" METAL STUDS @ 16" O.C. INTERIOR W/ 5/8" GWB EACH SIDE FROM FLOOR TO ROOF DECK (TYP) NON LOADBEARING WALL WITH SOUND INSULATION		(2HR-RATED) 3 5/8" METAL STUDS @ 16" O.C. INTERIOR W/ 2X 5/8" GWB EACH SIDE FROM FLOOR TO 8" ABOVE CEILING (TYP) NON LOADBEARING WALL WITH SOUND INSULATION
	3 5/8" METAL STUDS @ 16" O.C. INTERIOR W/ 5/8" SOUNDBREAK GWB EACH SIDE FROM FLOOR TO ROOF DECK (TYP) NON LOADBEARING WALL WITH SOUND INSULATION		(2HR-RATED) 3 5/8" METAL STUDS @ 16" O.C. INTERIOR W/ 2X 5/8" GWB EACH SIDE FROM FLOOR TO ROOF DECK (TYP) NON LOADBEARING WALL WITH SOUND INSULATION
	6" METAL STUDS @ 16" O.C. INTERIOR W/ 5/8" GWB EACH SIDE FROM FLOOR TO 6" ABOVE CLG. (TYP) NON LOADBEARING WALL WITH SOUND INSULATION		(2HR-RATED) 6" METAL STUDS @ 16" O.C. INTERIOR W/ 2X 5/8" SOUNDBREAK GWB EACH SIDE FROM FLOOR TO ROOF DECK (TYP) NON LOADBEARING WALL WITH SOUND INSULATION
	6" METAL STUDS @ 16" O.C. INTERIOR W/ 5/8" GWB EACH SIDE FROM FLOOR TO ROOF DECK (TYP) NON LOADBEARING WALL WITH SOUND INSULATION		(2HR-RATED) 6" METAL STUDS @ 16" O.C. INTERIOR W/ 2X 5/8" GWB EACH SIDE FROM FLOOR TO ROOF DECK (TYP) NON LOADBEARING WALL WITH SOUND INSULATION
	8" CMU NON LOADBEARING WALL FROM FLOOR TO ROOF DECK ABOVE (TYP.)		

B = BUSINESS

A-3 = ASSEMBLY

S-1 = STORAGE

FE = FIRE EXTINGUISHER ON STANDARD HOOK
 F.E.C. = FIRE EXTINGUISHER AND CABINET
 LARSEN SEMI-RECESSED FS 2409-R3
 BRUSHED CHROME W/ MP5 FIRE EXTINGUISHER

2 HR RATED WALL (U.L. U906)

* 90 MINUTE RATED GLAZING AND FRAMES

90 MINUTE RATED DOOR AND FRAMES



(34.25") CLEAR EXIT WIDTH

68.5

○

(X) =EXIT

K.B. =KNOX BOX, FIRE DEPARTMENT KEY LOCK BOX


R.B. CONFIRM LOCATION W/ FIRE DEPARTMENT

P.H. PANIC HARDWARE

PROPERTY LINE > 30'

NO LIMIT OF OPENING

 = EMERGENCY LIGHT- REFER TO ELECTRICAL DRAWINGS

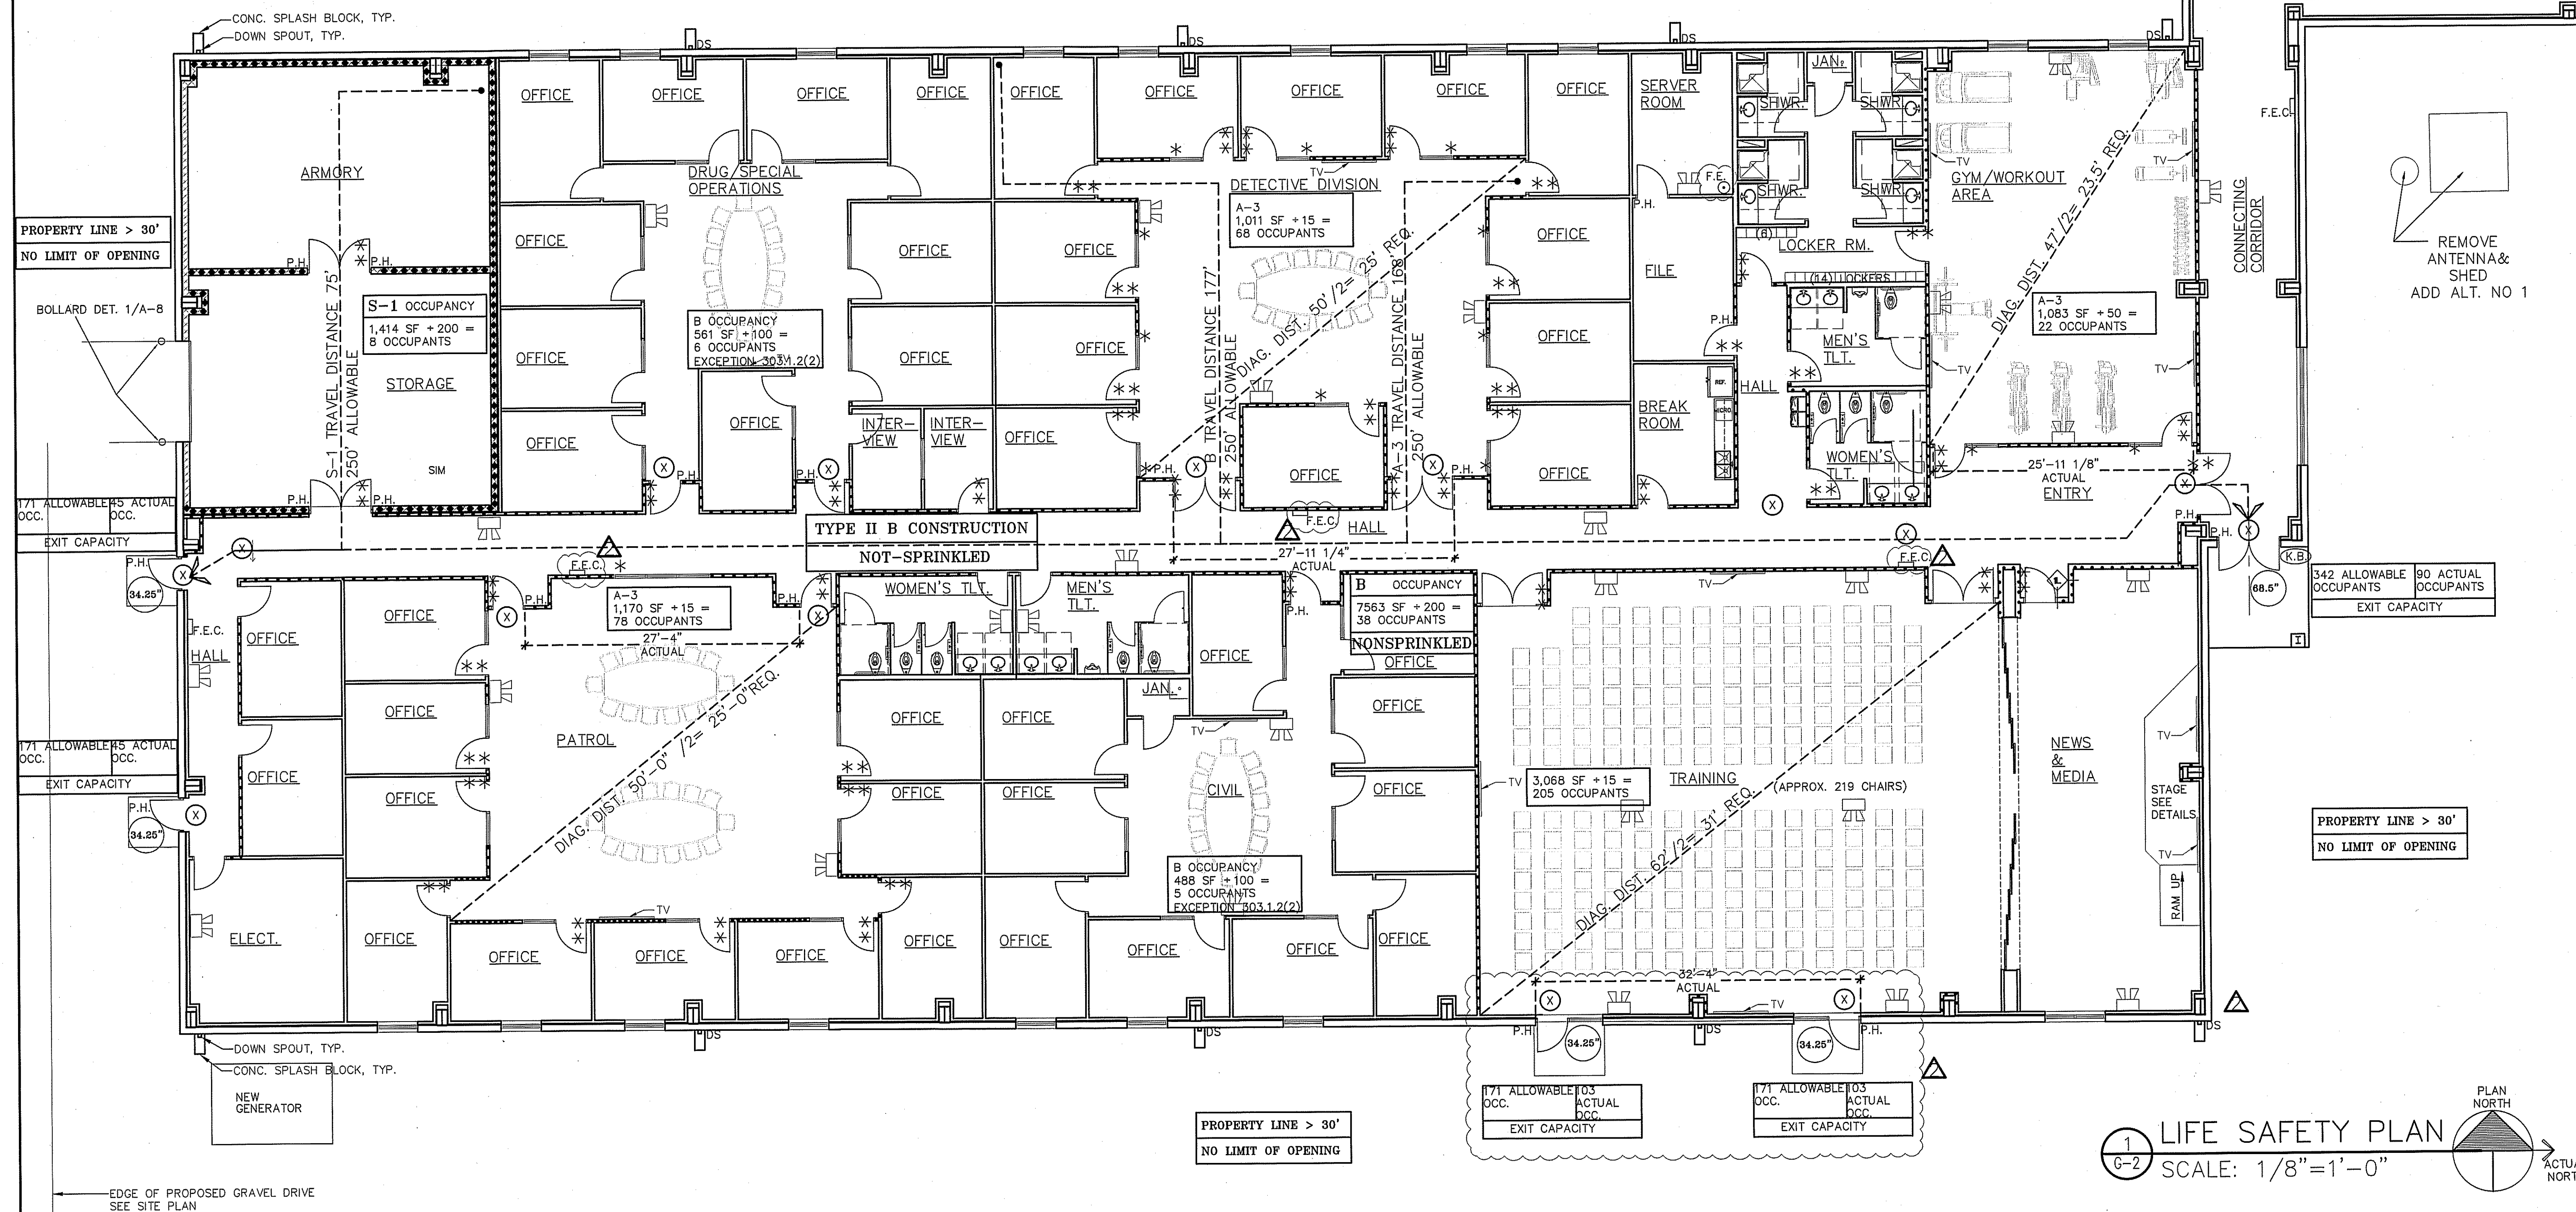

- **Architectural Design**
- **Planning**
- **Interiors**





Lee D. Dixon, Jr., AIA
252-247-2127
lee@coastalarchitecture.net

4206 Bridges St. Ext.

**Suite C
Morehead City, NC
28557**

www.CoastalArchitecture.net

**COLUMBUS COUNTY
SHERIFF'S OFFICE
WHITEVILLE, NORTH CAROLINA**

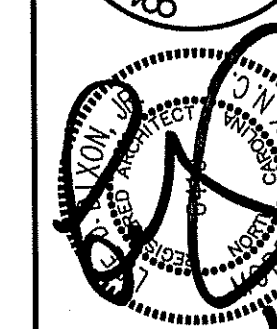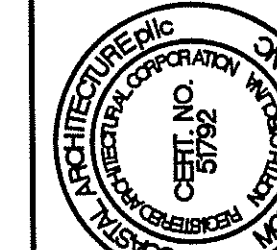

LIFE SAFETY PLAN

23029

ISSUED: 12.12.2024

DWG BY: CRF

CKD BY: LDD

REVISIONS	
01	03 / 19 / 20

01	02/18/20
02	03/17/20


QUAL	SHEET NO
------	----------



G-2

OF


DESIGN NO. UL U419
FIRE RATING: 2 HOURS
STC RATING: 55
SOUND TEST: UG5-10000
SYSTEM THICKNESS: 6-10" (153 MM)
LOCATION: INTERIOR
FRAMING TYPE: STEEL STUD (NON-LOAD BEARING)

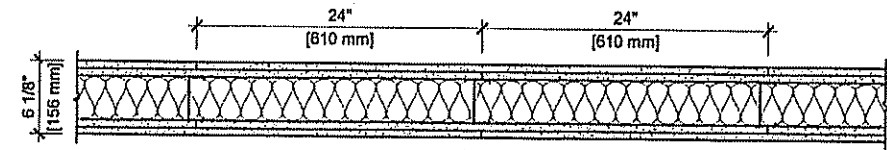


ASSEMBLY REQUIREMENTS:

GYPSUM PANELS: TWO LAYERS 5/8" (15.9 MM) SHEETROCK® GYPSUM PANEL (UL TYPE SCX)
STEEL STUDS: 4-7/8" (124 MM) STEEL STUD, EDS (2019), 24" (610 MM) O.C.
INSULATION: 3-1/2" (89 MM) FIBERGLASS INSULATION
GYPSUM PANELS: TWO LAYERS 5/8" (15.9 MM) SHEETROCK® GYPSUM PANEL (UL TYPE SCX)

 - GENERAL WALL NOTES:**
1. REFER TO APPLICABLE CODES REQUIREMENTS TO ENSURE COMPLIANCE PRIOR TO CONSTRUCTION.
 2. FOR THE MOST UP-TO-DATE DETAILS, INCLUDING CONSTRUCTION VARIATIONS, REFER TO THE PUBLISHED DESIGN.
 3. WHERE DESIGN NO. INDICATES "REF", THE FIRE RATING IS BASED ON LABORATORY TEST DATA OF THE REFERENCED ASSEMBLY.
 4. STUD SIZES AND INSULATION THICKNESSES ARE MINIMUM UNLESS OTHERWISE STATED IN THE PUBLISHED ASSEMBLY.
 5. STUD AND FASTENER SPACINGS ARE MINIMUM UNLESS OTHERWISE STATED IN THE PUBLISHED ASSEMBLY.
 6. PANEL ORIENTATION SHALL BE AS SPECIFIED IN THE PUBLISHED DESIGN.
 7. FIRE RATINGS ARE FROM BOTH SIDES UNLESS OTHERWISE STATED.
 8. PRE-RATINGS ARE MAINTAINED WITH ONE OR MORE OF THE FOLLOWING MODIFICATIONS: INCREASE STUD DEPTH, INCREASE STUD MATERIAL THICKNESS, DECREASE STUD SPACING, DECREASE FASTENER SPACING, INCREASE INSULATION THICKNESS UP TO CAVITY DEPTH.
 9. WHERE ACoustICAL PERFORMANCE IS PROVIDED IN AN ESTIMATED RANGE, THE VALUES ARE BASED ON LABORATORY TEST DATA OF SIMILARLY CONSTRUCTED ASSEMBLIES.
 10. SOUND RATINGS ARE MAINTAINED WITH ONE OR MORE OF THE FOLLOWING MODIFICATIONS: INCREASE STUD DEPTH, DECREASE STUD MATERIAL THICKNESS, INCREASE STUD SPACING, INCREASE FASTENER SPACING, INCREASE INSULATION THICKNESS UP TO CAVITY DEPTH. MODIFICATIONS MUST NOT EXCEED LIMITATIONS OF FIRE RATING.




UL U419

 

SN-P-2-04


DESIGN NO. UL U419
FIRE RATING: 1 HOUR
STC RATING: 45
SOUND TEST: UG5-10042
SYSTEM THICKNESS: 4-10" (102 MM)
LOCATION: INTERIOR
FRAMING TYPE: STEEL STUD (NON-LOAD BEARING)

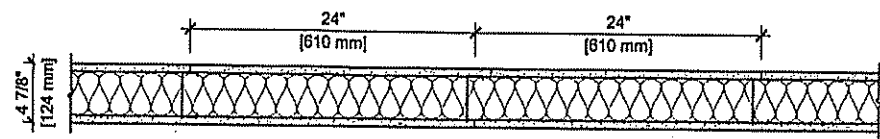


ASSEMBLY REQUIREMENTS:

GYPSUM PANELS: ONE LAYER 5/8" (15.9 MM) SHEETROCK® GYPSUM PANEL (UL TYPE SCX)
STEEL STUDS: 4-7/8" (124 MM) STEEL STUD, EDS (2019), 24" (610 MM) O.C.
INSULATION: 3-1/2" (89 MM) FIBERGLASS INSULATION
GYPSUM PANELS: ONE LAYER 5/8" (15.9 MM) SHEETROCK® GYPSUM PANEL (UL TYPE SCX)

 - GENERAL WALL NOTES:**
1. REFER TO APPLICABLE CODES REQUIREMENTS TO ENSURE COMPLIANCE PRIOR TO CONSTRUCTION.
 2. FOR THE MOST UP-TO-DATE DETAILS, INCLUDING CONSTRUCTION VARIATIONS, REFER TO THE PUBLISHED DESIGN.
 3. WHERE DESIGN NO. INDICATES "REF", THE FIRE RATING IS BASED ON LABORATORY TEST DATA OF THE REFERENCED ASSEMBLY.
 4. STUD SIZES AND INSULATION THICKNESSES ARE MINIMUM UNLESS OTHERWISE STATED IN THE PUBLISHED ASSEMBLY.
 5. STUD AND FASTENER SPACINGS ARE MINIMUM UNLESS OTHERWISE STATED IN THE PUBLISHED ASSEMBLY.
 6. PANEL ORIENTATION SHALL BE AS SPECIFIED IN THE PUBLISHED DESIGN.
 7. FIRE RATINGS ARE FROM BOTH SIDES UNLESS OTHERWISE STATED.
 8. PRE-RATINGS ARE MAINTAINED WITH ONE OR MORE OF THE FOLLOWING MODIFICATIONS: INCREASE STUD DEPTH, INCREASE STUD MATERIAL THICKNESS, DECREASE STUD SPACING, DECREASE FASTENER SPACING, INCREASE INSULATION THICKNESS UP TO CAVITY DEPTH.
 9. WHERE ACoustICAL PERFORMANCE IS PROVIDED IN AN ESTIMATED RANGE, THE VALUES ARE BASED ON LABORATORY TEST DATA OF SIMILARLY CONSTRUCTED ASSEMBLIES.
 10. SOUND RATINGS ARE MAINTAINED WITH ONE OR MORE OF THE FOLLOWING MODIFICATIONS: INCREASE STUD DEPTH, DECREASE STUD MATERIAL THICKNESS, INCREASE STUD SPACING, INCREASE FASTENER SPACING, INCREASE INSULATION THICKNESS UP TO CAVITY DEPTH. MODIFICATIONS MUST NOT EXCEED LIMITATIONS OF FIRE RATING.




UL U419

 

SN-P-1-02

UL FIRE RATED
Design No. U906

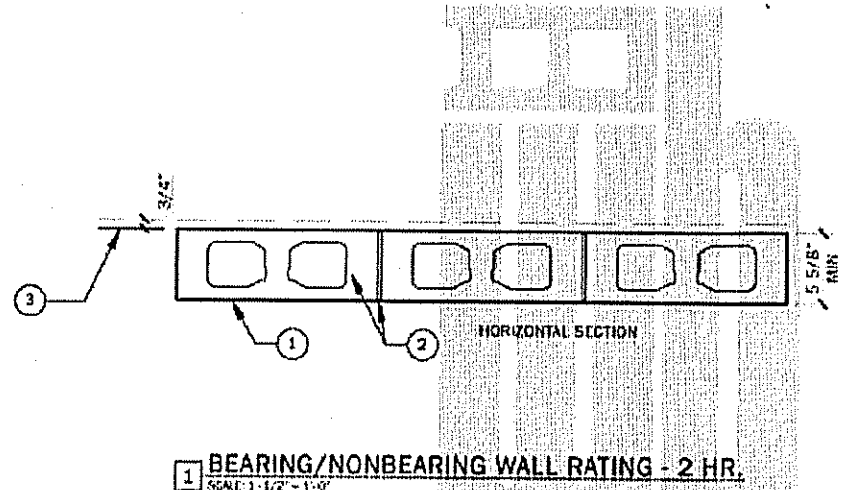

1. CONCRETE BLOCKS - Nominal 8 by 8 by 16 in., hollow or solid.
Classification D-2 (2 in.)
Anchor Concrete Products, Inc.
Florida Brick Industries, Inc.
Pike Industries Inc. d/b/a Ticon Whitcomb.
Whitcomb Concrete Block Co., Inc.
 2. MORTAR - Blocks laid in full bed of mortar, nom. 3/8 in. thick, of not less than 2 1/4 and not more than 3 1/2 parts of clean sharp sand to 1 part Portland cement (proportioned by volume) and not more than 50 percent hydrated lime (by cement volume). Vertical joints staggered.
 3. PORTLAND CEMENT STUCCO OR GYPSUM PLASTER - If used, add 1/2 in. to Classification. Attached to concrete blocks (Item 1).
 4. FORMER PLASTER - Optional - not stucco 1-1/2 in. thick min., 4 ft wide sheathing attached to concrete blocks (Item 1).
- Galco's Corp. - Type T-Mortar
*Bearing the UL Classification Marking

Coastal
Architecture

- Architectural Design
- Planning
- Interiors





Member of the American
Institute of Architects

Lee D. Dixon, Jr., AIA
202-247-2127
lee@coastalarchitecture.net

4206 Bridges St. Ext.,
Suite C
Morehead City, NC
28557

www.CoastalArchitecture.net

COLUMBUS COUNTY
SHERIFF'S OFFICE
WHITEVILLE, NORTH CAROLINA

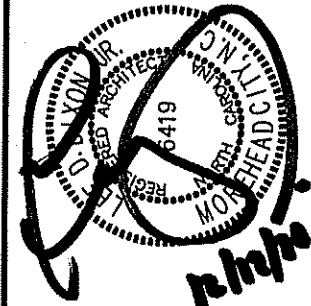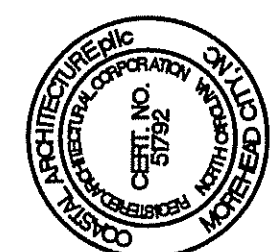

U.L. DETAILS

23029

ISSUED: 12.12.2024
DWG BY: CRF
CKD BY: LDD

REVISIONS

01	02/19/2025
02	03/18/2025

SHEET NO.

G-3
OF


WALL TYPE LEGEND

1A	3 5/8" METAL STUDS 16" O.C. INTERIOR W/ 5/8" GWB EACH SIDE FROM FLOOR TO 6" ABOVE CEILING (TYP) NON LOADBEARING WALL WITH SOUND INSULATION	1G	8" CMU (2 HR RATED) NON LOADBEARING WALL FROM FLOOR TO ROOF DECK ABOVE (TYP.) AND 3 5/8" METAL STUDS 16" O.C. INTERIOR NON LOADBEARING WALL FROM FLOOR TO ROOF DECK ABOVE (TYP.) W/ 5/8" GWB ON OFFICE OR HALL SIDE WITH SOUND INSULATION
1B	3 5/8" METAL STUDS 16" O.C. INTERIOR W/ 5/8" GWB EACH SIDE FROM FLOOR TO ROOF DECK (TYP) NON LOADBEARING WALL WITH SOUND INSULATION	1H	(2HR-RATED) 3 5/8" METAL STUDS 16" O.C. INTERIOR W/ 2X 5/8" GWB EACH SIDE FROM FLOOR TO 6" ABOVE CEILING (TYP) NON LOADBEARING WALL WITH SOUND INSULATION
1C	3 5/8" METAL STUDS 16" O.C. INTERIOR W/ 5/8" GWB EACH SIDE FROM FLOOR TO ROOF DECK (TYP) NON LOADBEARING WALL WITH SOUND INSULATION	1J	(2HR-RATED) 3 5/8" METAL STUDS 16" O.C. INTERIOR W/ 2X 5/8" GWB EACH SIDE FROM FLOOR TO ROOF DECK (TYP) NON LOADBEARING WALL WITH SOUND INSULATION
1D	6" METAL STUDS 16" O.C. INTERIOR W/ 5/8" GWB EACH SIDE FROM FLOOR TO 6" ABOVE CLG. (TYP) NON LOADBEARING WALL WITH SOUND INSULATION	1K	(2HR-RATED) 3 5/8" METAL STUDS 16" O.C. INTERIOR W/ 2X 5/8" GWB EACH SIDE FROM FLOOR TO ROOF DECK (TYP) NON LOADBEARING WALL WITH SOUND INSULATION
1E	6" METAL STUDS 16" O.C. INTERIOR W/ 5/8" GWB EACH SIDE FROM FLOOR TO ROOF DECK (TYP) NON LOADBEARING WALL WITH SOUND INSULATION	1L	(2HR-RATED) 3 5/8" METAL STUDS 16" O.C. INTERIOR W/ 2X 5/8" GWB EACH SIDE FROM FLOOR TO ROOF DECK (TYP) NON LOADBEARING WALL WITH SOUND INSULATION
1F	8" CMU NON LOADBEARING WALL FROM FLOOR TO ROOF DECK ABOVE (TYP.)		

* 90 MINUTE RATED GLAZING AND FRAMES
** 90 MINUTE RATED DOOR AND FRAMES

NOTE:

STENCIL RATED WALLS EVERY 15'-30" IN MIN. 2 INCH LETTERING, INDICATE PURPOSE OF WALL. PER 2018 NC BUILDING CODE, SECTION 703.7

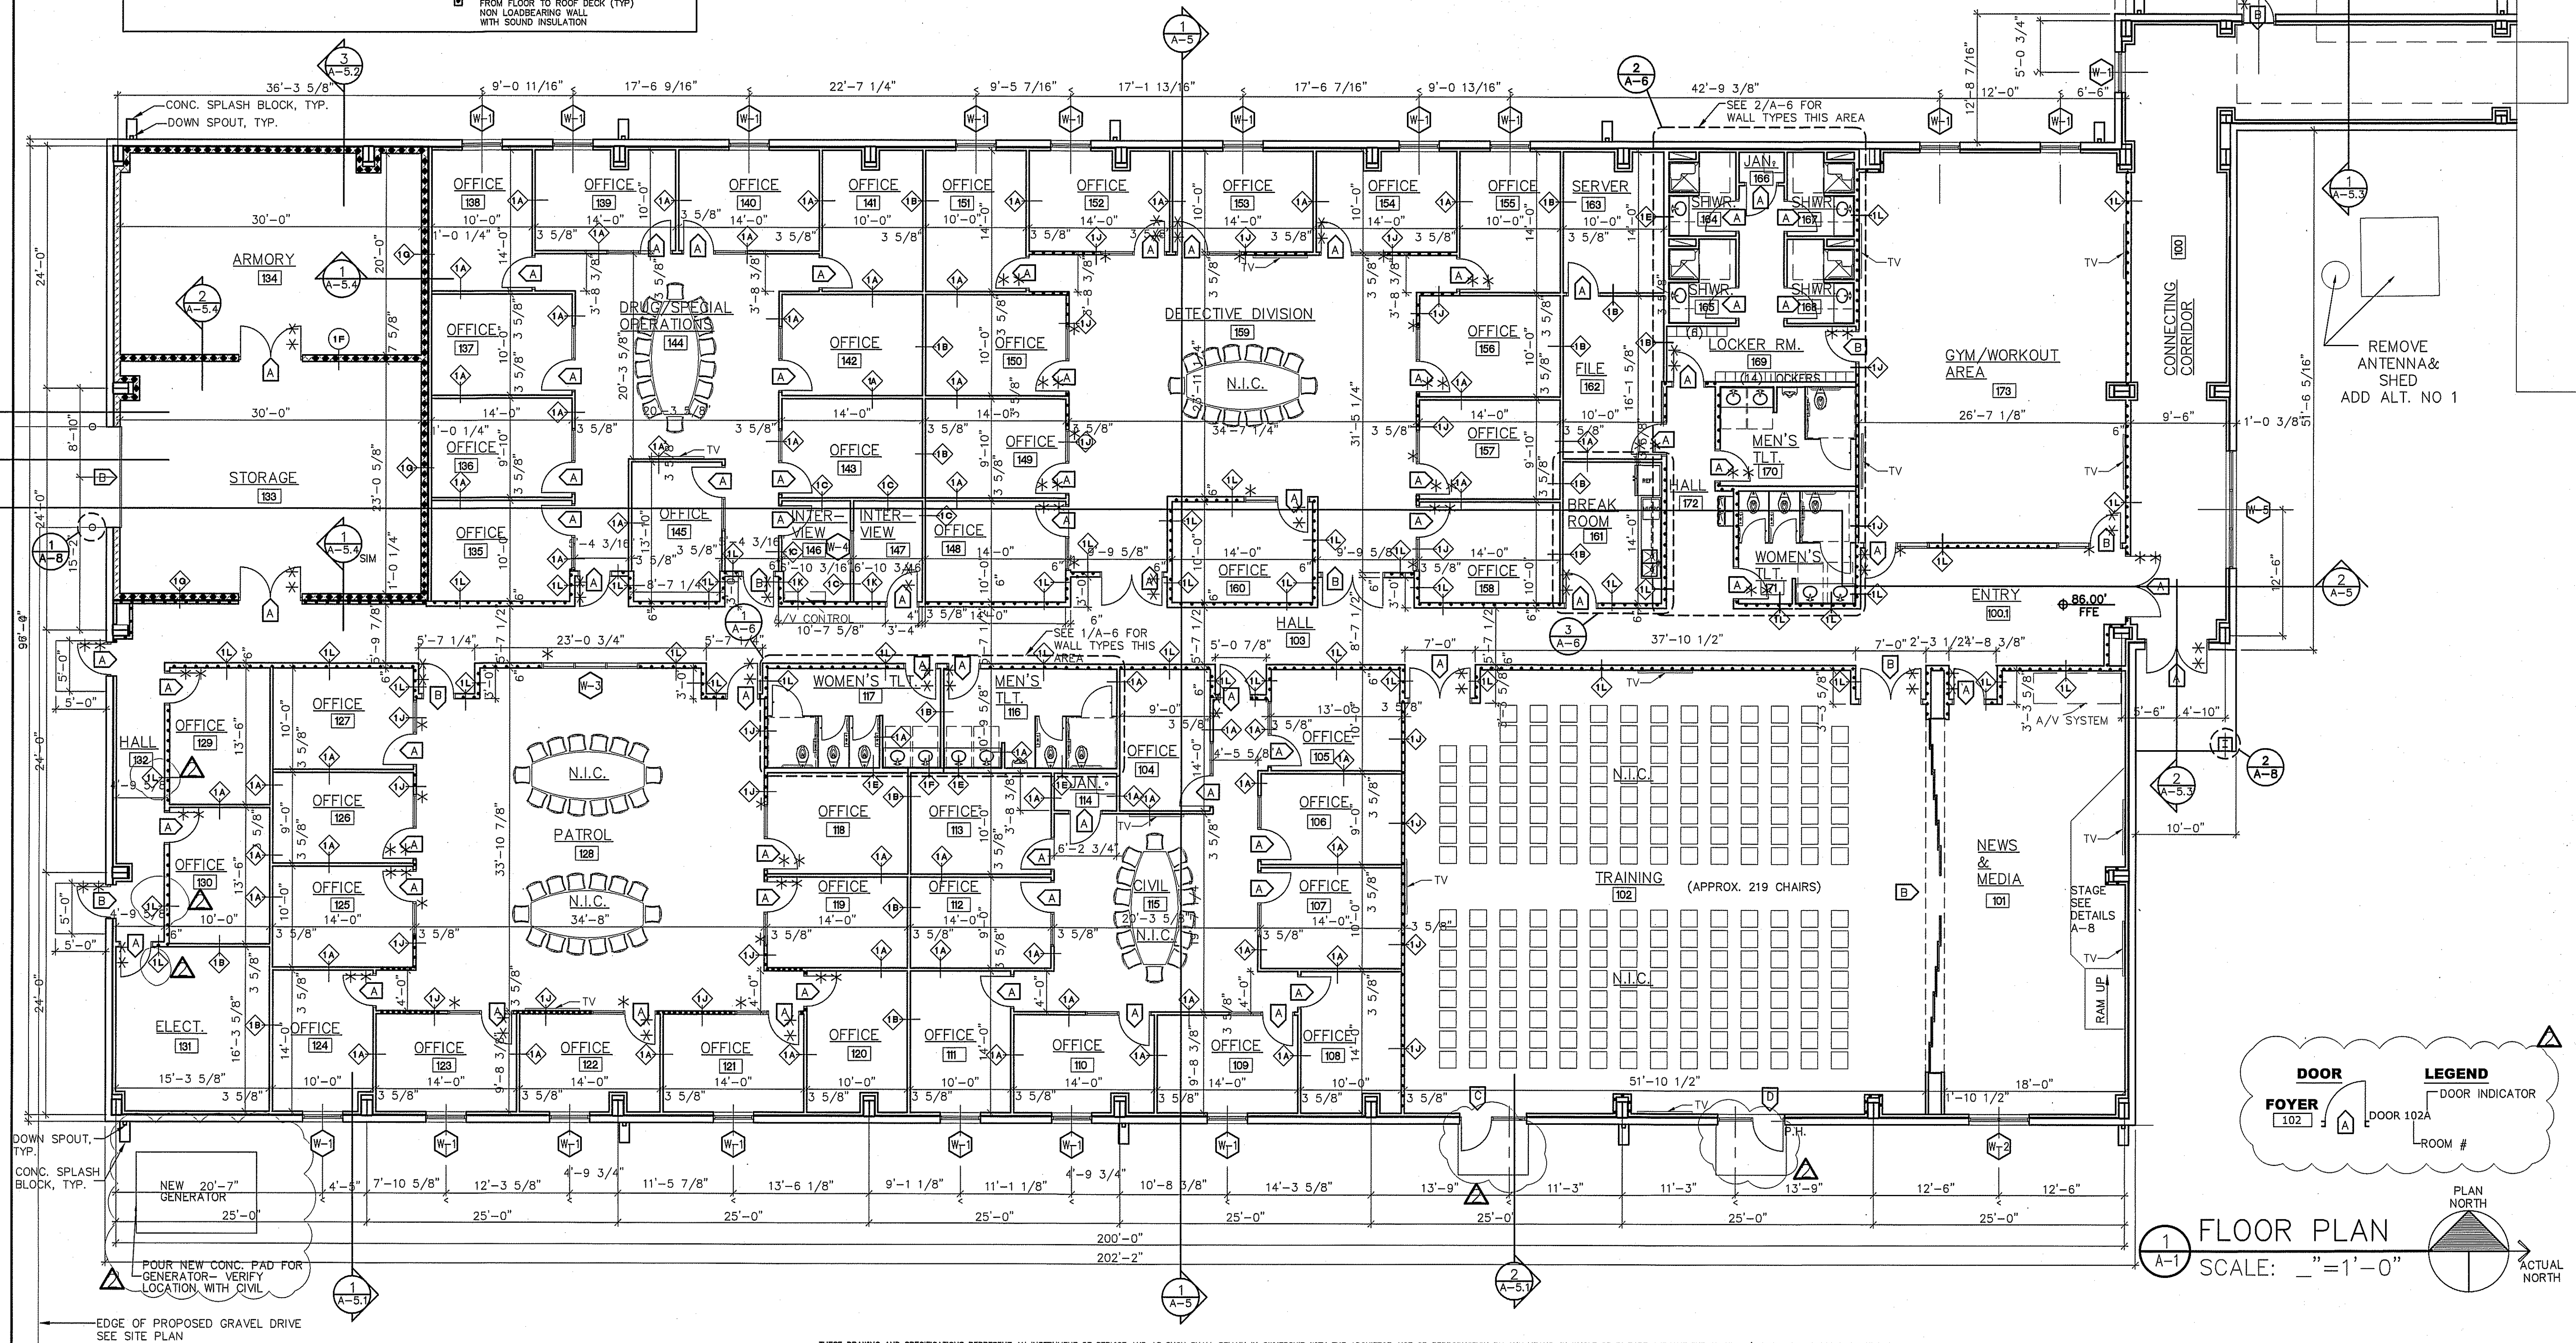

Coastal
Architecture

• Architectural
Design
• Planning
• Interiors





Member of the American
Institute of Architects

Lee D. Dixon, Jr., AIA
252-547-2127
lee@coastalarchitecture.net

4206 Bridges St. Ext.,
Suite C
Morehead City, NC
28557

www.CoastalArchitecture.net

COLUMBUS COUNTY
SHERIFF'S OFFICE
WHITEVILLE, NORTH CAROLINA

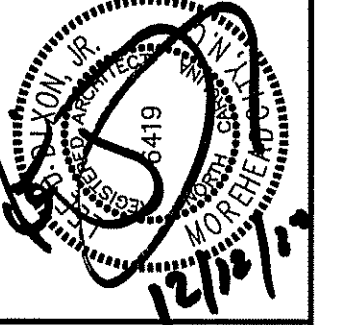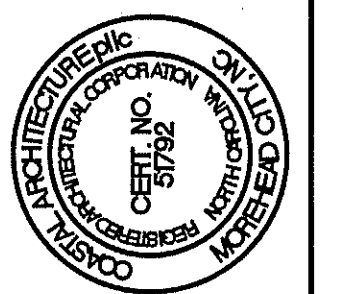

FLOOR PLAN

23029

ISSUED: 12.12.2024

DWG BY: MSG

CKD BY: LDD

REVISIONS



02 03/17/2025

SHEET NO.

A-1

OF

COLUMBUS COUNTY
SHERIFF'S OFFICE
WHITEVILLE, NORTH CAROLINA

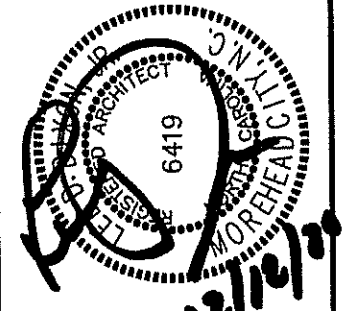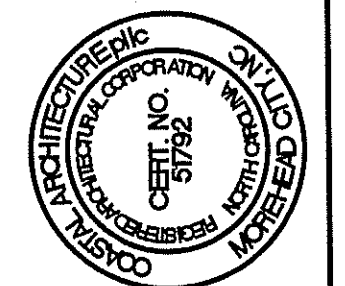


ROOF PLAN

23029


ISSUED: 12.12.2024
DWG BY: MSG
CKD BY: LDD
REVISIONS

SHEET NO.
A-1.1
OF

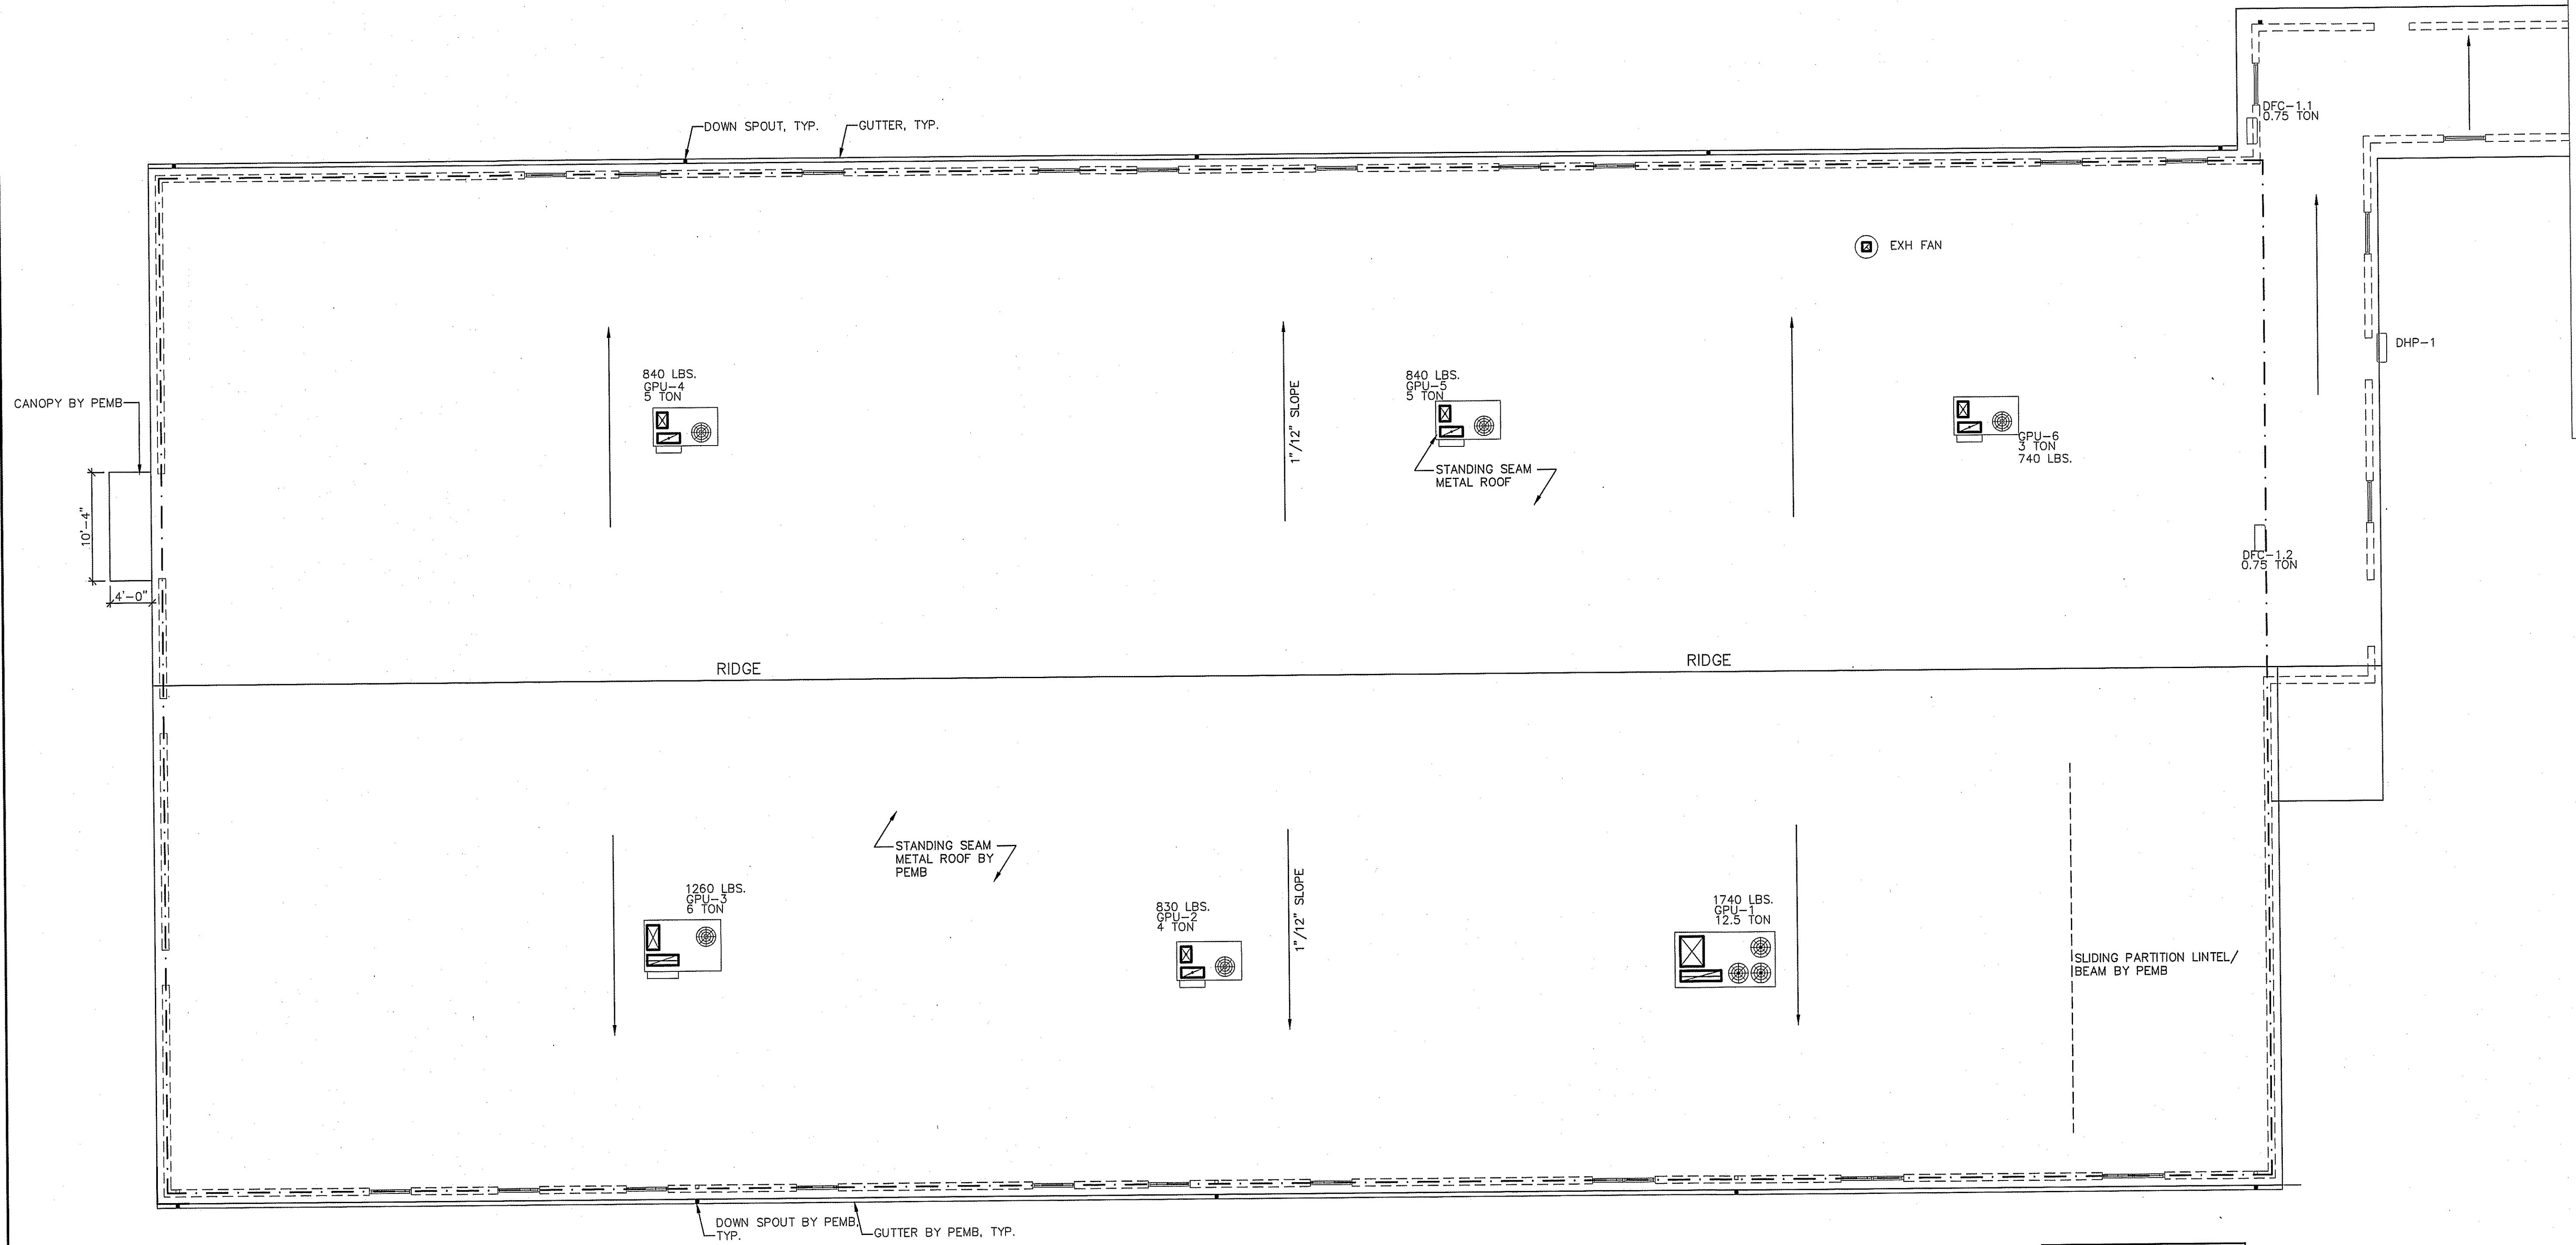

GUTTER AND DOWNSPOUT
DESIGN BY PEMB

1
A-1.1
ROOF PLAN
SCALE: 1/8"=1'-0"

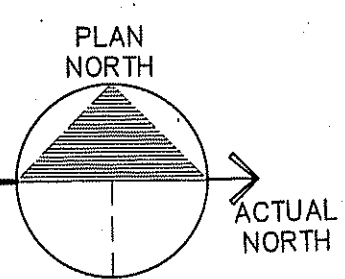


LEGEND:

- C = SECURITY CAMERA
 F = CARD SWIPE/ FOB
 TV = WALL MOUNT TV
 [X] CEILING LIGHT - SEE ELECTRICAL
 [X] RETURN- SEE ELECTRICAL
 [X] DIFFUSER- SEE ELECTRICAL
 — HANGING LIGHT- SEE ELECTRICAL


GENERAL NOTE:

REFER TO ELECTRICAL AND MECHANICAL FOR EXACT LOCATION AND TYPE. TYP.

WITH SOUND INSULATION

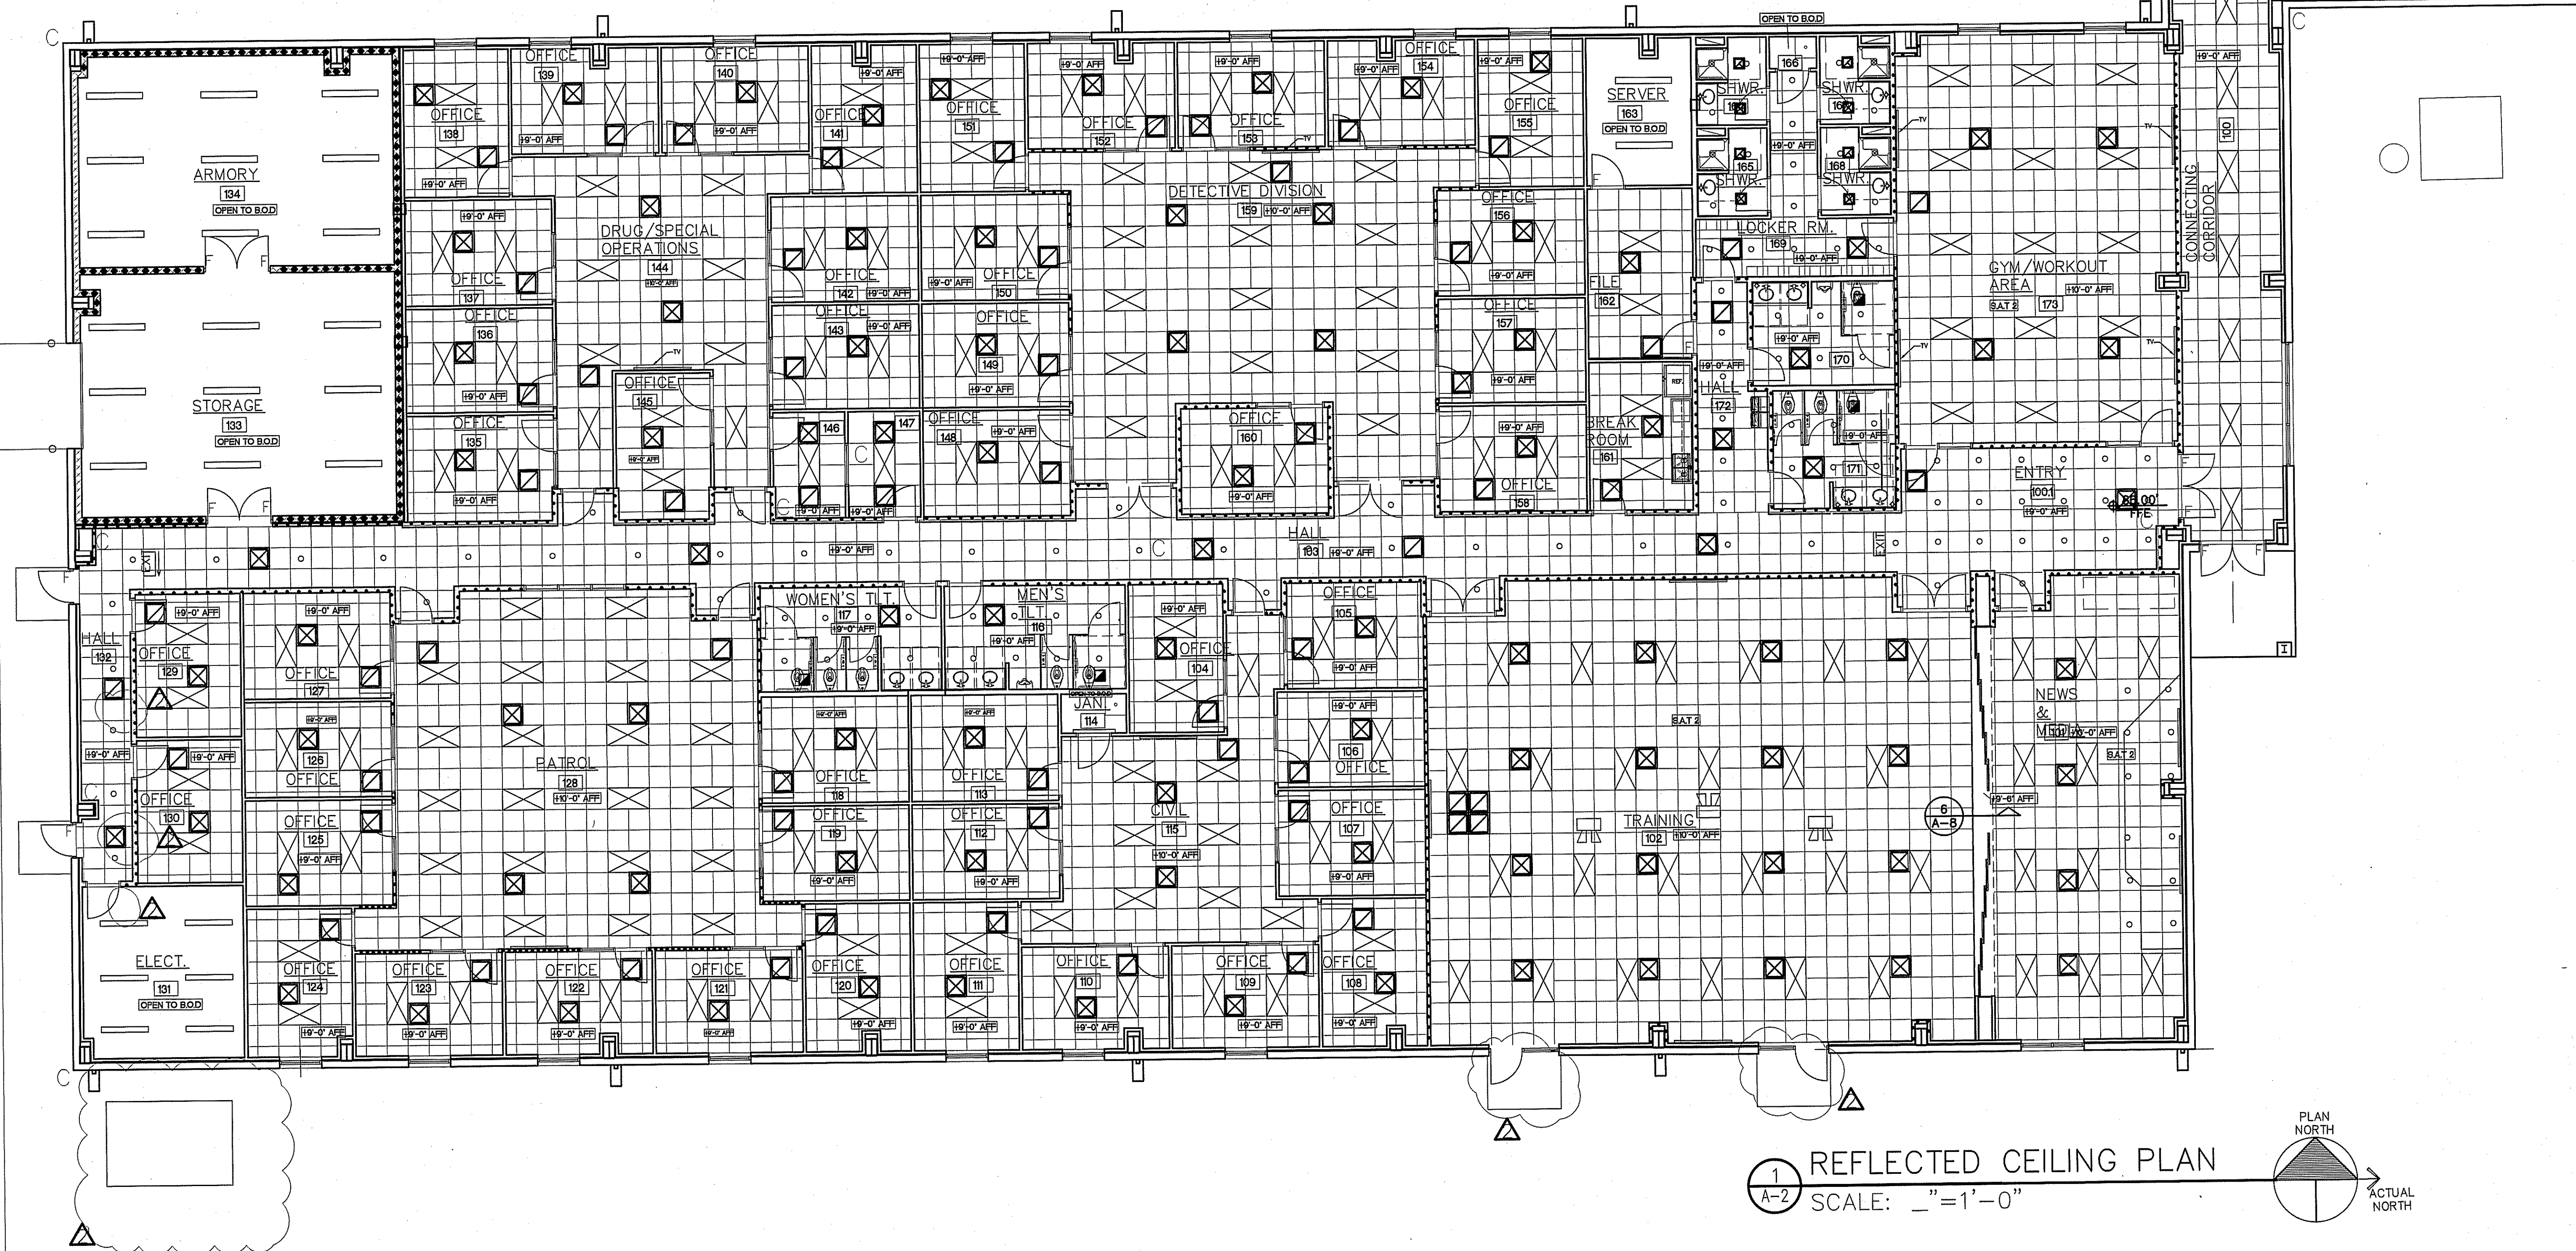

1 REFLECTED CEILING PLAN
 A-2 SCALE: 1/8" = 1'-0"

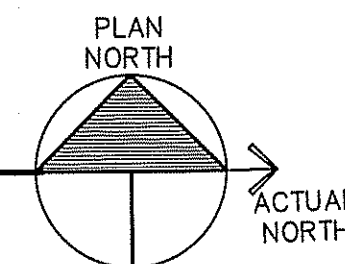

Coastal
 Architecture

- Architectural Design
- Planning
- Interiors





Member of the American Institute of Architects

Lee D. Dixon, Jr., AIA
 252-247-2127
 lee@coastalarchitecture.net

4206 Bridges St. Ext., Suite C
 Morehead City, NC 28557

www.CoastalArchitecture.net

COLUMBUS COUNTY
 SHERIFF'S OFFICE
 WHITEVILLE, NORTH CAROLINA

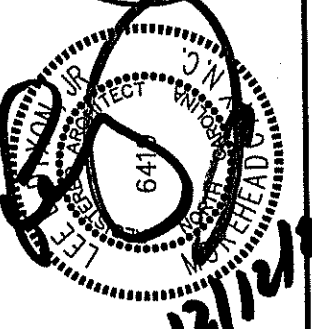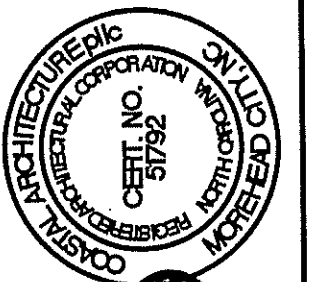

REFLECTED CEILING PLAN


23029

ISSUED: 12.12.2024
 DWG BY: MSG
 CKD BY: LDD
 REVISIONS

SHEET NO.
 A-2
 OF

WINDOW SCHEDULE					
MARK	SIZE	TYPE	MATERIAL	GLAZING	REMARKS
W-1	4'-0" X 5'-0"	FIXED	ALUM.	IMPACT RESISTANT	
W-2	6'-0" X 5'-0"	FIXED	ALUM.	IMPACT RESISTANT	
W-3	9'-8" X 7'-0"	FIXED	ALUM.	90 MIN FIRE RATED	
W-4	4'-0" X 3'-0"	FIXED	ALUM.	ONE WAY GLAZING	
W-5	11'-8" X 5'-0"	FIXED	ALUM.	IMPACT RESISTANT	
WINDOW SCHEDULE REMARKS					
• ALL GLAZING TO BE IMPACT RESISTANT.					
• WINDOWS SHALL MEET APPLICABLE WIND ZONE CODE DESIGN PRESSURE REQUIREMENTS.					
• PROVIDE HEAD AND SILL FLASHING AT ALL WINDOWS.					

MASONRY LINTEL SCHEDULE						
MAX SPAN	WIDTH	DEPTH	REINFORCEMENT			MAX COVER
			BOTTOM	TOP	STIRRUPS	
6'-4"	8"	8"	ONE ~#5	ONE ~#5	#5 @ 8" O.C.	2"
11'-4"	8"	16"	ONE ~#5	ONE ~#5	#5 @ 8" O.C.	3"
REMARKS						
1. EXTEND GROUTED OPEN END MASONRY UNITS AND REINFORCING 1'-4" PAST EA. JAMB MIN. USE CORNER BARS WHERE 1'-4" CANNOT BE ACHIEVED.						
2. HEADER TO BEAR 8" ON SOLID GROUTED CMU BLOCK EACH END.						
3. ALL REINFORCEMENT SHALL BE CONTINUOUS, SPLICES ARE NOT PERMITTED.						

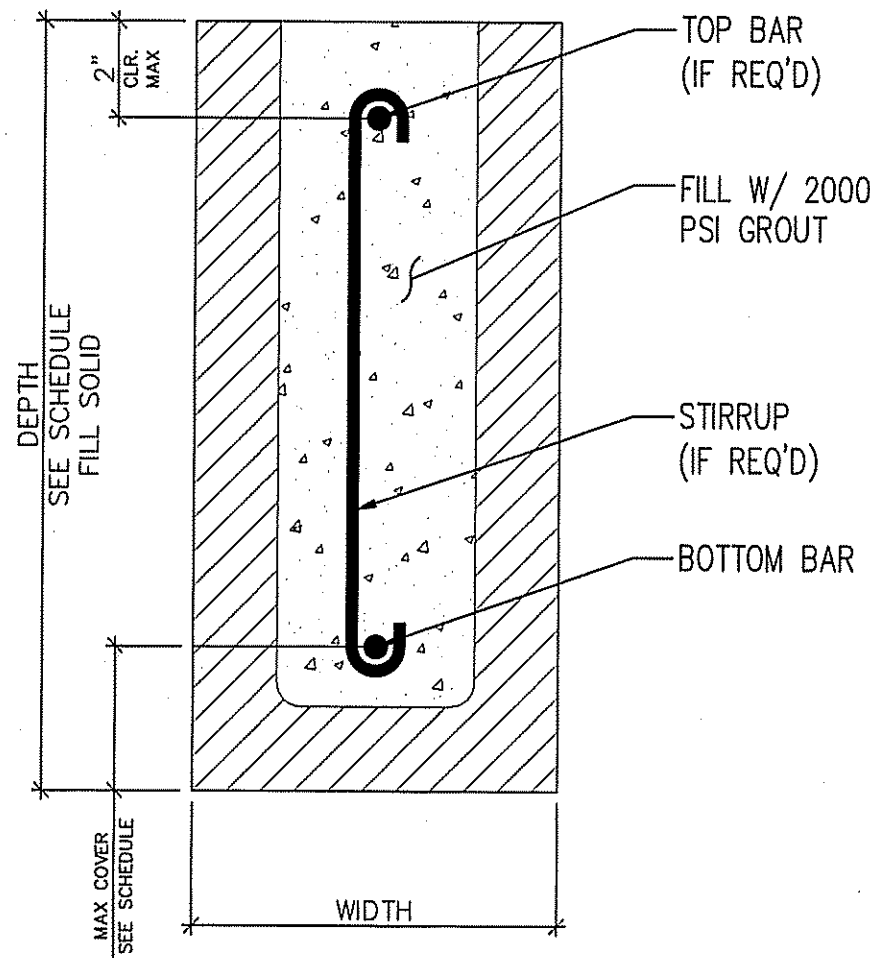

TYPICAL MASONRY LINTEL DETAIL
SCALE: 3"=1'-0"

DOOR SCHEDULE				
DOOR NO.	SIZE	DOOR		REMARKS
		TYPE	FRAME	
100A	(2) 3'-0" X 7'-0"	2	C	① ② ④
100B	3'-0" X 7'-0"	1	A	① ② ④
100.1A	(2) 3'-0" X 7'-0"	5	D	① ② ⑤
101A	3'-0" X 7'-0"	4	B	① ② ⑤
101B	55'-0" X 9'-6" OPENING	8	BY MFR	(2) RAYDOOR SLIDING POCKET WALL
102A	(2) 3'-0" X 7'-0"	5	D	① ② ⑤
102B	(2) 3'-0" X 7'-0"	5	D	① ② ⑤
102C	3'-0" X 7'-0"	1	H	① ② ⑤
102D	3'-0" X 7'-0"	1	H	① ② ⑤
104A	3'-0" X 7'-0"	3	F	③
105A	3'-0" X 7'-0"	3	F	③
106A	3'-0" X 7'-0"	3	F	③
107A	3'-0" X 7'-0"	3	F	③
108A	3'-0" X 7'-0"	3	B	③
109A	3'-0" X 7'-0"	3	F	③
110A	3'-0" X 7'-0"	3	F	③
111A	3'-0" X 7'-0"	3	B	③
112A	3'-0" X 7'-0"	3	F	③
113A	3'-0" X 7'-0"	3	B	③
114A	3'-0" X 7'-0"	3	B	① ③ ⑤
115A	3'-0" X 7'-0"	4	B	① ② ⑤
116A	3'-0" X 7'-0"	3	B	① ③ ⑤
117A	3'-0" X 7'-0"	3	B	① ③ ⑤
118A	3'-0" X 7'-0"	3	F	① ② ⑤
119A	3'-0" X 7'-0"	3	F	③
120A	3'-0" X 7'-0"	3	B	③
121A	3'-0" X 7'-0"	3	F	③
122A	3'-0" X 7'-0"	3	F	③
123A	3'-0" X 7'-0"	3	F	③
124A	3'-0" X 7'-0"	3	B	③
125A	3'-0" X 7'-0"	3	F	③
126A	3'-0" X 7'-0"	3	F	③
127A	3'-0" X 7'-0"	3	F	③
128A	3'-0" X 7'-0"	4	B	② ⑤
128B	3'-0" X 7'-0"	4	B	① ② ⑤
129A	3'-0" X 7'-0"	3	F	① ③
130A	3'-0" X 7'-0"	3	F	① ③
131A	3'-0" X 7'-0"	3	B	① ③ ⑤
132A	3'-0" X 7'-0"	1	A	① ② ④
132B	3'-0" X 7'-0"	1	A	① ② ④
133A	(2) 3'-0" X 7'-0"	6	D	① ② ④ ⑤
133B	10'-0" X 8'-0"	7	G	COILING DOOR
134A	(2) 3'-0" X 7'-0"	6	D	① ② ④ ⑤
135A	3'-0" X 7'-0"	3	F	③
136A	3'-0" X 7'-0"	3	F	③
137A	3'-0" X 7'-0"	3	F	③
138A	3'-0" X 7'-0"	3	B	③
139A	3'-0" X 7'-0"	3	F	③
140A	3'-0" X 7'-0"	3	F	③
141A	3'-0" X 7'-0"	3	B	③
142A	3'-0" X 7'-0"	3	F	③
143A	3'-0" X 7'-0"	3	F	③
144A	3'-0" X 7'-0"	4	B	① ② ⑤
144B	3'-0" X 7'-0"	4	B	① ② ⑤
145A	3'-0" X 7'-0"	3	F	③
146A	3'-0" X 7'-0"	3	B	① ③
147A	3'-0" X 7'-0"	3	B	① ③ ⑤
148A	3'-0" X 7'-0"	3	F	① ③ ⑤
149A	3'-0" X 7'-0"	3	F	① ③ ⑤
150A	3'-0" X 7'-0"	3	F	① ③ ⑤
151A	3'-0" X 7'-0"	3	B	① ③ ⑤
152A	3'-0" X 7'-0"	3	F	① ③ ⑤
153A	3'-0" X 7'-0"	3	F	① ③ ⑤
154A	3'-0" X 7'-0"	3	F	① ③ ⑤
155A	3'-0" X 7'-0"	3	B	① ③ ⑤
156A	3'-0" X 7'-0"	3	F	① ③ ⑤
157A	3'-0" X 7'-0"	3	F	① ③ ⑤
158A	3'-0" X 7'-0"	3	F	① ③ ⑤
159A	3'-0" X 7'-0"	5	E	① ② ⑥
159B	3'-0" X 7'-0"	5	E	① ② ⑥
160A	3'-0" X 7'-0"	3	F	③
161A	3'-0" X 7'-0"	4	B	① ③ ⑤
162A	3'-0" X 7'-0"	3	B	① ② ④ ⑤
163A	3'-0" X 7'-0"	3	B	① ② ④
164A	3'-0" X 7'-0"	3	B	③
165A	3'-0" X 7'-0"	3	B	③
166A	3'-0" X 7'-0"	3	B	③
167A	3'-0" X 7'-0"	3	B	③
168A	3'-0" X 7'-0"	3	B	③
169A	3'-0" X 7'-0"	3	B	① ③ ⑤
169B	3'-0" X 7'-0"	3	B	① ③ ⑤
170A	3'-0" X 7'-0"	3	B	① ③ ⑤
171A	3'-0" X 7'-0"	3	B	① ③ ⑤
173A	3'-0" X 7'-0"	1	F	① ③ ⑤
173B	3'-0" X 7'-0"	1	F	① ③ ⑤

DOOR SCHEDULE REMARKS

- CLOSER
 - PANIC HARDWARE
 - PUSH/ PULLS
 - CARD SWIPE
 - 20 MIN RATED DOOR
 - 90 MIN RATED DOOR
- SEE A-3.1
*CLASS RATE PER XXXX

ROOM FINISH SCHEDULE									
ROOM NUMBERS	ROOM	FLOORS	BASE	WALLS	CEILINGS	FINISH	FIRE RATING	HEIGHT (NOMINAL)	REMARKS
100	CONNECTING CORRIDOR	LVP	VINYL BASE	GWB-PTD	S.A.T.	A	A	9'-0"	
100.1	ENTRY				S.A.T.	A	A	9'-0"	
101	NEWS & MEDIA				S.A.T. 2	C	C	11'-0"	
102	TRAINING				S.A.T. 2	C	C	11'-0"	
103	HALL				S.A.T.	A	A	9'-0"	
104	OFFICE						C		
105	OFFICE								
106	OFFICE								
107	OFFICE								
108	OFFICE								
109	OFFICE								
110	OFFICE								
111	OFFICE								
112	OFFICE								
113	OFFICE								
114	JANITOR								
115	CIVIL								
116	MEN'S TOILET	TILE	TILE BASE						MARBLE THRESHOLD
117	WOMEN'S TOILET	TILE	TILE BASE						MARBLE THRESHOLD
118	OFFICE	LVP	VINYL BASE						
119	OFFICE								
120	OFFICE								
121	OFFICE								
122	OFFICE								
123	OFFICE								
124	OFFICE								
125	OFFICE								
126	OFFICE								
127	OFFICE								
128	PATROL							10'-0"	
129	OFFICE							9'-0"	
130	OFFICE								
131	MECH./ELECT.								
132	HALL								
133	STORAGE	CONC. W/ SEALER				A	C		
134	ARMORY	CONC. W/ SEALER							
135	OFFICE	LVP	VINYL BASE	CMU BLOCK PTD.	EXPOSED EXPOSED			9'-0"	
136	OFFICE			GWB-PTD	S.A.T.				
137	OFFICE								
138	OFFICE								
139	OFFICE								
140	OFFICE								
141	OFFICE								
142	OFFICE								
143	OFFICE								
144	DRUG/SPECIAL OPERATIONS								
145	OFFICE							10'-0"	
146	INTERVIEW							9'-0"	
147	INTERVIEW								SOUNDBREAK GWB
148	OFFICE								SOUNDBREAK GWB
149	OFFICE								
150	OFFICE								
151	OFFICE								
152	OFFICE								
153	OFFICE								
154	OFFICE								
155	OFFICE								
156	OFFICE								
157	OFFICE								
158	OFFICE								
159	DETECTIVE DIVISION							10'-0"	
160	OFFICE							9'-0"	
161	BREAK ROOM								
162	FILE								
163	MECH.								
164	SHOWER	TILE	TILE BASE						MARBLE THRESHOLD
165	SHOWER	TILE	TILE BASE						MARBLE THRESHOLD
166	JANITOR	LVP	VINYL BASE						
167	SHOWER	TILE	TILE BASE						MARBLE THRESHOLD
168	SHOWER	TILE	TILE BASE						MARBLE THRESHOLD
169	LOCKER ROOM	LVP	VINYL BASE						
170	MEN'S TOILET	TILE	TILE BASE						
171	WOMEN'S TOILET	TILE	TILE BASE						
172	HALL	LVP	VINYL BASE						
173	GYM/WORKOUT AREA	LVP	VINYL BASE					10'-0"	

ROOM FINISH SCHEDULE REMARKS

- ALL GWB TO BE MILDEW RESISTANT
- SEE G-2 FOR RATING REQUIREMENT

Coastal
Architecture

• Architectural Design
• Planning
• Interiors





Member of the American Institute of Architects

Lee D. Dixon, Jr., AIA
252-247-2127
ltd@coastalarchitecture.net

4206 Bridges St. Ext., Suite C
Morehead City, NC 28557
www.CoastalArchitecture.net

COLUMBUS COUNTY
SHERIFF'S OFFICE
WHITEVILLE, NORTH CAROLINA

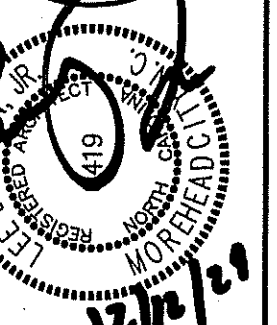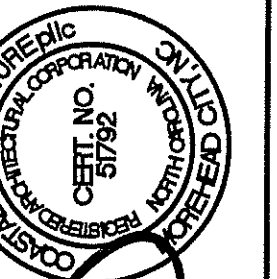

DOOR, WINDOW AND ROOM FINISH SCHEDULES

23029

ISSUED: 12.12.2024

DWG BY: CRF

CKD BY: LDD


REVISIONS

02 03/17/2025

SHEET NO.

A-3


OF

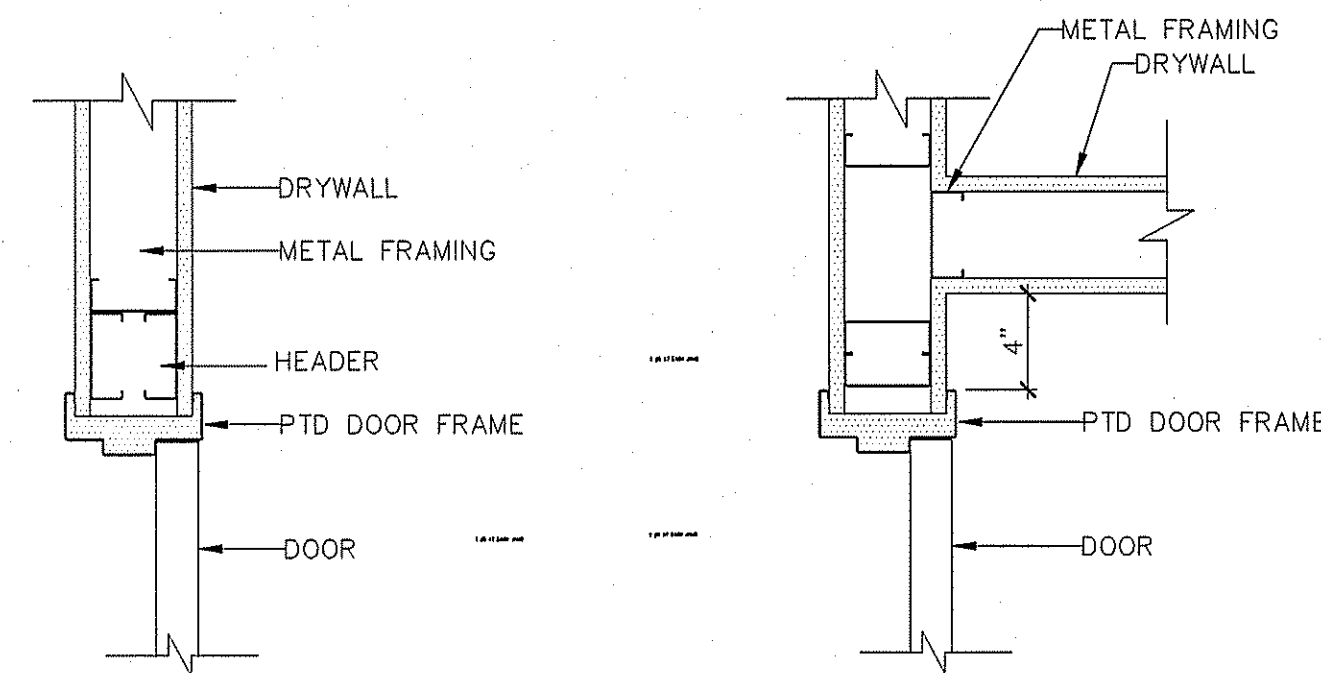

HEAD 3

JAMB 3


6 HEAD AND JAMB (DW)
SCALE: 1 1/2"=1'-0"

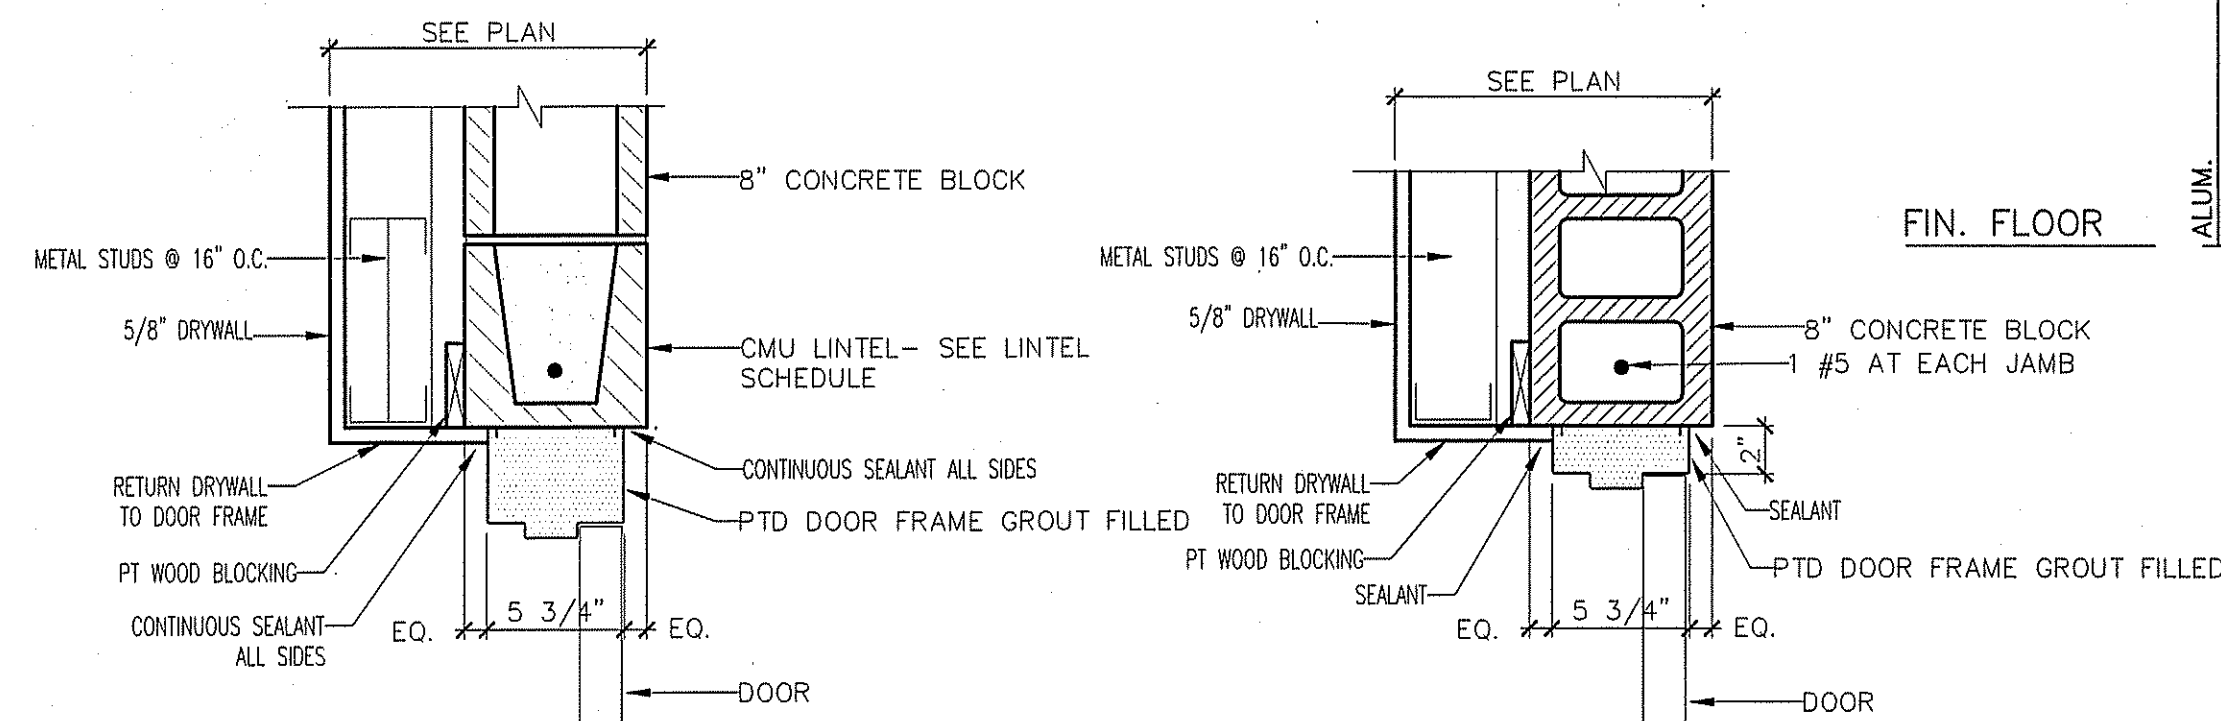

HEAD 2

JAMB 2


5 HEAD AND JAMB (CMU & DW)
SCALE: 1 1/2"=1'-0"

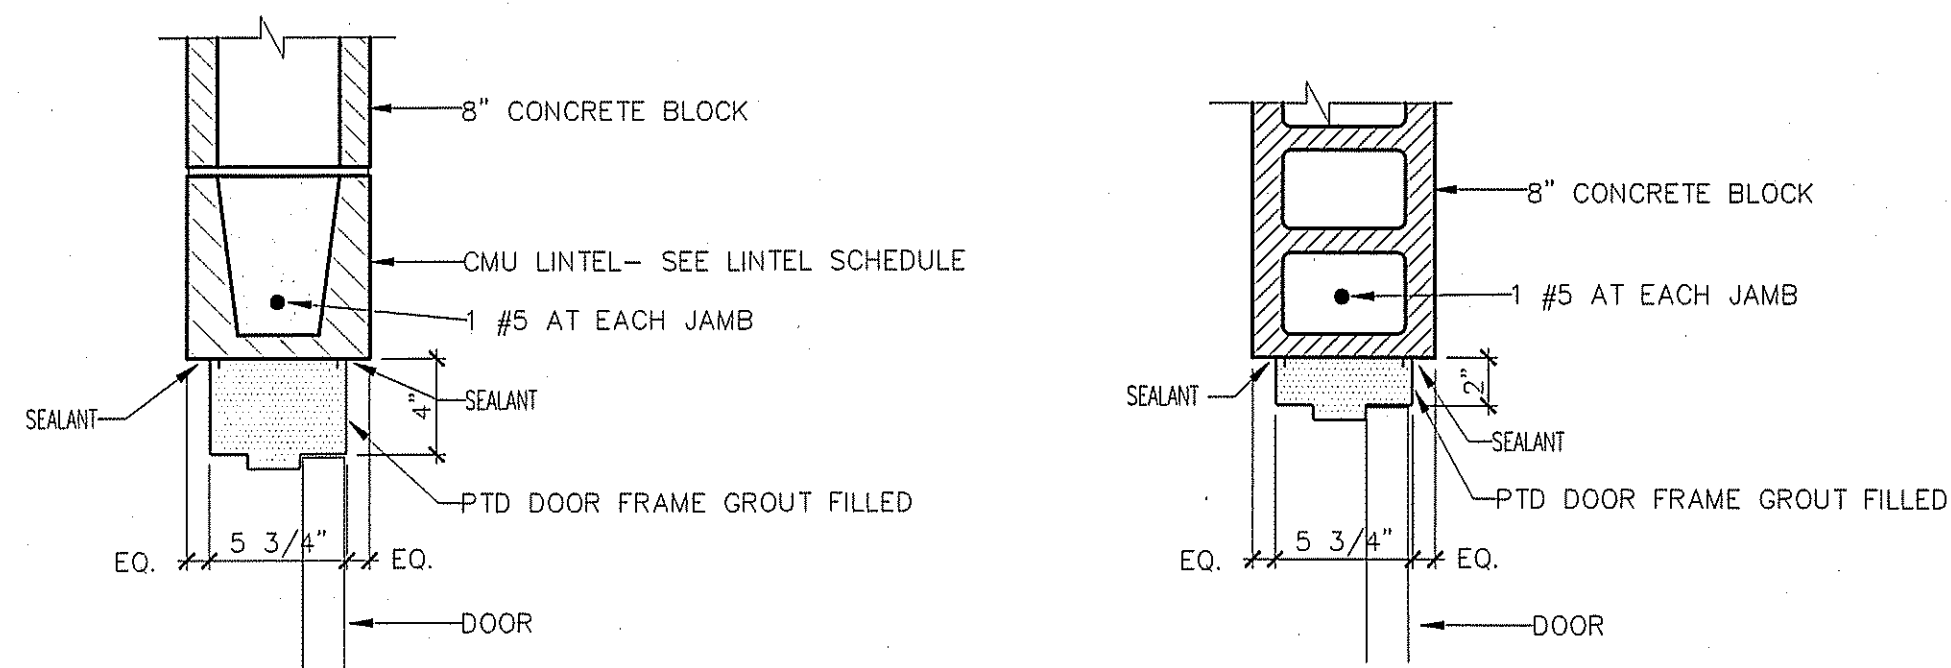


HEAD 1

JAMB 1


4 HEAD AND JAMB (CMU)
SCALE: 1 1/2"=1'-0"

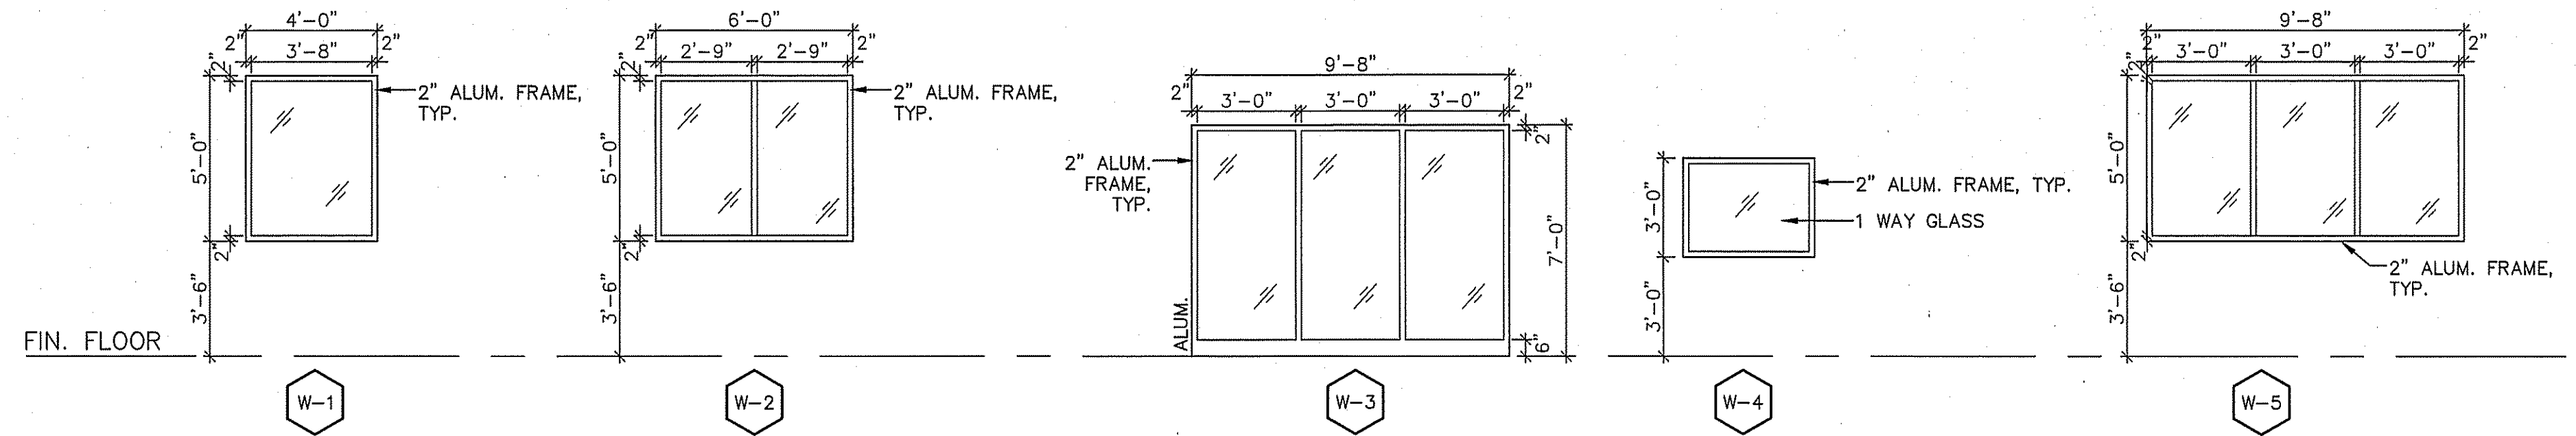


3 WINDOW ELEVATIONS
SCALE: 1/4"=1'-0"

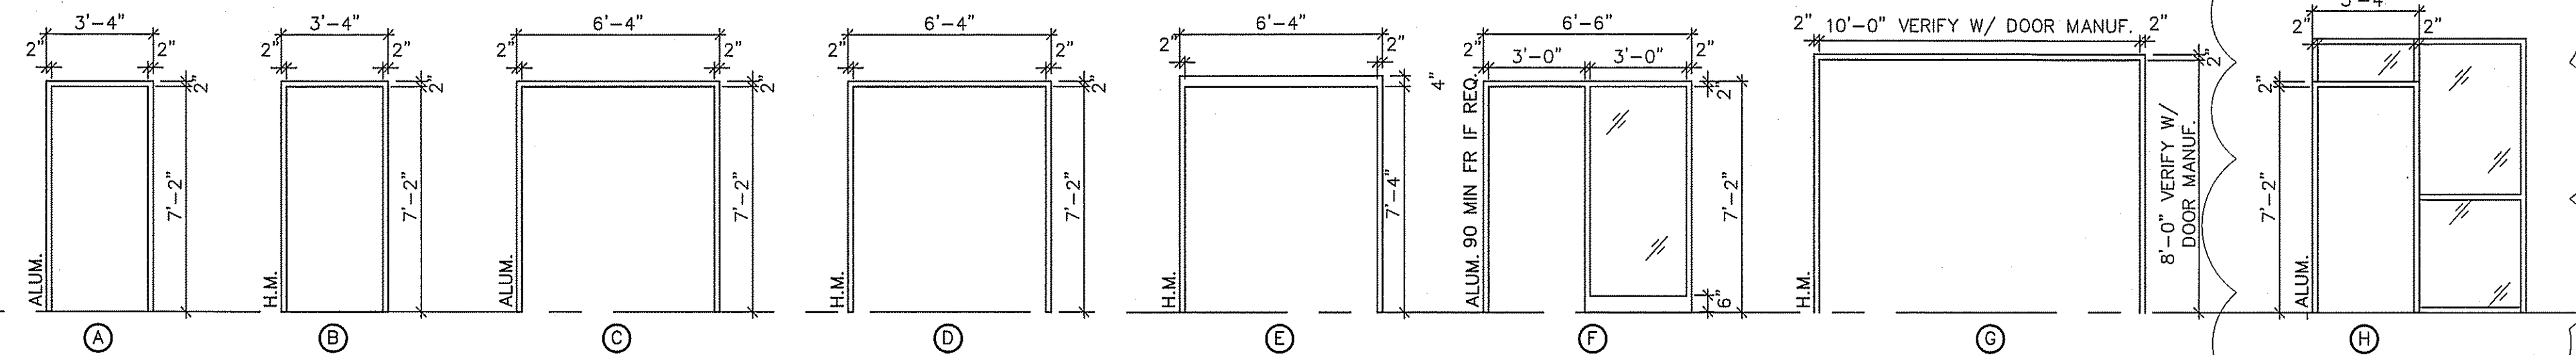




2 DOOR FRAME ELEVATIONS
SCALE: 1/4"=1'-0"

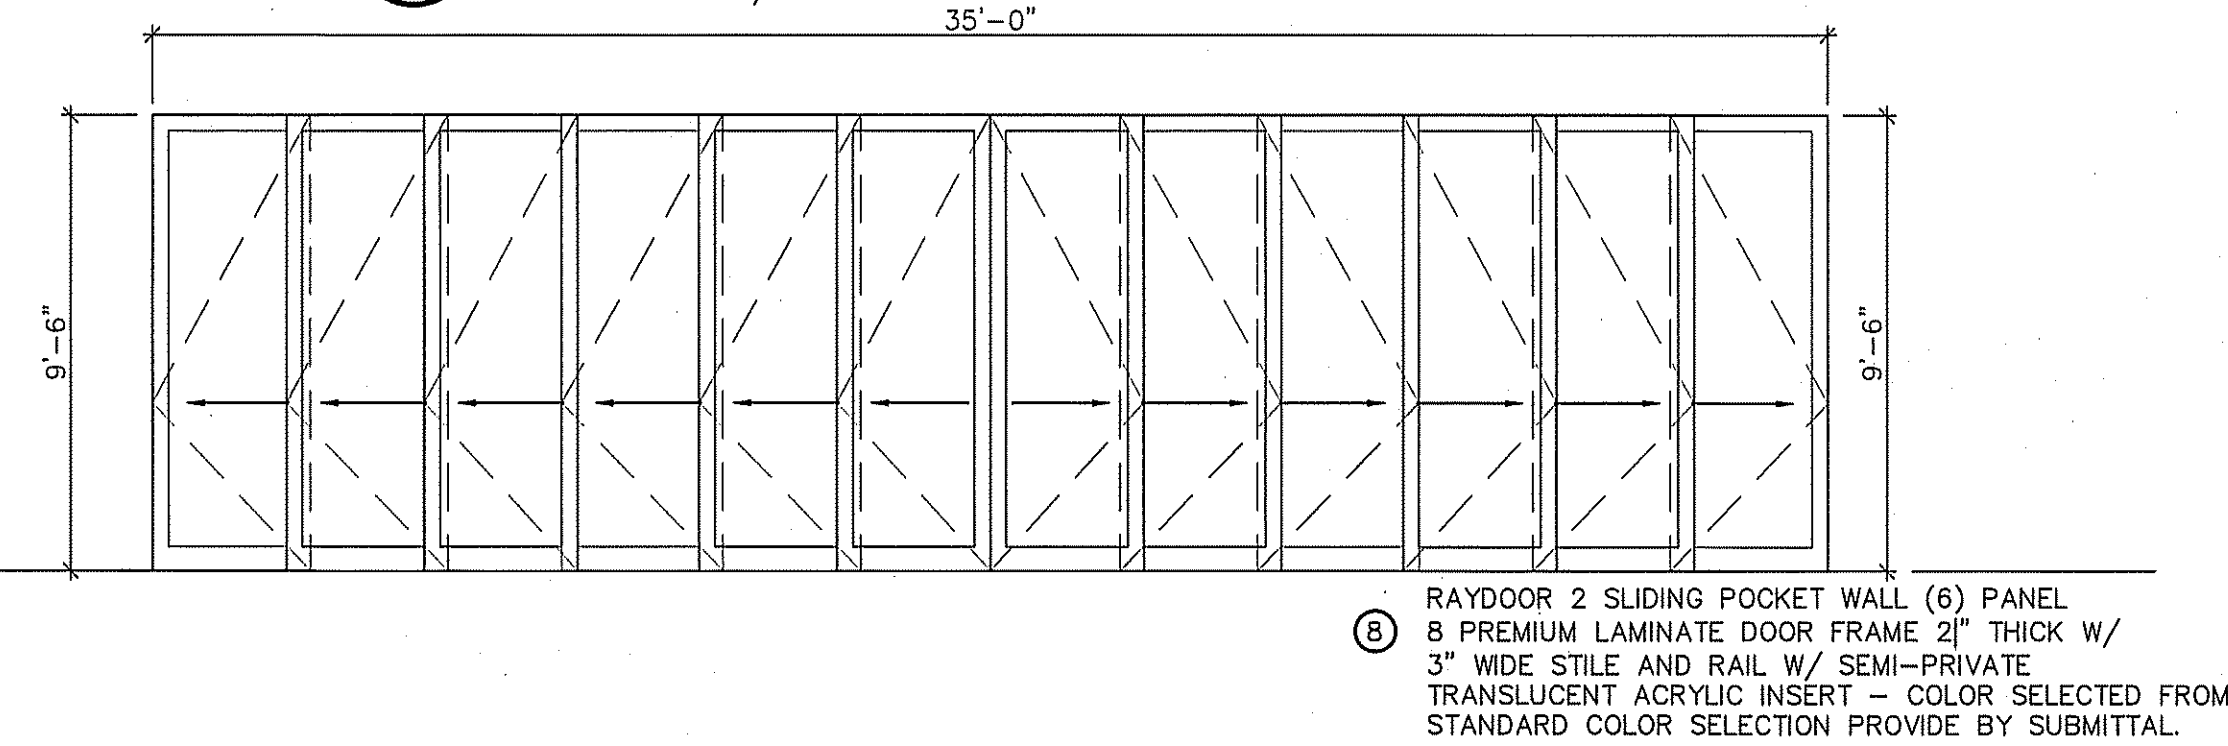

RAYDOOR 2 SLIDING POCKET WALL (6) PANEL
8 PREMIUM LAMINATE DOOR FRAME 2\"/>

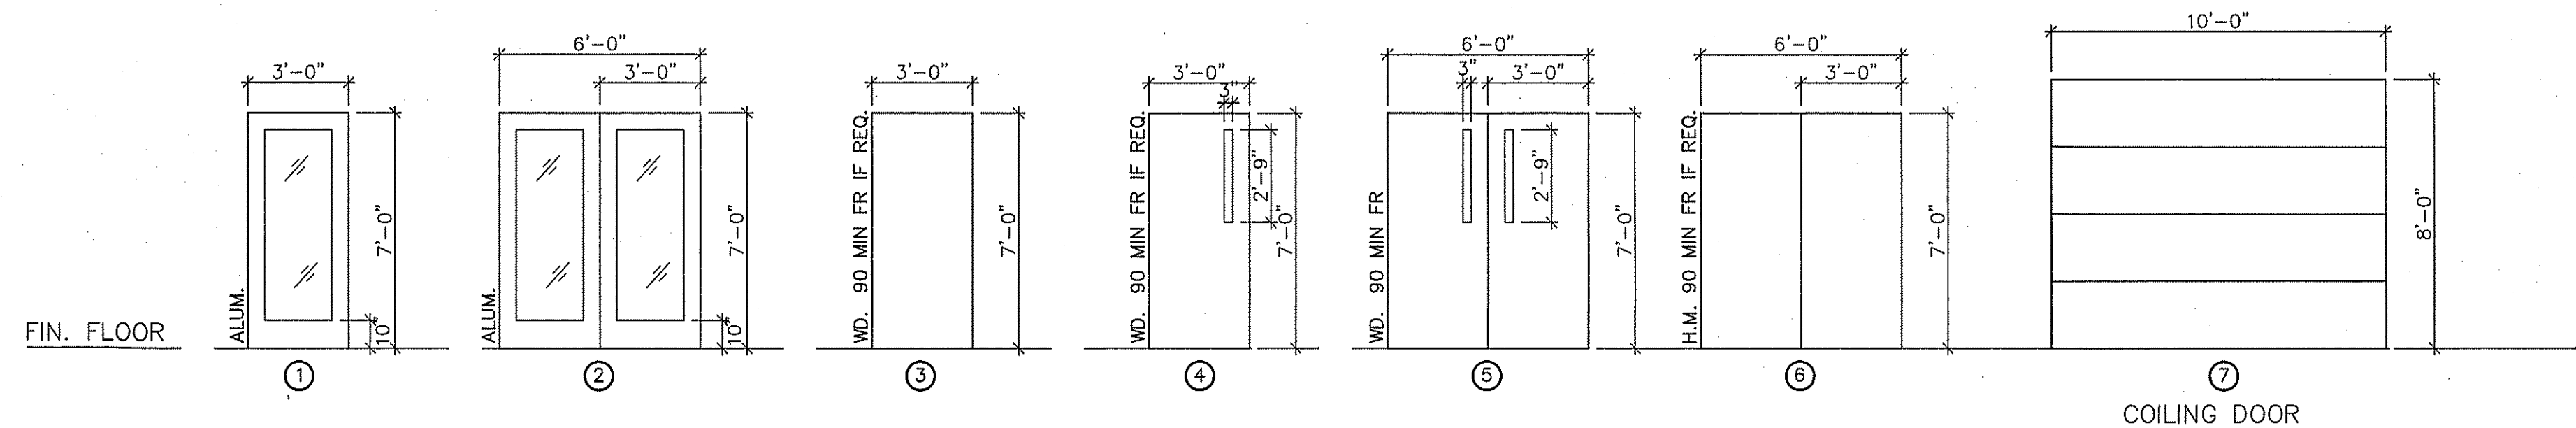


1 DOOR ELEVATIONS
SCALE: 1/4"=1'-0"

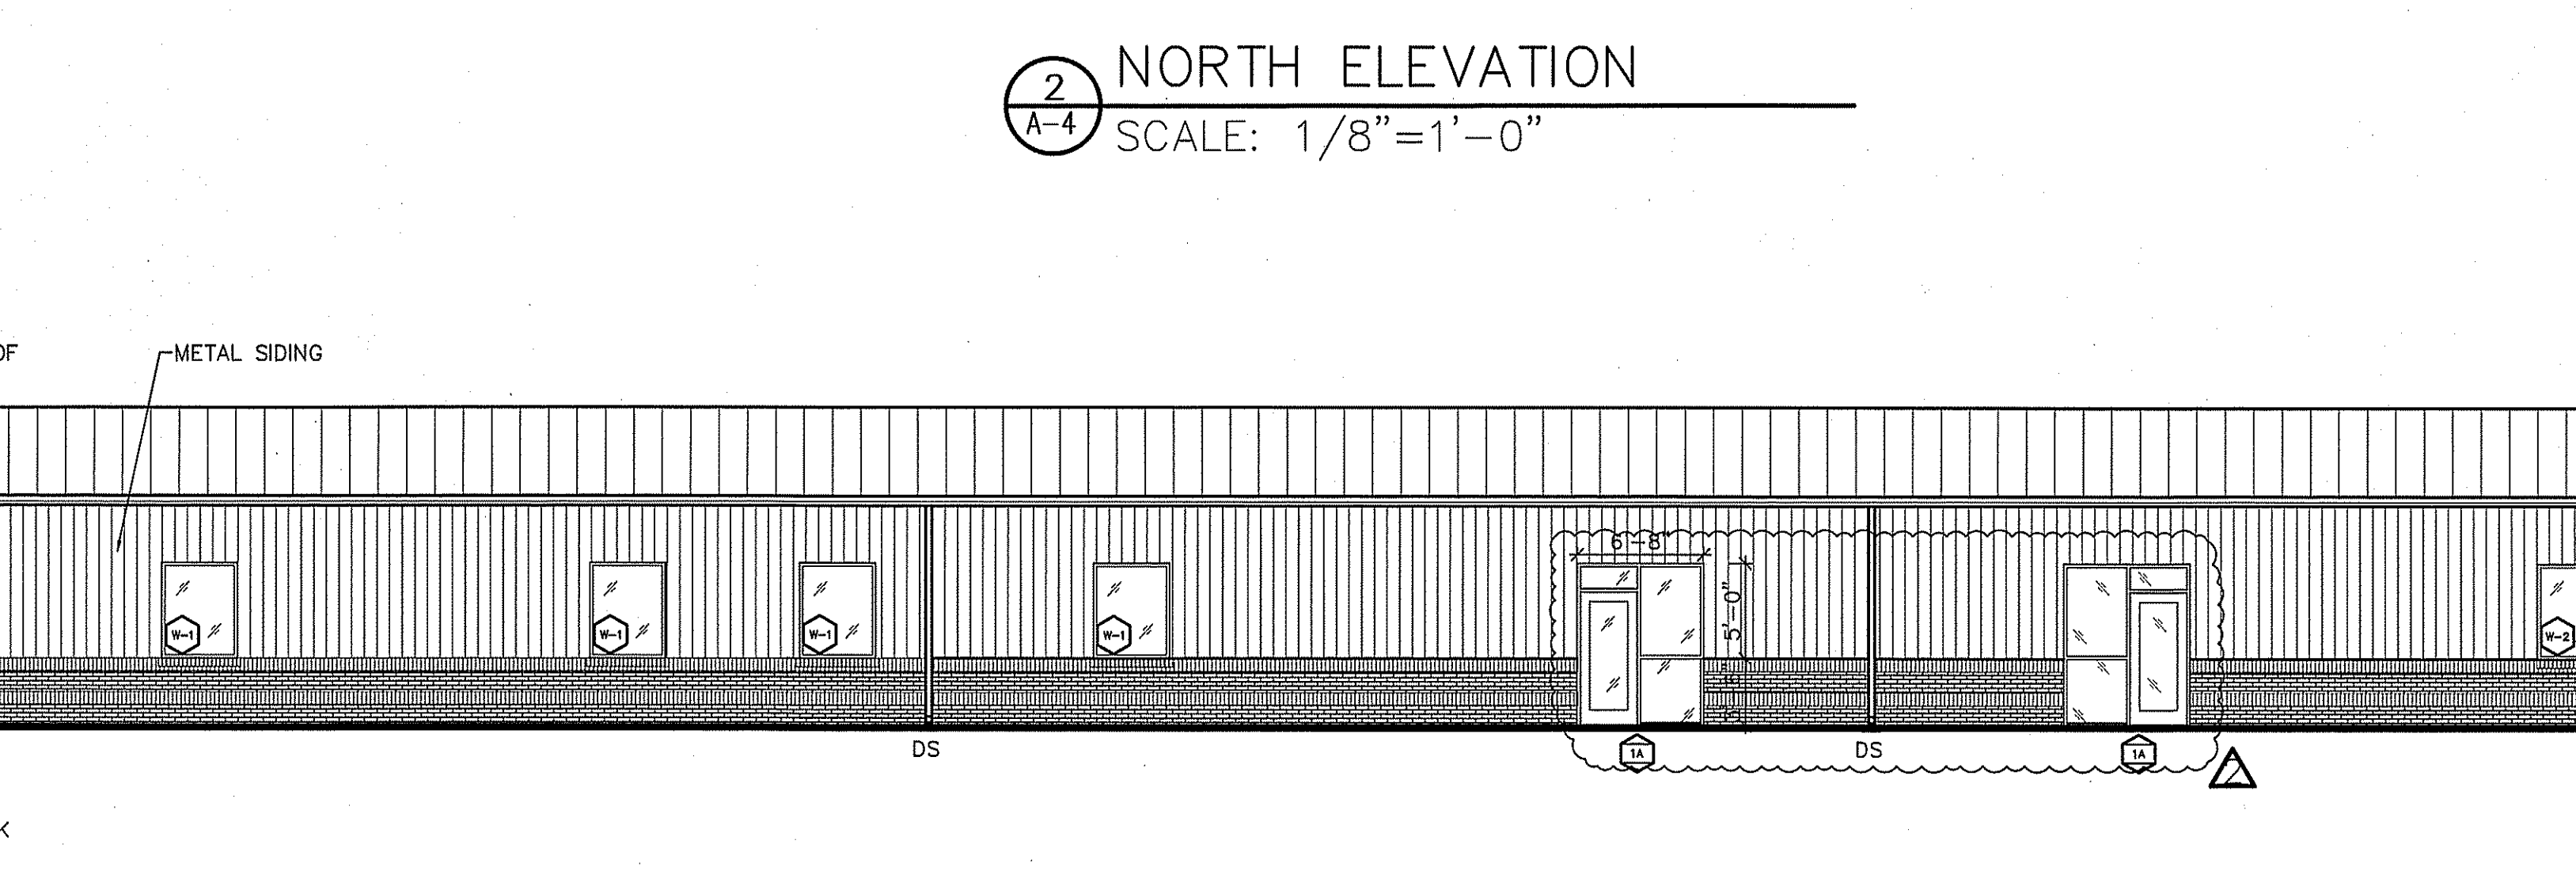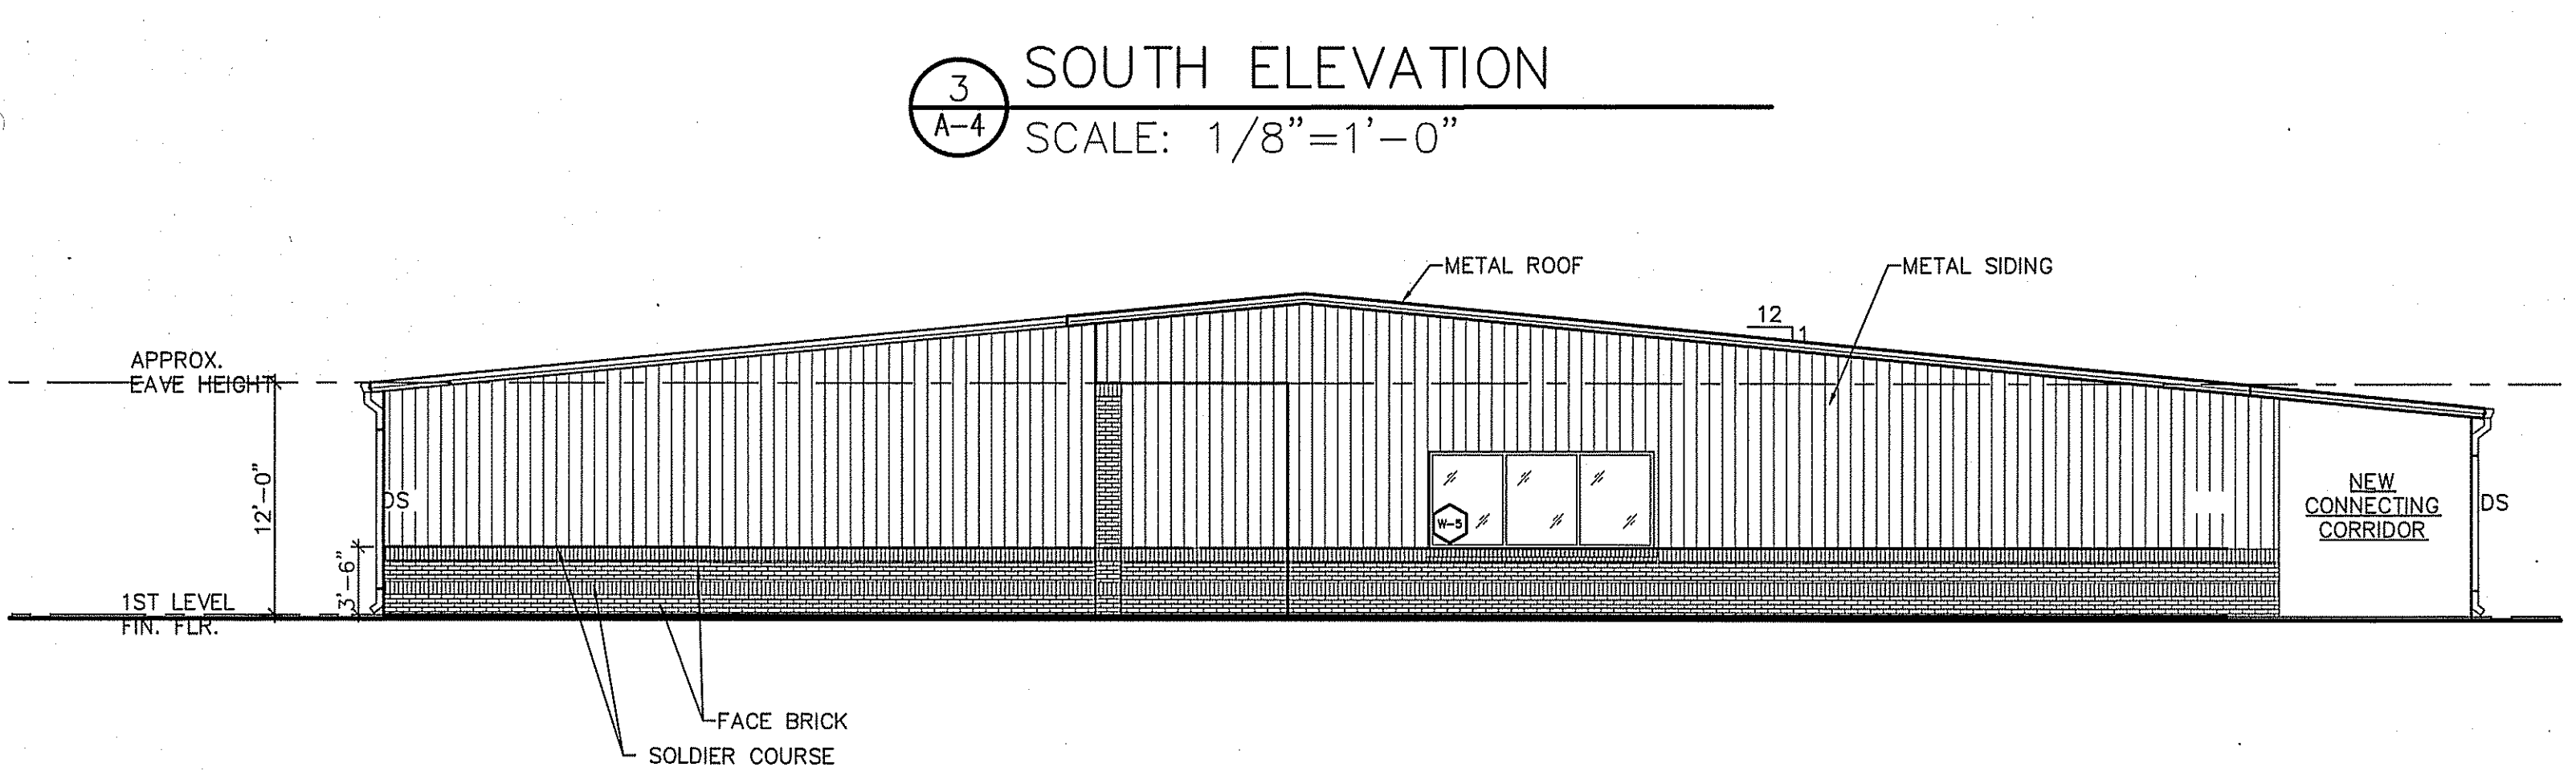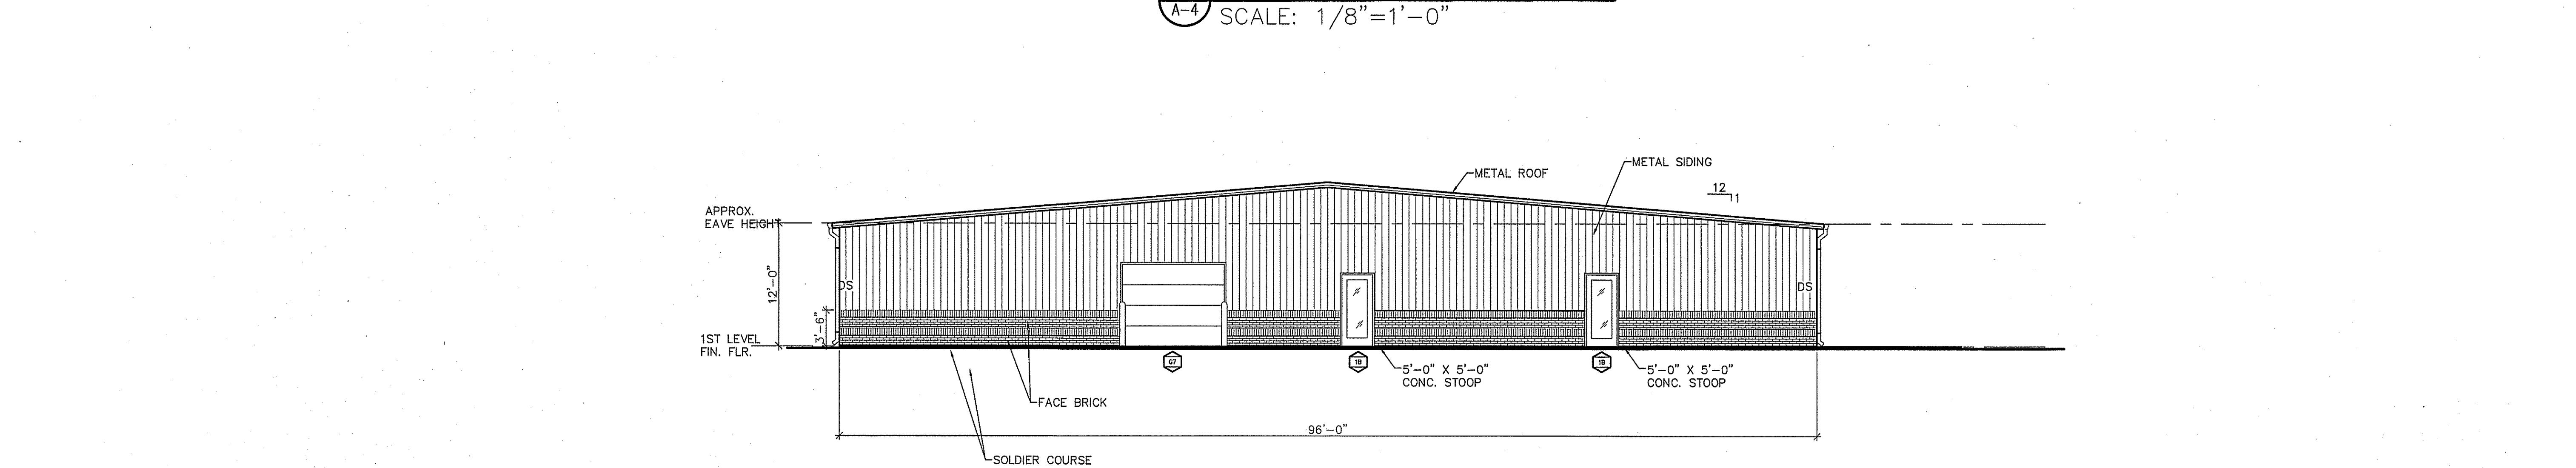


A-4


THESE DRAWING AND SPECIFICATIONS REPRESENT AN INSTRUMENT OF SERVICE AND AS SUCH SHALL REMAIN IN OWNERSHIP WITH THE ARCHITECT. USE OR REPRODUCTION BY ANY MEANS, IN WHOLE OR IN PART, WITHOUT THE ARCHITECT'S WRITTEN CONSENT IS PROHIBITED.

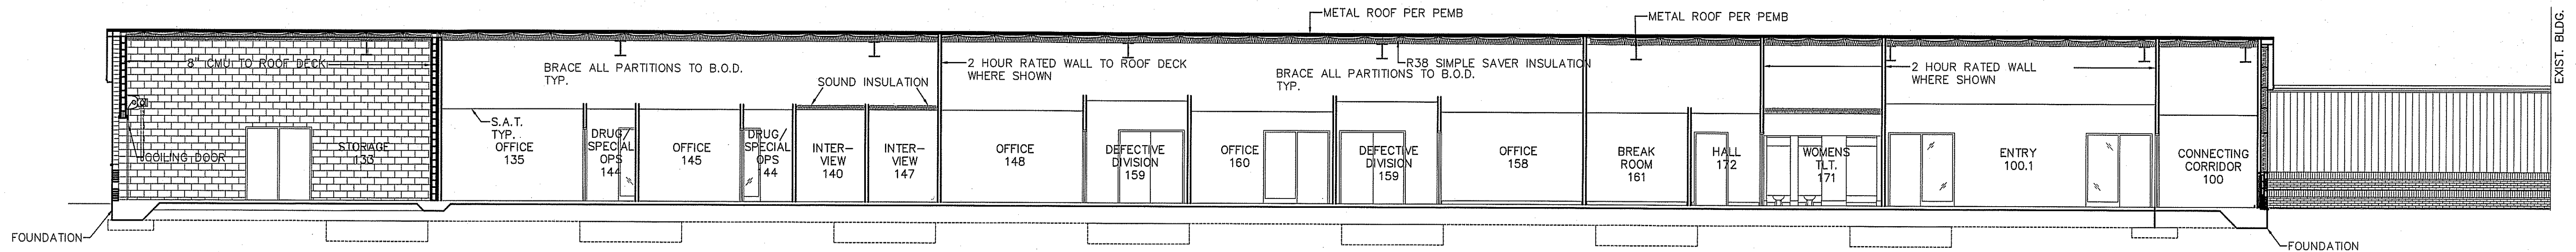

SECTION
2
A-5
SCALE: 1/8"=1'-0"

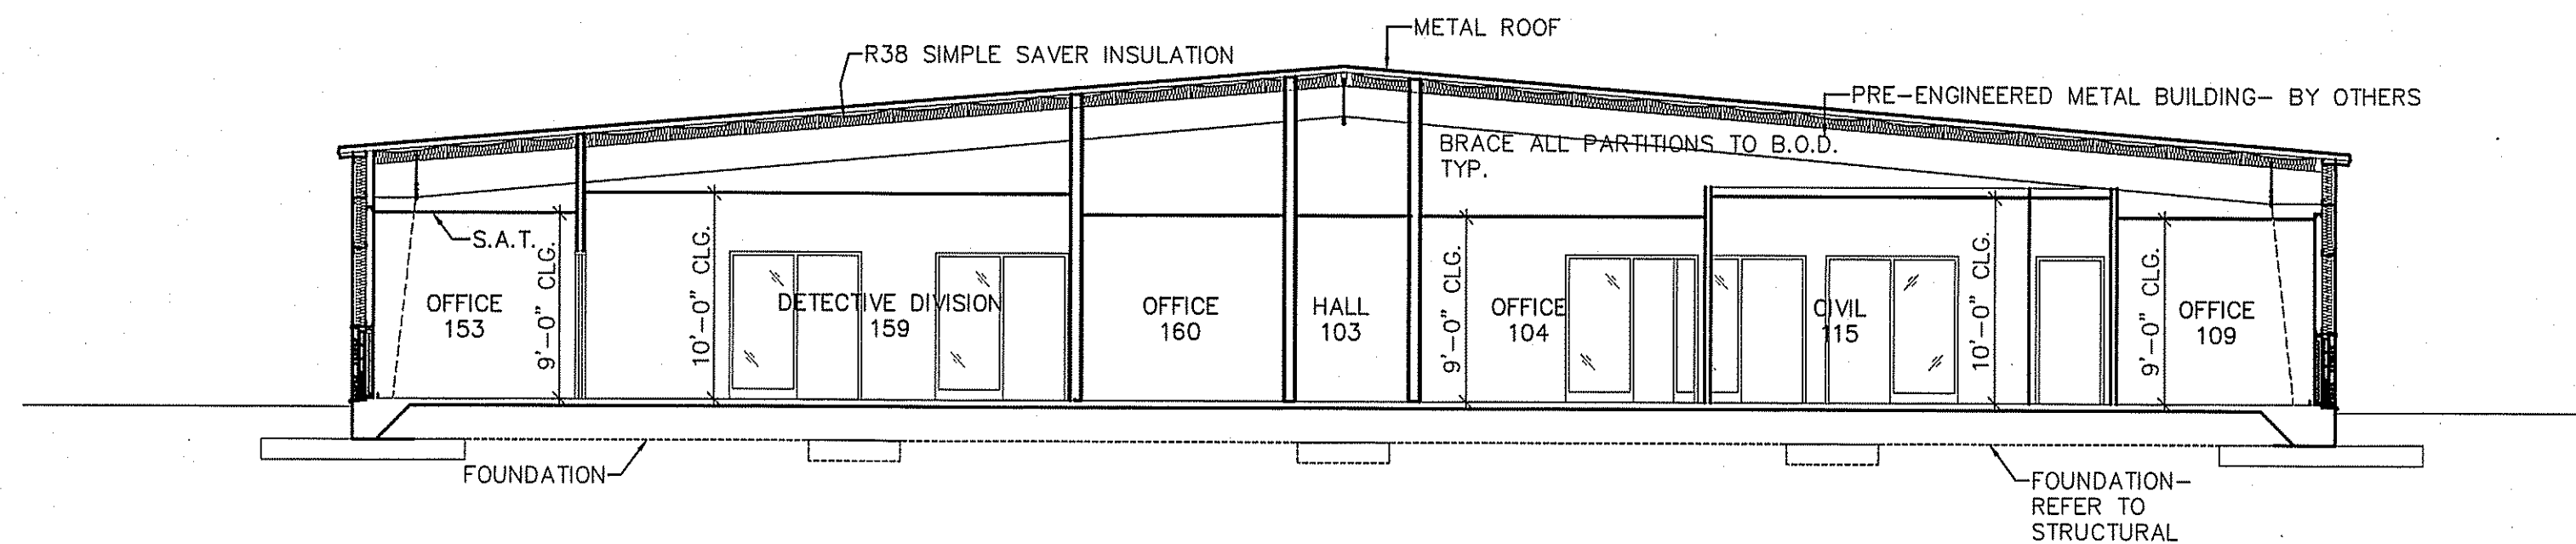

SECTION
1
A-5
SCALE: 1/8"=1'-0"

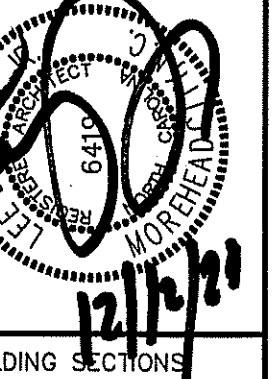

BUILDING SECTIONS

23029

ISSUED: 12.12.2024


DWG BY: SKC

CKD BY: LDD


REVISIONS

SHEET NO.


A-5
OF

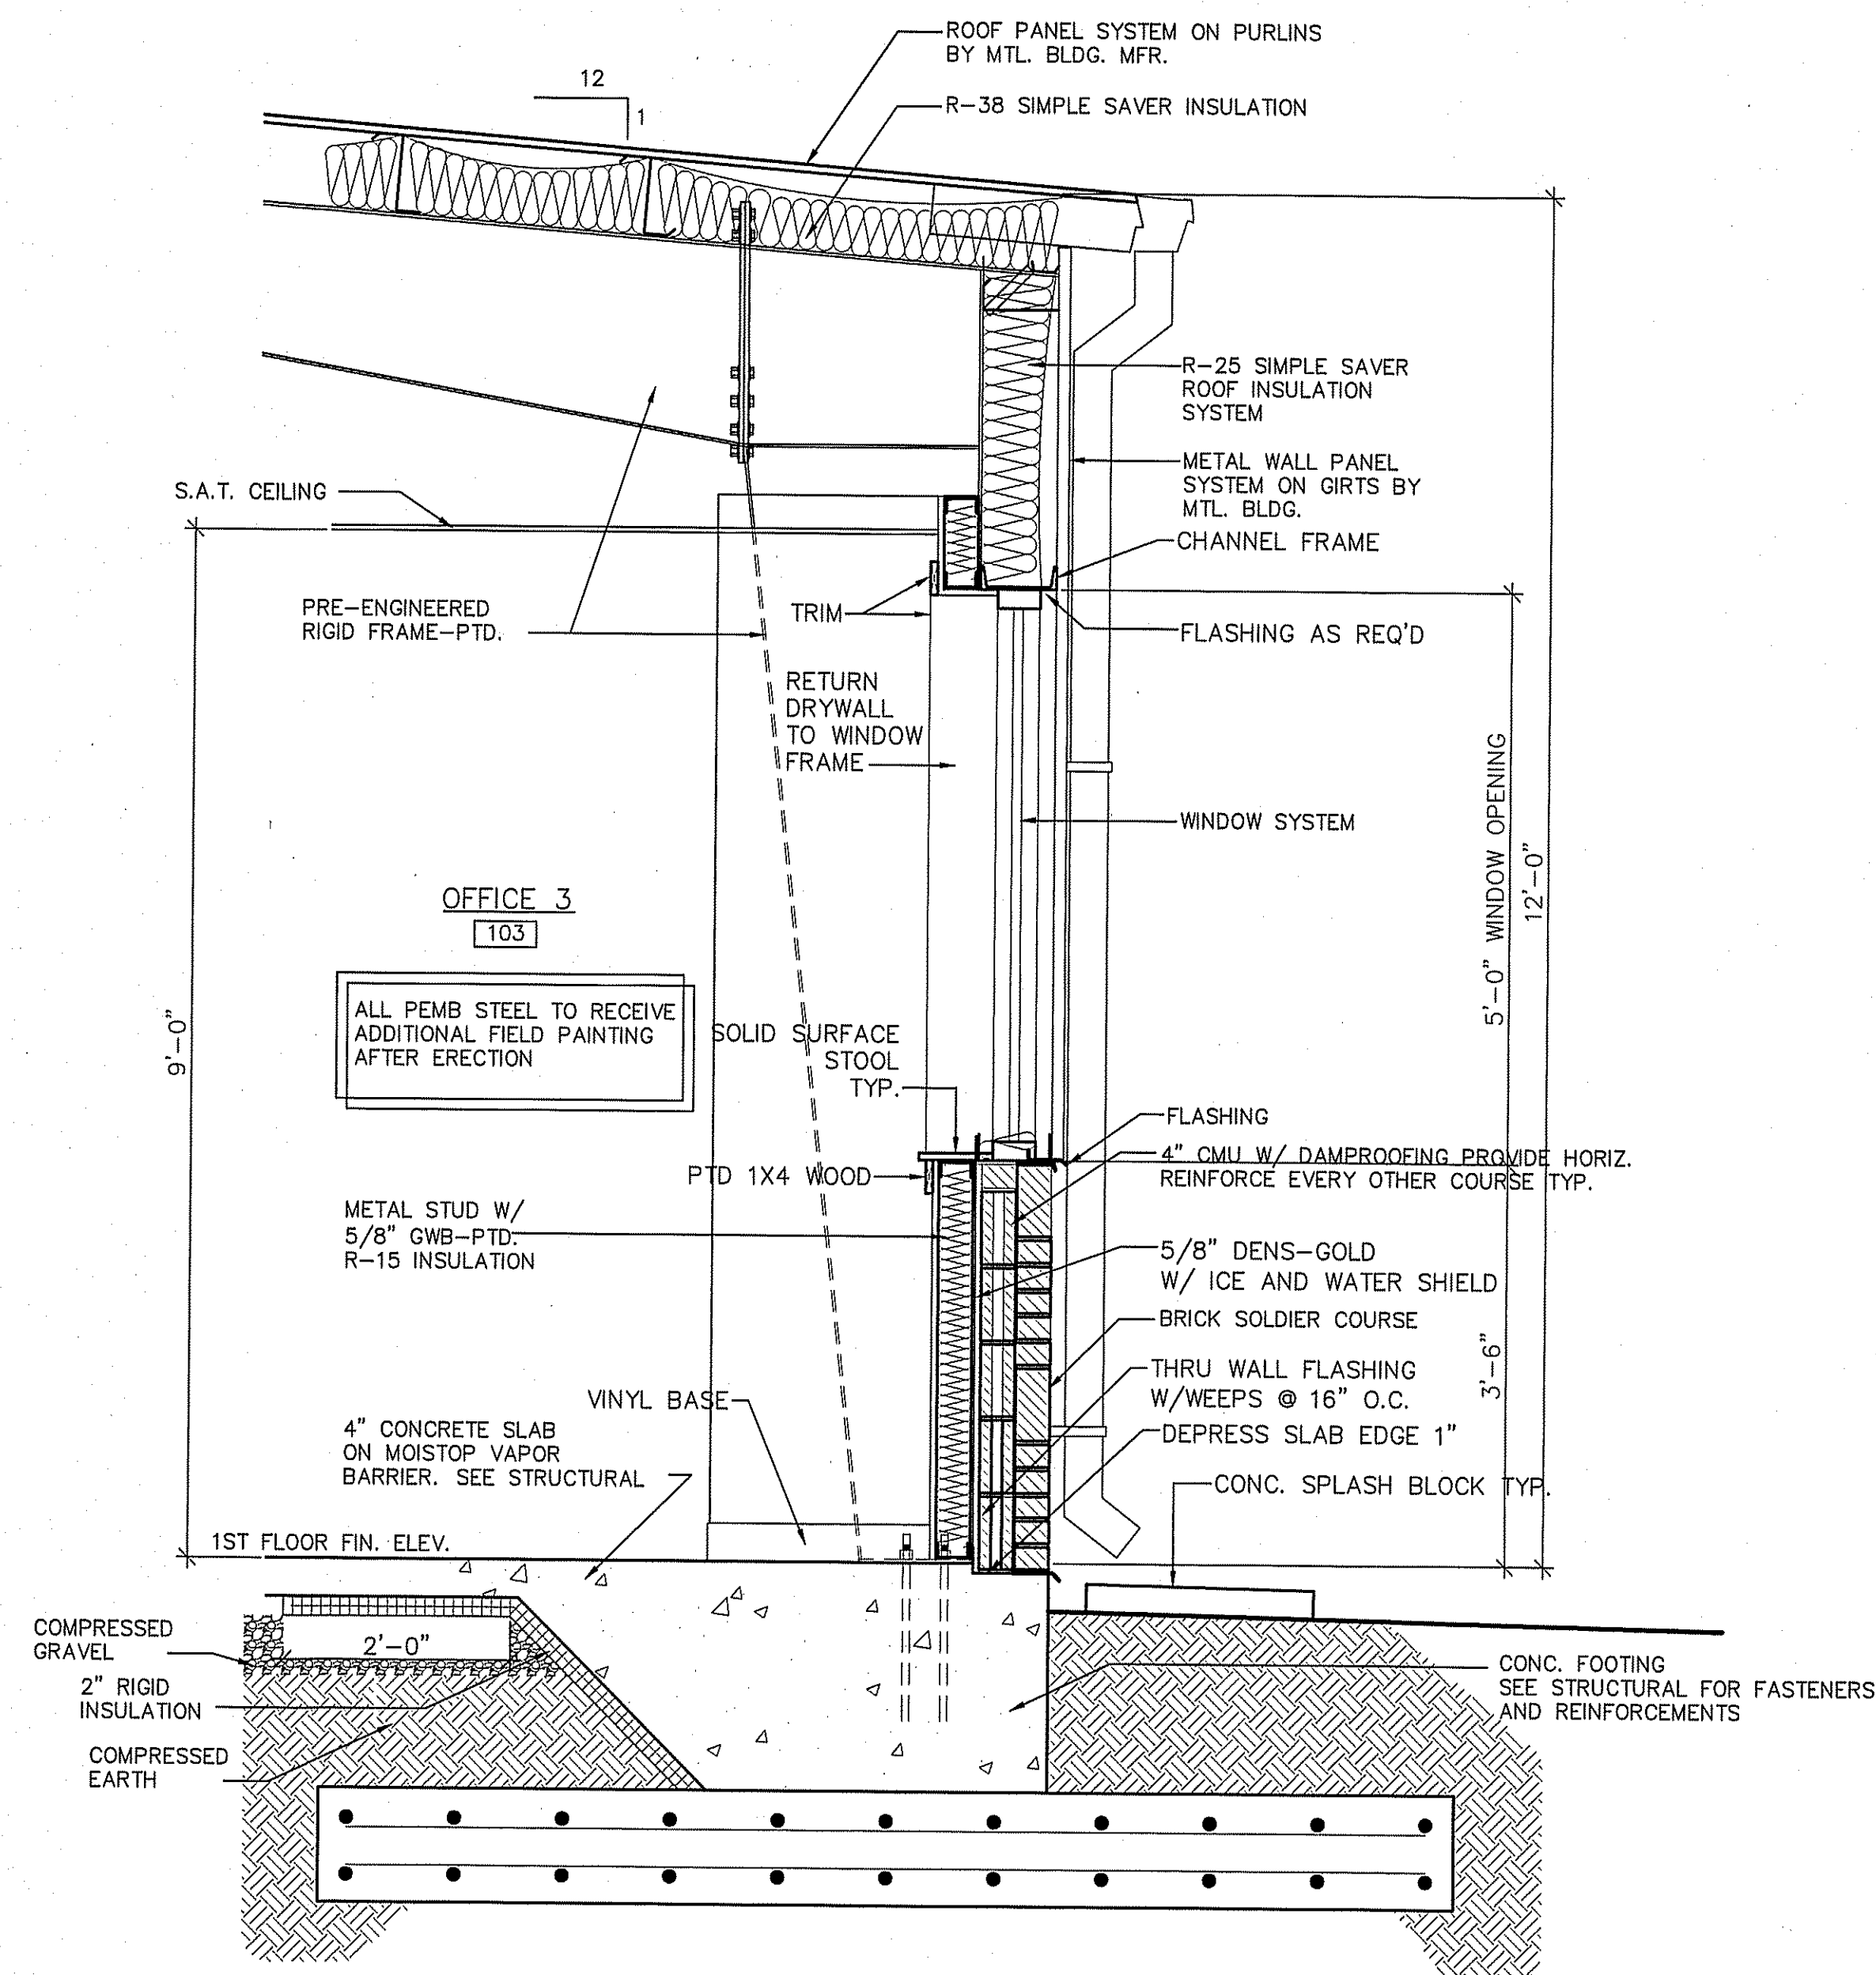

2 WALL SECTION
A-5.1 SCALE: 3/4"=1'-0"

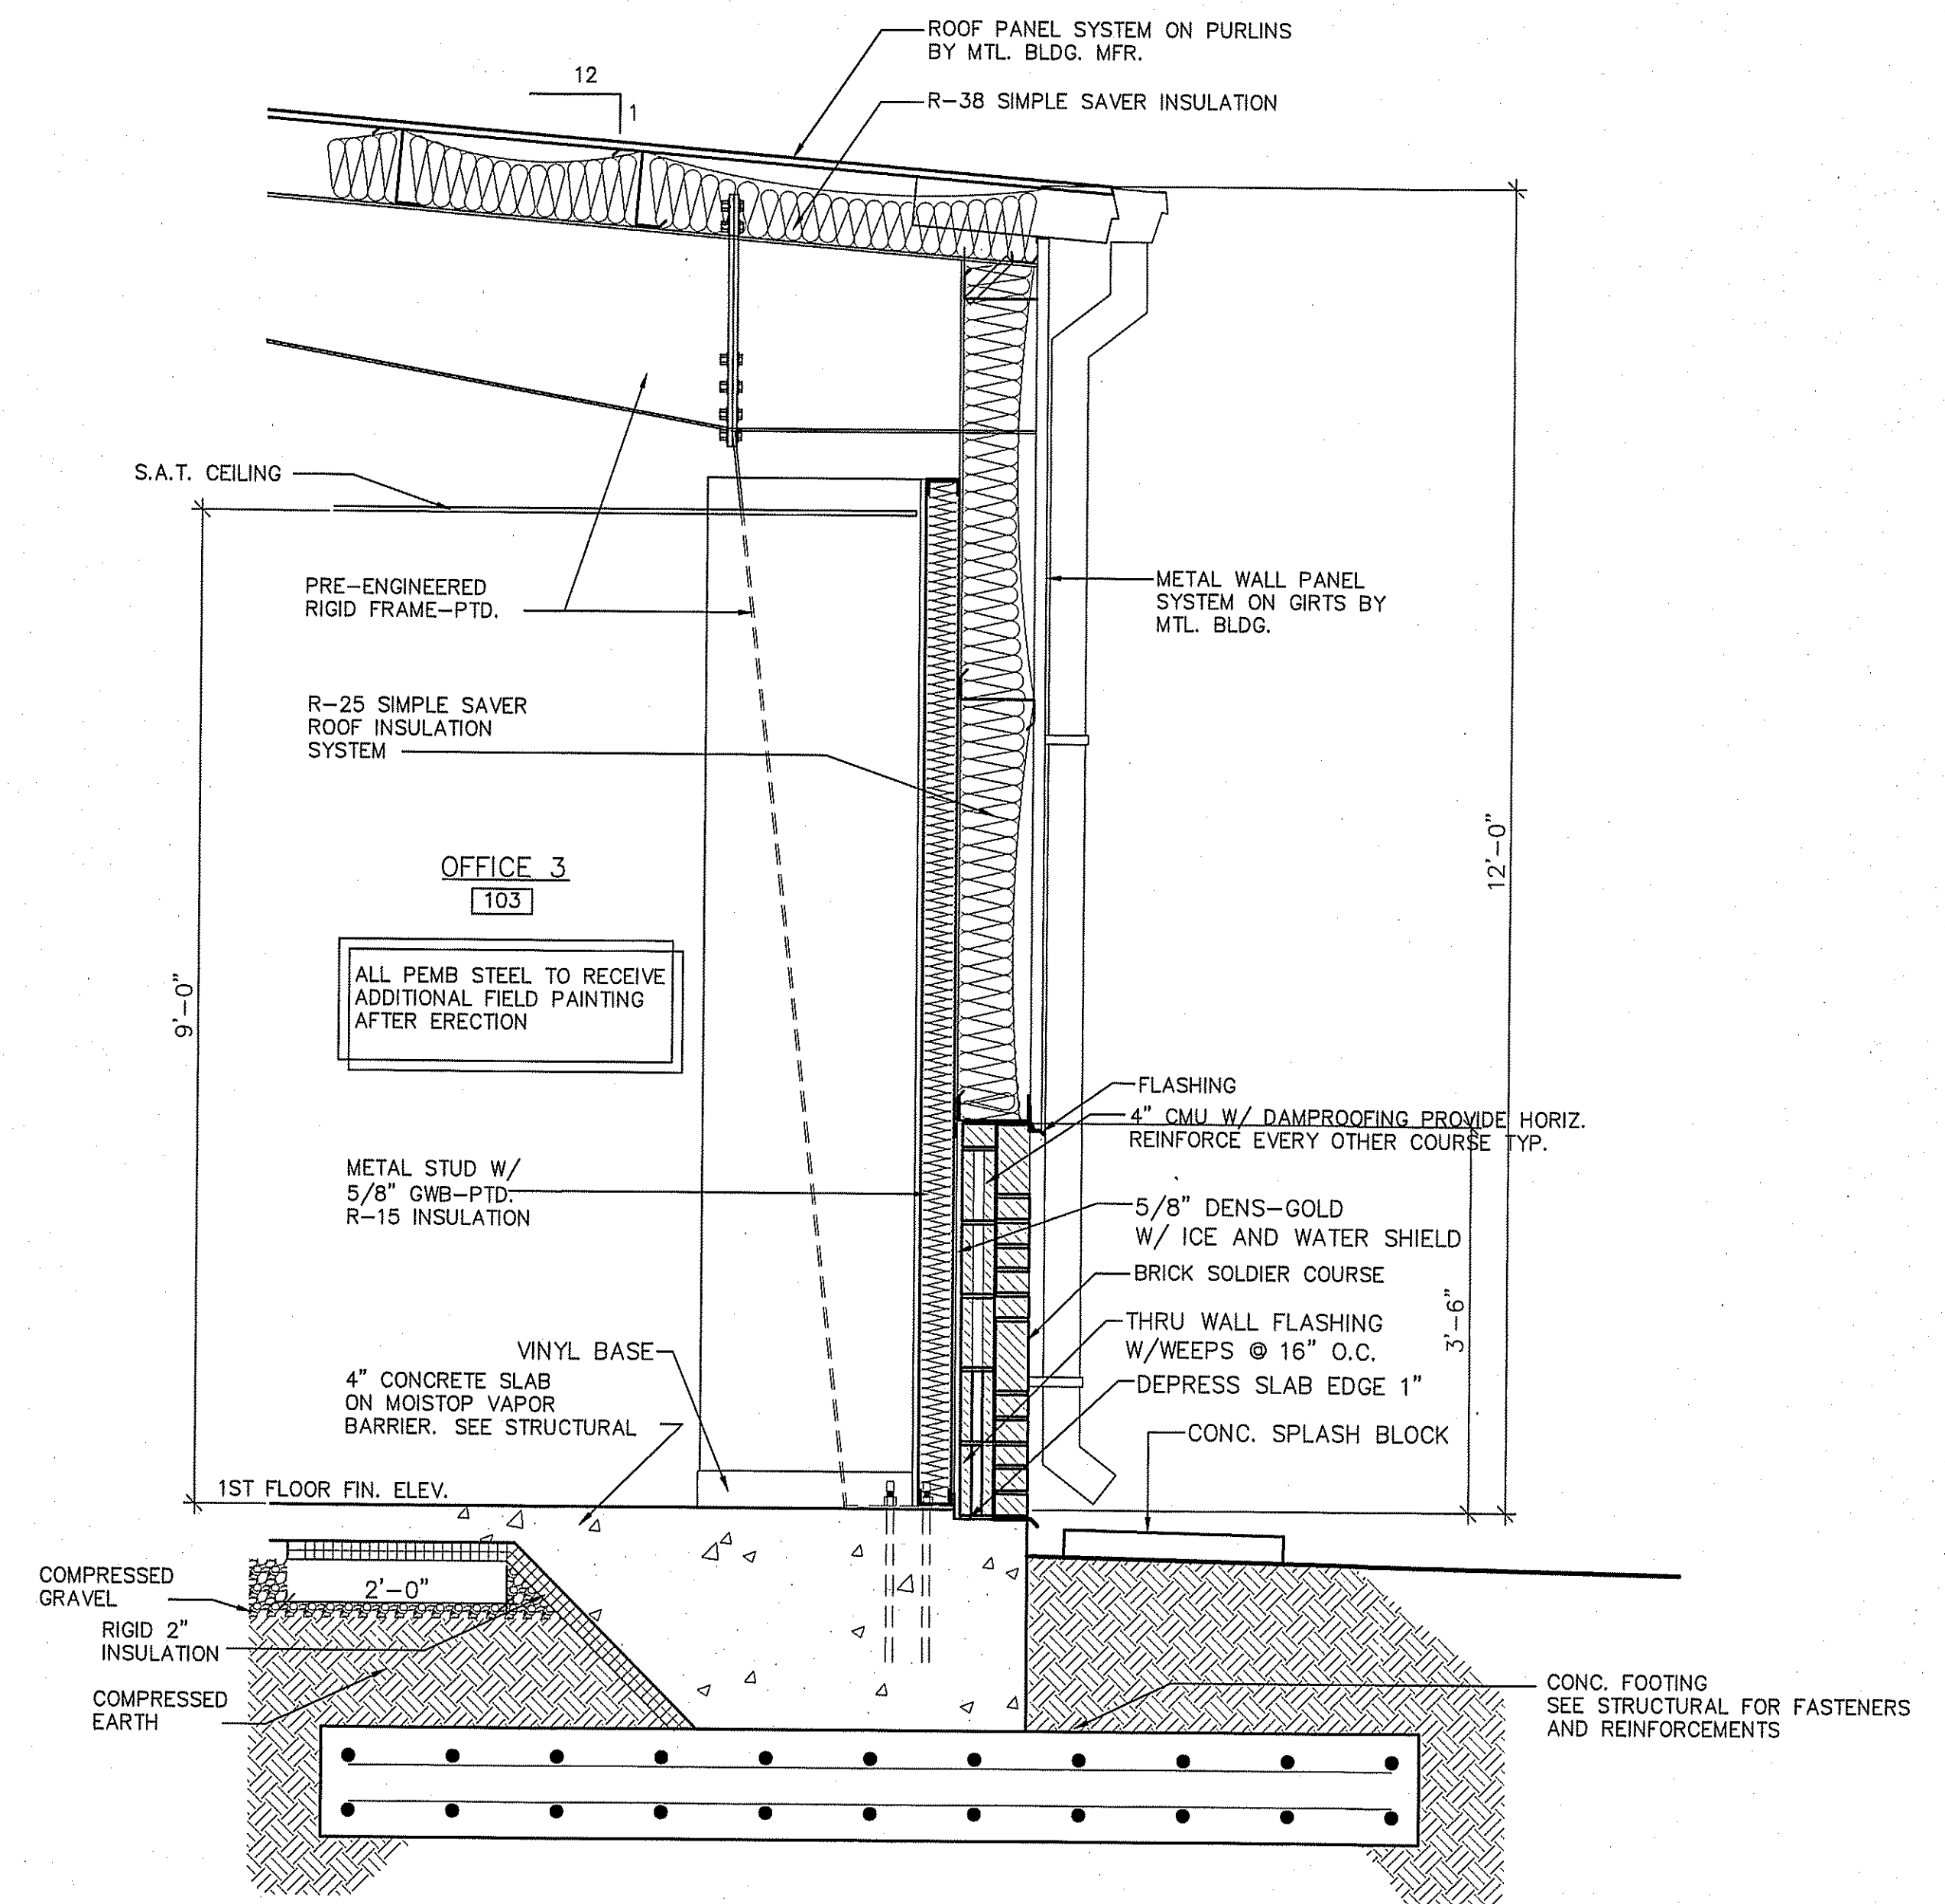

1 WALL SECTION
A-5.1 SCALE: 3/4"=1'-0"

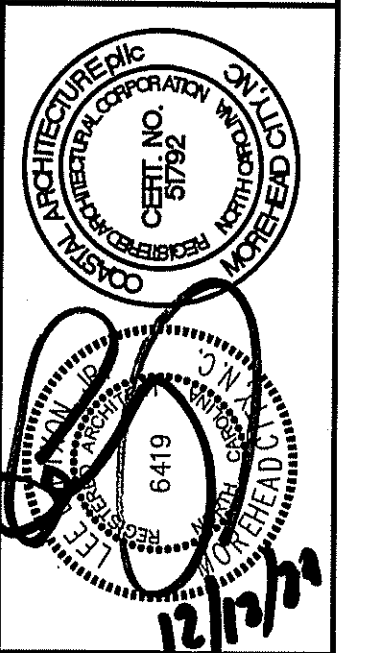


WALL SECTIONS

23029


ISSUED: 12.12.2024
DWG BY: MSG
CKD BY: LDD

REVISIONS


SHEET NO.
A-5.1
OF

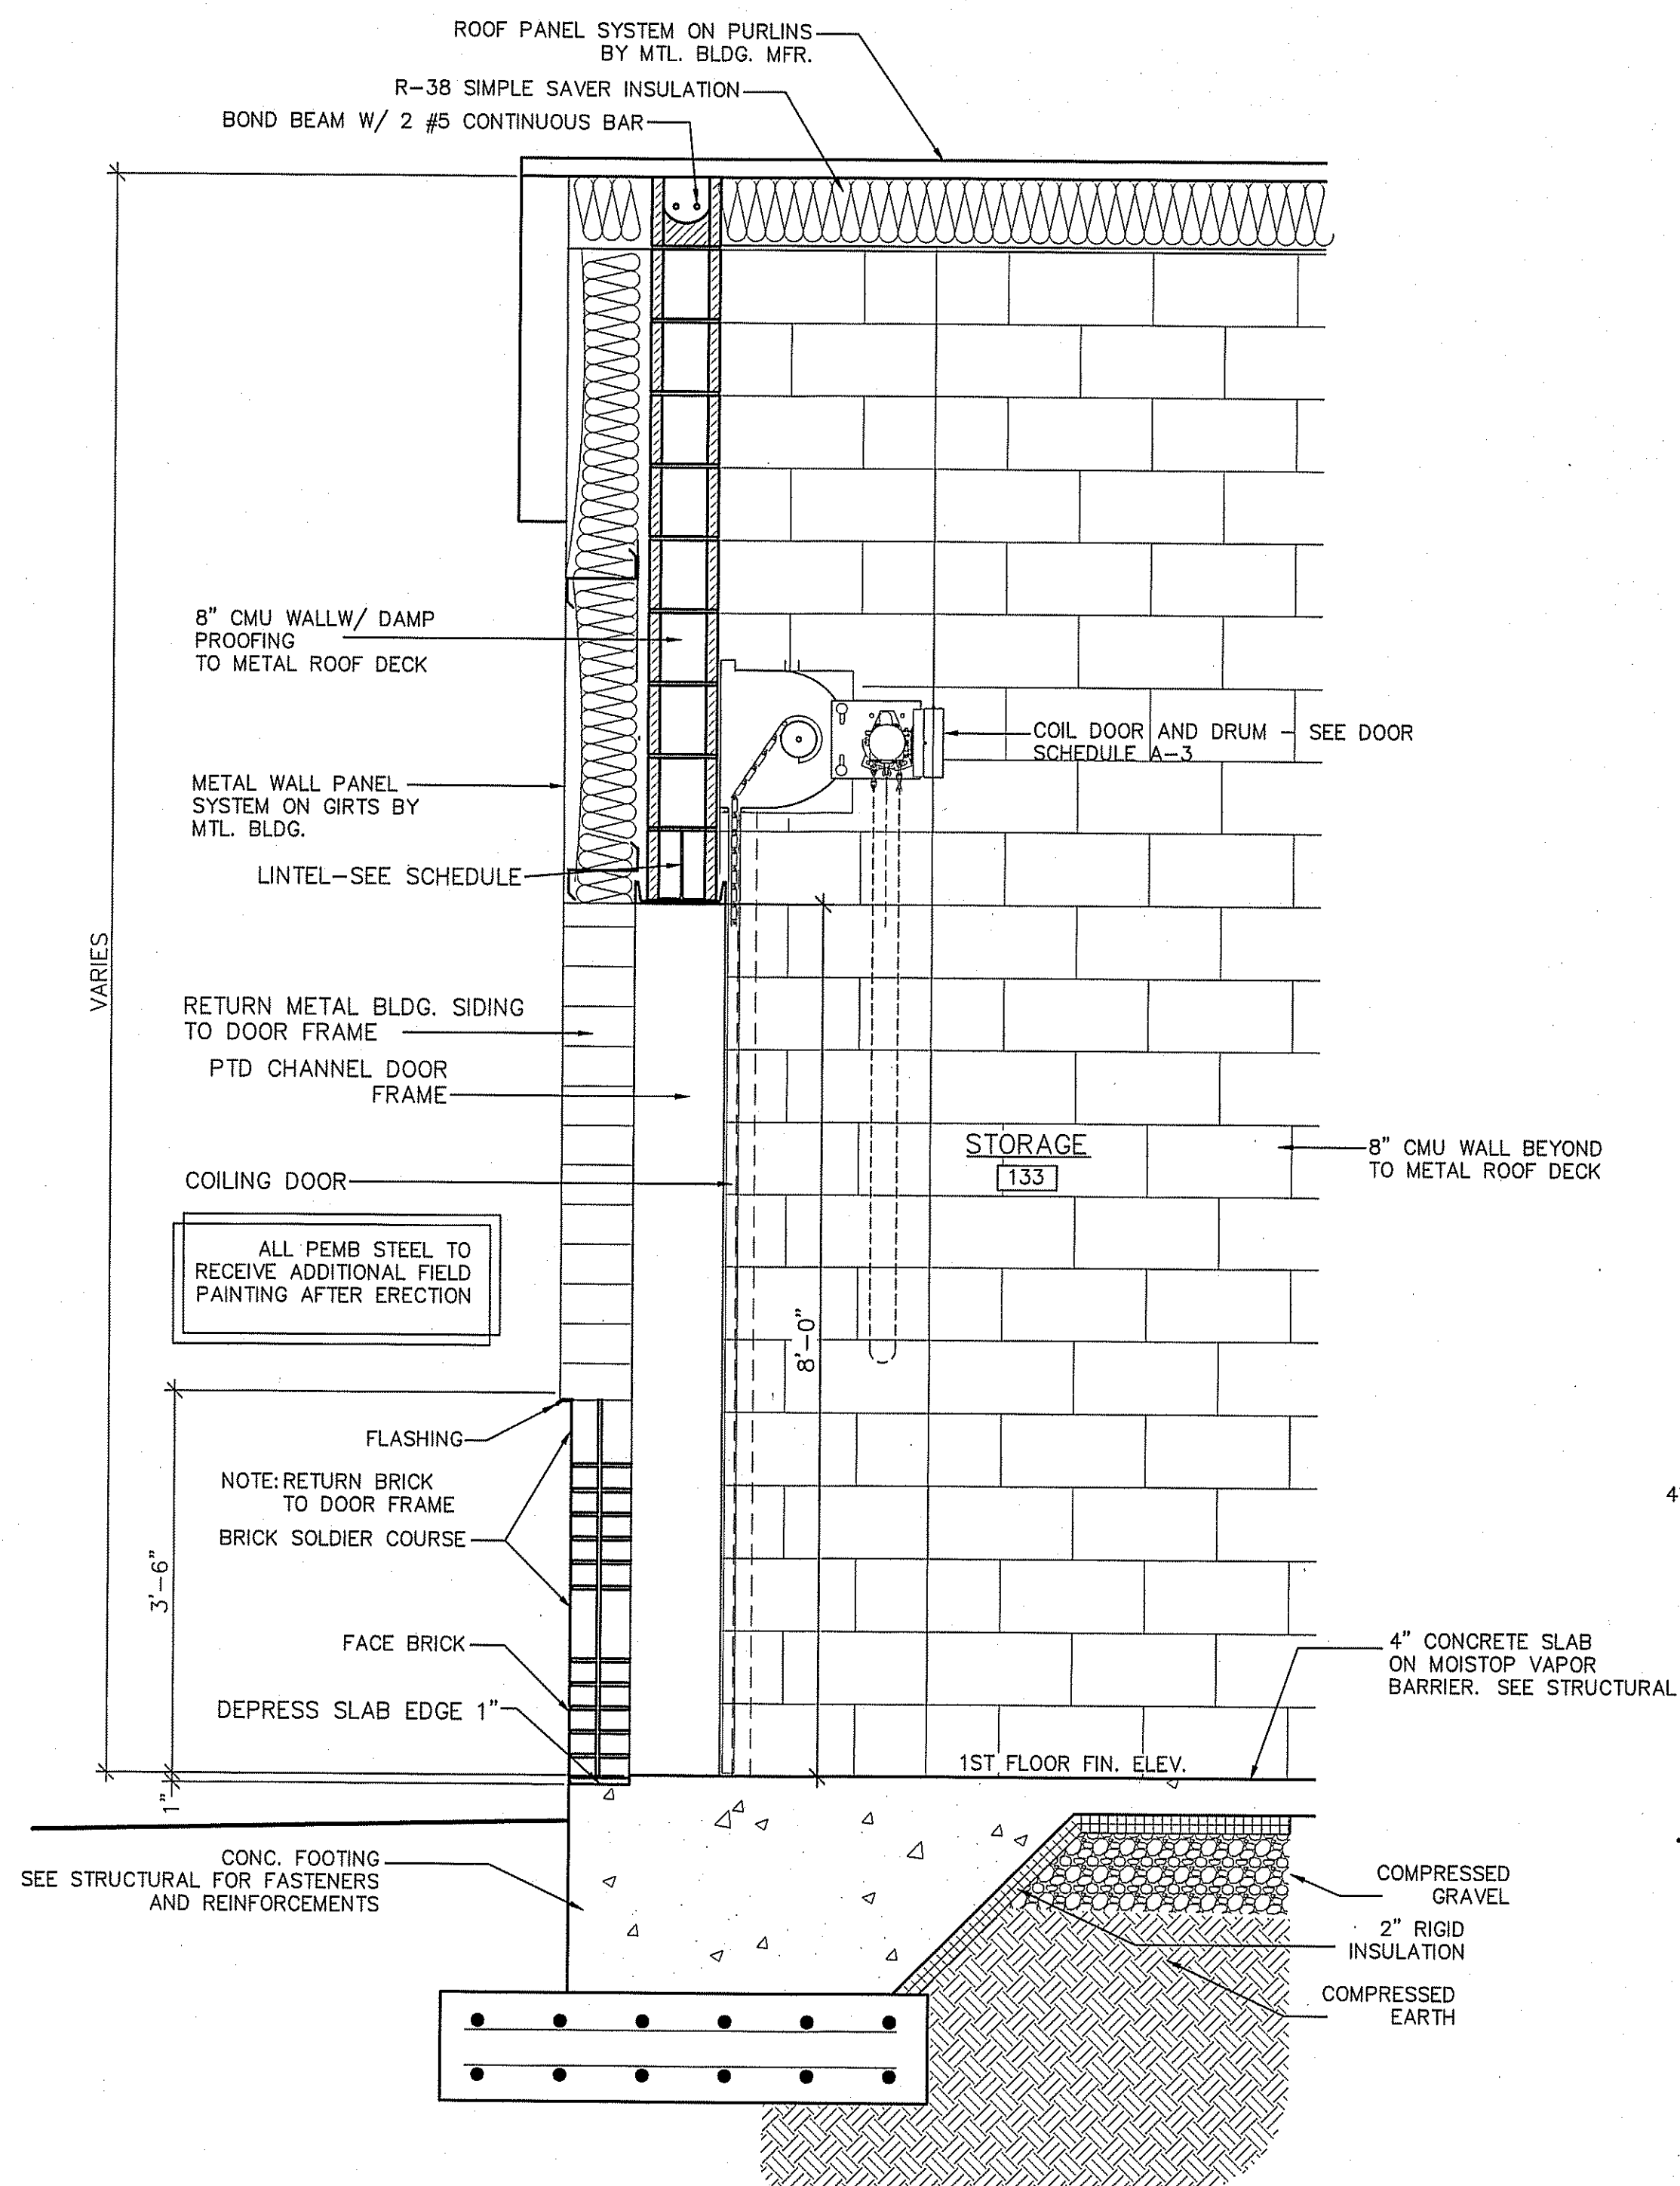


1 WALL SECTION
A-5.2 SCALE: 3/4"=1'-0"

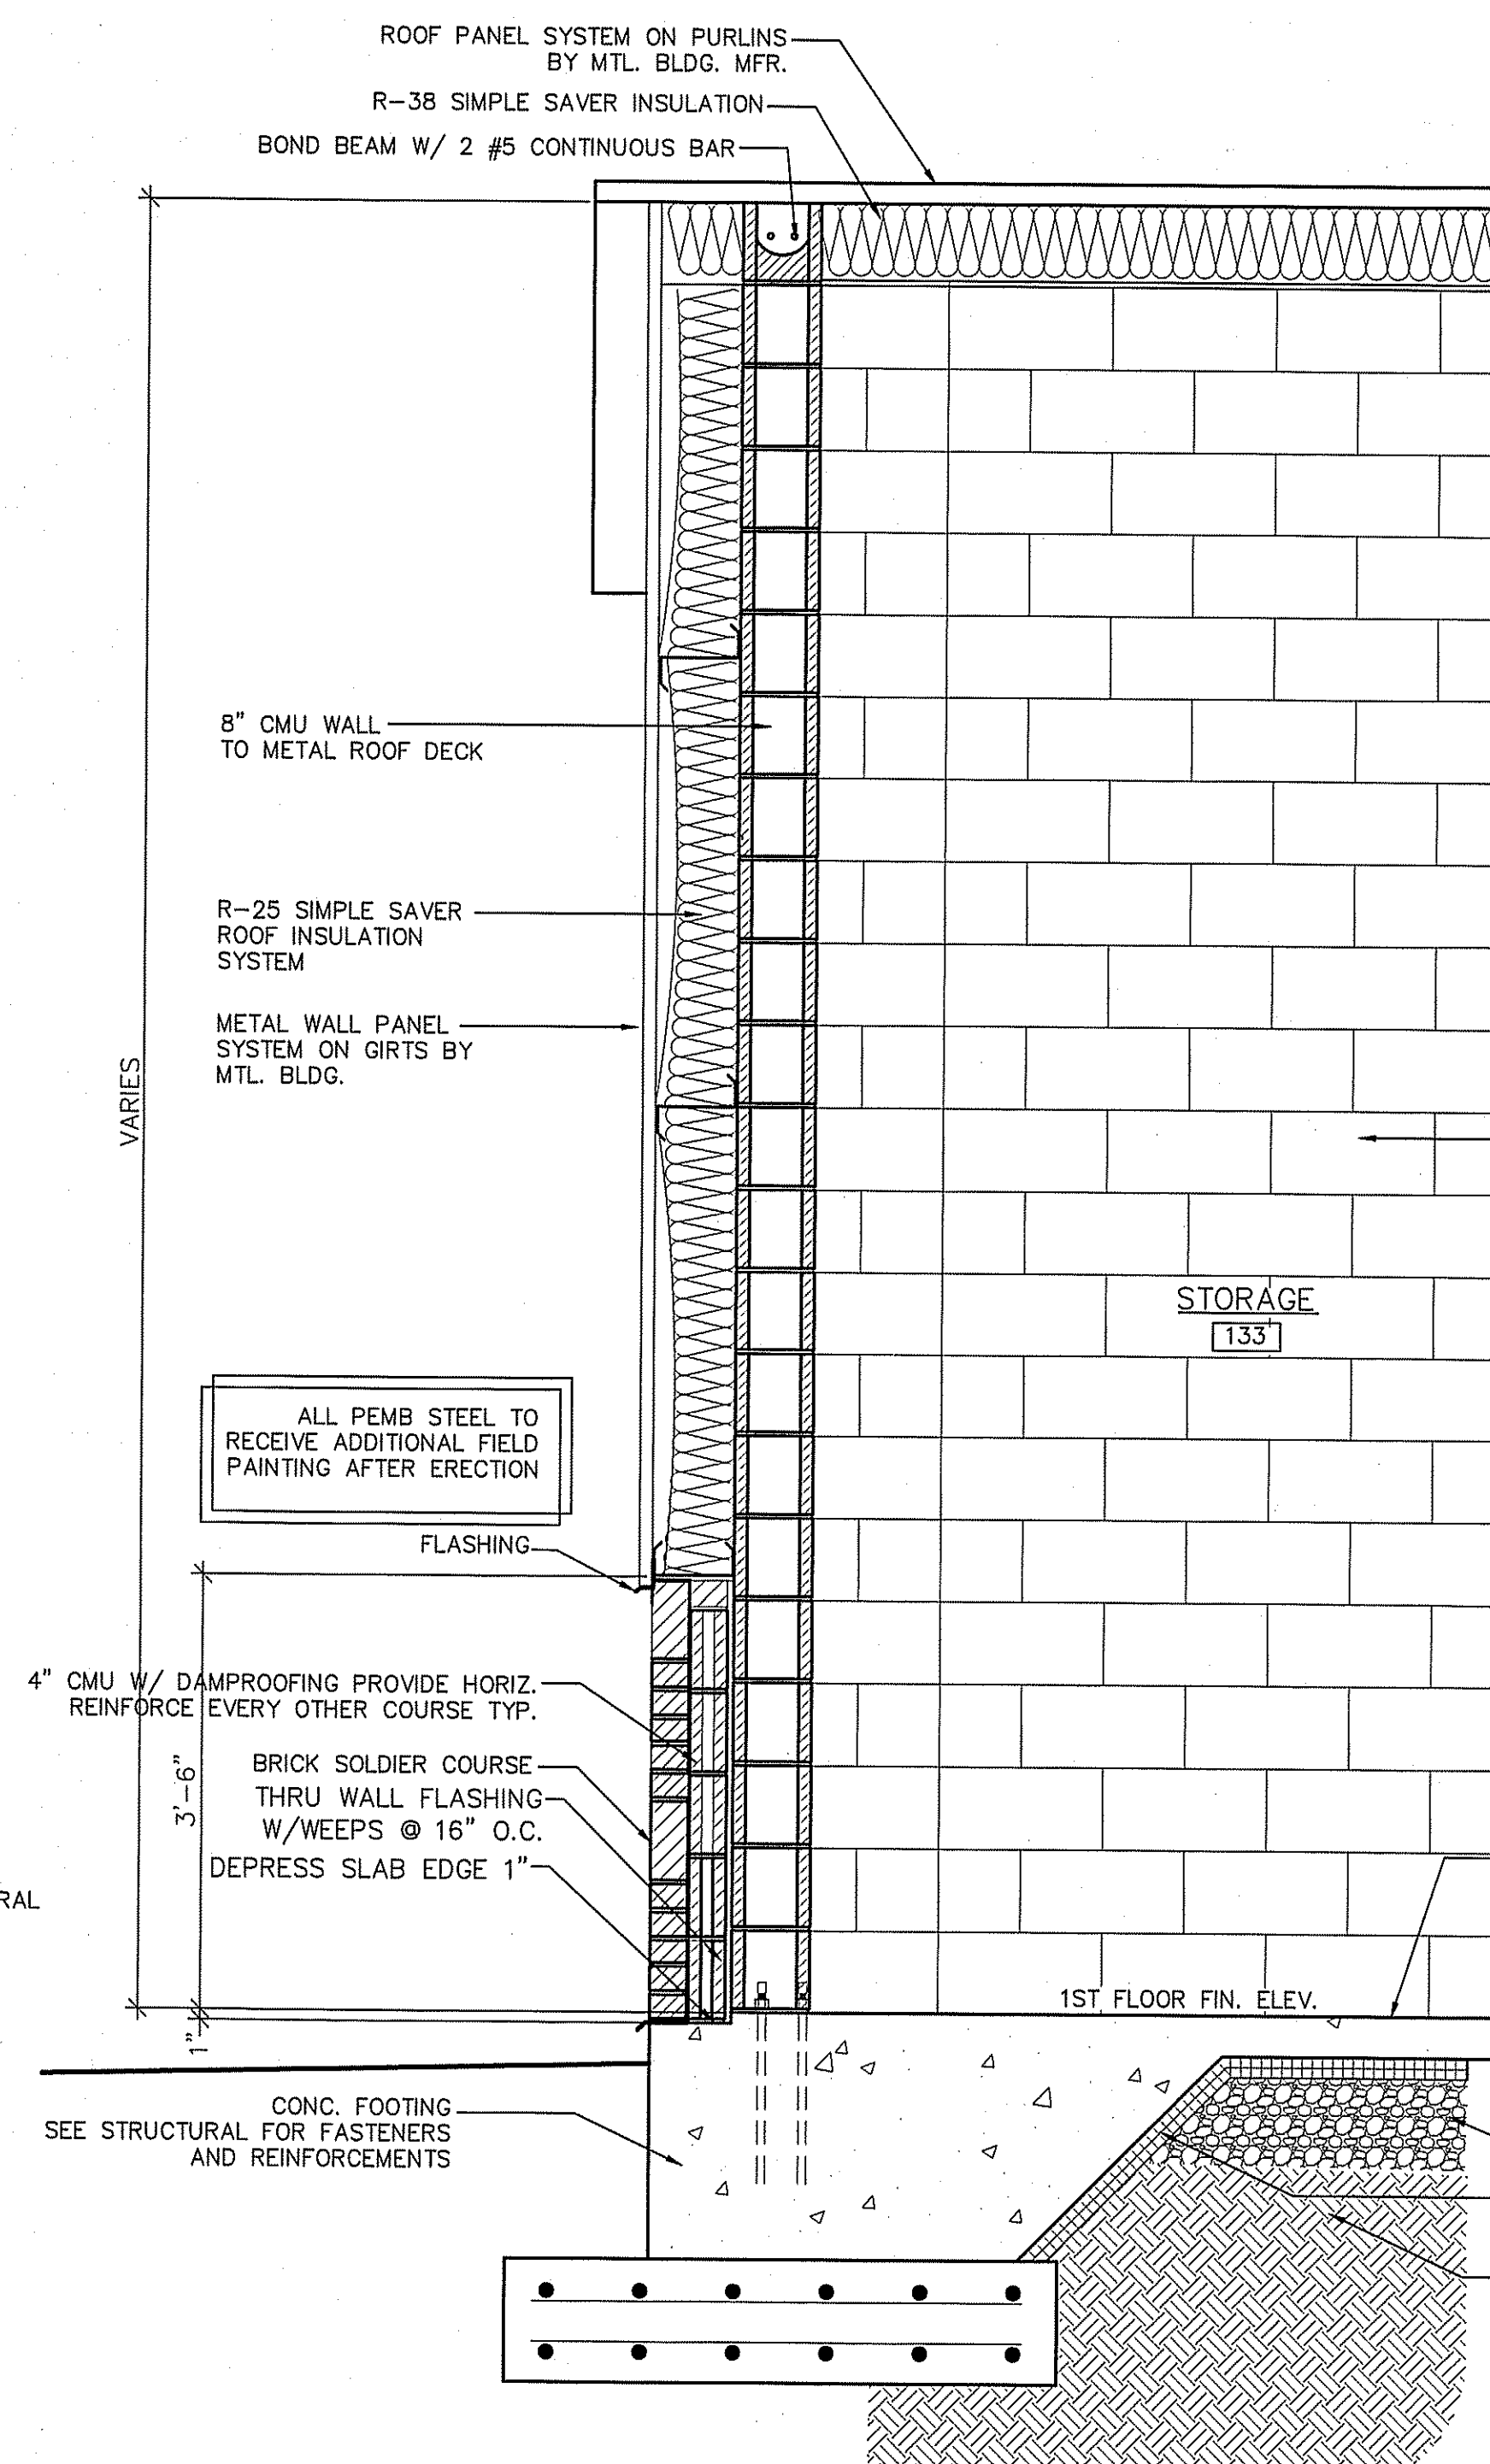

2 WALL SECTION
A-5.2 SCALE: 3/4"=1'-0"

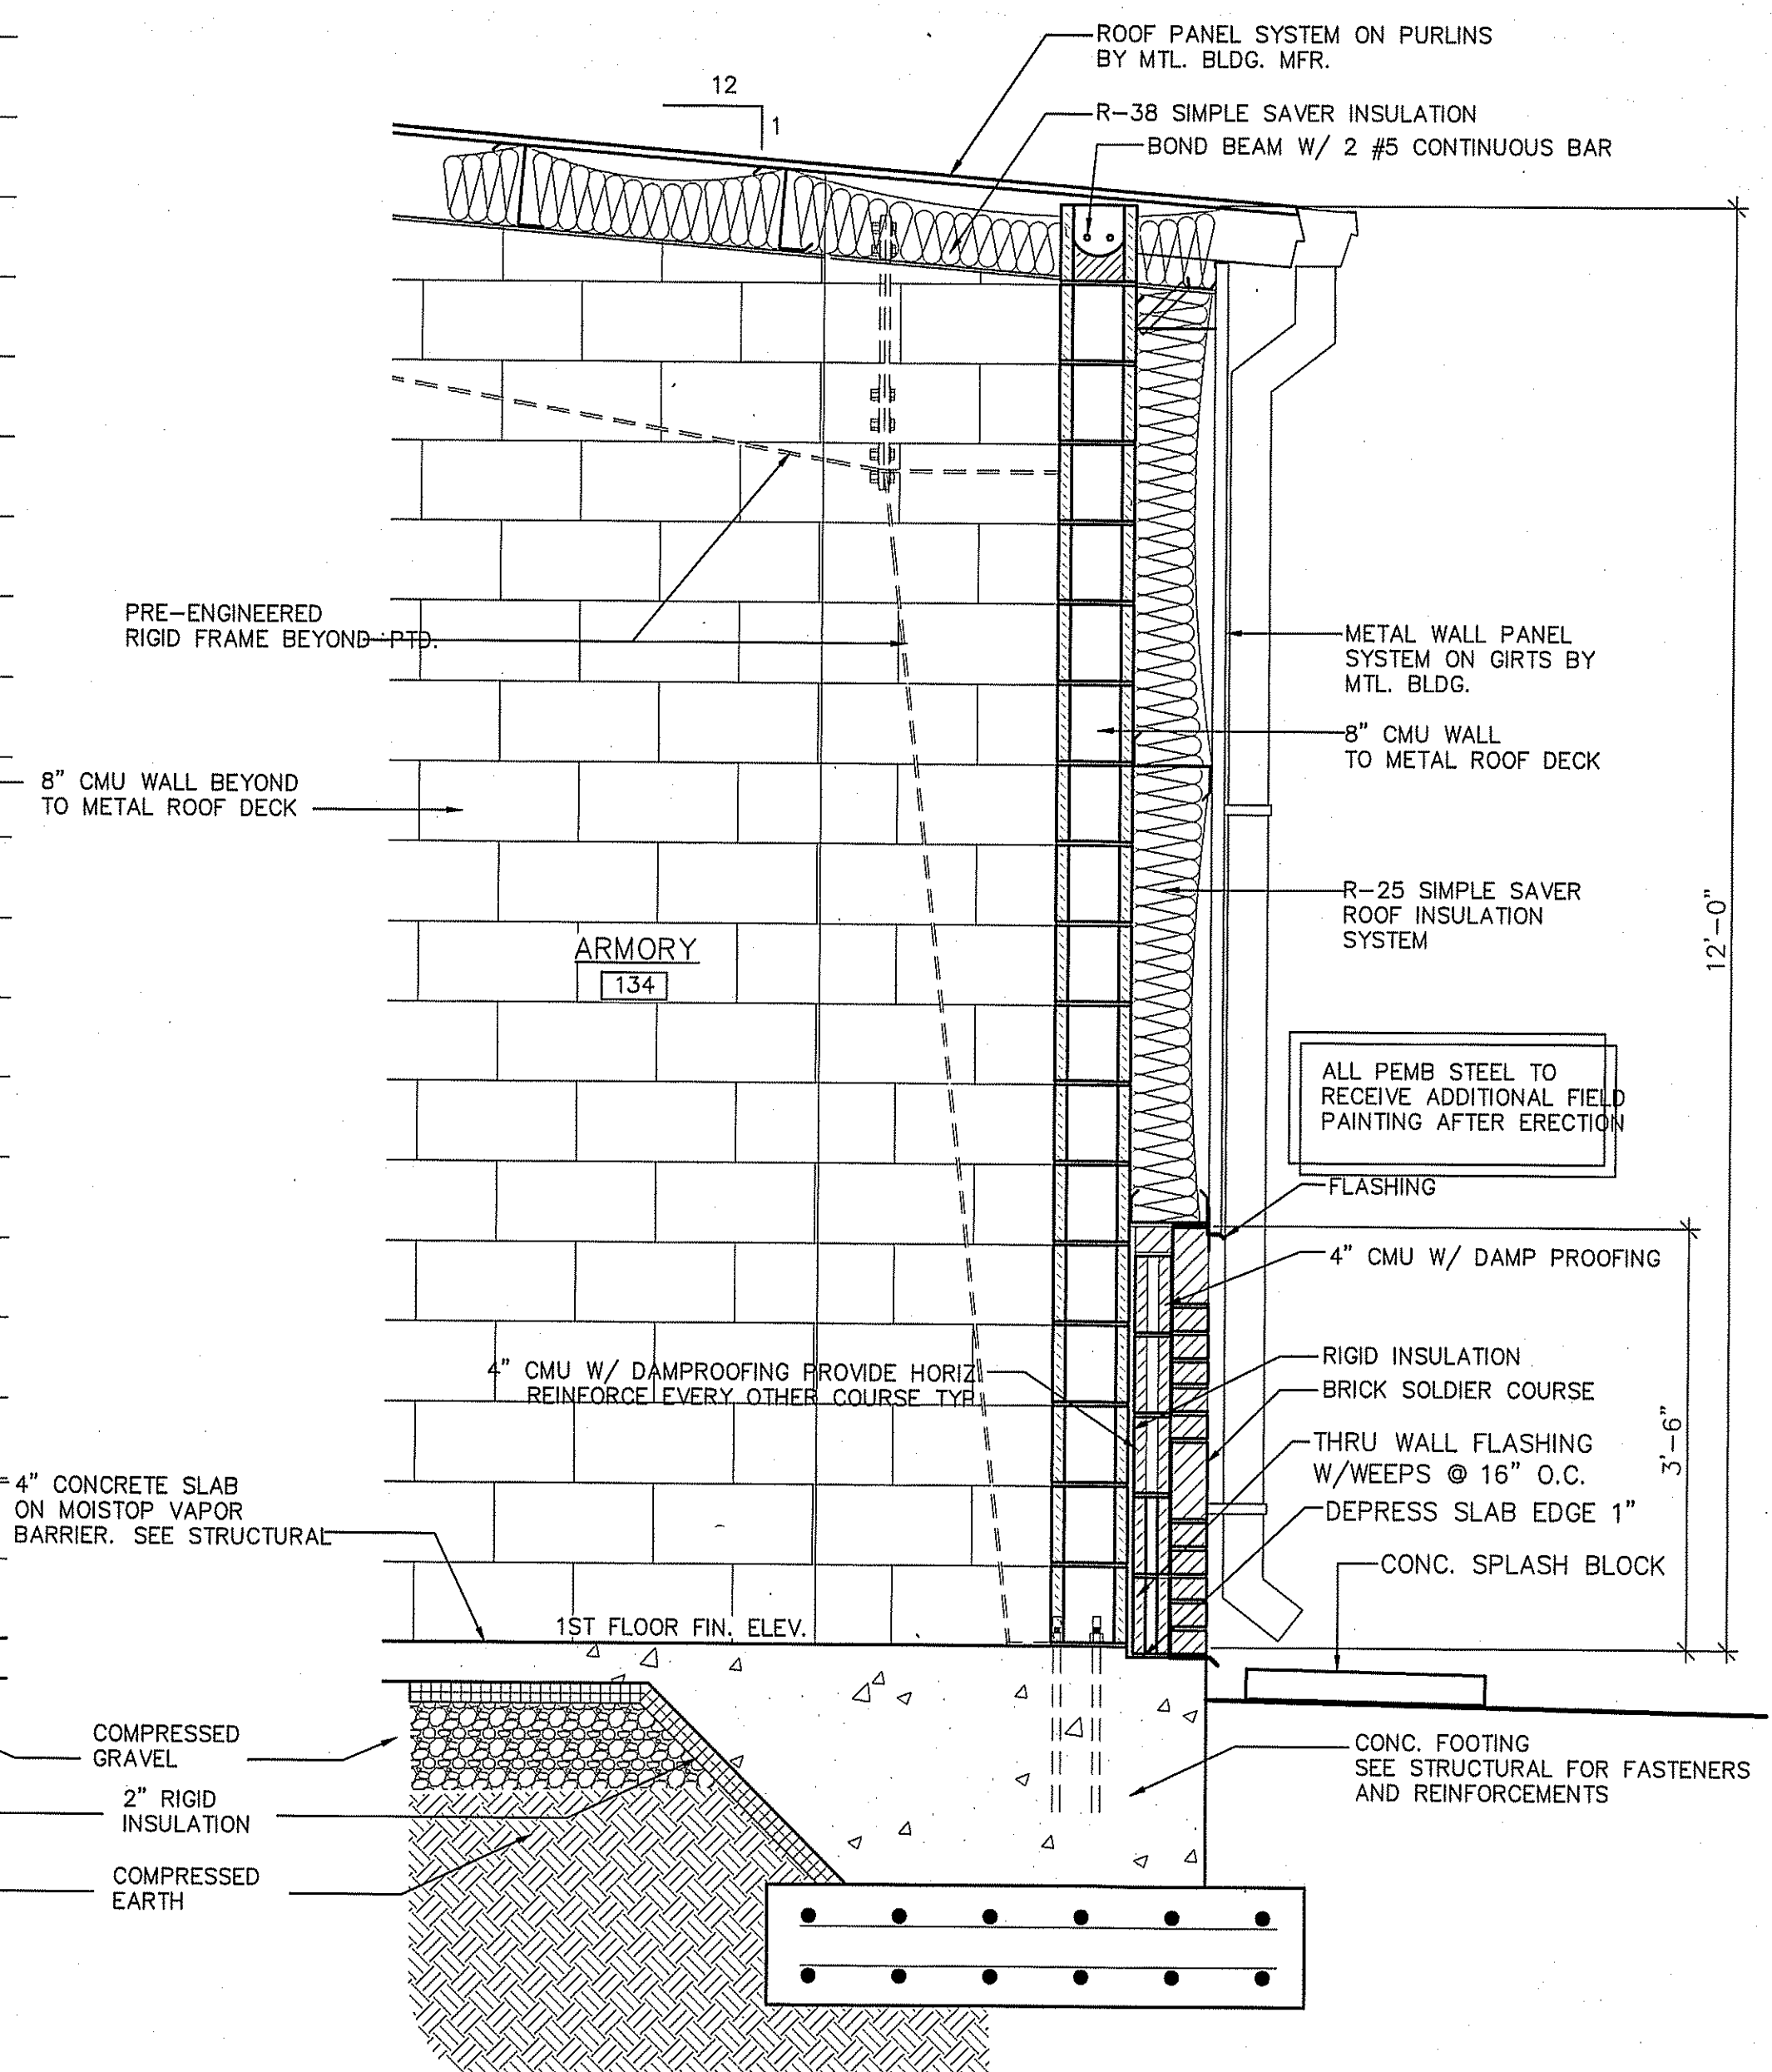


3 WALL SECTION
A-5.2 SCALE: 3/4"=1'-0"

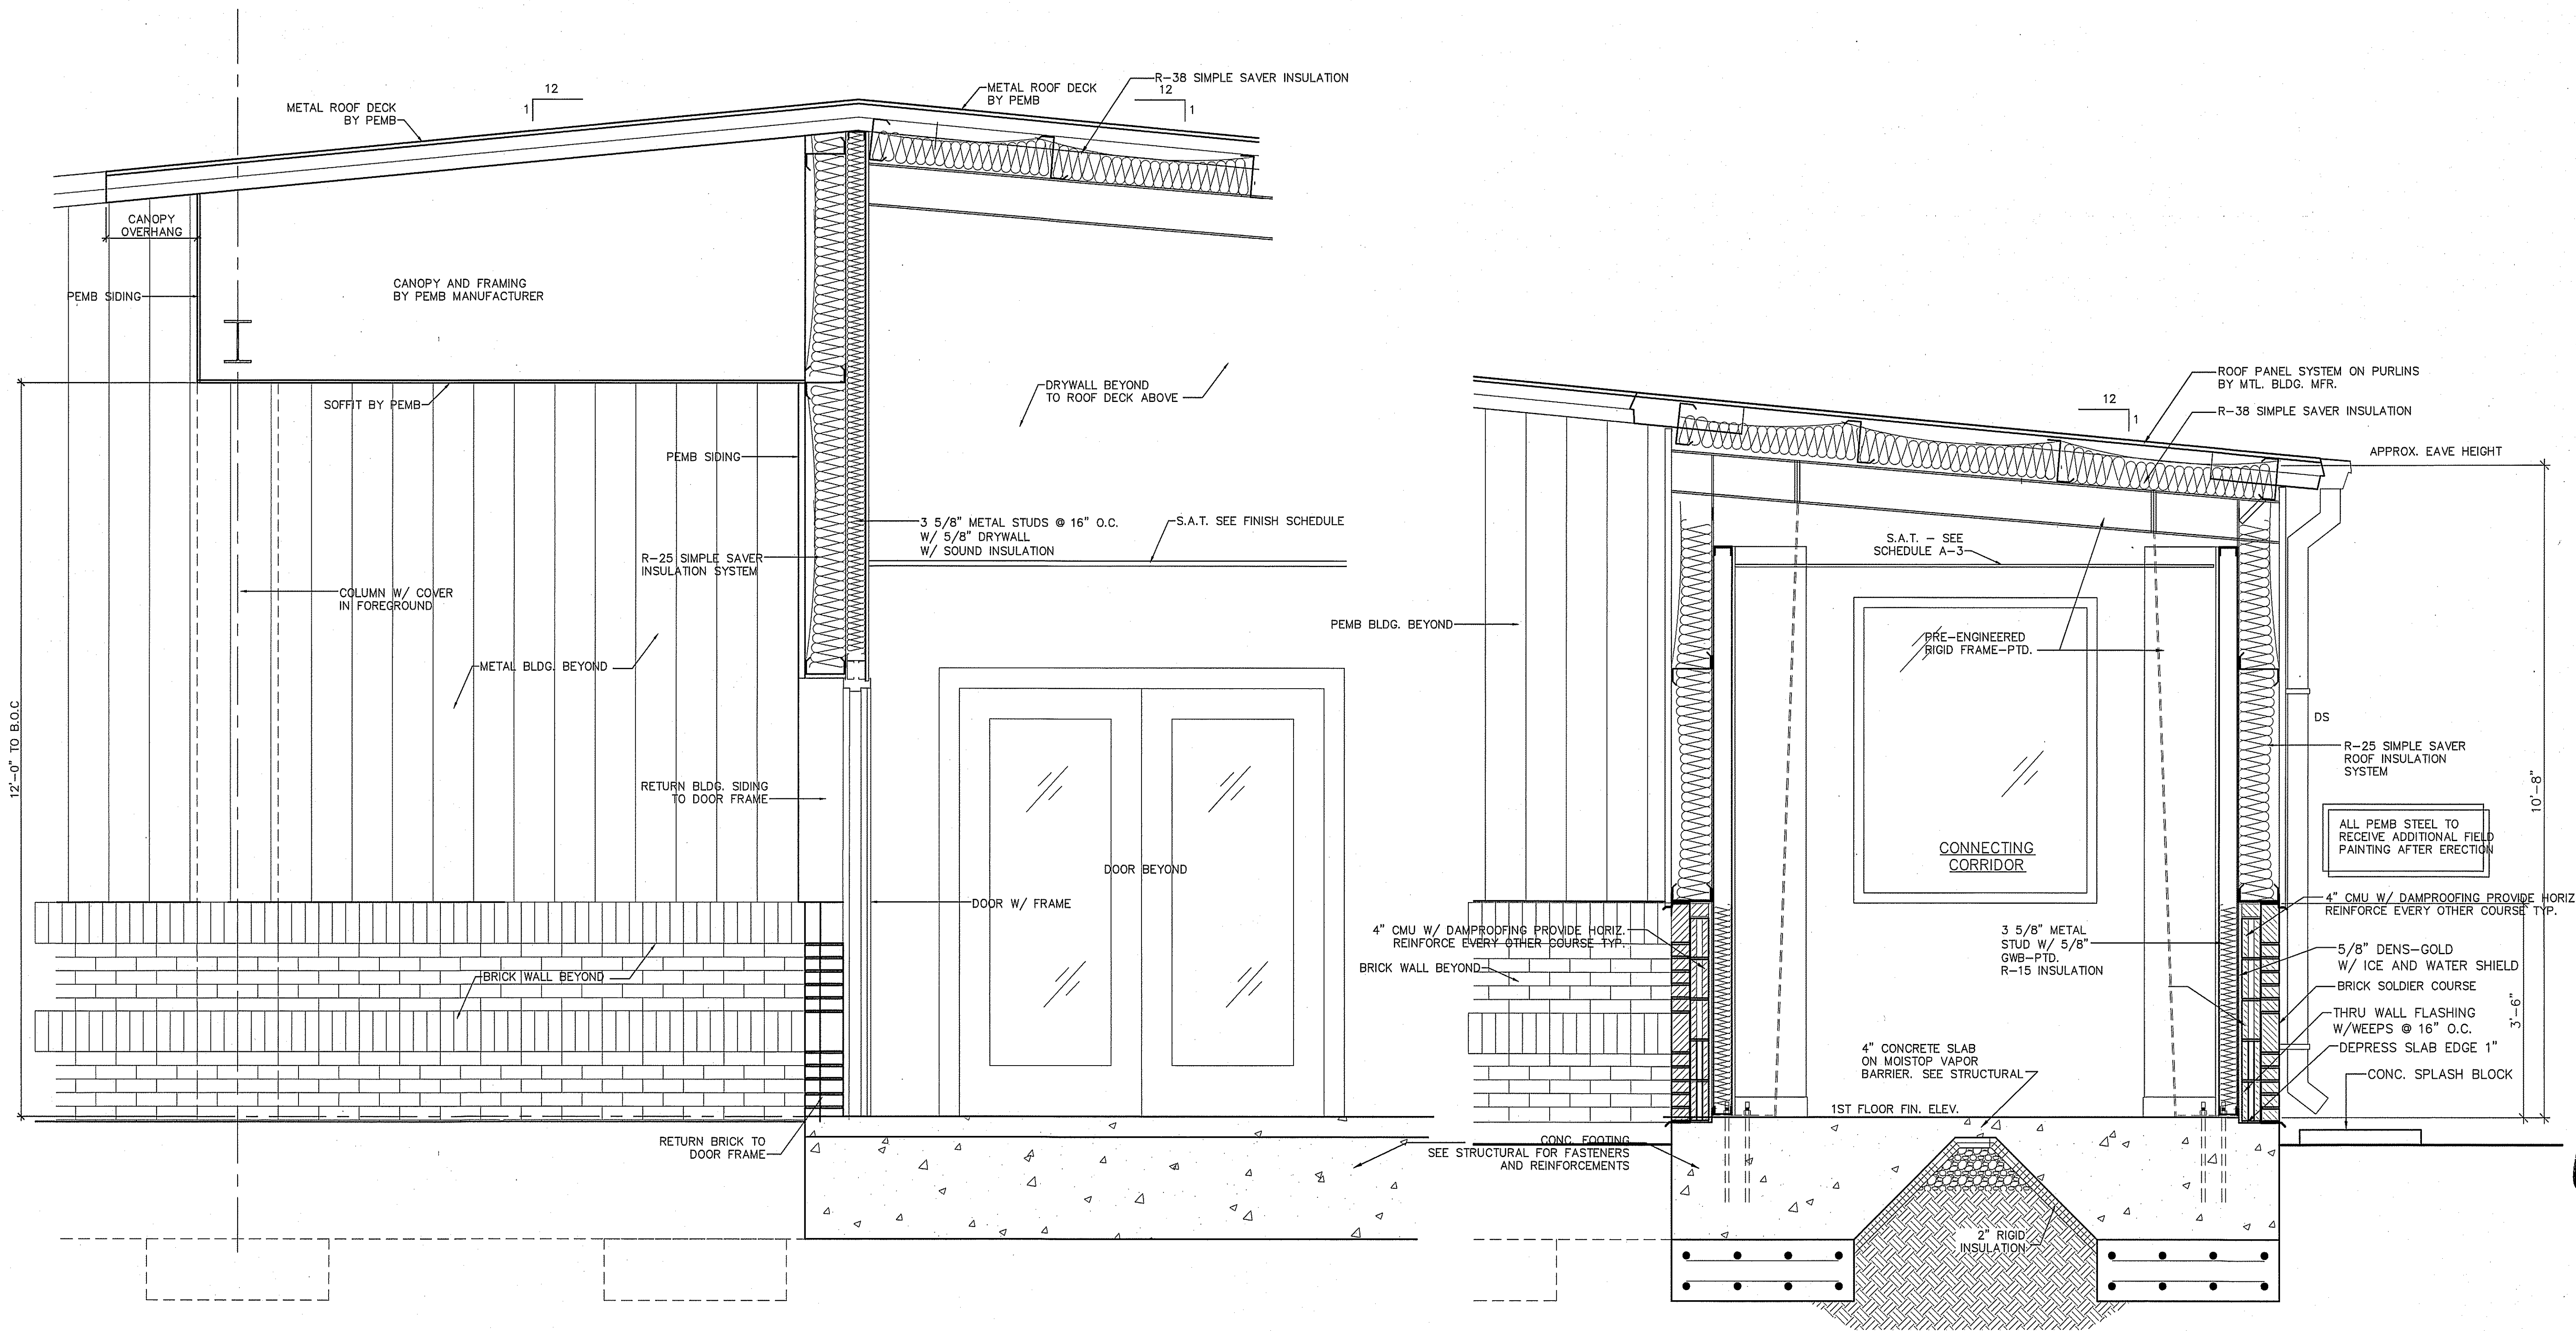


2 WALL SECTION
A-5.3 SCALE: 3/4"=1'-0"

1 WALL SECTION
A-5.3 SCALE: 3/4"=1'-0"

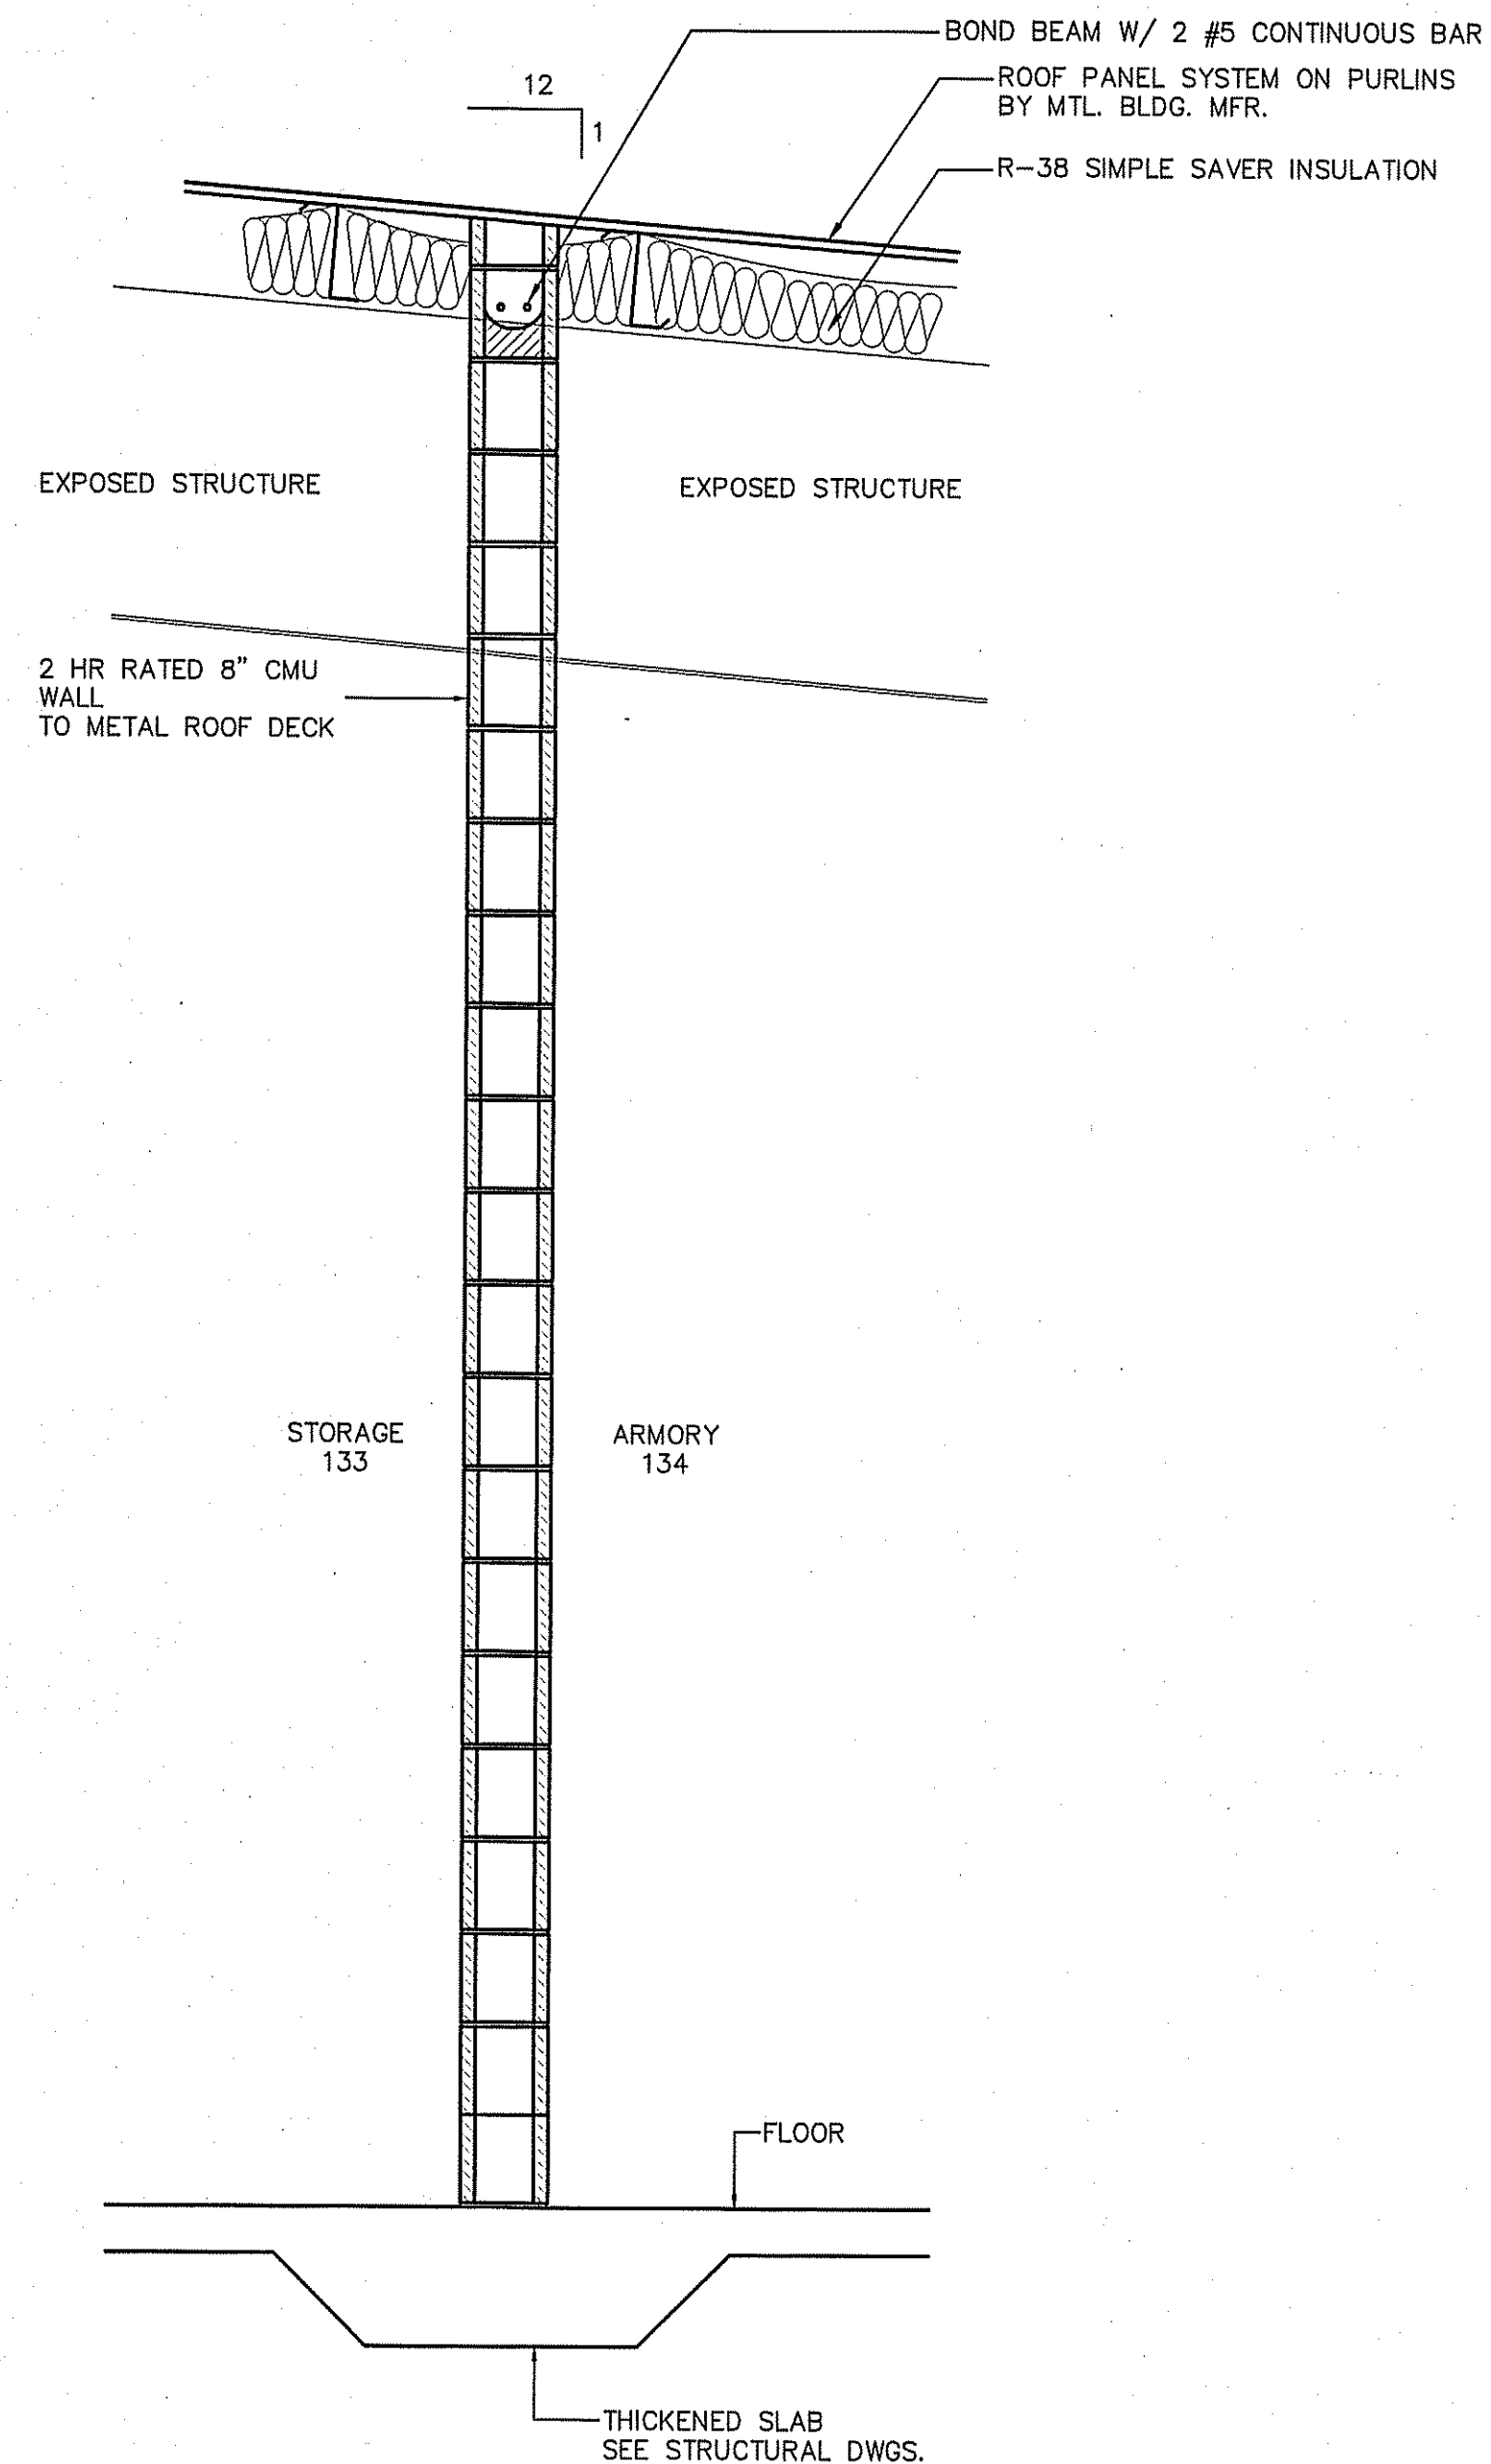


2 WALL SECTION
A-5.4 SCALE: 3/4"=1'-0"

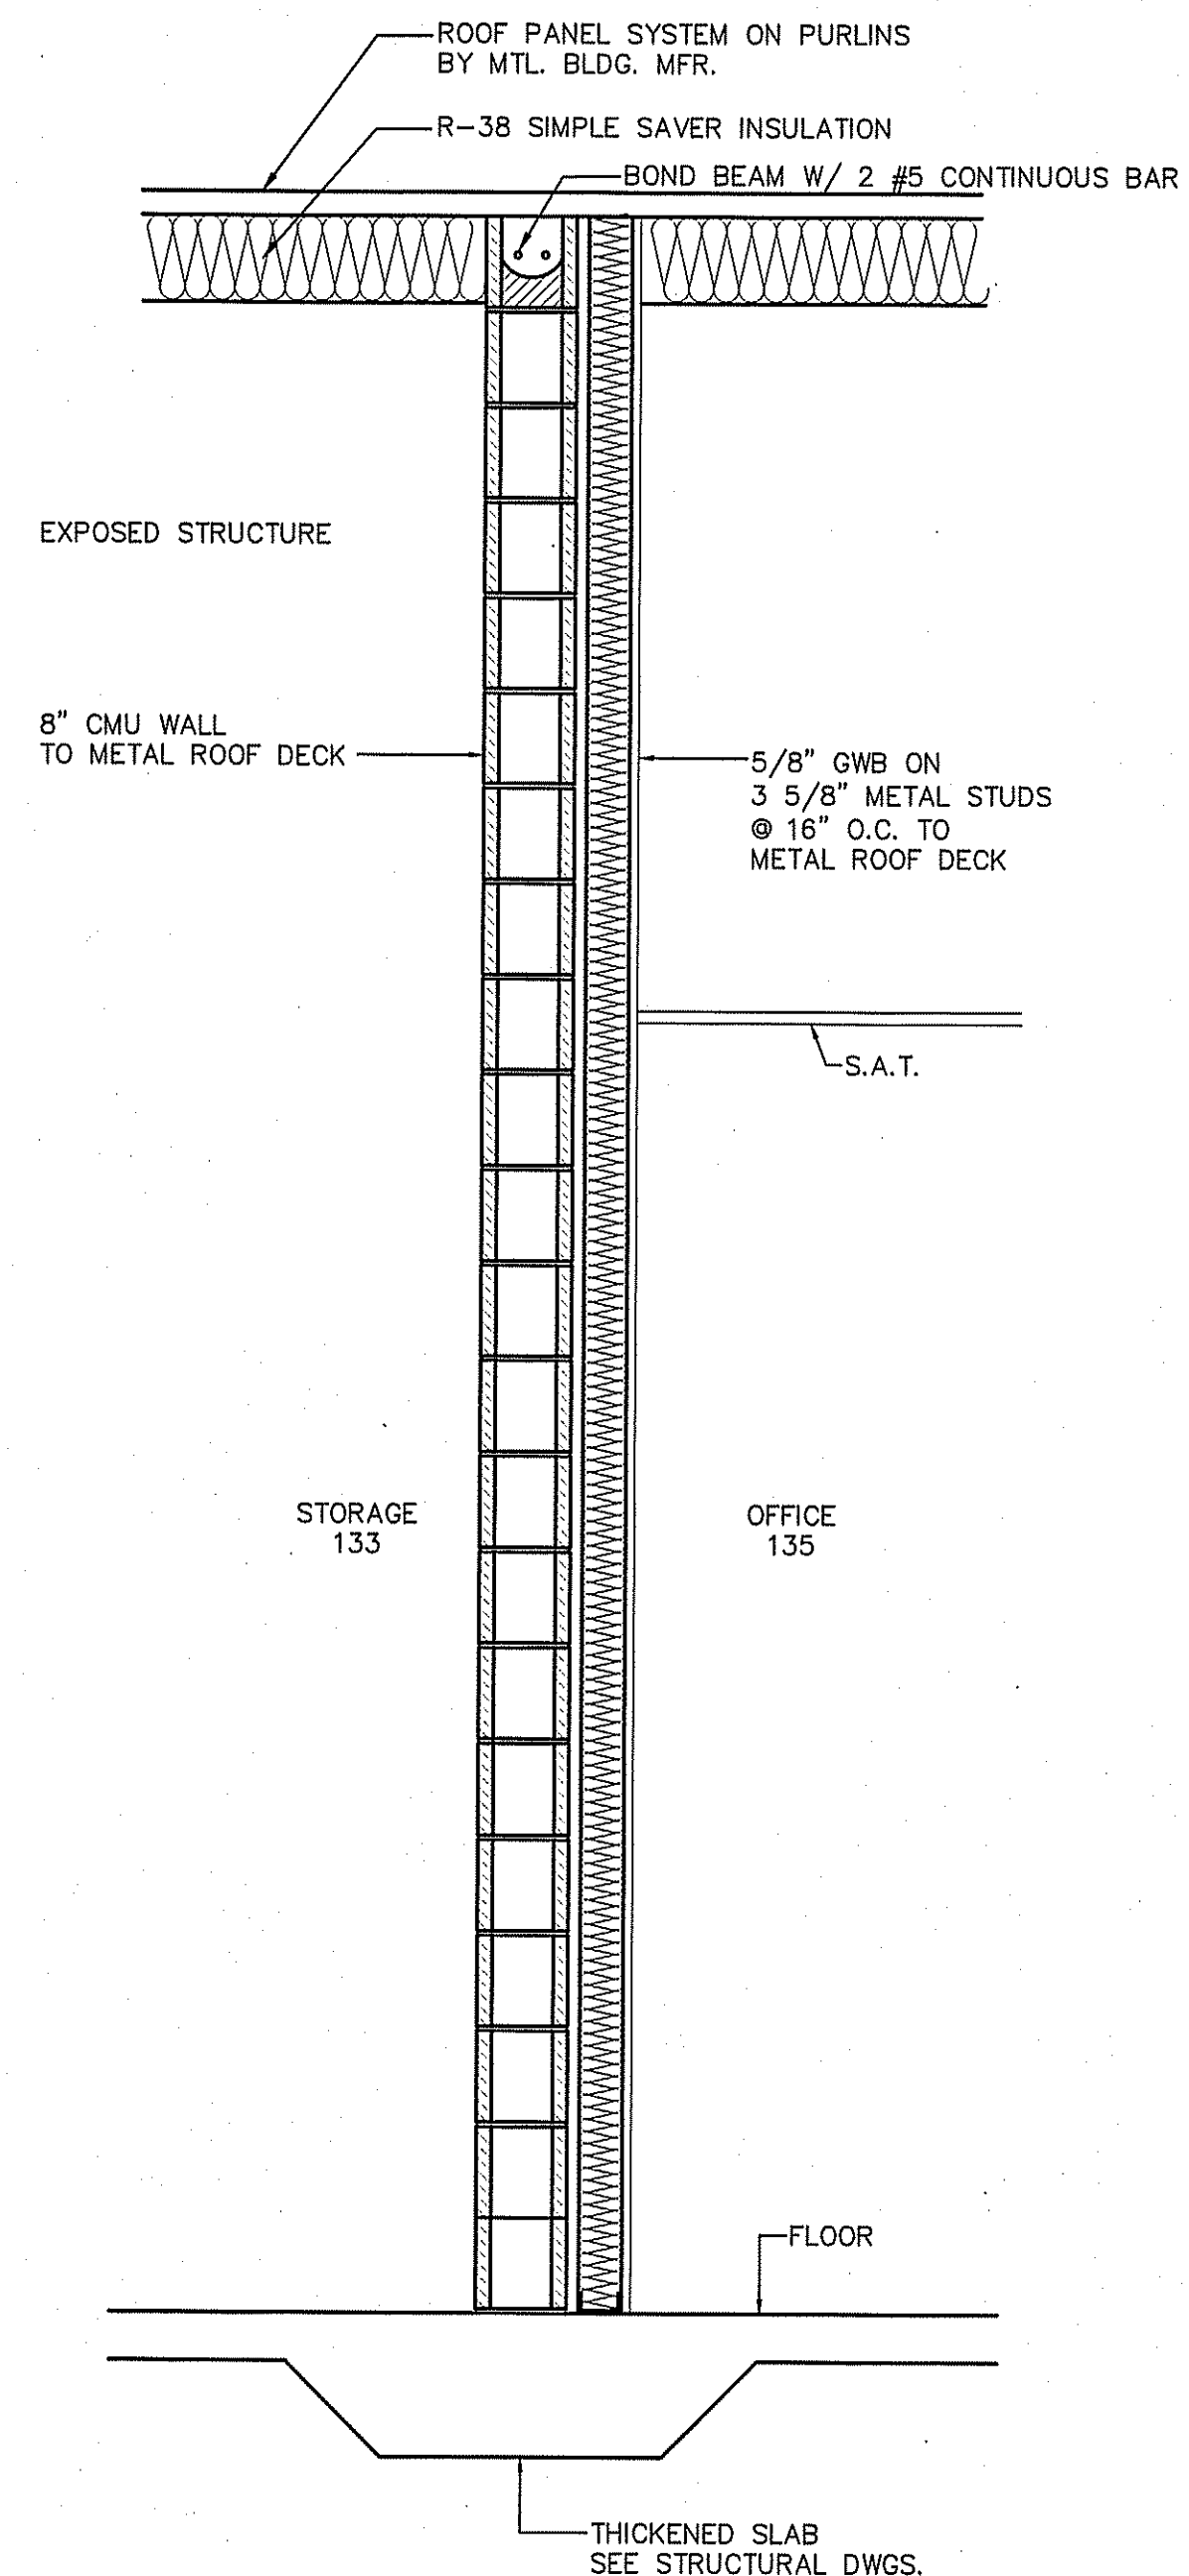

1 WALL SECTION
A-5.4 SCALE: 3/4"=1'-0"


TOILET ACCESSORIES SCHEDULE			
MARK	ITEM	MT.HT.	REMARKS
TA-1	FRAMELESS MIRROR 5'-6"W X 3'-6"H	3'-4"	HT. TO BOTTOM OF MIRROR
TA-2	FRAMELESS MIRROR 5'-0"W X 3'-6"H	3'-4"	HT. TO BOTTOM OF MIRROR
TA-3	TOILET TISSUE DISPENSER	3'-4"	HT. TO TOP OF DISPENSER
TA-4	PAPER TOWEL DISPENSER B-9262	4'-0" MAX	HT. TO BOTTOM OF DISPENSER
TA-5	HANDICAP SOAP DISPENSER B-2013	4'-0" MAX	HT. TO BOTTOM OF DISPENSER
TA-6	GRAB BAR 42" B-6806X42	3'-0" MAX	HT. TO CENTER
TA-7	GRAB BAR 24" B-6806X24	3'-0" MAX	HT. TO CENTER
TA-8	GRAB BAR 18" (VERTICAL) B-6806X18	3'-3" MAX	HT. TO BOTTOM OF CENTER OF BAR @ 40" FROM REAR WALL
TA-9	SURFACE MOUNTED SEAT COVER DISPENSER	2'-6"	HT. TO TOP OF DISPENSER
TA-10	SANITARY BIN	2'-6"	
TA-11	COAT HOOK	4'-0" MAX	HT. TO TOP OF DISPENSER
TA-12	FOLDING SHOWER SEAT B-5181	17"-19"	HT. FROM FLOOR TO TOP OF SEAT
TA-13	GRAB BAR B-6806X48	3'-0" MAX	HT. FROM FLOOR TO TOP OF GRIPPING SURFACE
TA-14	GRAB BAR 24" B-6806X24	3'-0" MAX	HT. TO CENTER
TA-15	SHOWER CURTAIN ROD B-207 X 60	72" - 74"	HT. FROM FLOOR TO < OF ROD
TA-16	PREFAB FIBERGLASS SHOWER INSERT 36"		SEE PLUMBING DRAWING
TA-17	FRAMELESS MIRROR 3'-6"W X 3'-6"H	3'-4"	HT. TO BOTTOM OF MIRROR
TA-18	CHILD CHANGING TABLE		

- NOTES:
- MODEL NUMBERS ARE BOBRICK, UON. BRADLEY, FRANKLIN & ASI ARE APPROVED EQUALS. SUBMIT CUT SHEETS FOR APPROVAL.
 - SUBMIT SHOP DRAWINGS FOR ALL TOILET PARTITION CONFIGURATIONS.
 - ALL HANDRAILS SHALL BE BLOCKED TO SUPPORT A 250 LB. LOAD MINIMUM.
 - PROVIDE BLOCKING AS REQUIRED FOR ALL ACCESSORIES.

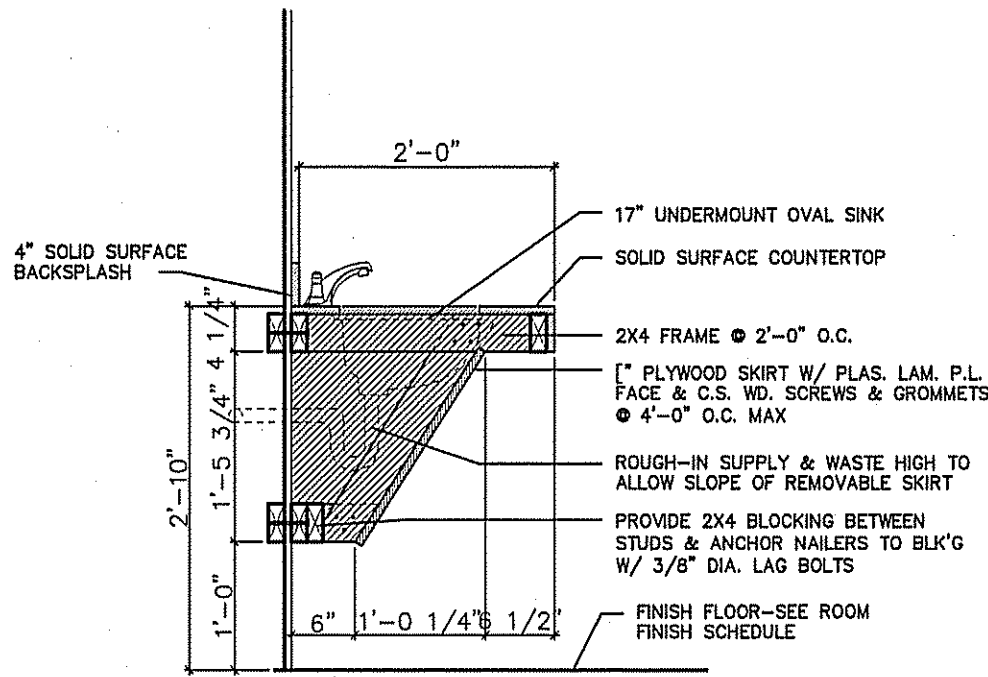


5 VANITY DETAIL
A-6 SCALE: 1"=1'-0"


- GENERAL NOTES:
1. PLASTIC LAMINATE P.L. EXTERIOR/WHITE MELAMINE COATING
 2. CONCEALED HINGES THROUGHOUT
 3. 4" SATIN CHROME PULL WIRES
 4. ALL SHELVING ADJUSTABLE W/ COUNTERSUNK STANDARDS

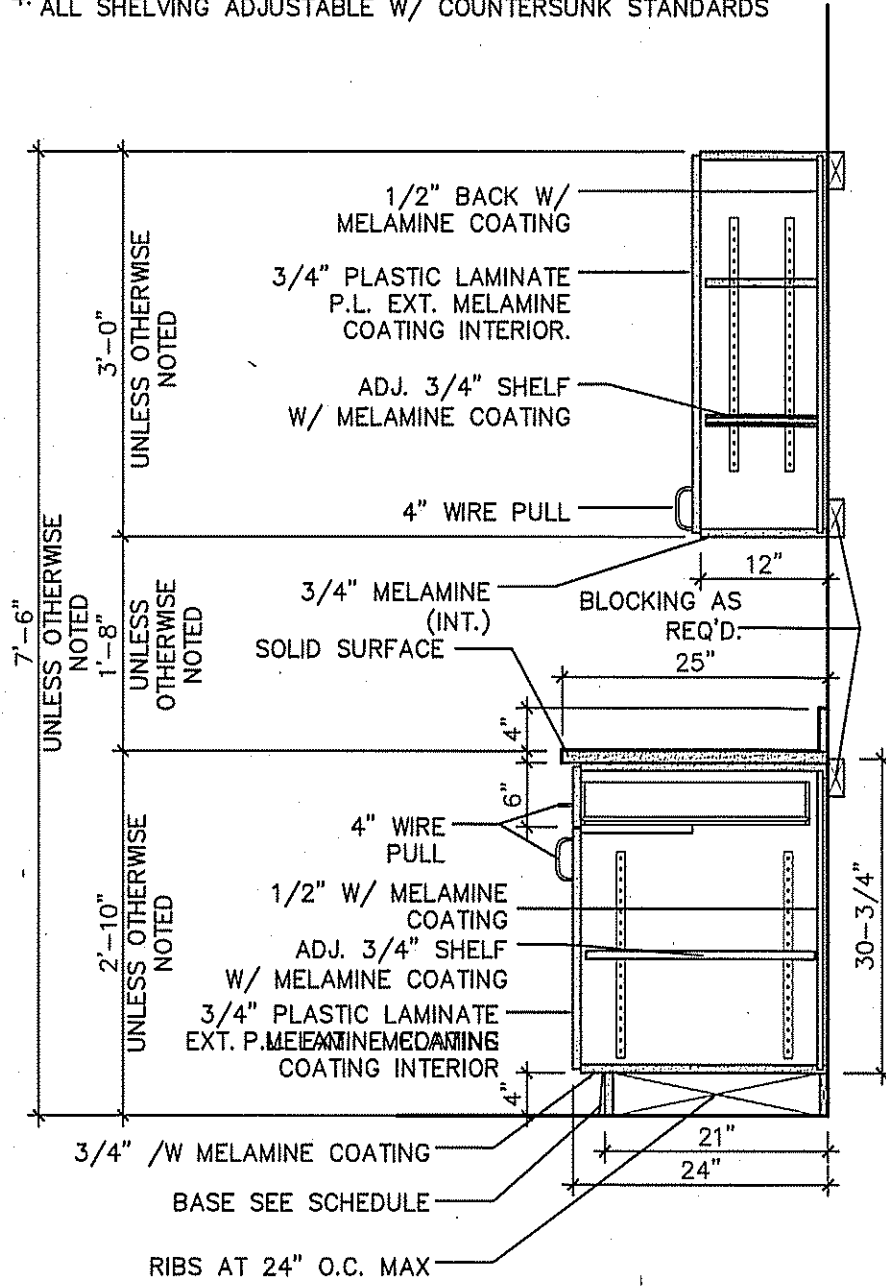


4 KITCHEN CABINET SECTION
A-6 SCALE: 3/4"=1'-0"

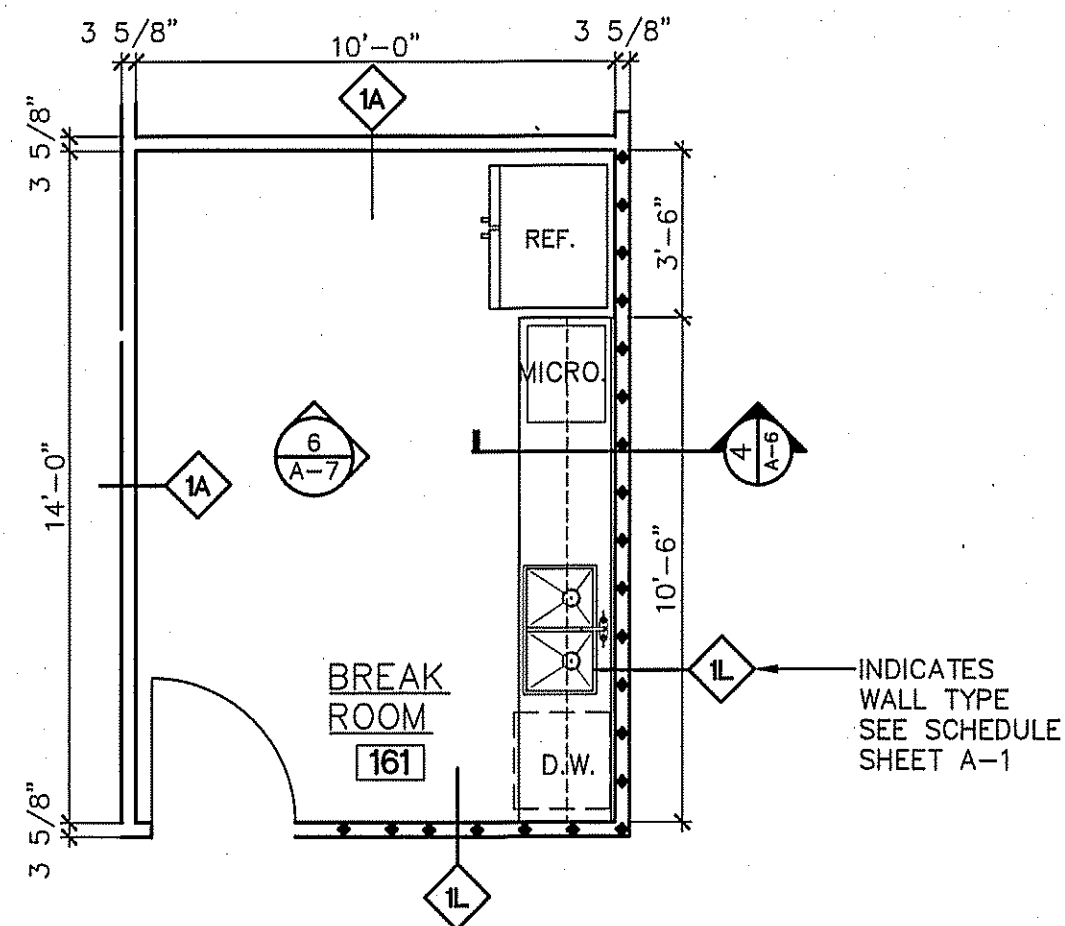




3 BREAK ROOM 161
A-6 ENLARGED PLAN
SCALE: 1/4"=1'-0"

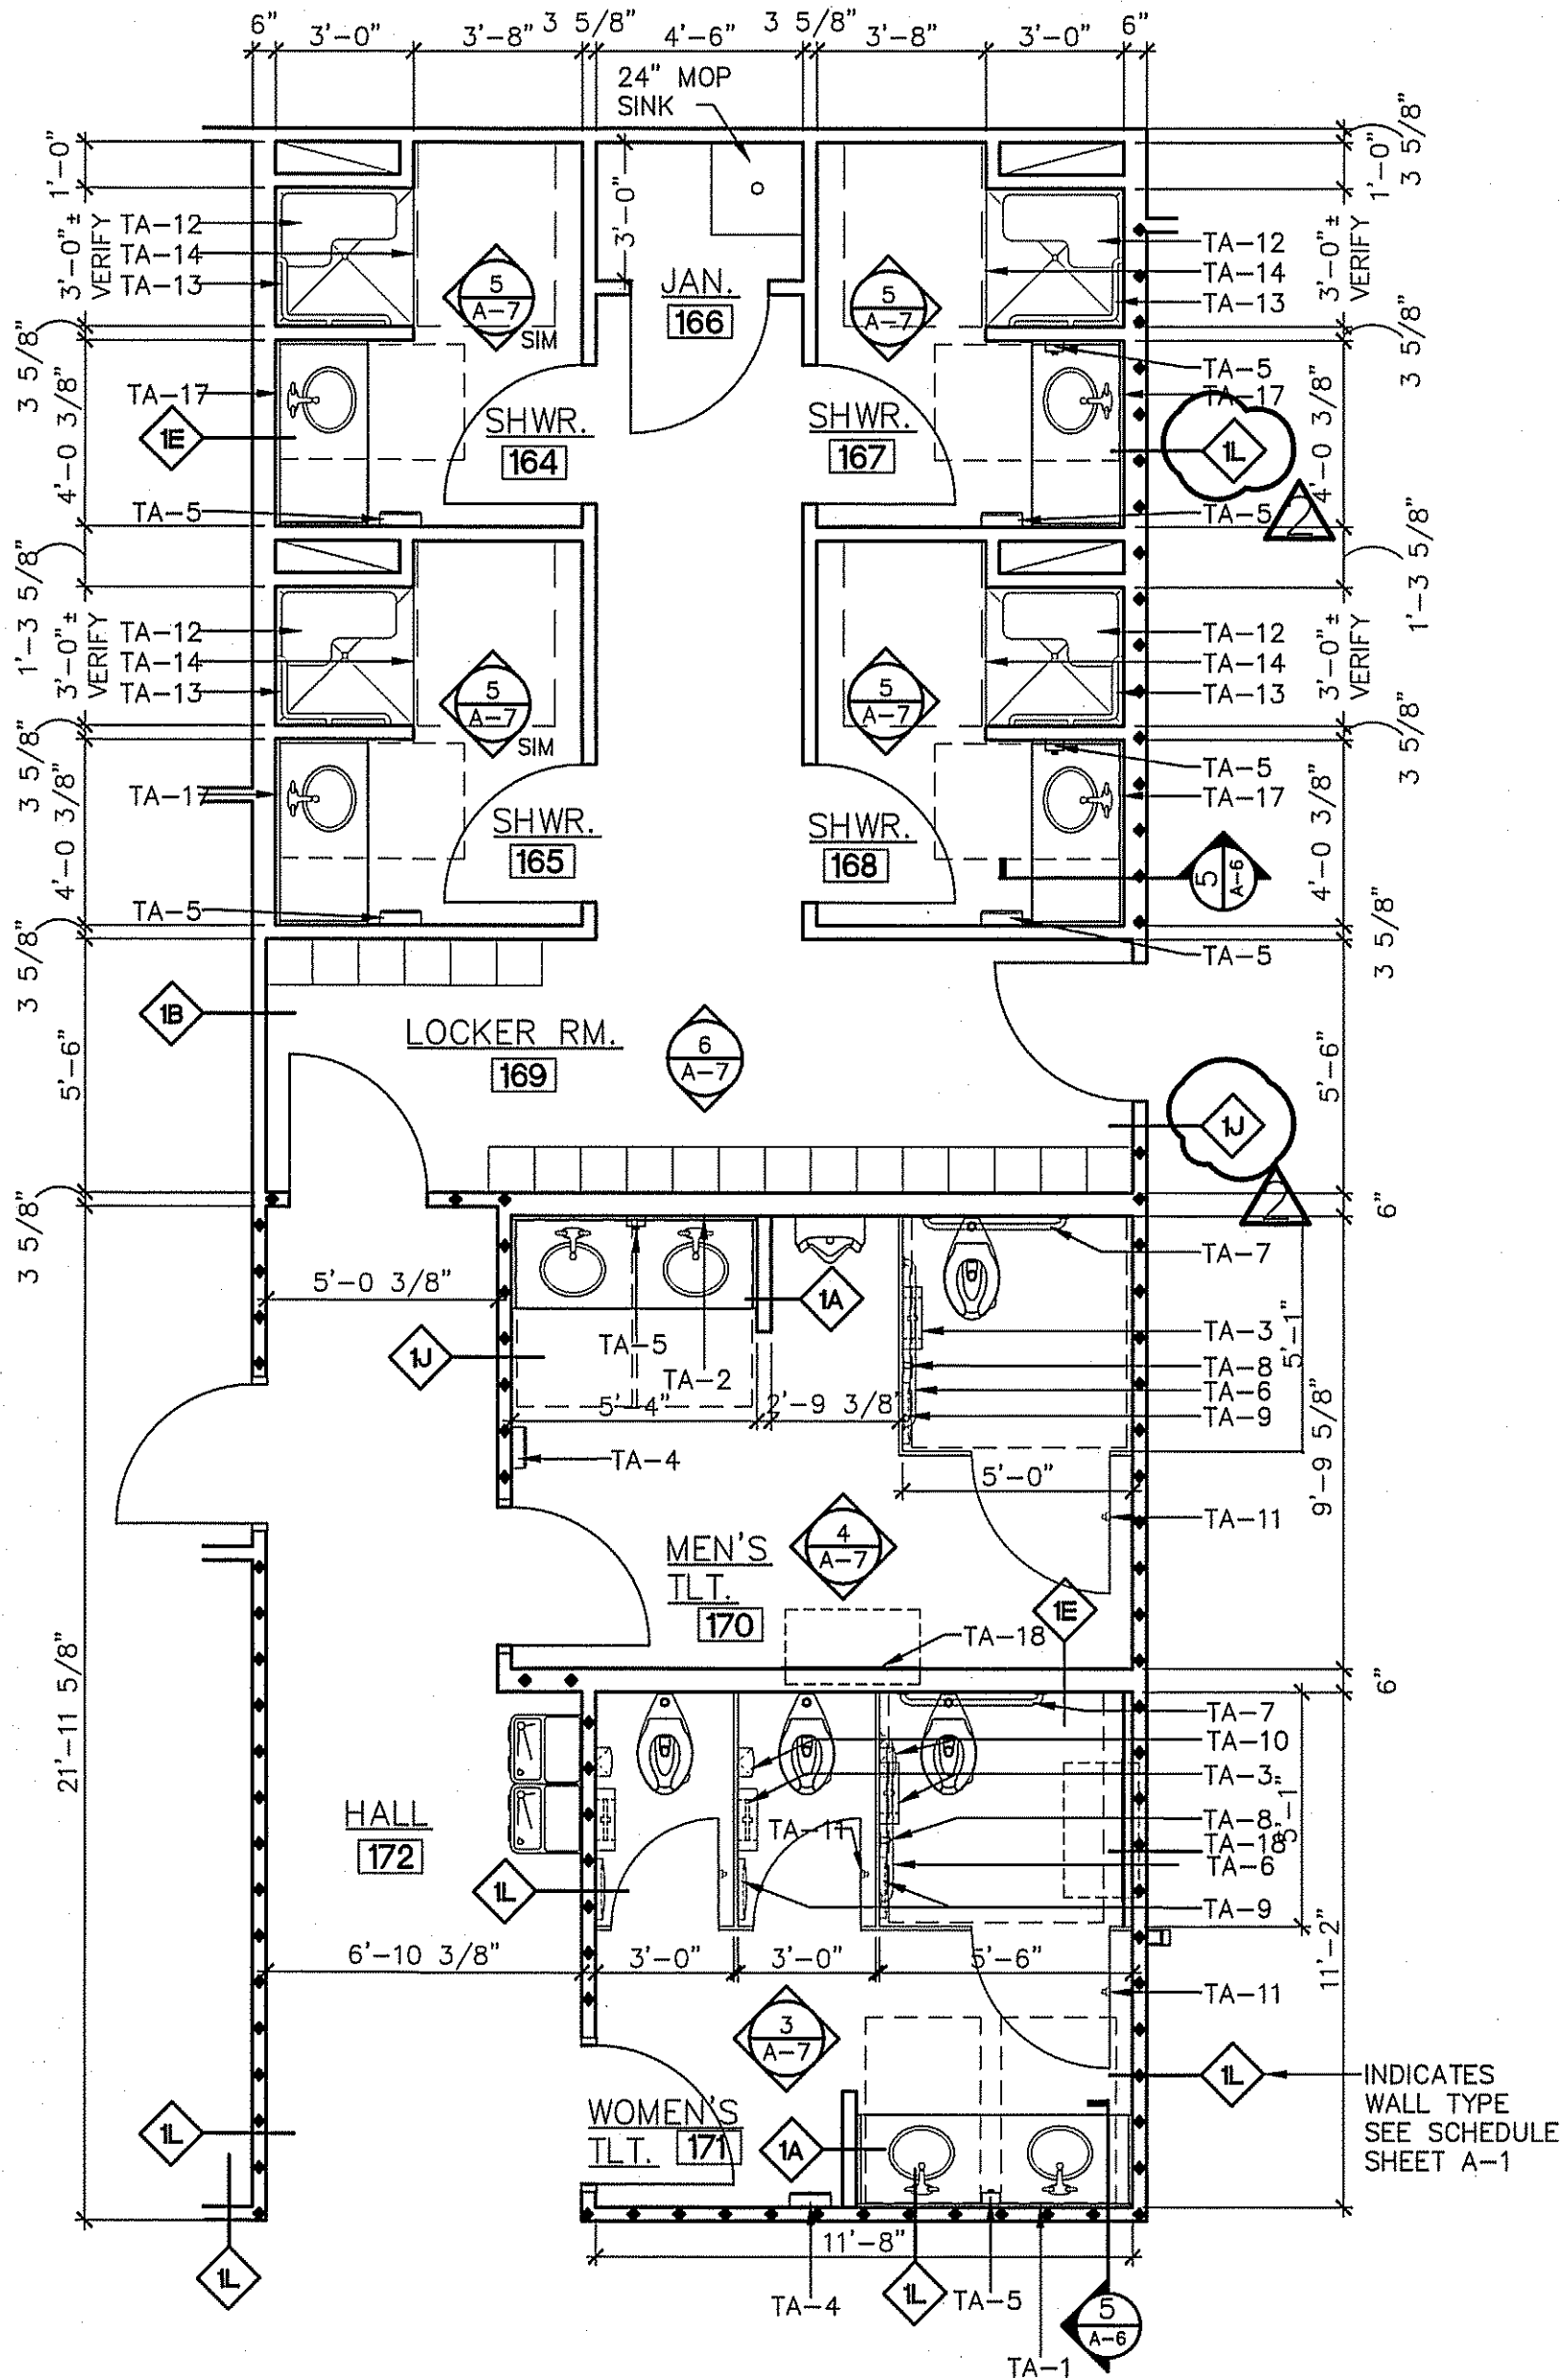





2 MEN'S TOILET 116 & WOMEN'S TOILET 117
A-6 ENLARGED PLAN
SCALE: 1/4"=1'-0"

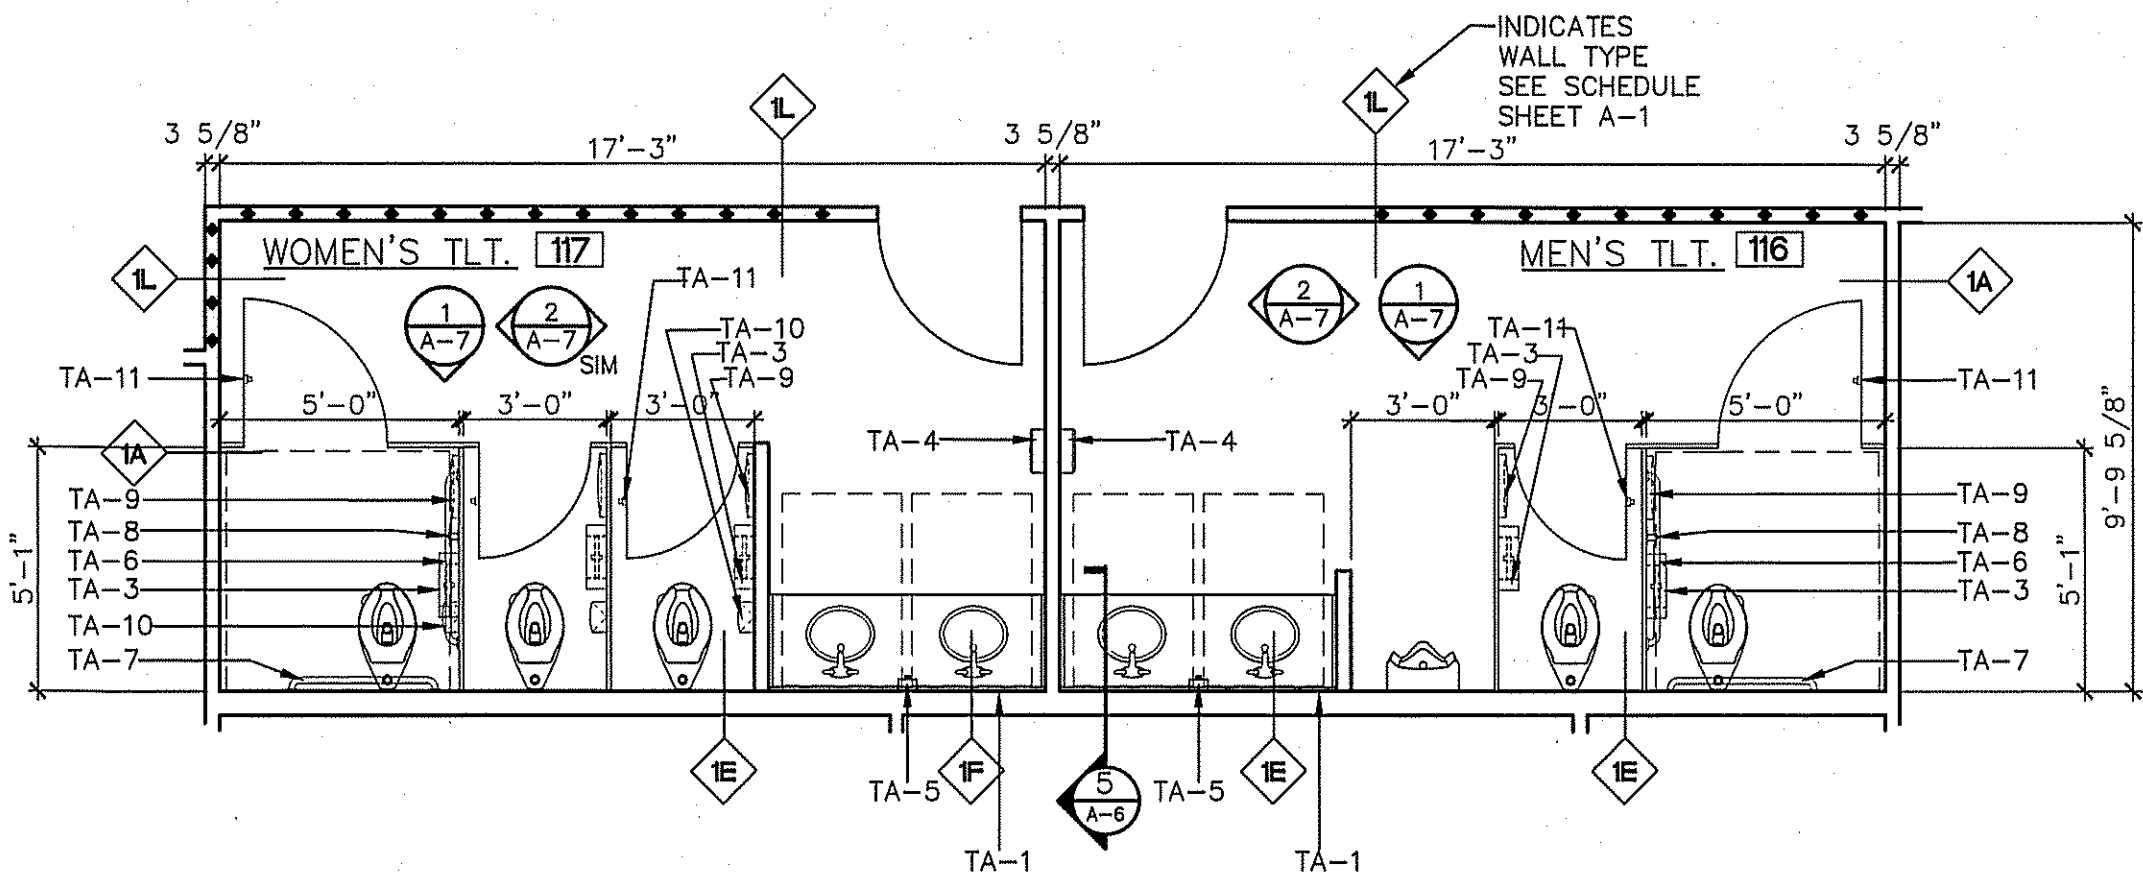


1 MEN'S TOILET 116 & WOMEN'S TOILET 117
A-6 ENLARGED PLAN
SCALE: 1/4"=1'-0"

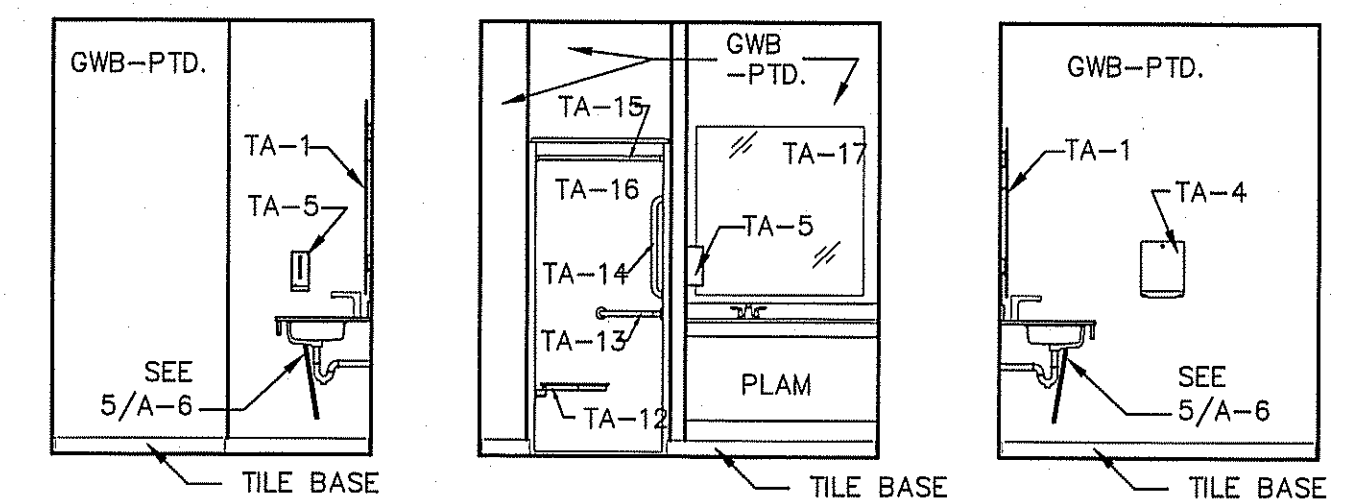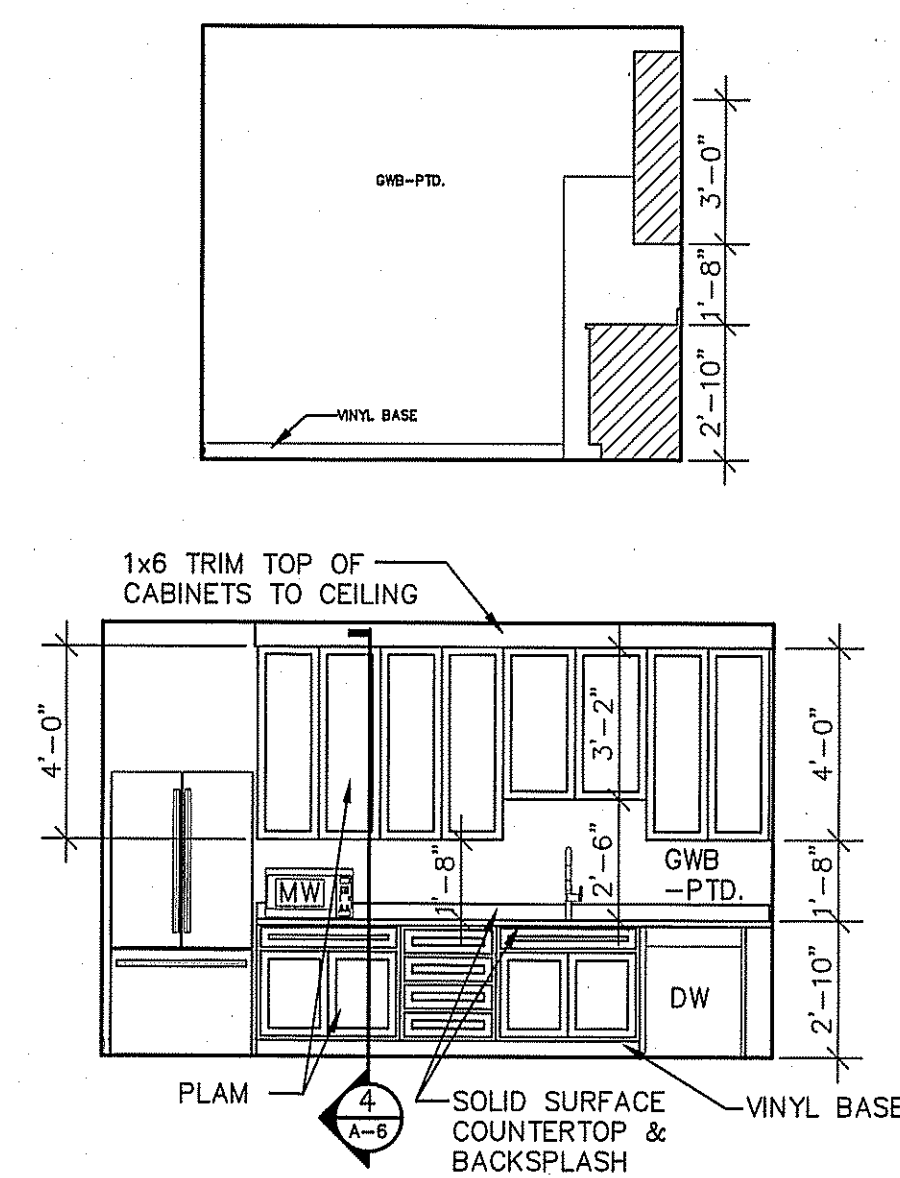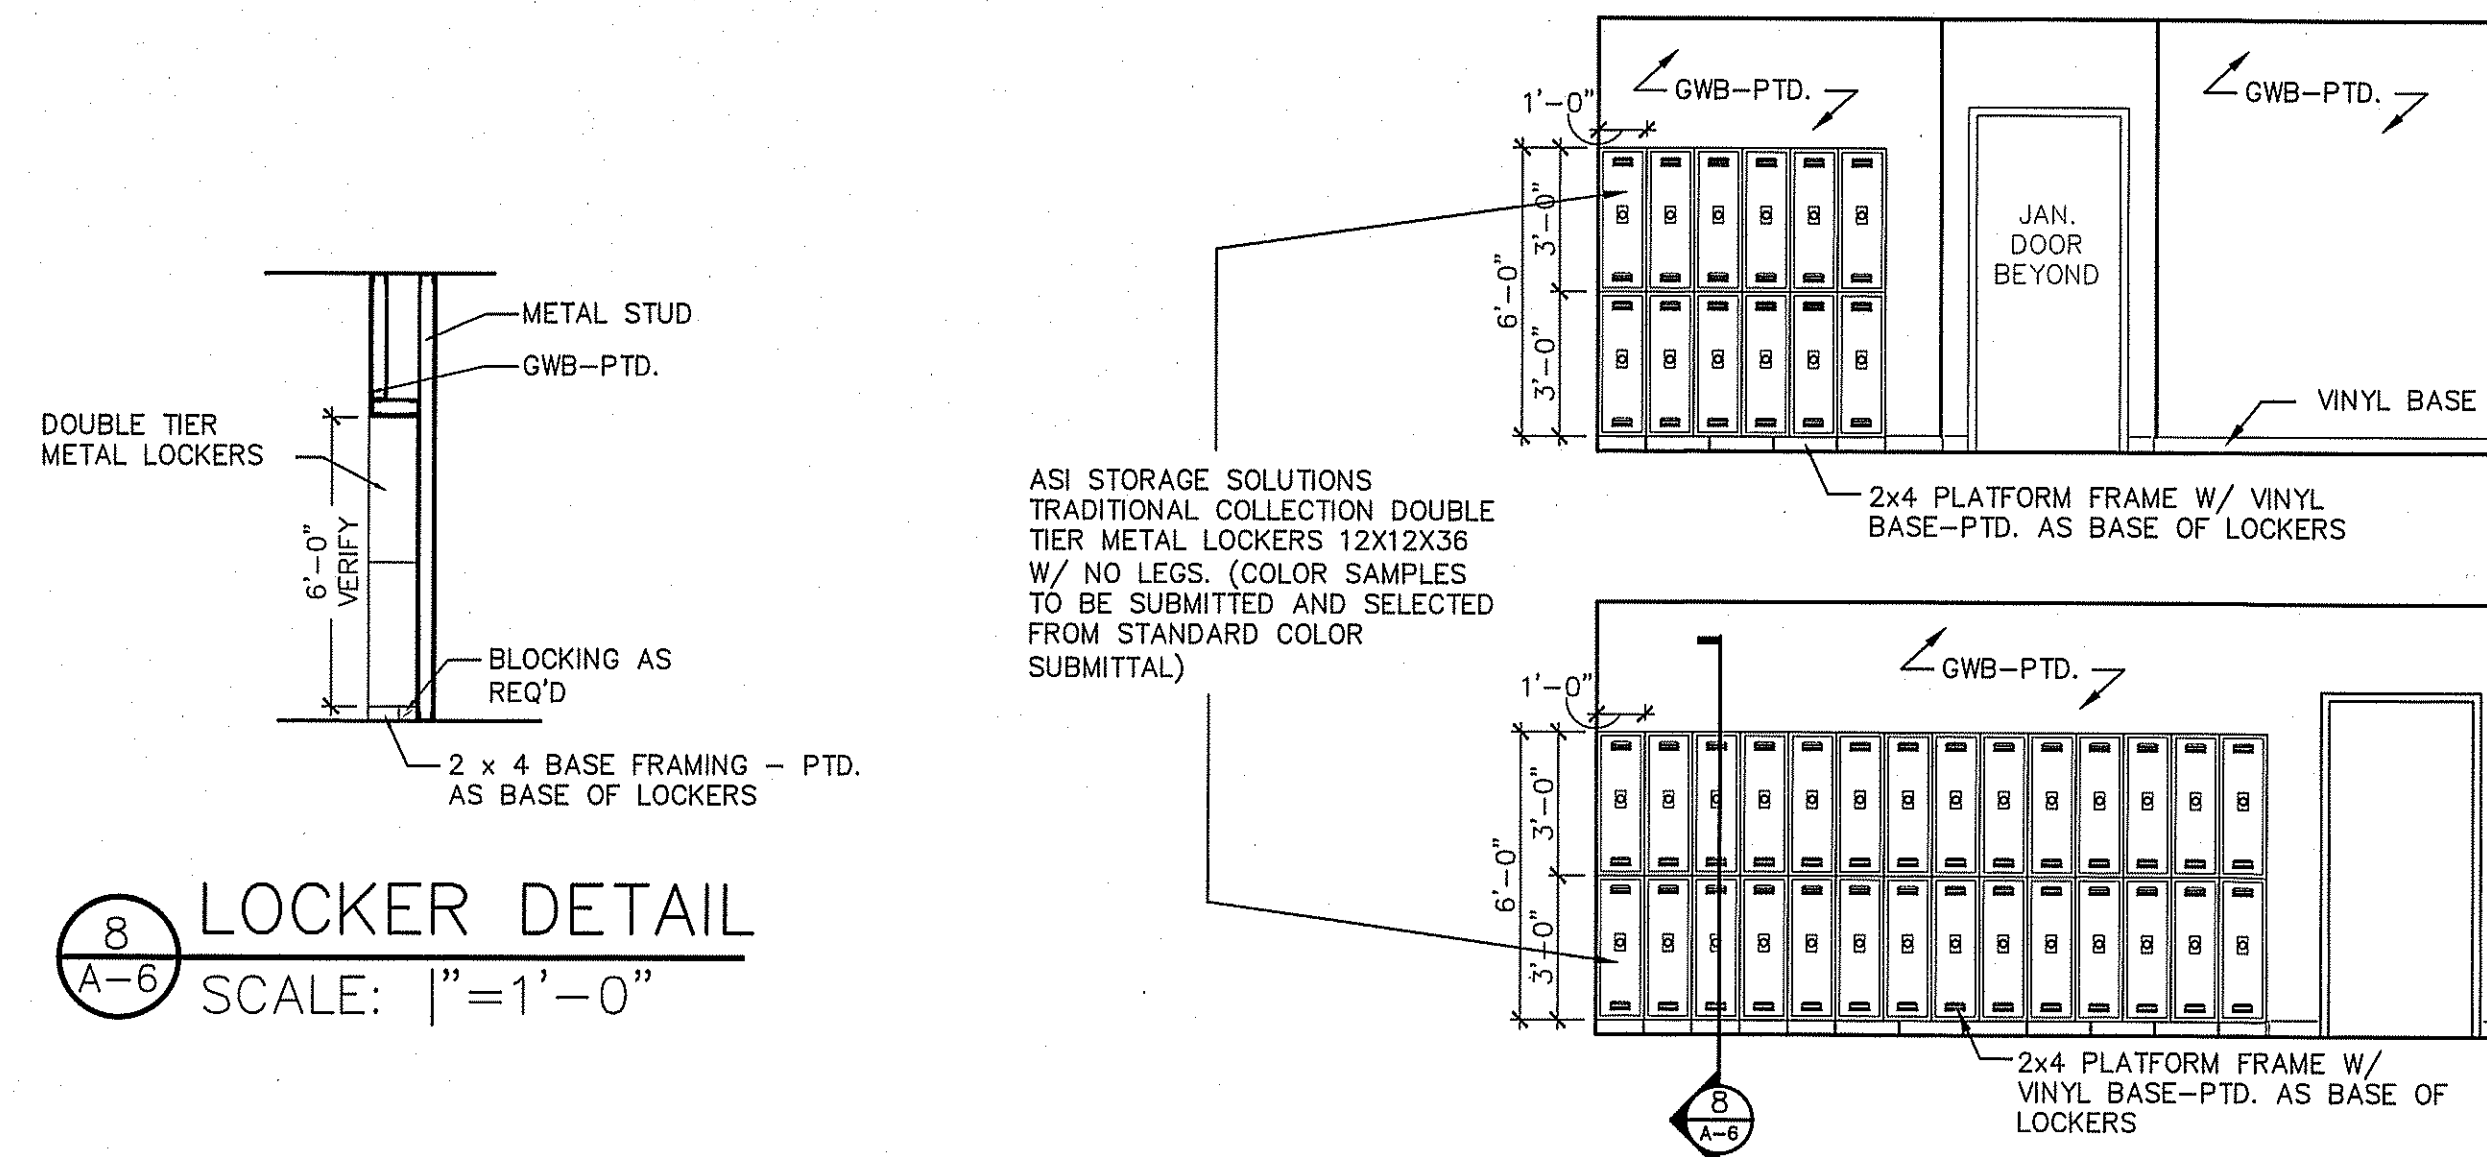


SHOWER 167 SAME
SHOWER 164 & 165
SAME, OPPOSITE HAND

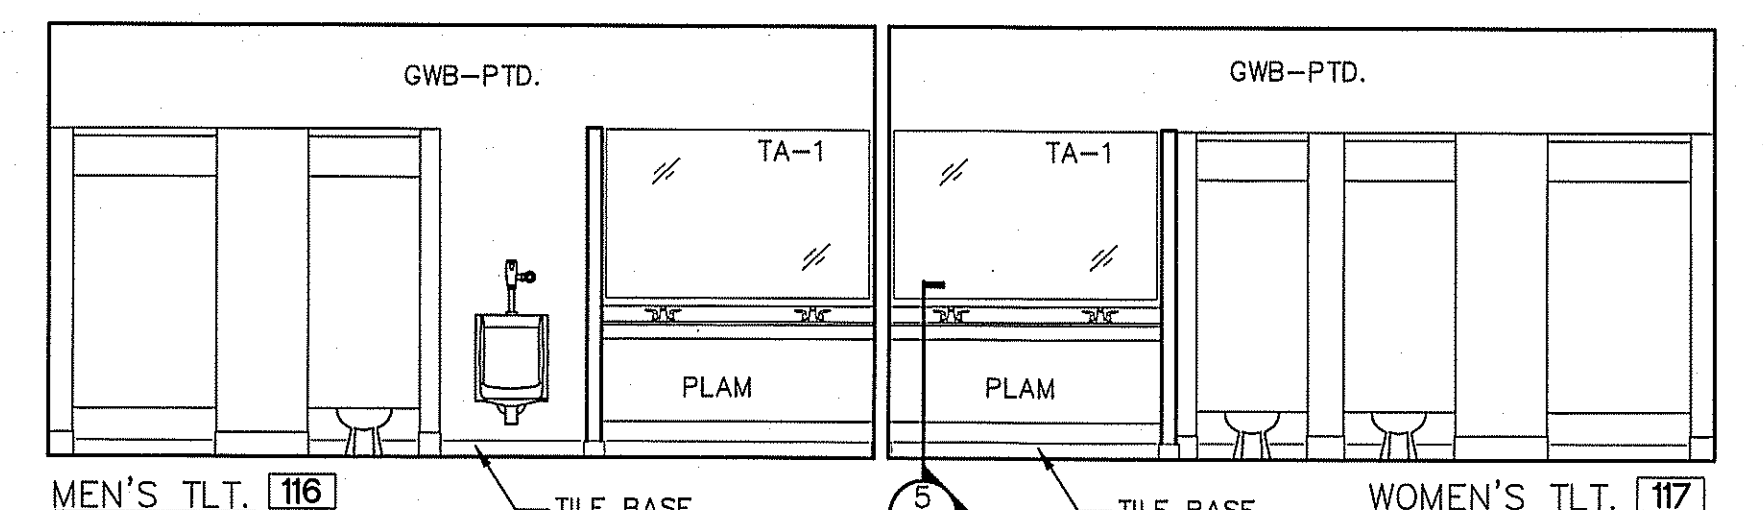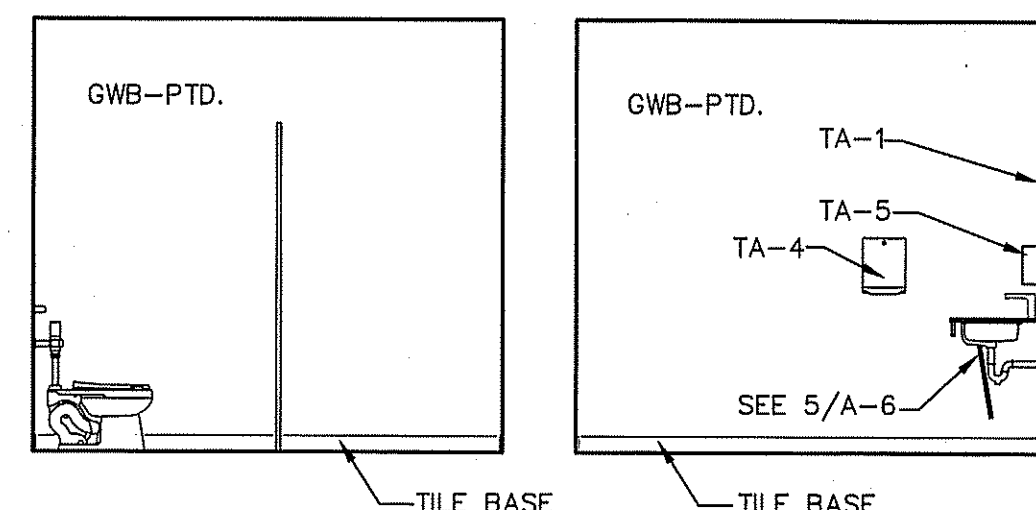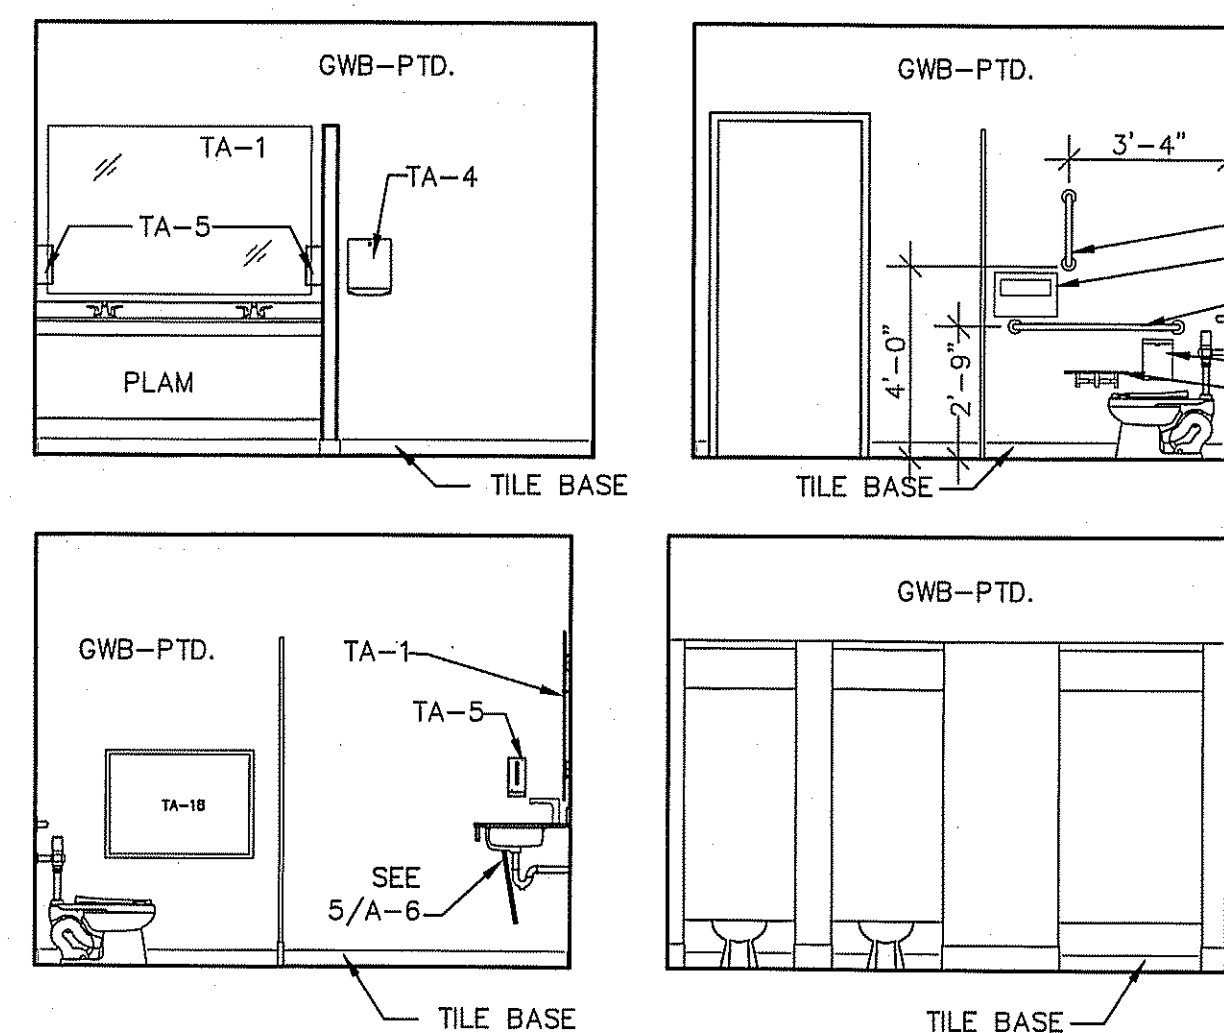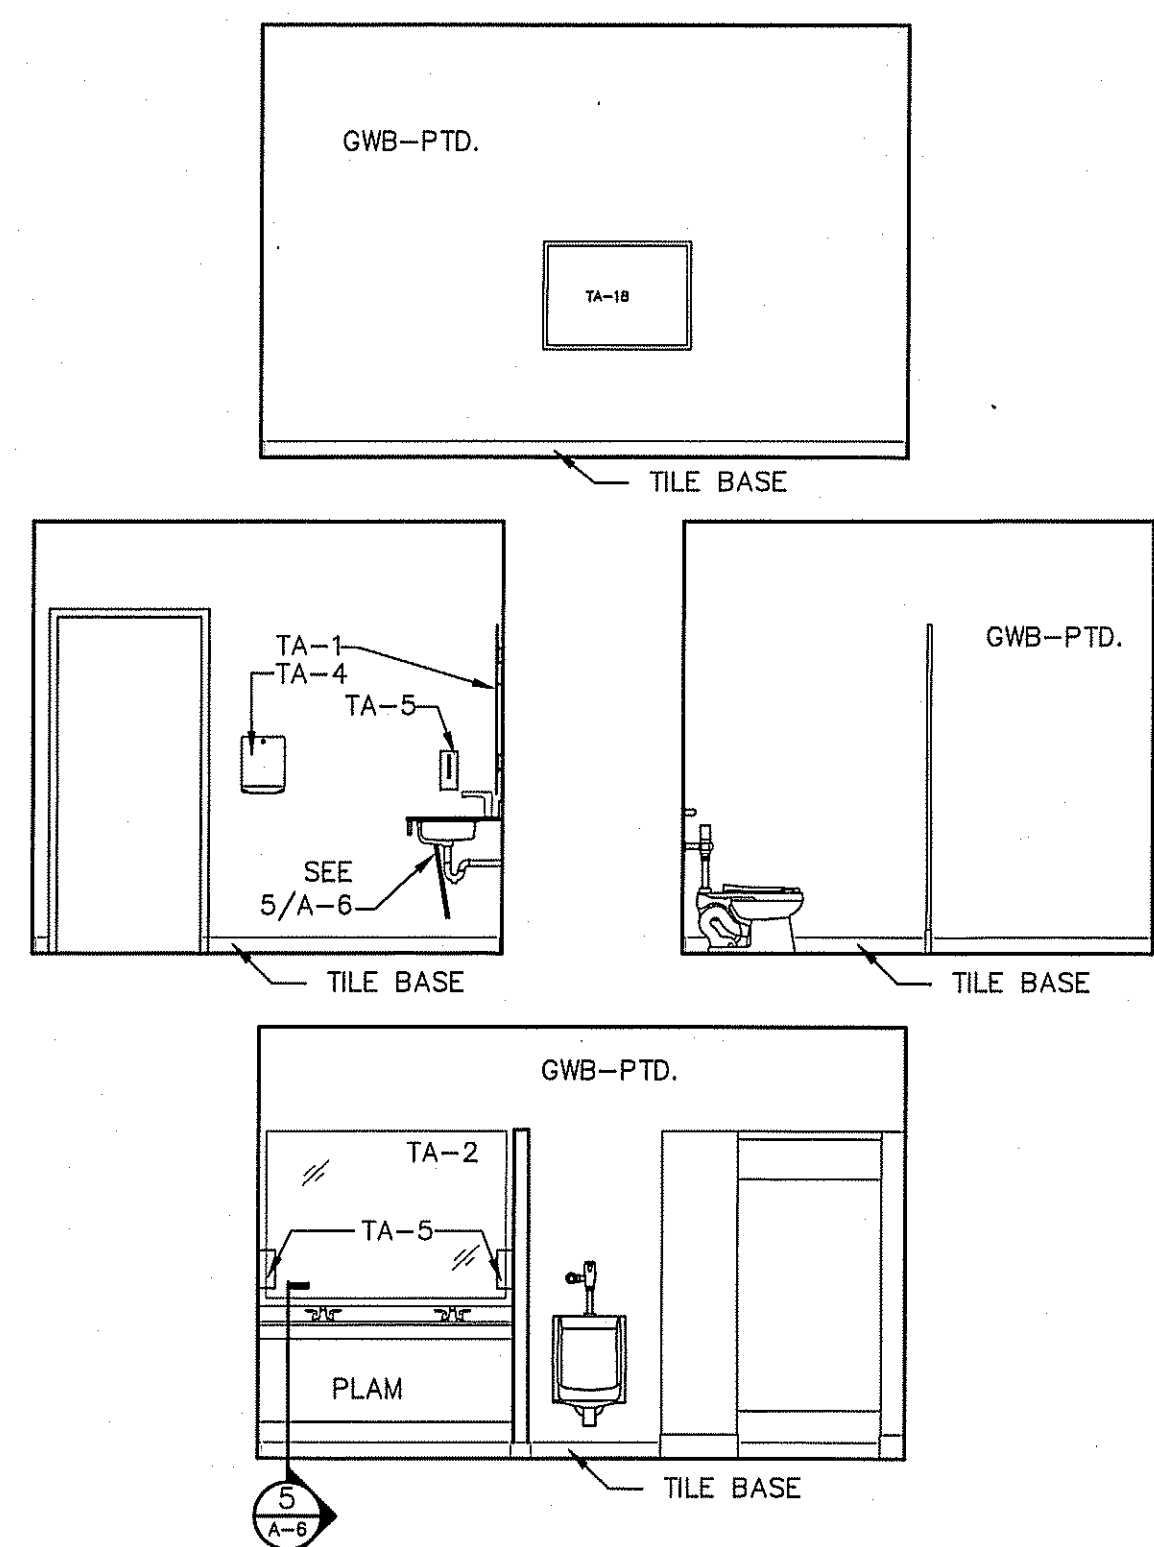


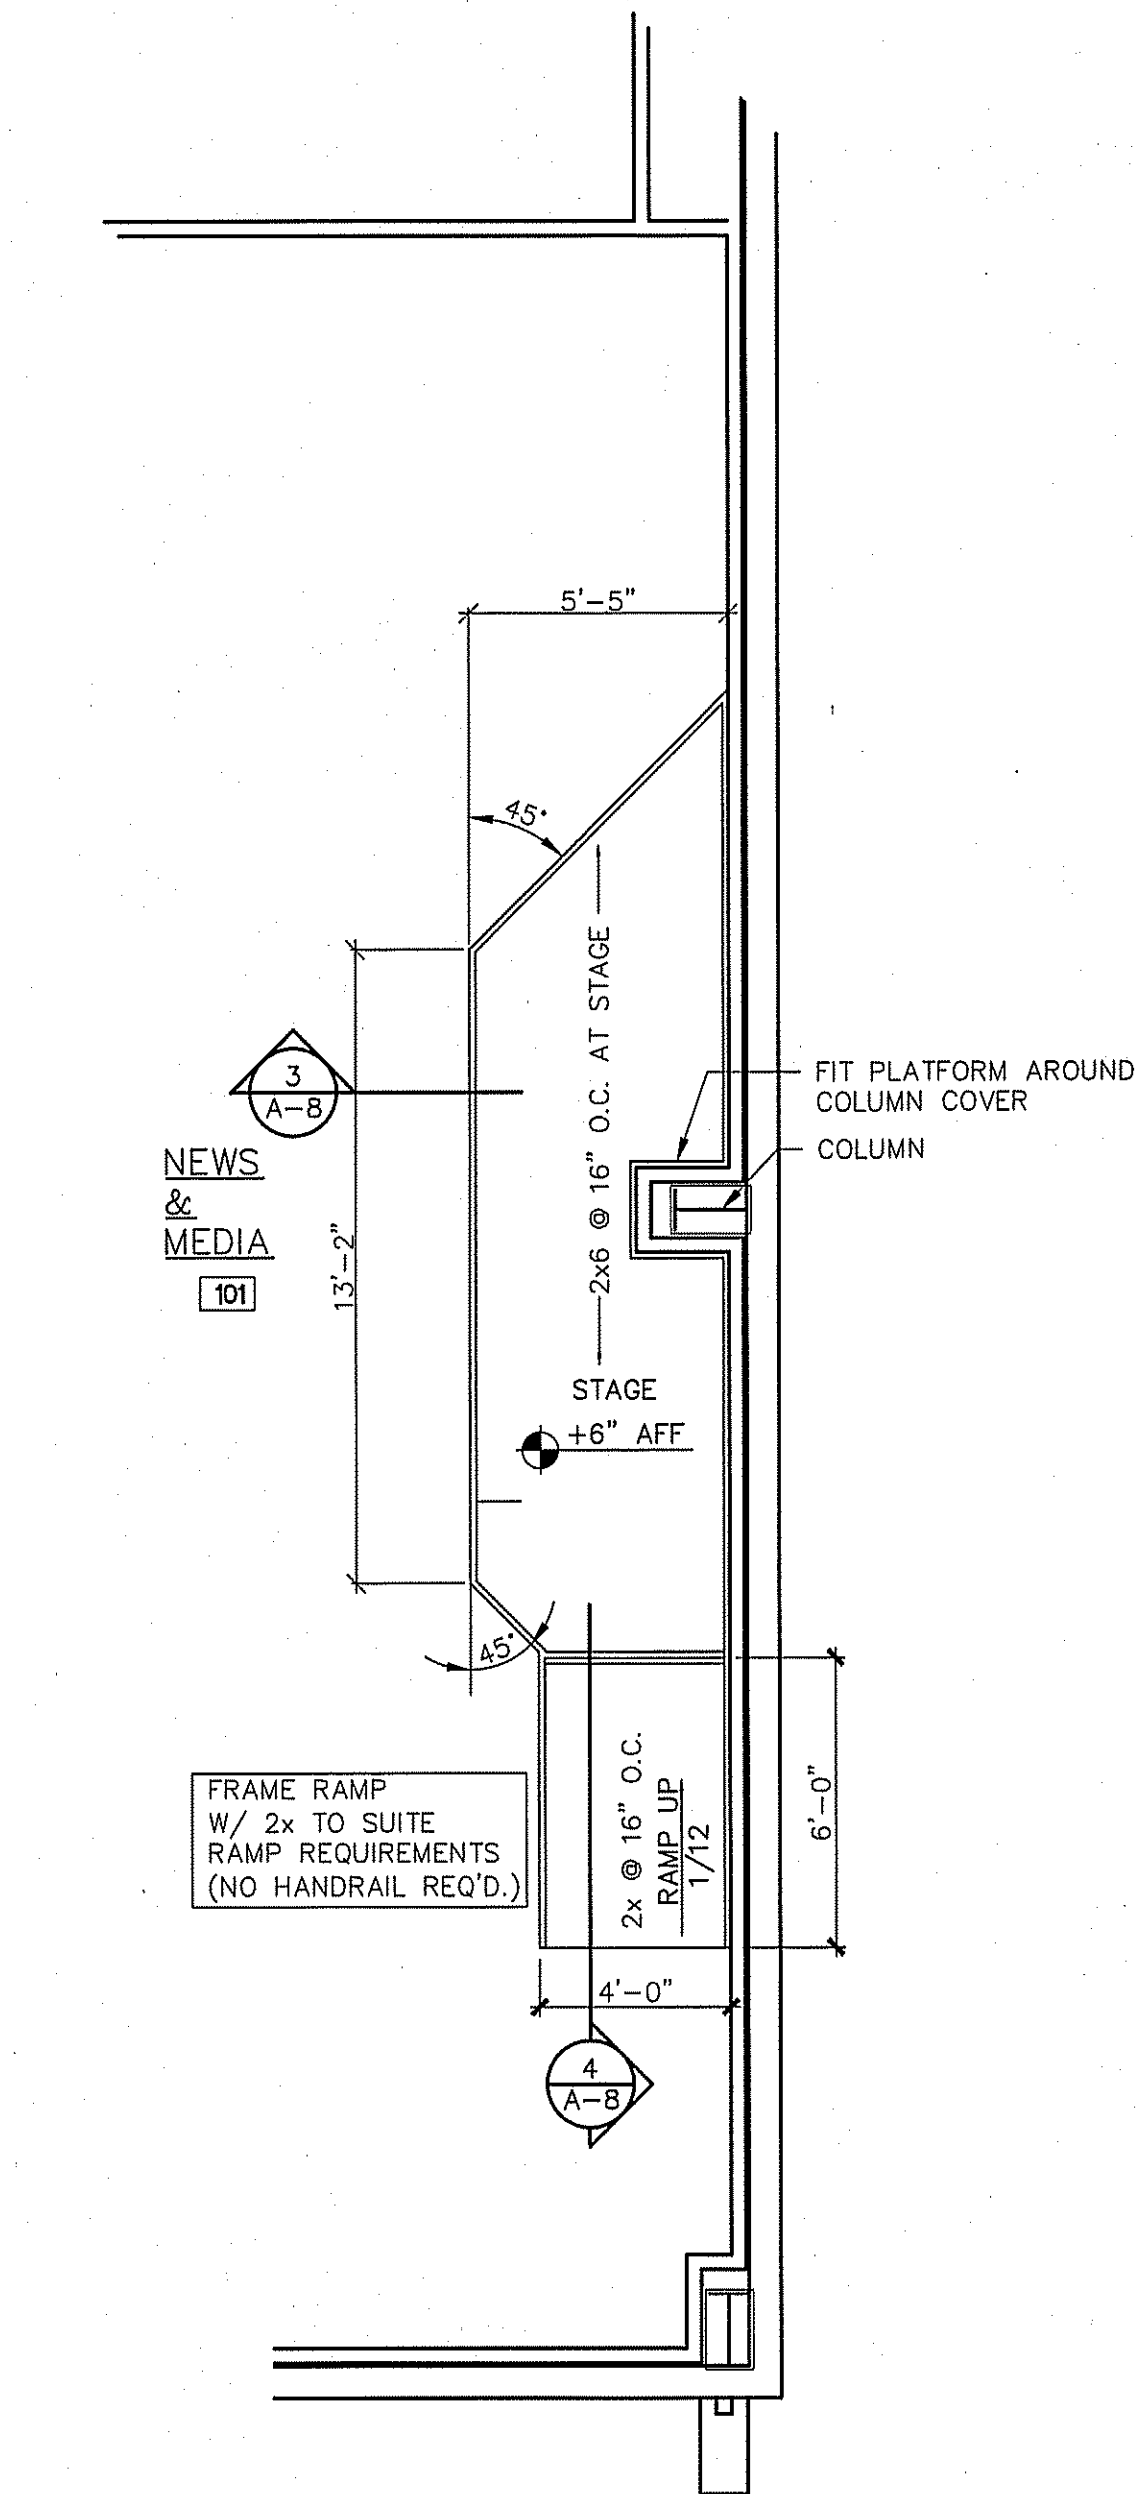


1 PLATFORM FRAMING PLAN
A-8 SCALE: 1/4"=1'-0"

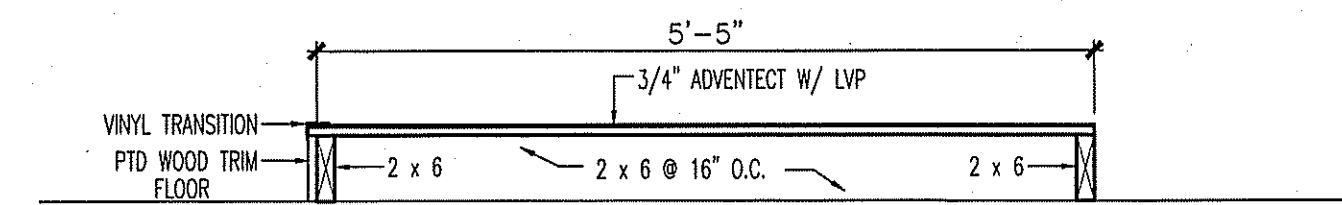


3 PLATFORM SECTION
A-8 SCALE: 3/4"=1'-0"

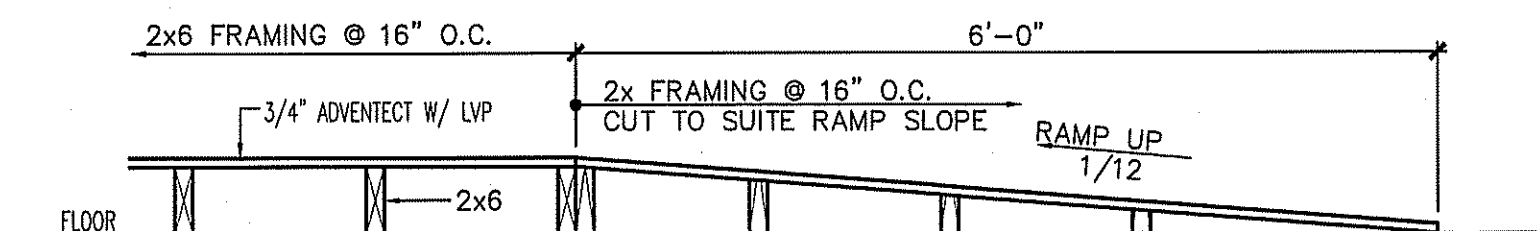


4 PLATFORM SECTION
A-8 SCALE: 3/4"=1'-0"

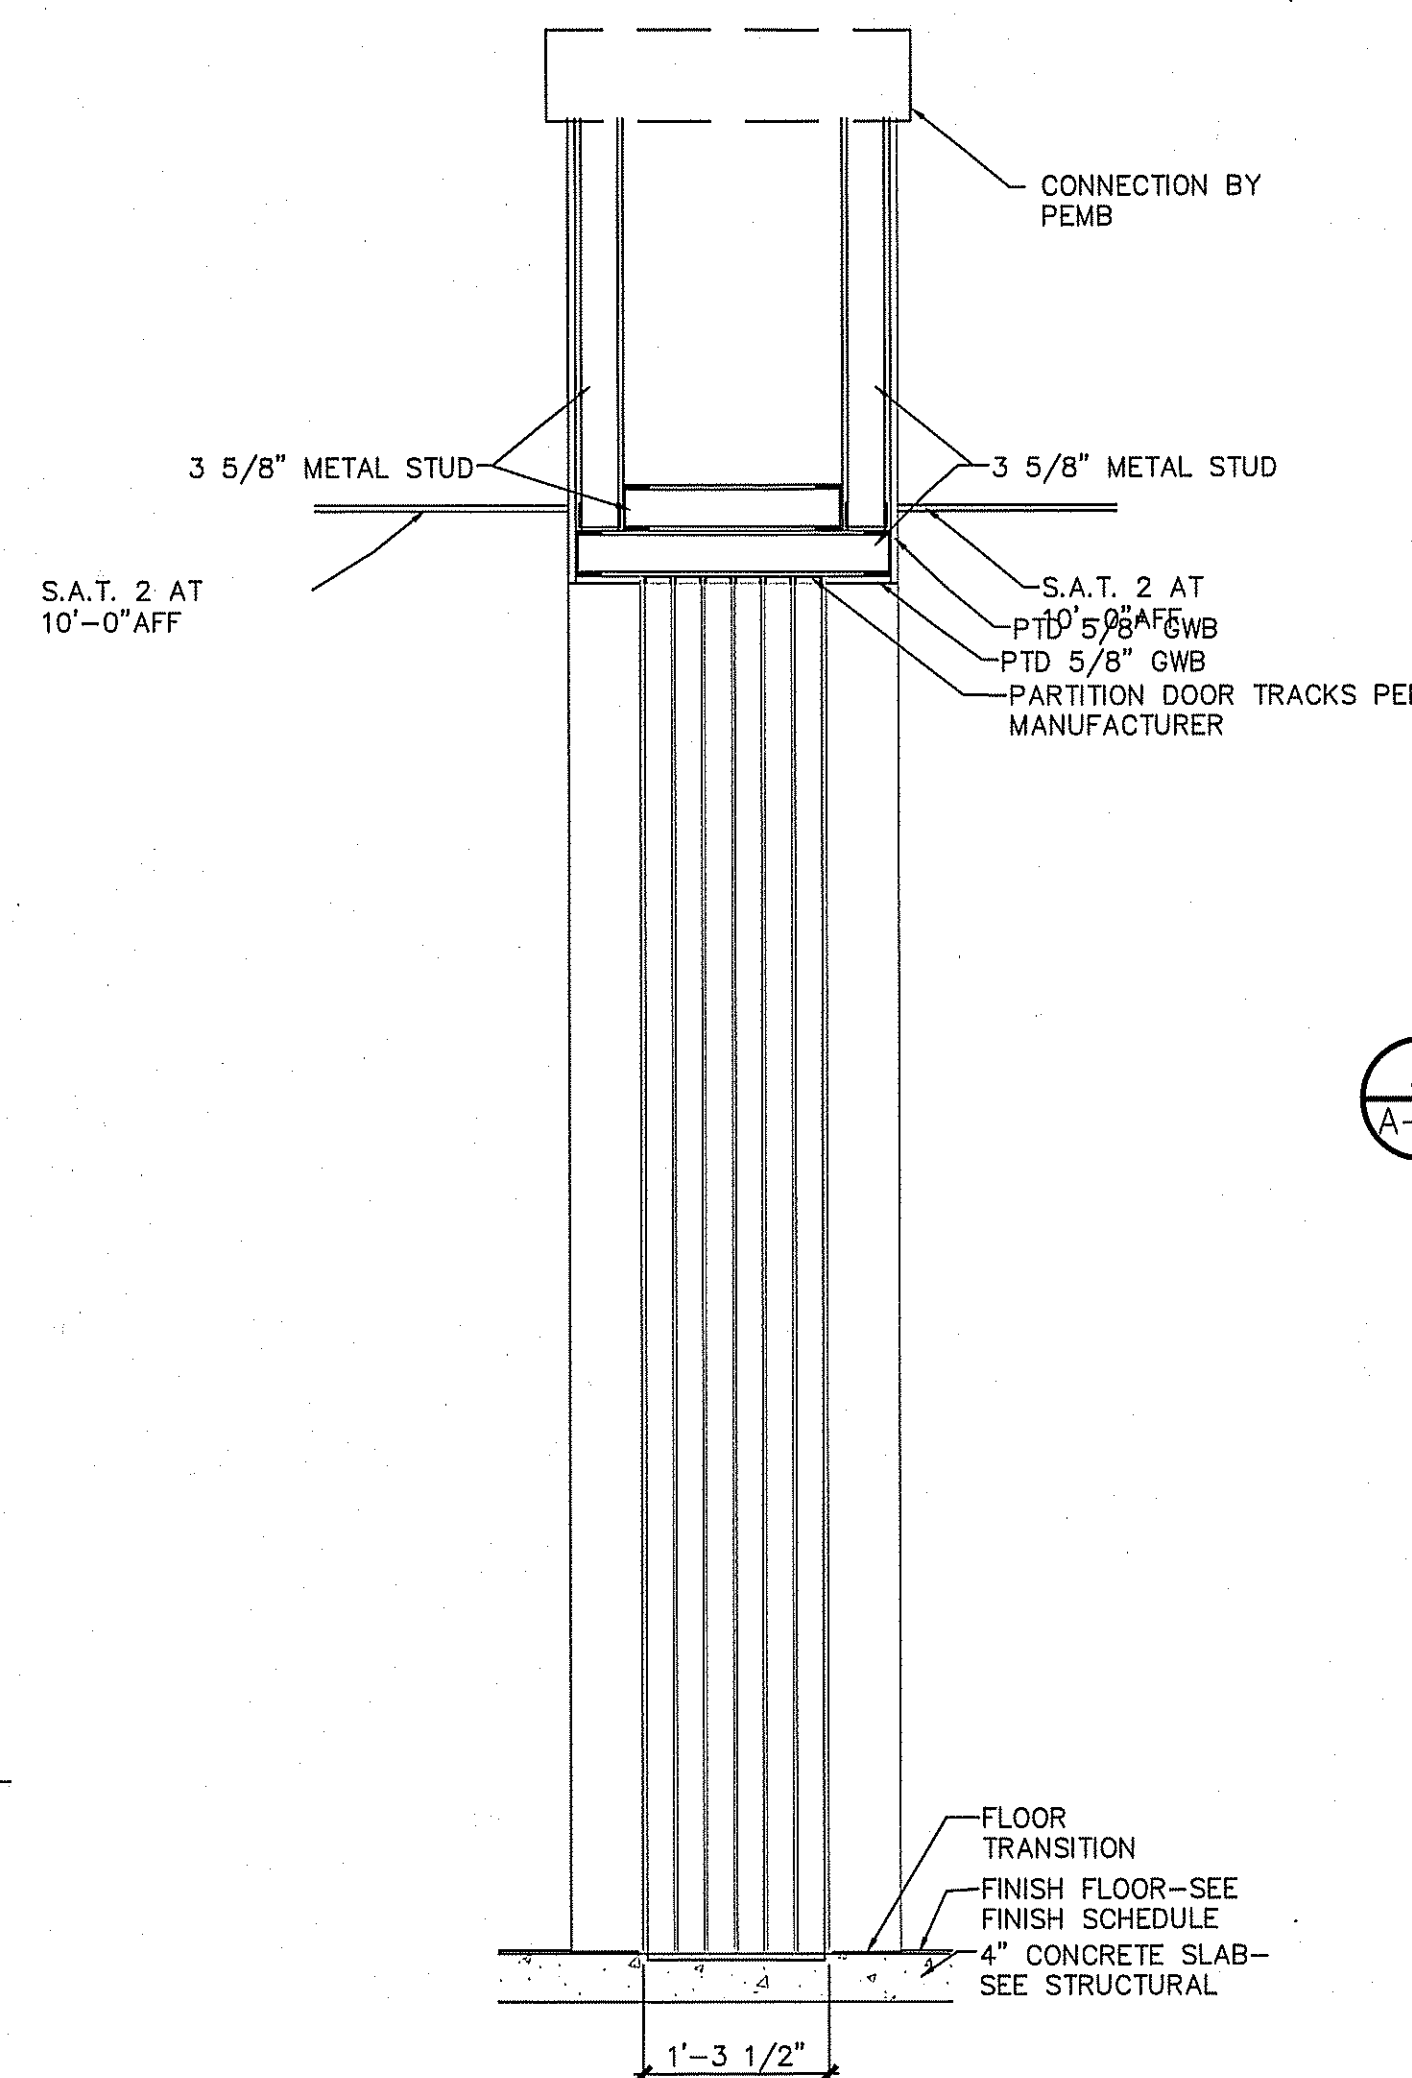


6 SOFFIT SECTION AT PARTITION
A-8 SCALE: 3/4"=1'-0"

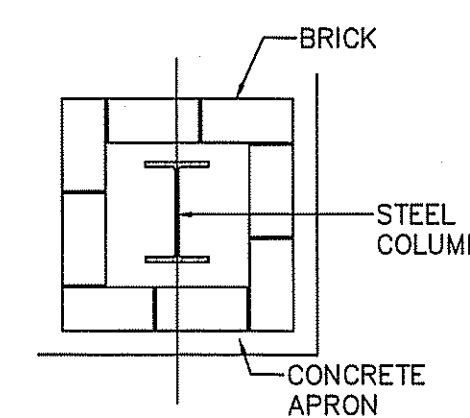

2 PORCH COLUMN
A-8 SCALE: 3/4"=1'-0"

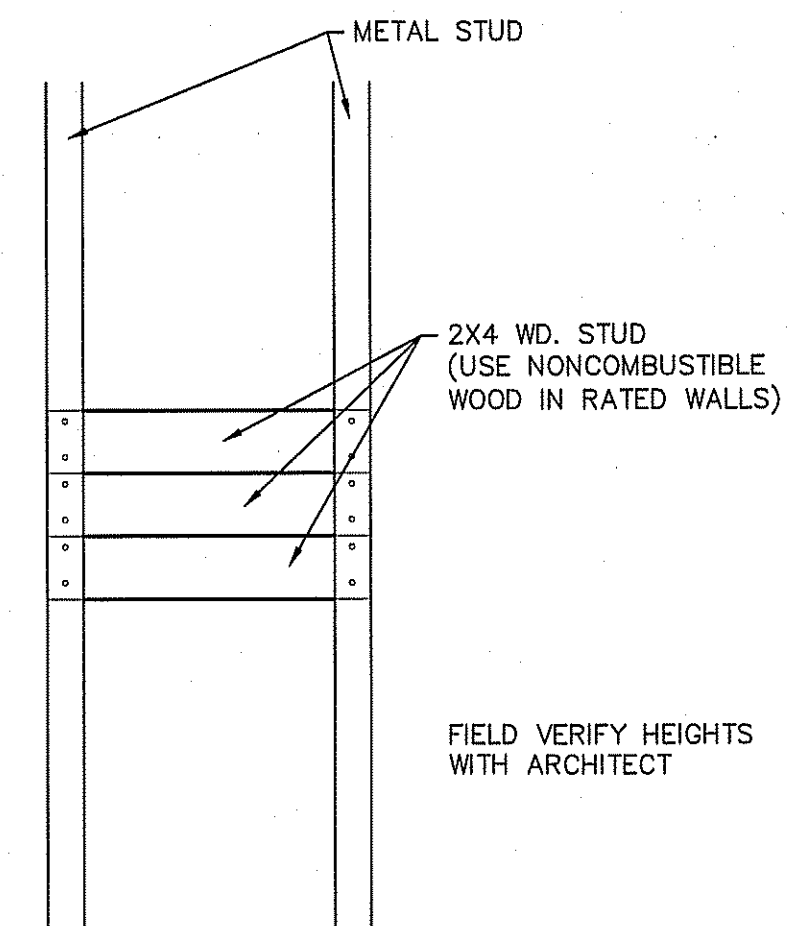

5 TV BLOCKING DETAIL
A-5 SCALE: 1"=1'-0"

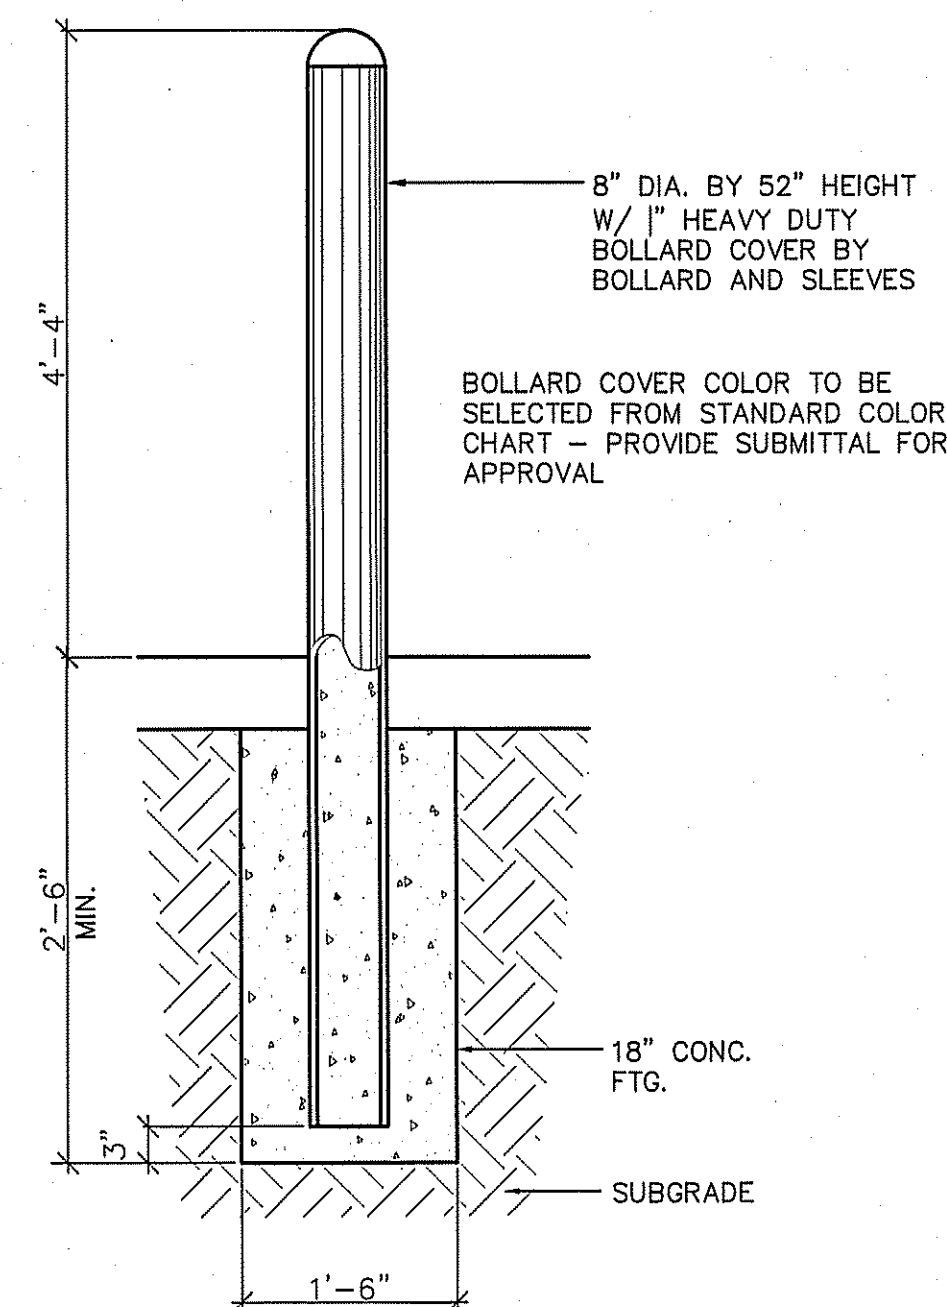

1 TYPICAL BOLLARD DETAIL
A-9 SCALE: 3/4"=1'-0"