

29 January 2025


Addendum 4

**Columbus County
Sheriff's Department
Whiteville, NC**

The following addendum shall supersede previous information and does hereby become part of the contract documents.


- See revised Sheets C-1 and C-3 clarifying the RPZ detail, water and sewer connections. Provide receptacle in hot box for heat trace, run to 20 amp spare breaker in closest electrical panel
- Increase Brick allowance from \$550/thousand to \$850/thousand (materials only)
- Clarification: Sheet FA2: in the Connecting Corridor, the RAP devices shown are Remote Annunciator Panels

End of Addendum 4

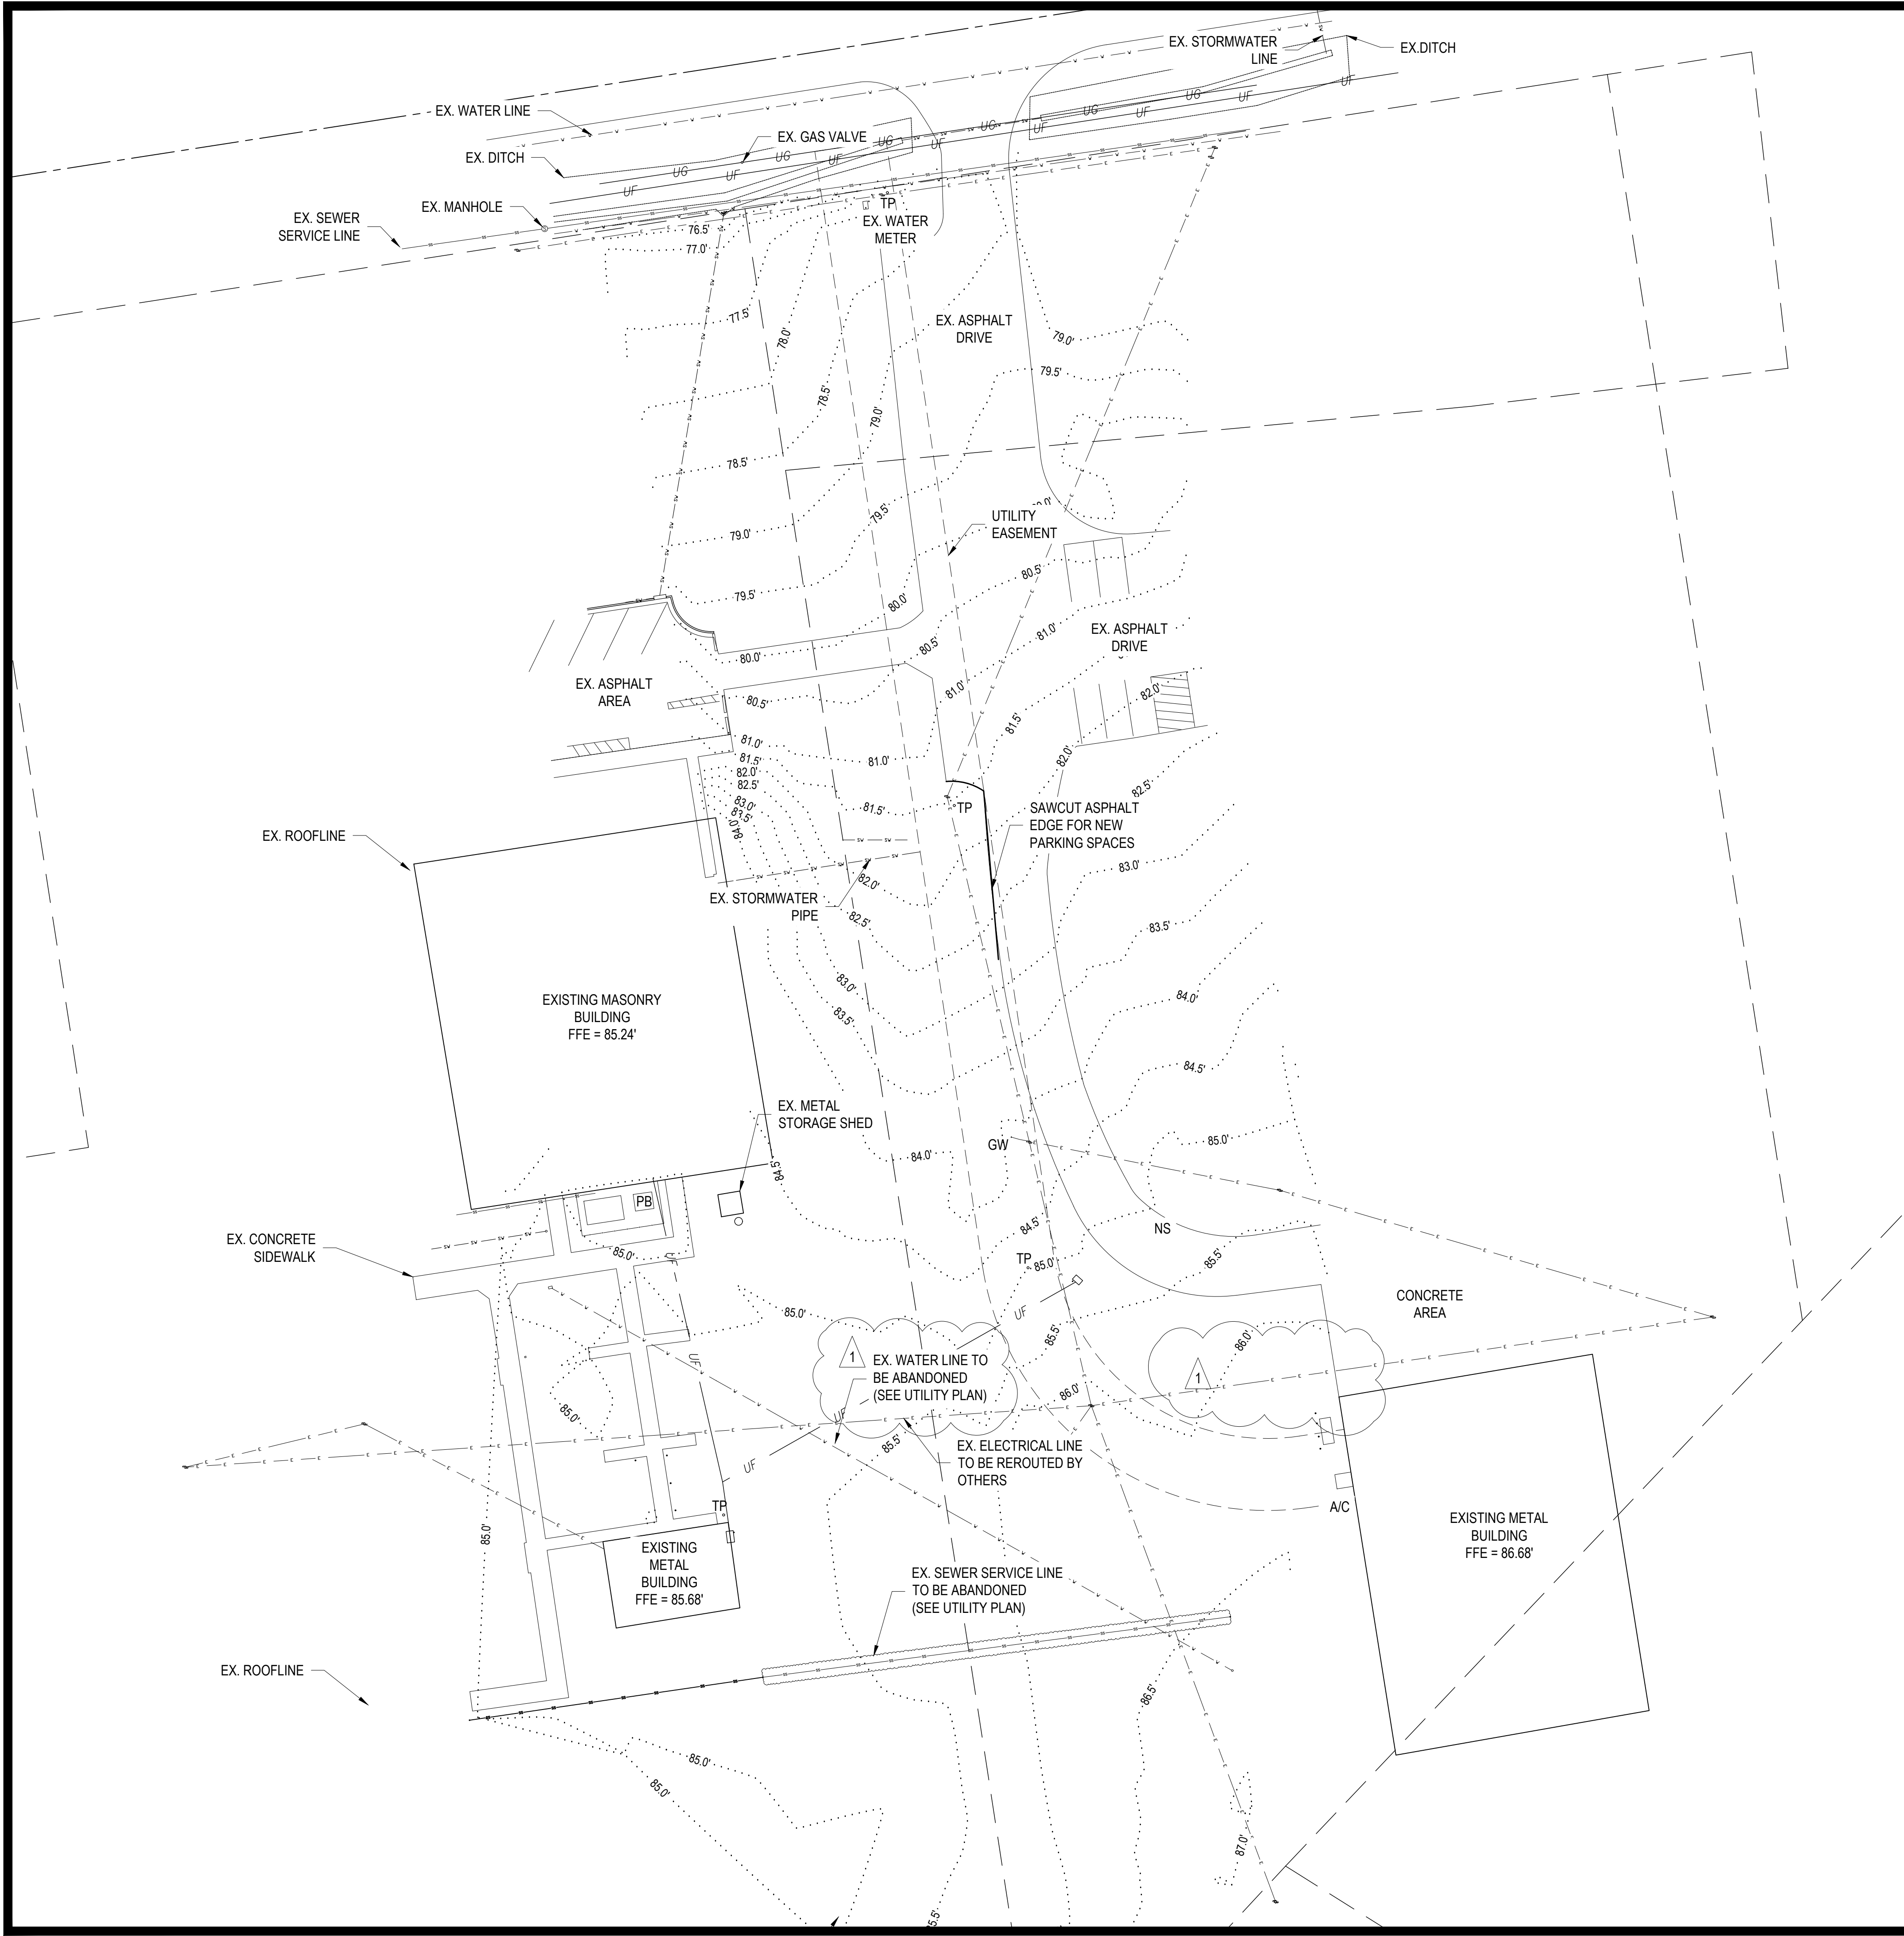

NOTES:

- BOUNDARY, TOPOGRAPHIC SURVEY PROVIDED BY SOLES & WALKER, P.A., P.L.S., DATED: 9/24/2024
- CONTRACTOR SHALL BE RESPONSIBLE FOR LOCATING ALL UTILITIES WITHIN PROJECT AREA PRIOR TO CONSTRUCTION AND PROTECTING UTILITIES AS NECESSARY.

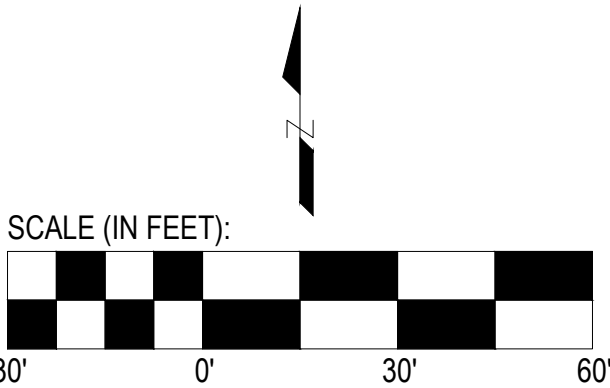

THIS DRAWING IS THE PROPERTY OF ARENDELL ENGINEERS AND IS NOT TO BE REPRODUCED OR USED FOR ANY PROJECT IN WHOLE OR IN PART WITHOUT EXPRESS WRITTEN PERMISSION.

PROJECT MANAGER:

JJW

DESIGNED:

JJW

DRAWN BY:

JST

CHECKED:

JJW

SCALE:

1" = 30'

DATE:

01/27/2025



1004 Arendell Street
Morehead City, NC 28557
(252) 622-4338
Fax: (252) 622-4505

www.arendellengineers.com

North Carolina Certification No. C-1509

OWNER:

COLUMBUS COUNTY


PROJECT:

SHERIFF'S OFFICE
817 WASHINGTON STREET
WHITEVILLE, NORTH CAROLINA 28472

COLUMBUS COUNTY, NC

DRAWING:

EXISTING CONDITIONS AND
DEMOLITION PLAN

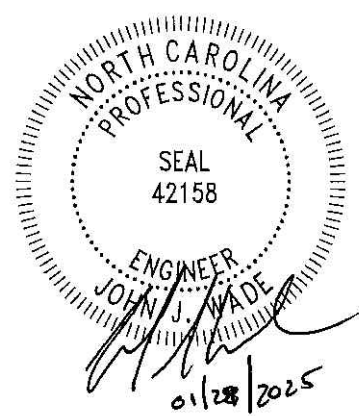

NO.	REVISION	BY	DATE
1	WATERLINE REVISIONS	JJW	01/29/25



SHEET NO:

C1
VOID


OF: 8

JOB NO.


24265

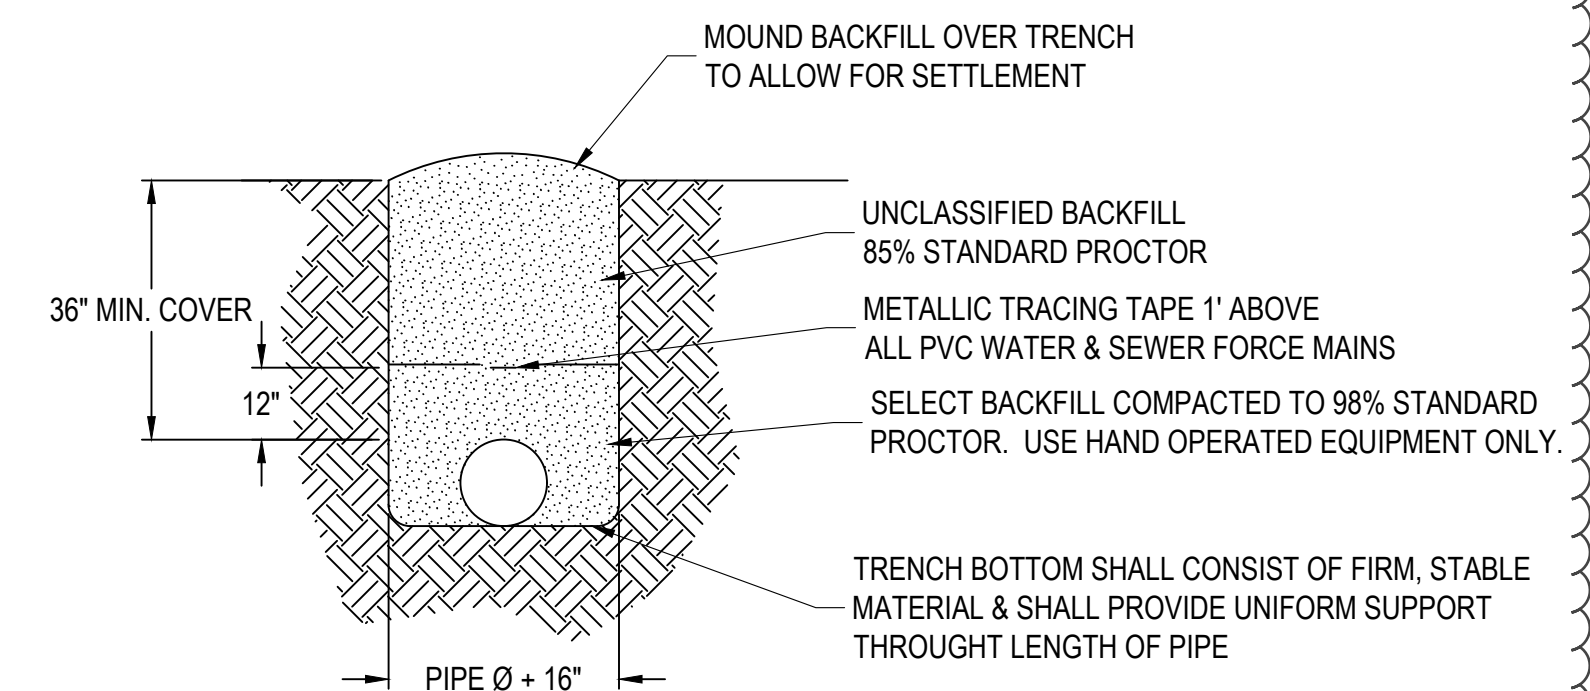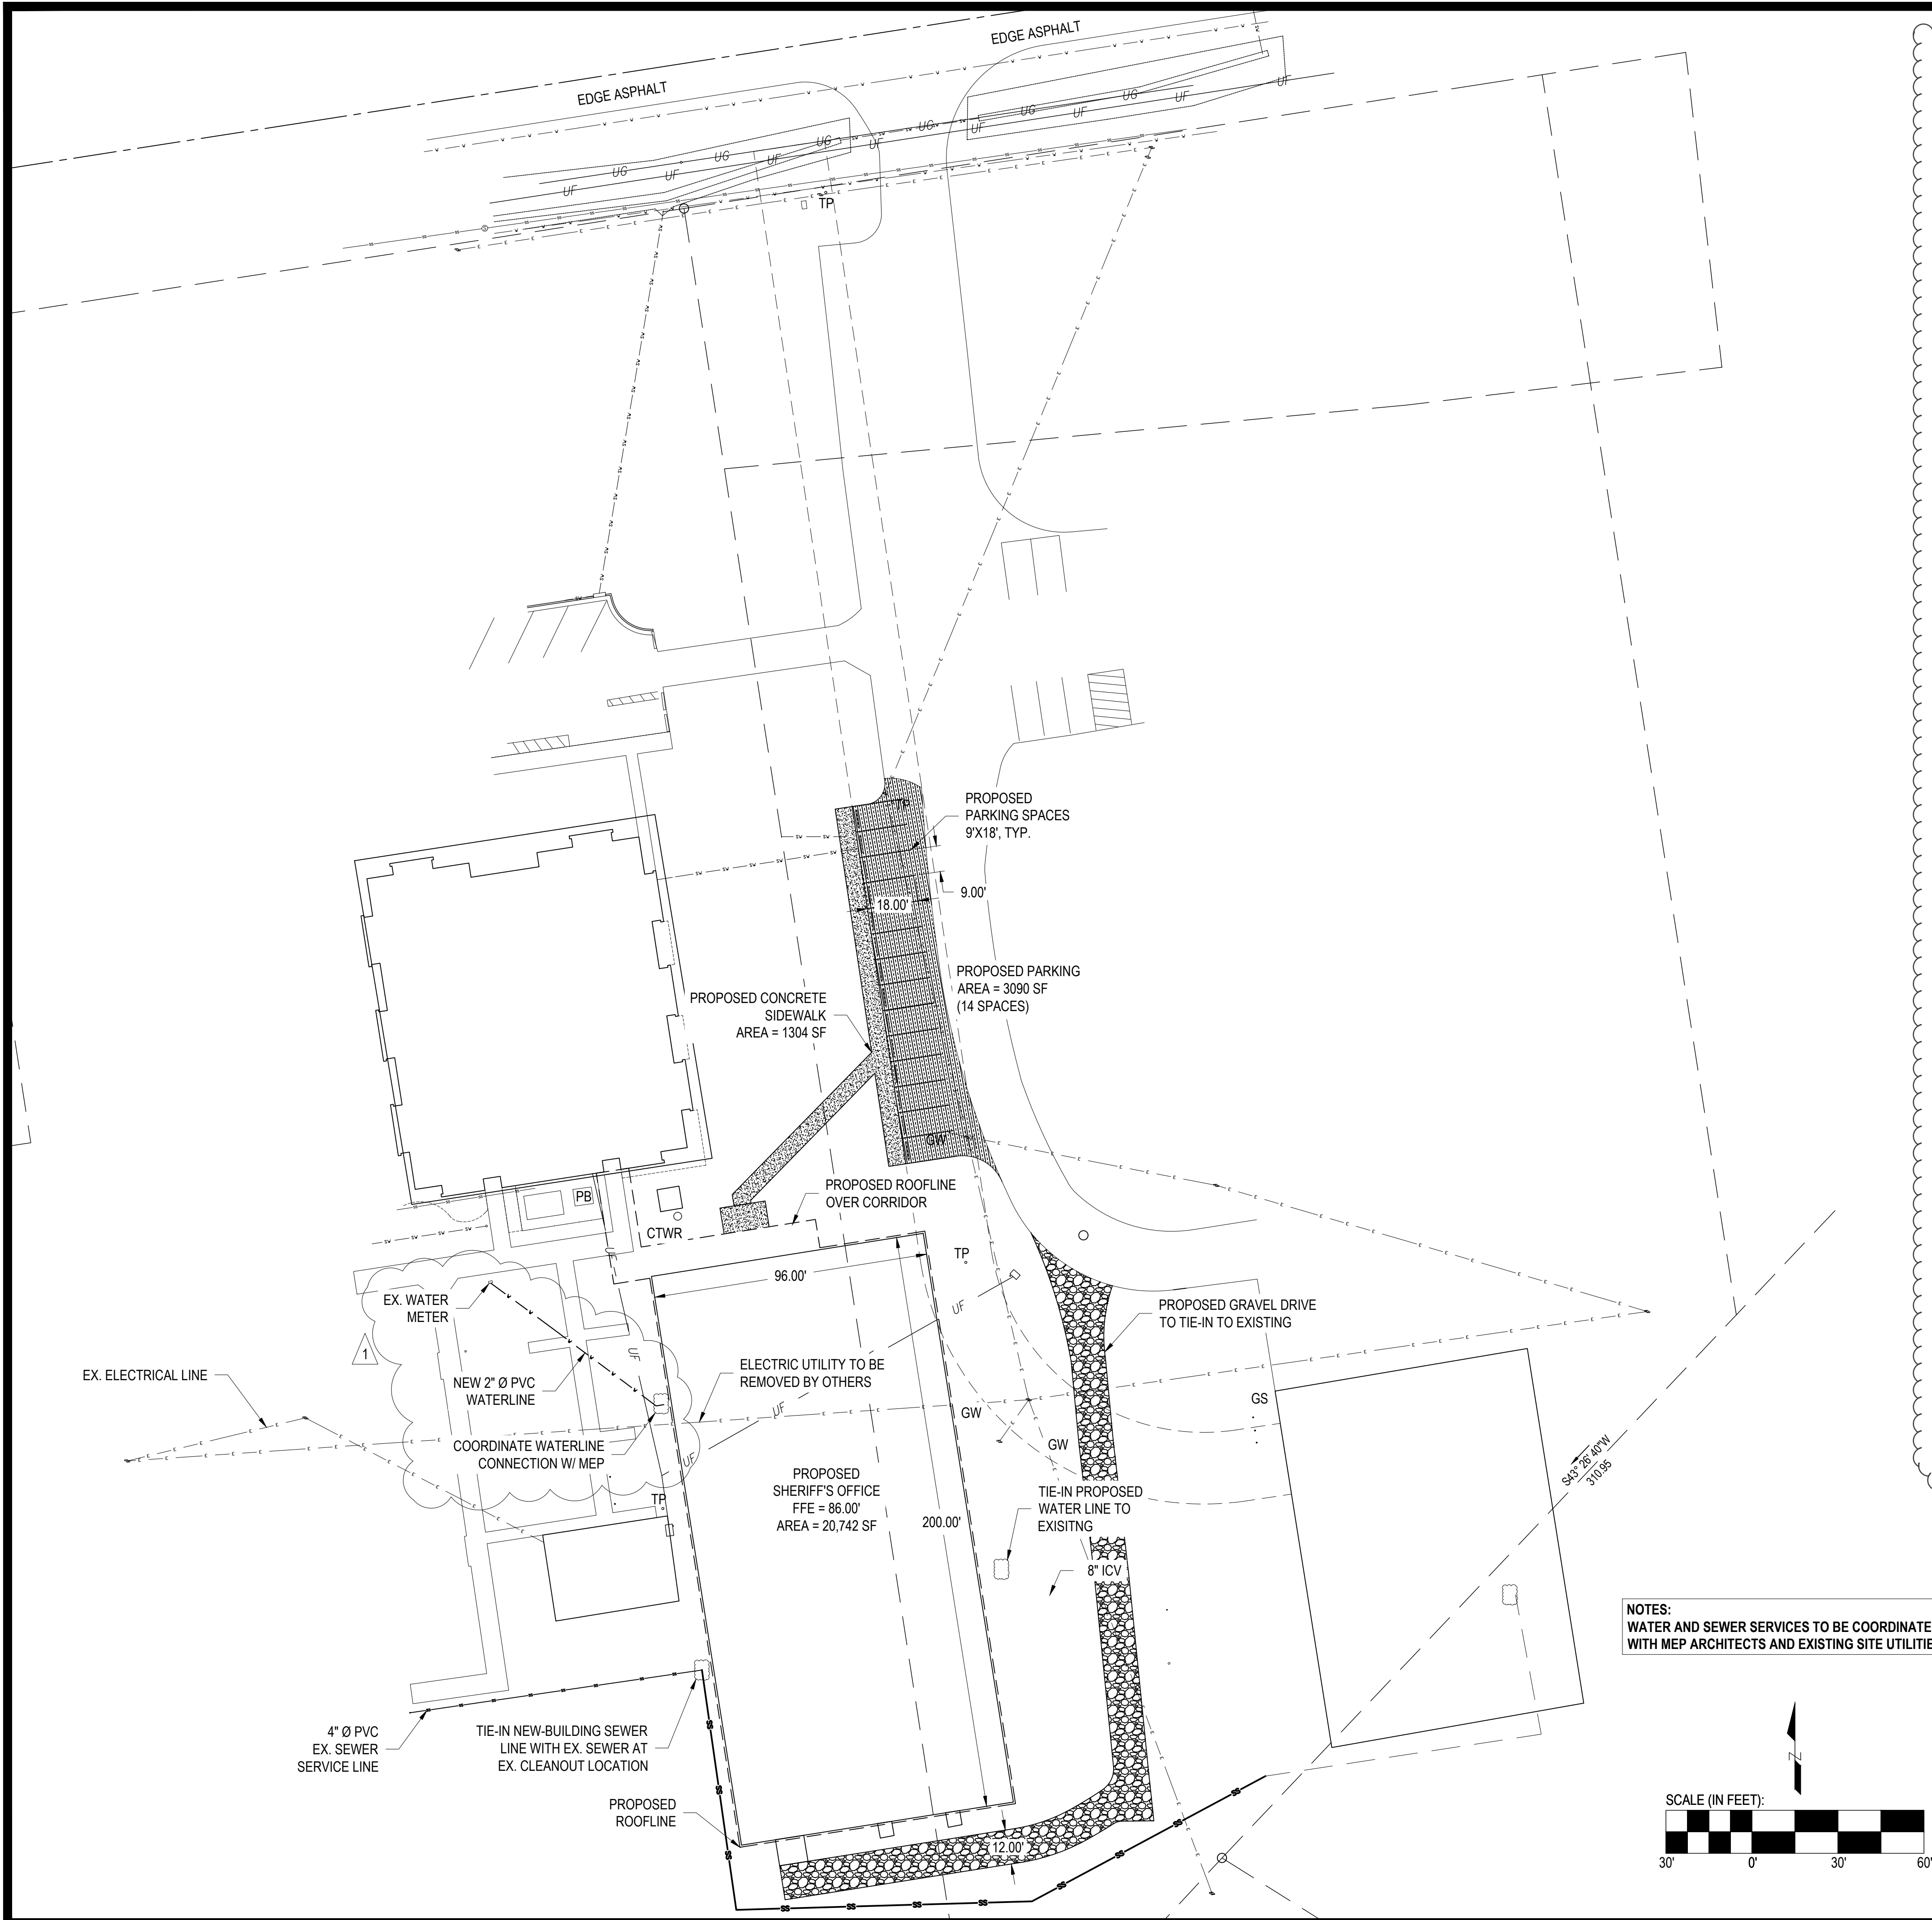

1 PIPE TRENCH OUTSIDE PAVED AREA
SCALE: NOT TO SCALE

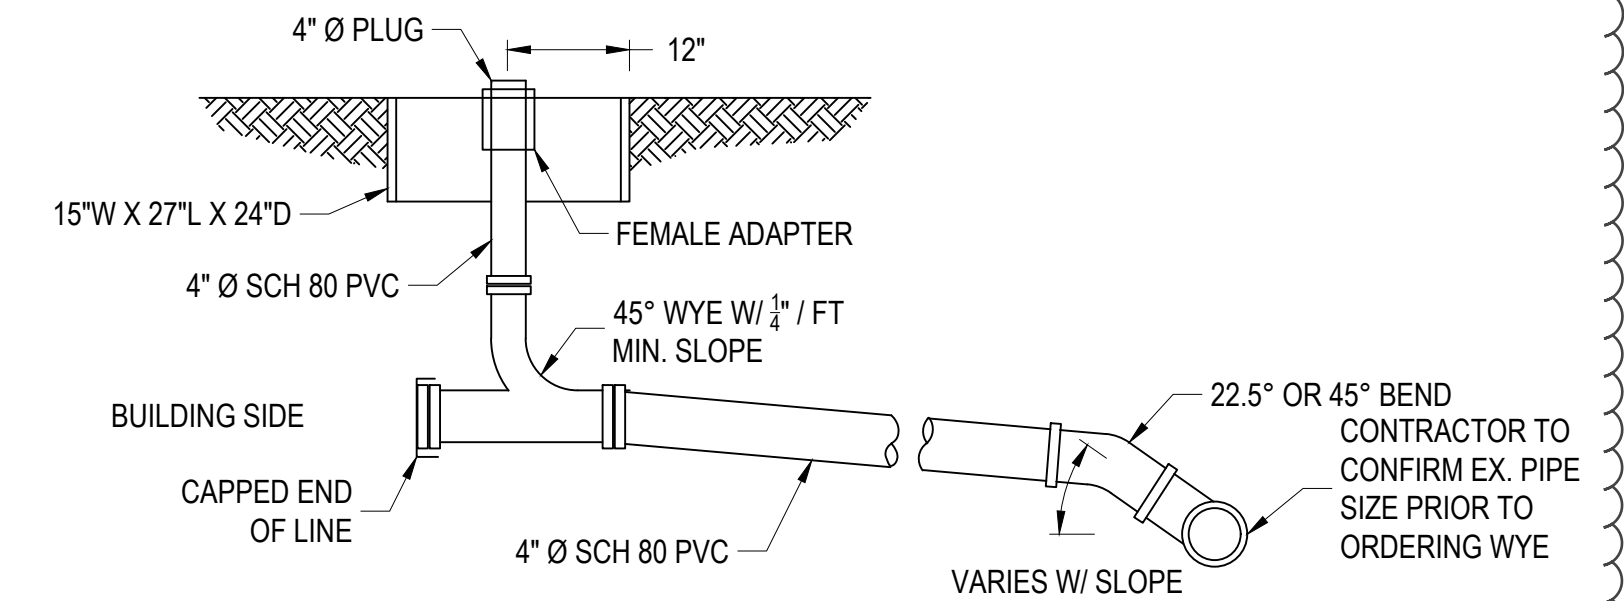


1 SANITARY SEWER CLEANOUT
SCALE: NOT TO SCALE

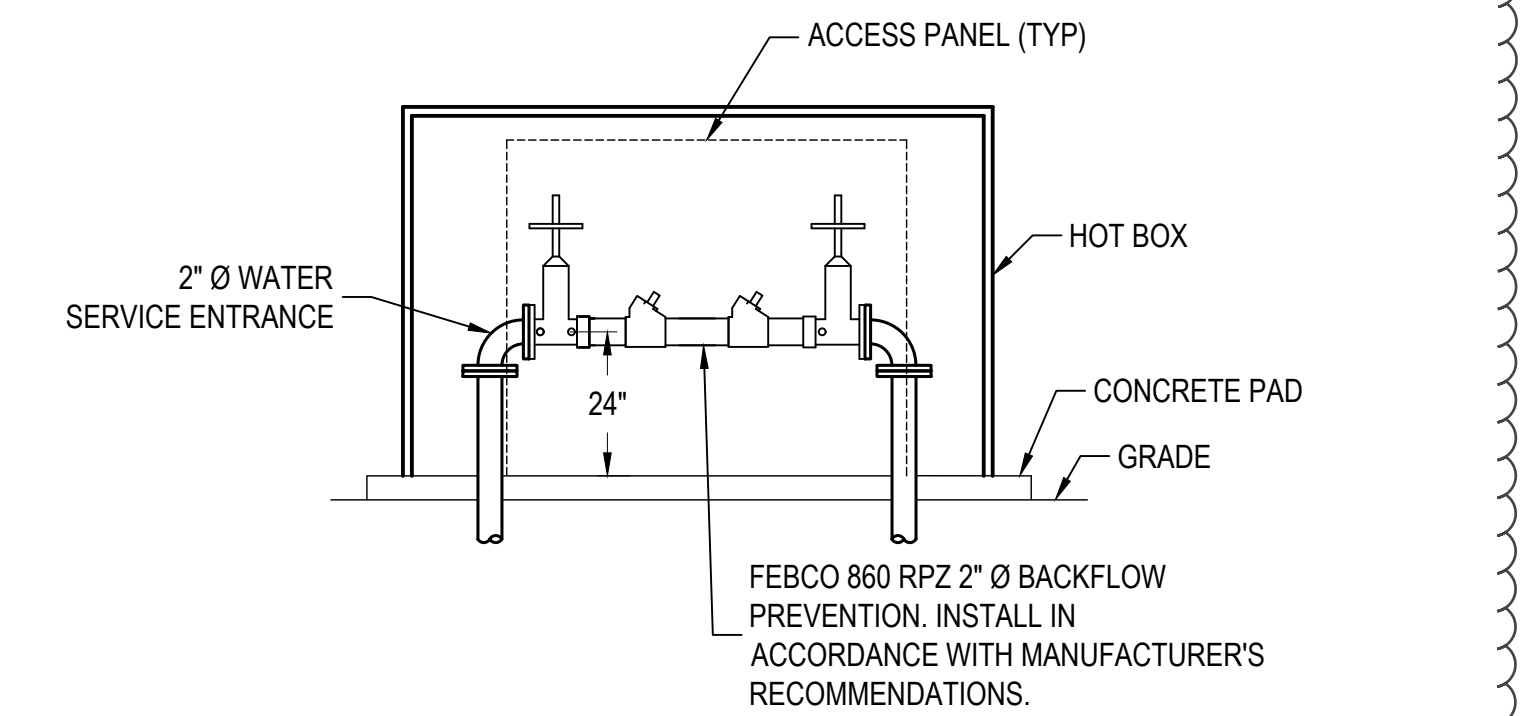

1 WATER SERVICE RPZ DETAIL
SCALE: NOT TO SCALE

NOTES:
WATER AND SEWER SERVICES TO BE COORDINATED
WITH MEP ARCHITECTS AND EXISTING SITE UTILITIES.

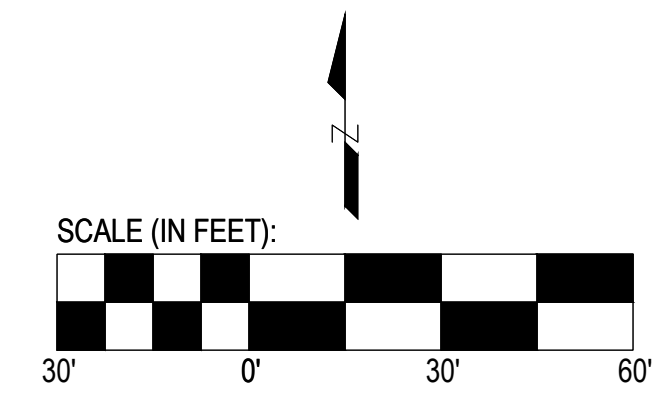

THIS DRAWING IS THE PROPERTY OF ARENDELL ENGINEERS AND IS NOT TO BE REPRODUCED OR USED FOR ANY PROJECT IN WHOLE OR IN PART WITHOUT EXPRESS WRITTEN PERMISSION.

PROJECT MANAGER: JJW

DESIGNED: JJW

DRAWN BY: JST

CHECKED: JJW

SCALE: 1" = 30'

DATE: 01/27/2025

ARENDELL ENGINEERS
CIVIL • COASTAL • ENVIRONMENTAL

1004 Arendell Street
Morehead City, NC 28557
(252) 622-4338
Fax: (252) 622-4505

www.arendellengineers.com

North Carolina Certification No. C-1509

OWNER: COLUMBUS COUNTY

PROJECT: SHERIFF'S OFFICE
817 WASHINGTON STREET
WHITEVILLE, NORTH CAROLINA 28472

COLUMBUS COUNTY, NC

DRAWING: UTILITY PLAN

NO.	REVISION	BY	DATE
1	WATERLINE REVISIONS	JJW	01/29/25

SHEET NO: OF: 8 JOB NO. 24265

C3 VOID